



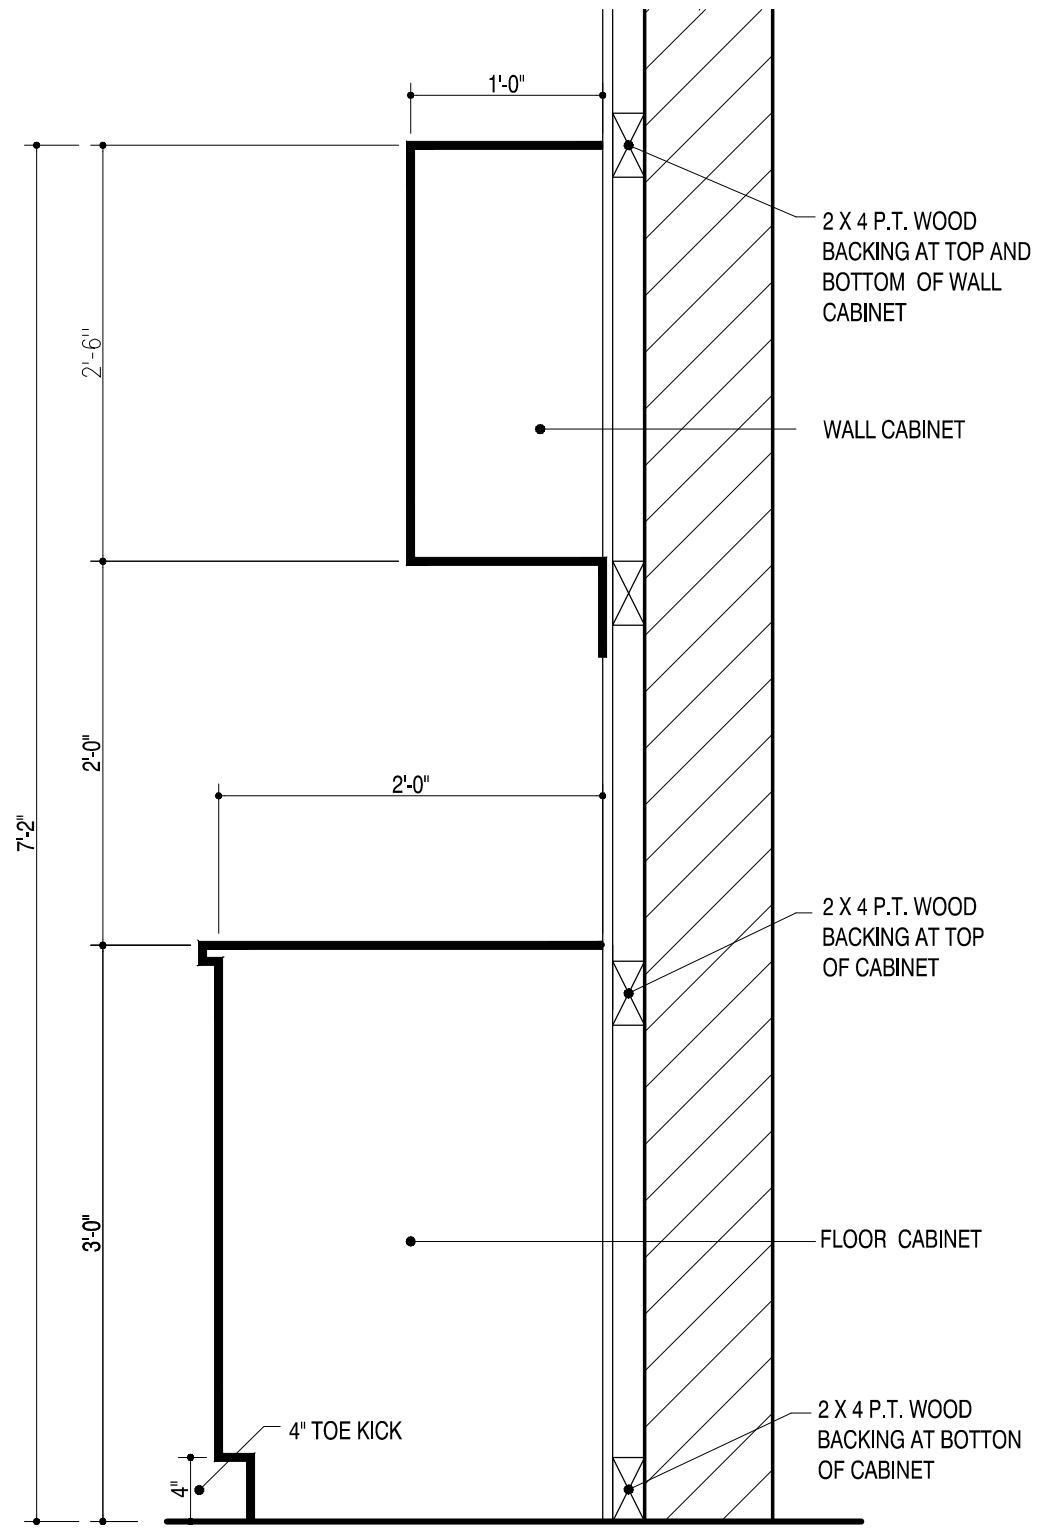

- NOTE: 1• PROVIDE BACKING FOR WALL CABINETS F.B.C. 2510.5.1.3.
- 2• PROVIDE 2\"/>

CABINET TO MASONRY WALL DETAIL

N.T.S.

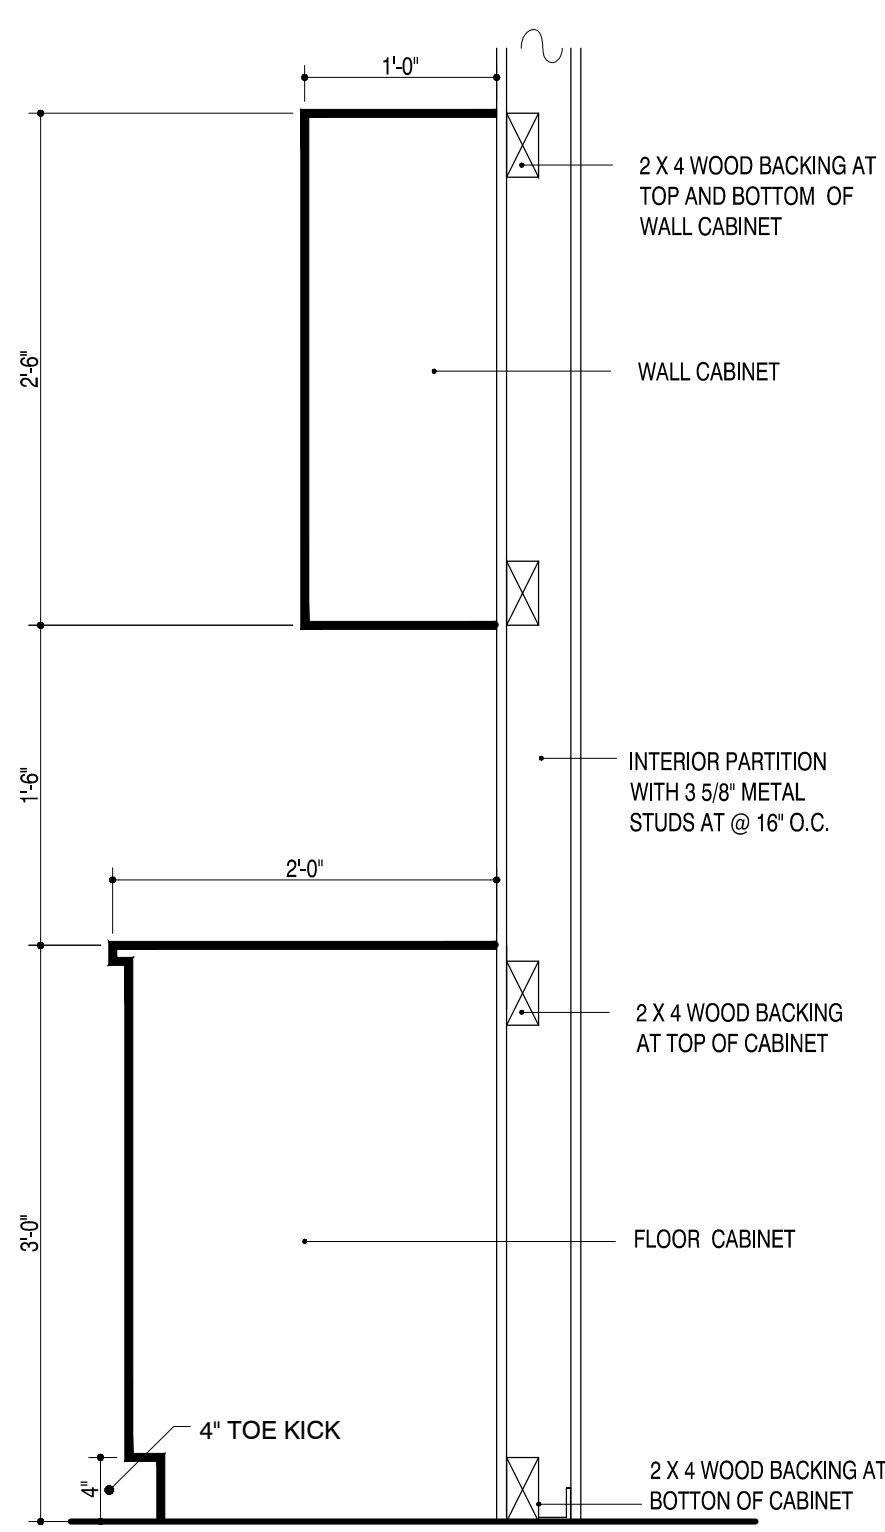

- NOTE: 1• PROVIDE BACKING FOR WALL CABINETS F.B.C. 2510.5.1.3
- A MINIMUM 2 x 4 HORIZONTAL WOOD MEMBER, SECURELY FASTENED TO NOT LESS THAN 2 STUDS, SHALL BE INSTALLED FOR THE ATTACHMENT OF EACH WALL HUNG PLUMBING FIXTURE AND WALL CABINET, AS PER F.B.C. R4411.4.5.1.3.
- 2• PROVIDE 20 GA. MTL. STUDS @ KITCHEN CABINETS WALL AS PER F.B.C. R4411.4.5.1.1


CABINET TO PARTITION WALL DETAIL

N.T.S.




PLANTER DETAIL

SCALE: 3/4\"/>

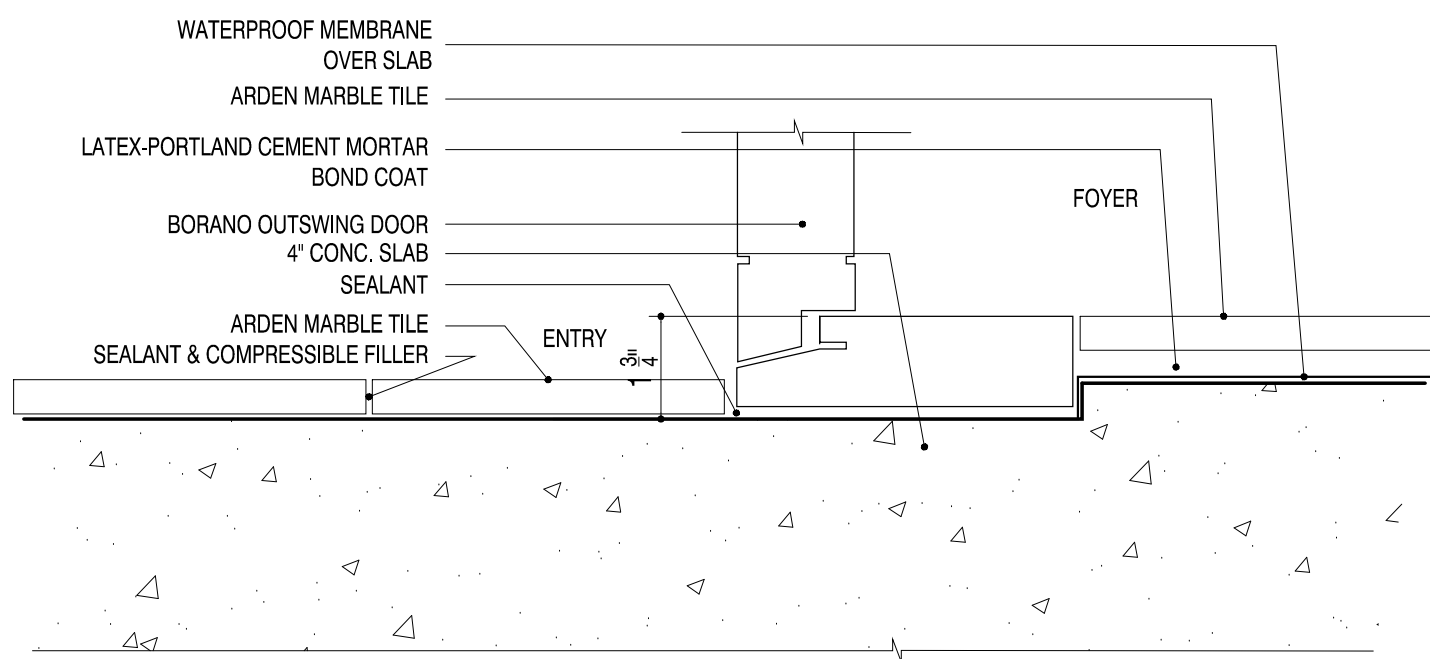


SILL DOOR DETAIL

N.T.S.

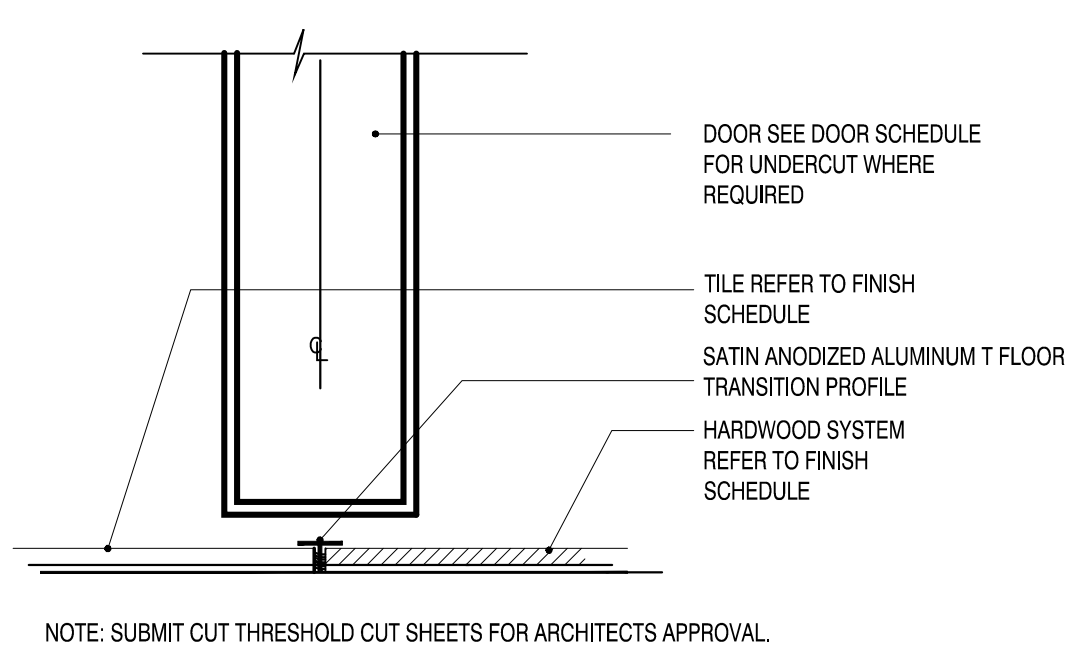


TILE TO HARDWOOD

SCALE: 1\"/>

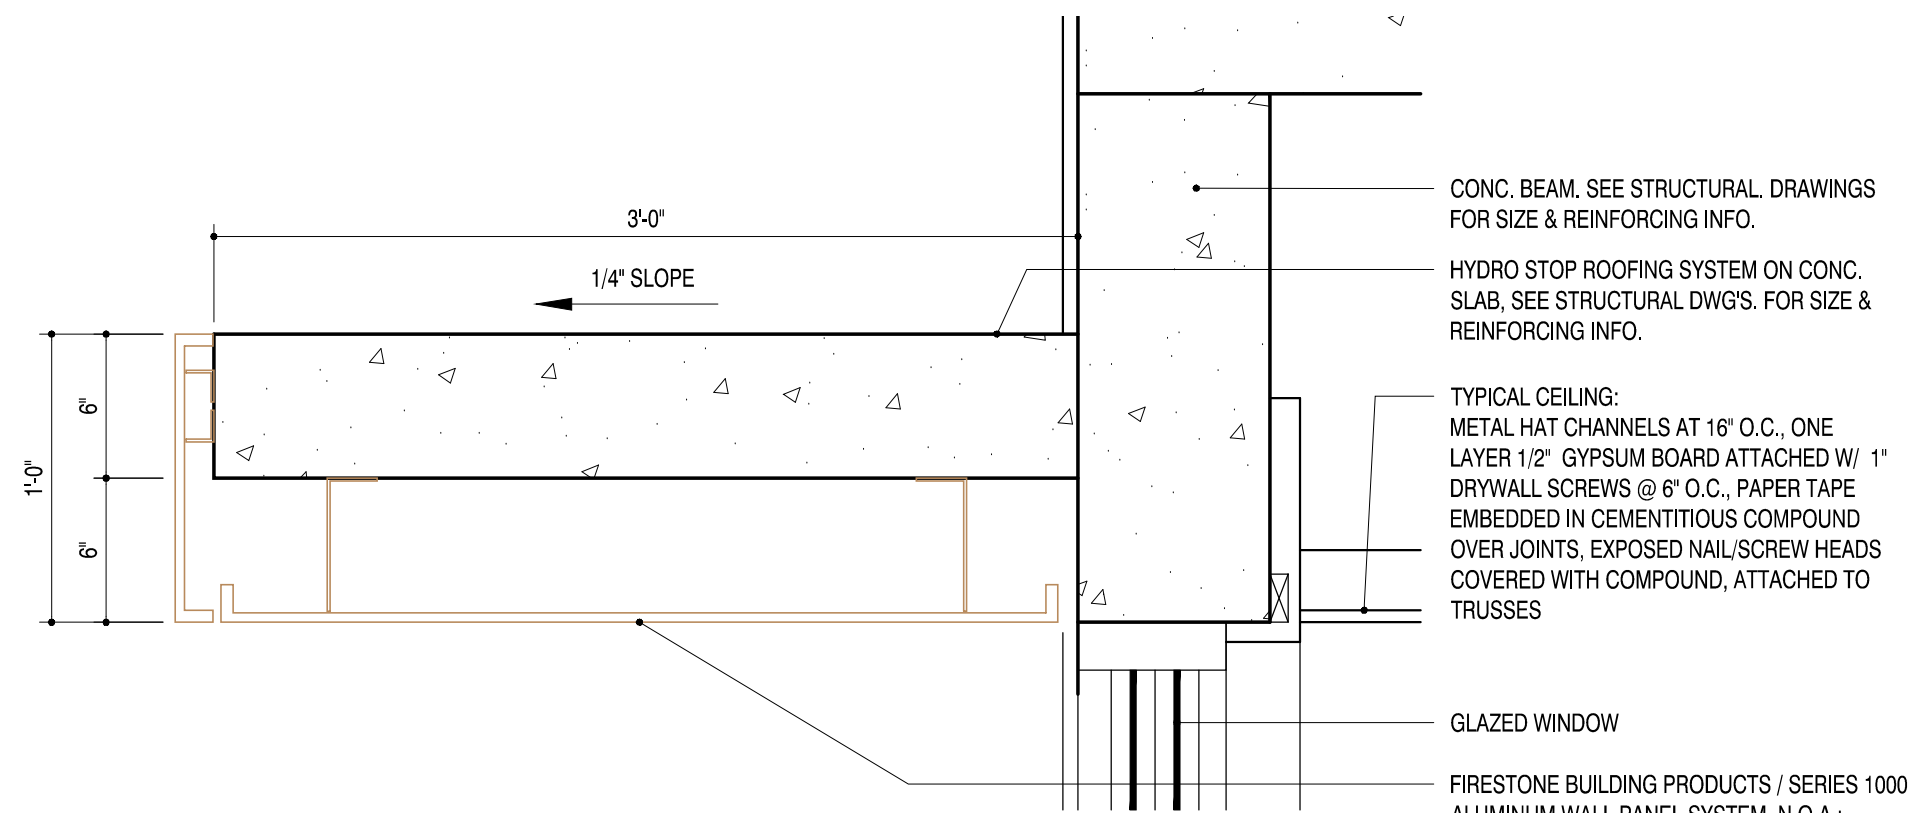

CEILING DETAIL

SCALE: 1 1/2\"/>

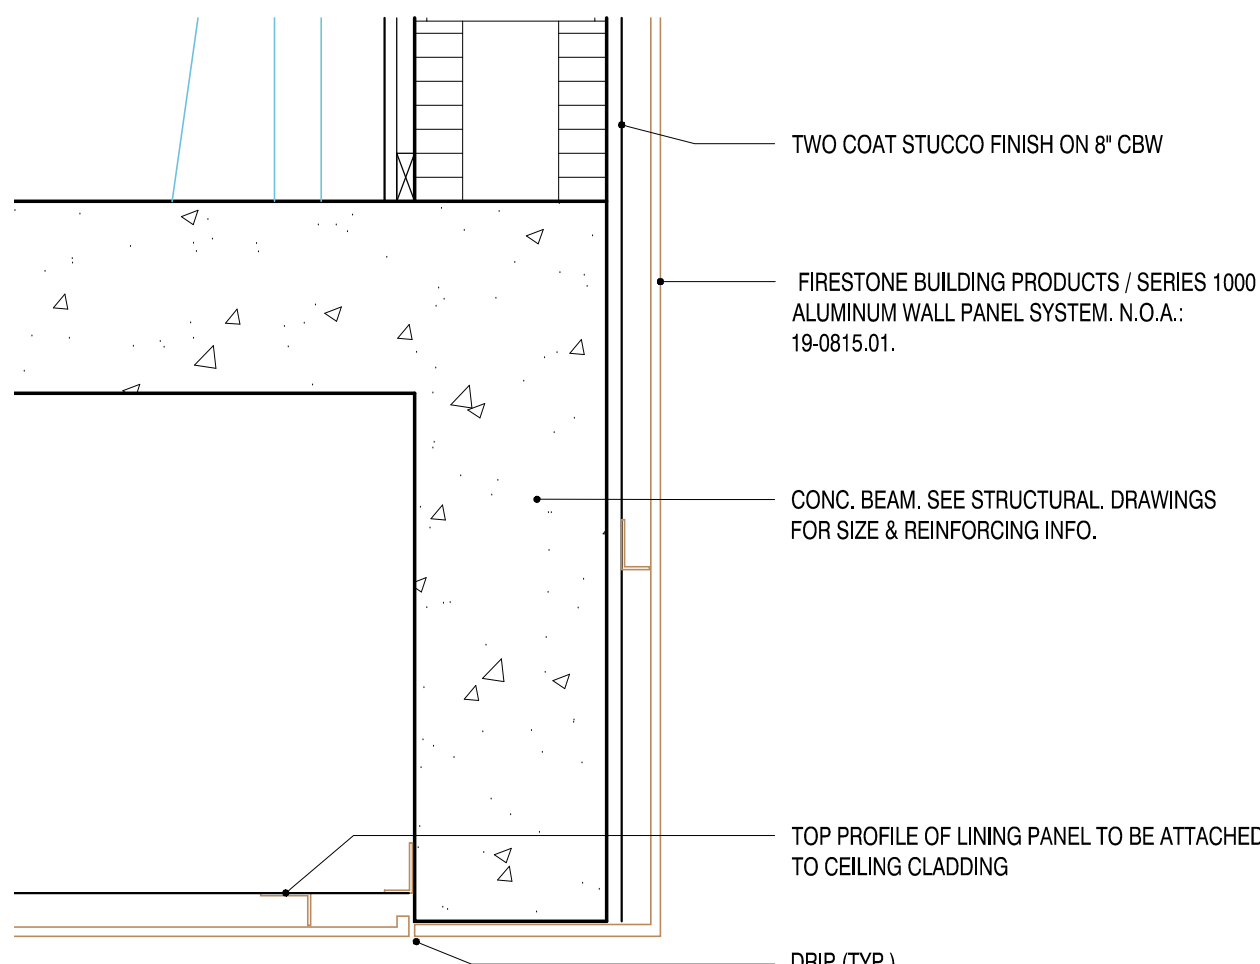

CEILING DETAIL

SCALE: 1 1/2\"/>

3 6\"/>

3b 6\"/>

3c 6\"/>


2 4\"/>

2b 4\"/>

2c 4\"/>


WALL TYPE

N.T.S.

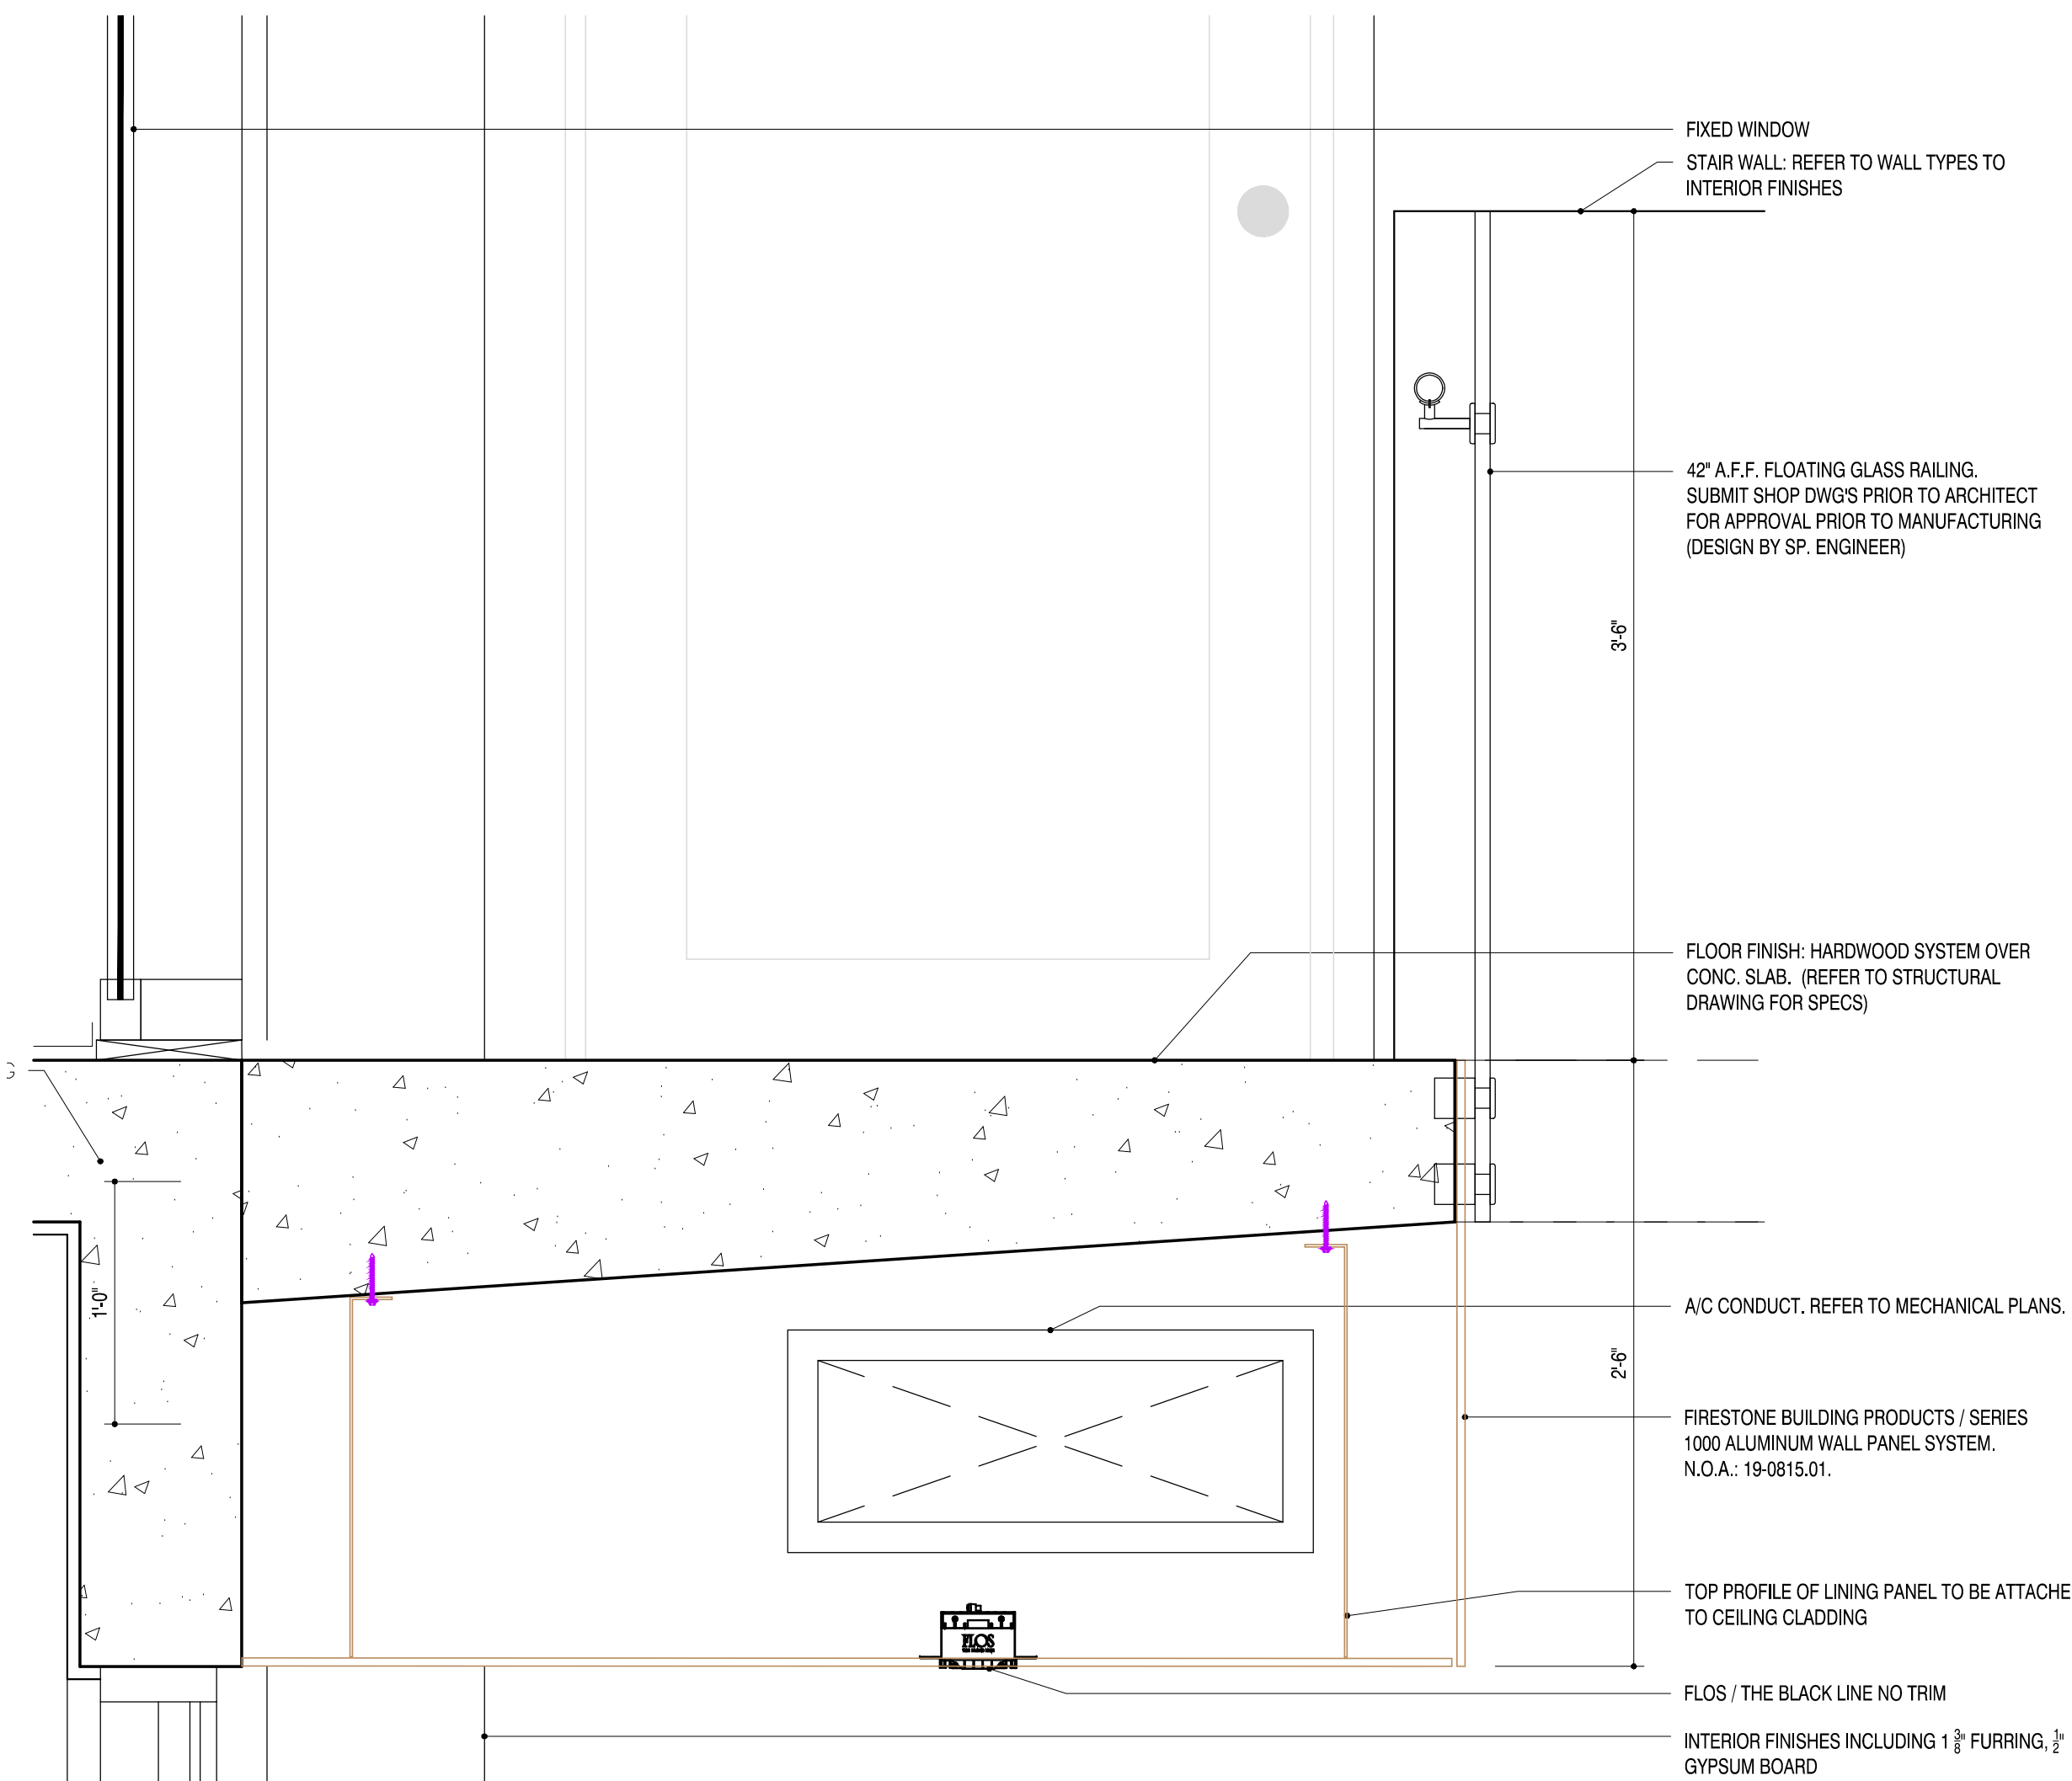

CEILING DETAIL

SCALE: 1 1/2\"/>

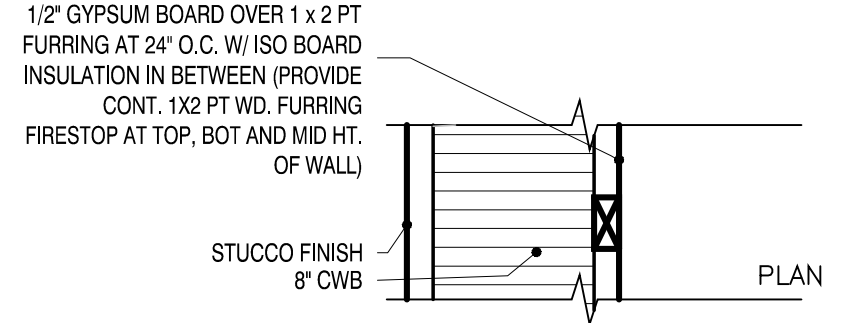

1 8\"/>

1b 8\"/>

1c 8\"/>

1d 8\"/>

1e 8\"/>

1f 8\"/>

1g 8\"/>

RAMOSMARTINEZarchitects

MIAMI 635 W. FLAGLER ST. SUITE 205 MIAMI, FL 33130

REGISTRATION: A.A. 26000528 WEBSITE: www.rmq.com TELEPHONE: 305-548-3006

NEW YORK 11 ERLE STREET 2ND FLOOR JERSEY CITY, NJ 07302

NEW RESIDENCE FOR ELIGES INVESTORS CONSTRUCTION AT 9841 SW 73rd COURT PINECREST, FLORIDA 33156

STRUCTURAL ENGINEER: EASTERN ENGINEERING 3401 NW 82nd AVE. SUITE 370 MIAMI, FLORIDA 33122 TEL.: 786-547-3517

SEAL: ORLANDO RANGEL, P.E. - 60225 9940 SW 37th STREET, MIAMI, FLORIDA 33165 TEL.: 786-547-3517

MECHANICAL ENGINEER: ORLANDO RANGEL, P.E. - 60225 9940 SW 37th STREET, MIAMI, FLORIDA 33165 TEL.: 786-547-3517

CIVIL ENGINEER: ANDRE D. MARTINEZ, P.E. - 85425 AM CIVIL - ENGINEERS & PLANNERS 860 SW 21st STREET MIAMI, FLORIDA 33135 TEL.: 786-289-9414 a.martinez85@gmail.com

LANDSCAPE ARCHITECT: 07/06/2022

ARCHITECT: HUMBERTO RAMOS APR 07/18/23

COPYRIGHT - 2021 - RAMOSMARTINEZarchitects, inc. THE DESIGNS, IDEAS AND DETAIL INDICATED OR REPRESENTED BY THIS DRAWING, CREATED AND DEVELOPED FOR USE ON THIS PROJECT, ARE OWNED BY AND THE LEGAL PROPERTY OF RAMOSMARTINEZ architects, inc. USE, REPRODUCTION, DISTRIBUTION OR ALTERATION IS PROHIBITED WITHOUT WRITTEN AUTHORIZATION BY THE ARCHITECT.

KEY PLAN:



COMM. NO.: 17-117 NO: REVISION: DATE:

DATE: JANUARY, 2022

DRAWN BY:

CONTENT: DETAILS

SHEET NUMBER:

A-7