


WATER PIPING SIZE	
①	1/2" CW
②	1/2" CW & 1/2" HW
③	1/2" HW
④	3/4" CW
⑤	3/4" CW & 1/2" HW
⑥	3/4" CW & 3/4" HW
⑦	3/4" HW
⑧	1" CW & 1/2" HW
⑨	1" CW & 3/4" HW
⑩	1" CW
⑪	1-1/4" CW

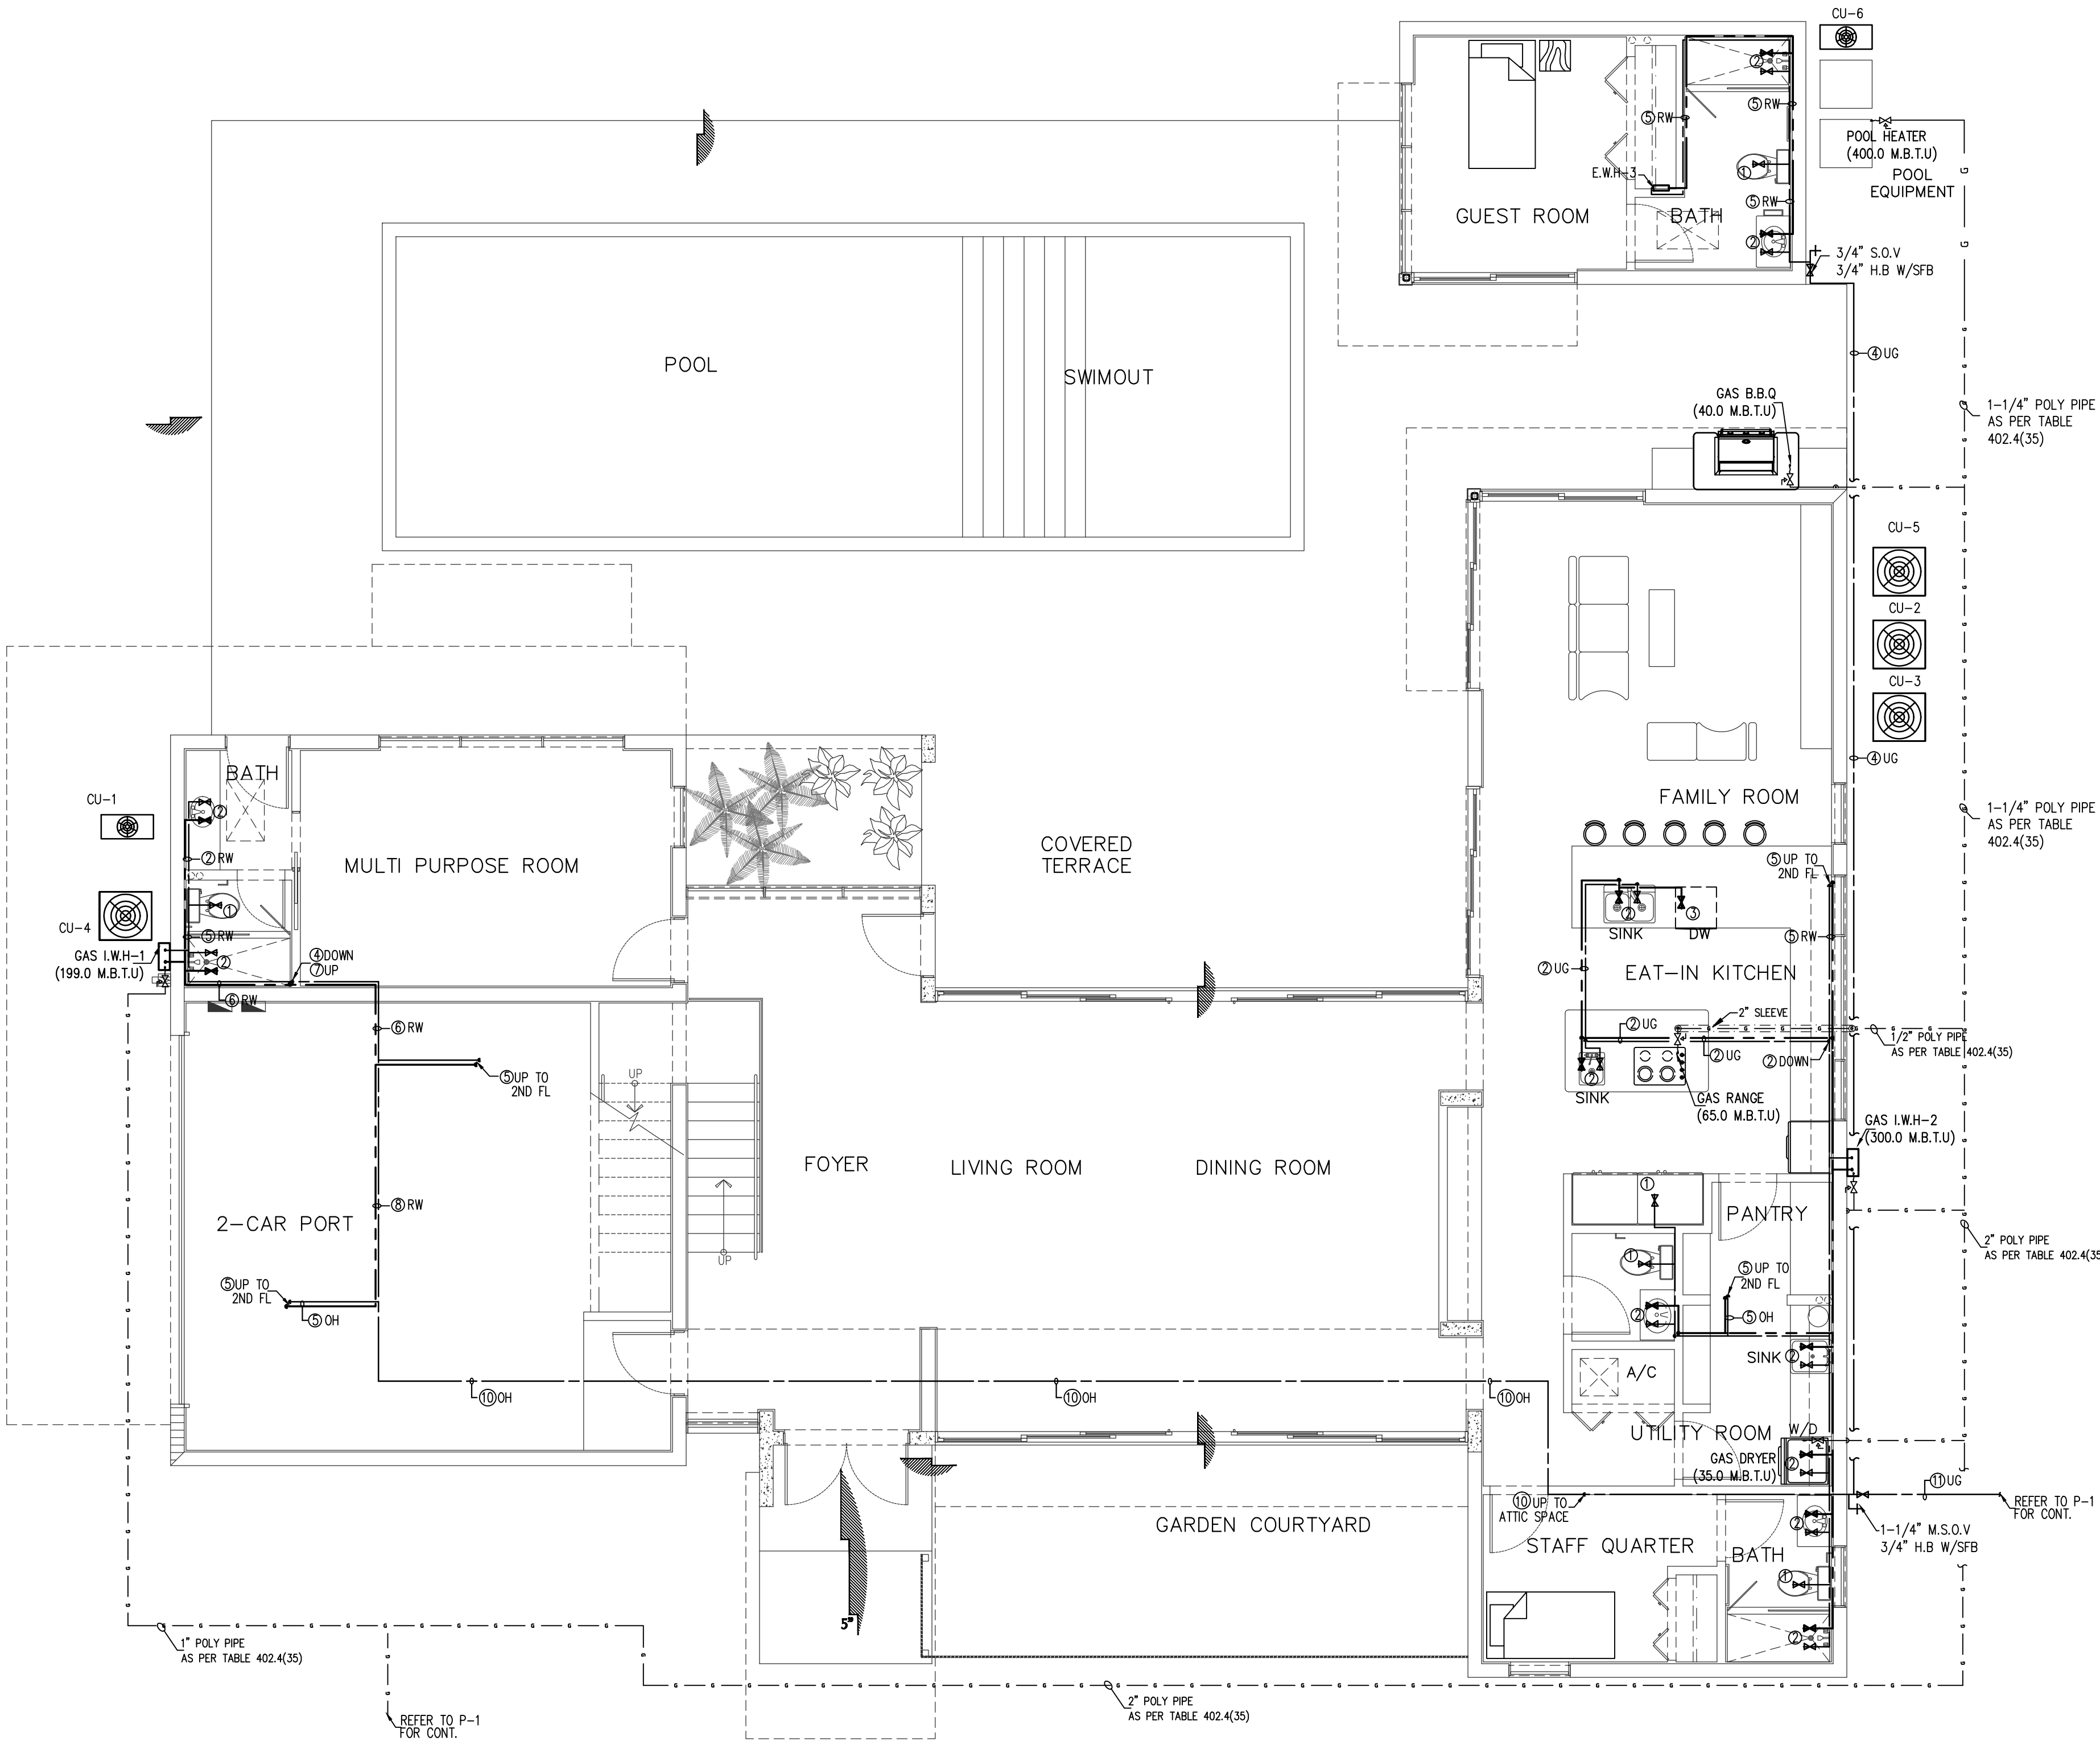

RAMOSMARTINEZarchitects

MIAMI	REGISTRATION: A.A.28000528	NEW YORK
655 W. FLAGLER ST.	WEBSITE: www.rmarq.com	11 ERIE STREET
SUITE 205		2nd FLOOR
MIAMI, FL 33130	TELEPHONE: 305-548-3006	JERSEY CITY, NJ 07302

NEW RESIDENCE
FOR
ELIGES INVESTORS CONSTRUCTION
AT
9841 SW 73rd COURT
PINECREST, FLORIDA 33156

STRUCTURAL ENGINEER: EASTERN ENGINEERING
3401 NW 80th AVE. SUITE 370
MIAMI, FLORIDA 33122 305-599-8133

MECHANICAL ENGINEER:

 
CIVIL ENGINEER:

LANDSCAPE ARCHITECT:

ARCHITECT:
HUMBERTO RAMOS
AIA 0077833

COPYRIGHT - 2021 - RAMOSMARTINEZarchitects, inc.
THE DESIGNS, IDEAS AND DETAIL INDICATED OR REPRESENTED BY THIS DRAWING, CREATED AND DEVELOPED FOR USE ON THIS PROJECT, ARE OWNED BY AND THE LEGAL PROPERTY OF RAMOSMARTINEZ architects, inc. USE, REPRODUCTION, DISTRIBUTION OR ALTERATION IS PROHIBITED WITHOUT WRITTEN AUTHORIZATION BY THE ARCHITECT.

KEY PLAN:



COMM. NO.: 17-117 NO: REVISION: DATE:

DATE: JANUARY, 2022

DRAWN BY:

CONTENT:

SHEET NUMBER:

WATER FISRT FLOOR PLAN
SCALE: 3/16" = 1'-0"

ORLANDO RANGEL

P.E. 60225

9940 S.W. 31th STREET MIAMI, FLORIDA 33165

TEF: 786-541 3511