 


TYPE: LOADCENTER		PANEL "C"							MAIN BUS: 200 A					
SERVICE: DWELLING UNIT		(COMBO SECTION)							NEUTRAL: 200 A					
VOLTAGE: 120/240 V, 1 ph, 3W									MAIN: 200 A MLO					
MOUNTING: SURFACE									AICS: 10,000					
AMPS	POLES	TOTAL V.A.	COND. SIZE	WIRE SIZE	REMARKS	CKT NO.		CKT NO.	REMARKS	WIRE SIZE	COND. SIZE	TOTAL V.A.	POLES	AMPS
15	2	2200	1/2	12	CU-1	1		2	GENERATOR OUTLET BACK-FEED CIRCUIT BREAKER	3	1-1/2	AS SHOWN	2	100
25	2	2700	1/2	10	CU-4	5		6	FUTURE SOLAR PNL. ARRAY BACK-FEED CIRCUIT BREAKER	10	2	AS SHOWN	2	30
CONNECTED LOAD : AS SHOWN						FEED-THRU LUGS TO PNL"A(I)"								
LOAD CALCULATION : SEE LOAD CALCULATION TABLE														

TYPE:

SERVICE:

VOLTAGE:

MOUNTING:

LOAD CENTER

HOUSE

120/240 V, 1PH, 3W

SURFACE

PANEL "P"

(N3R)

MAIN BUS:

NEUTRAL:

MAIN:

AICS:

100 A

100 A

100 A MBR

10,000

AMPS	POLES	TOTAL V.A.	COND. SIZE	WIRE SIZE	REMARKS	CKT NO.		CKT NO.	REMARKS	WIRE SIZE	COND. SIZE	TOTAL V.A.	POLES	AMPS
15	2	2200	1/2	12	CU-6 (AC UNIT FEED FROM CU)	1	2	2	SPACE	-	-	-	-	-
-	-	-	-	-	SPACE	3	4	6	SPRK. PUMP	12	1/2	2200	2	20
-	-	-	-	-	SPACE	5	6	8	POOL PUMP	12	1/2	2200	2	20
20	2	2200	1/2	10	POOL BLOWER	7	8	10	POOL LTNG. THRU LV XTR.	12	1/2	600	1	20
60	2	11200	3/4	6	IWH-3	9	10	12	GFI BATH	12	1/2	* △	1	20
-	-	-	-	-	SPACE	13	14	16	GEN. LTNG. & REC's GUEST	14	1/2	* △	1	15
-	-	-	-	-	SPACE	15	16	18	GEN. LTNG. & REC's GUEST	14	1/2	* △	1	15
-	-	-	-	-	SPACE	17	18	20	SPACE	-	-	-	-	-
-	-	-	-	-	SPACE	19	20	22	SPACE	-	-	-	-	-
-	-	-	-	-	SPACE	21	22	24	SPACE	-	-	-	-	-

CONNECTED LOAD: AS SHOWN

LOAD CALCULATION : SEE LOAD CALCULATION TABLE


NC : NONCOICIDENT LOADS RESPECT TO AHU's

* : LIGHTING & REC. @ 3VA/sf

△ : AFCI

FEEDER : SEE RISER

FEED FROM : SEE RISER

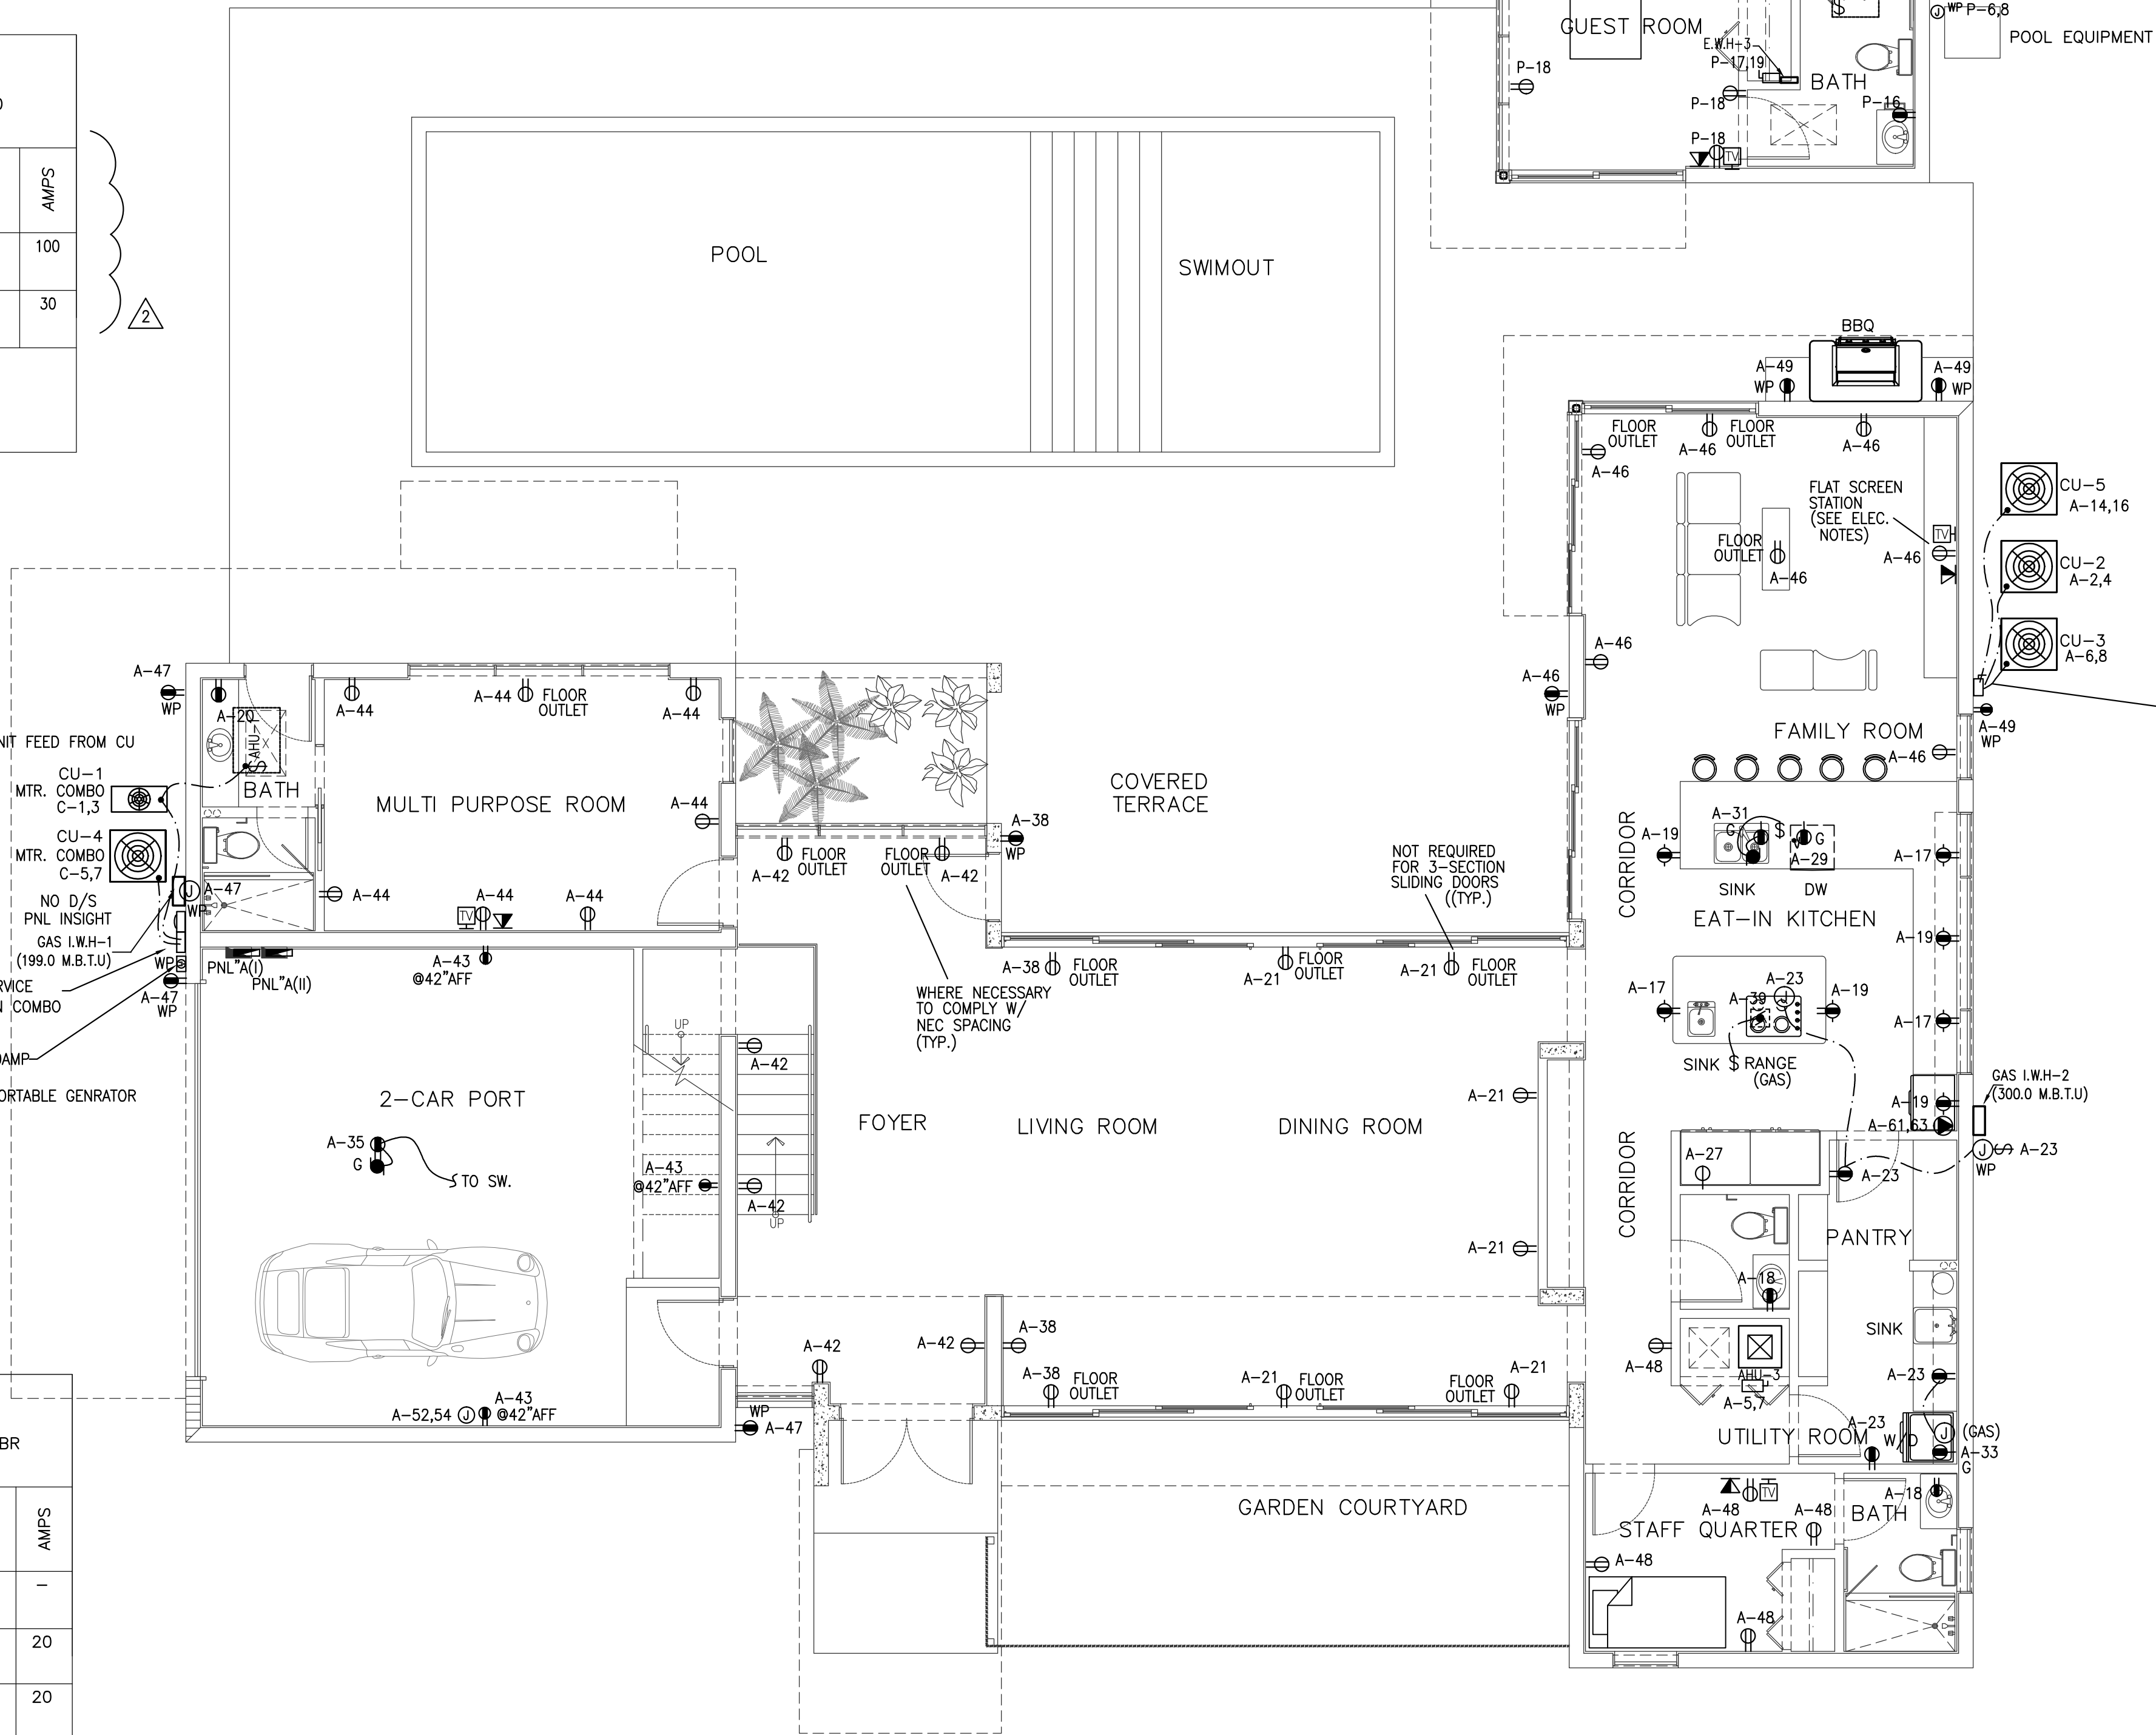

RAMOSMARTINEZarchitects

MIAMI 655 W FLAGLER ST. SUITE 205 MIAMI, FL 33130
REGISTRATION: A-A 26000528
WEBSITE: www.mraq.com
TELEPHONE: 305-548-3006
NEW YORK 11 ERIE STREET 2nd FLOOR JERSEY CITY, NJ 07302

FOR
NEW RESIDENCE
ELIGES INVESTORS CONSTRUCTION
AT
9841 SW 73rd COURT
PINECREST, FLORIDA 33156

STRUCTURAL ENGINEER: SEAL:
EASTERN ENGINEERING
3401 NW 82nd AVE. SUITE 370
MIAMI, FLORIDA 33122 305-599-8133

MECHANICAL ENGINEER:

CIVIL ENGINEER:

LANDSCAPE ARCHITECT:

ARCHITECT:
HUMBERTO RAMOS
A/E 0017833

COPYRIGHT - 2021 - RAMOSMARTINEZarchitects, inc.
THE DESIGNS, IDEAS AND DETAIL INDICATED OR REPRESENTED BY THIS DRAWING, CREATED AND DEVELOPED FOR USE ON THIS PROJECT, ARE OWNED BY AND THE LEGAL PROPERTY OF RAMOSMARTINEZ architects, inc. USE, REPRODUCTION, DISTRIBUTION OR ALTERATION IS PROHIBITED WITHOUT WRITTEN AUTHORIZATION BY THE ARCHITECT.

KEY PLAN:



COMM. NO.: 17-117 NO: REVISION: DATE:

DATE: JANUARY, 2022 01/04/23 B.D.C.

DRAWN BY:

CONTENT:

SHEET NUMBER:

POWER FISRT FLOOR PLAN
SCALE: 3/16" = 1'-0"

Elias P. Crespo
7724 W 29 Ln #102
HIALEAH, Florida, 33018
Phone (786) 413-6415 Fax (305) 824-9597
ELECTRICAL ENGINEER
P.E. LICENCE : 59295

E-4