


WATER PIPING SIZE	
①	1/2" CW
②	1/2" CW & 1/2" HW
③	1/2" HW
④	3/4" CW
⑤	3/4" CW & 1/2" HW
⑥	3/4" CW & 3/4" HW
⑦	3/4" HW
⑧	1" CW & 1/2" HW
⑨	1" CW & 3/4" HW
⑩	1" CW
⑪	1-1/4" CW

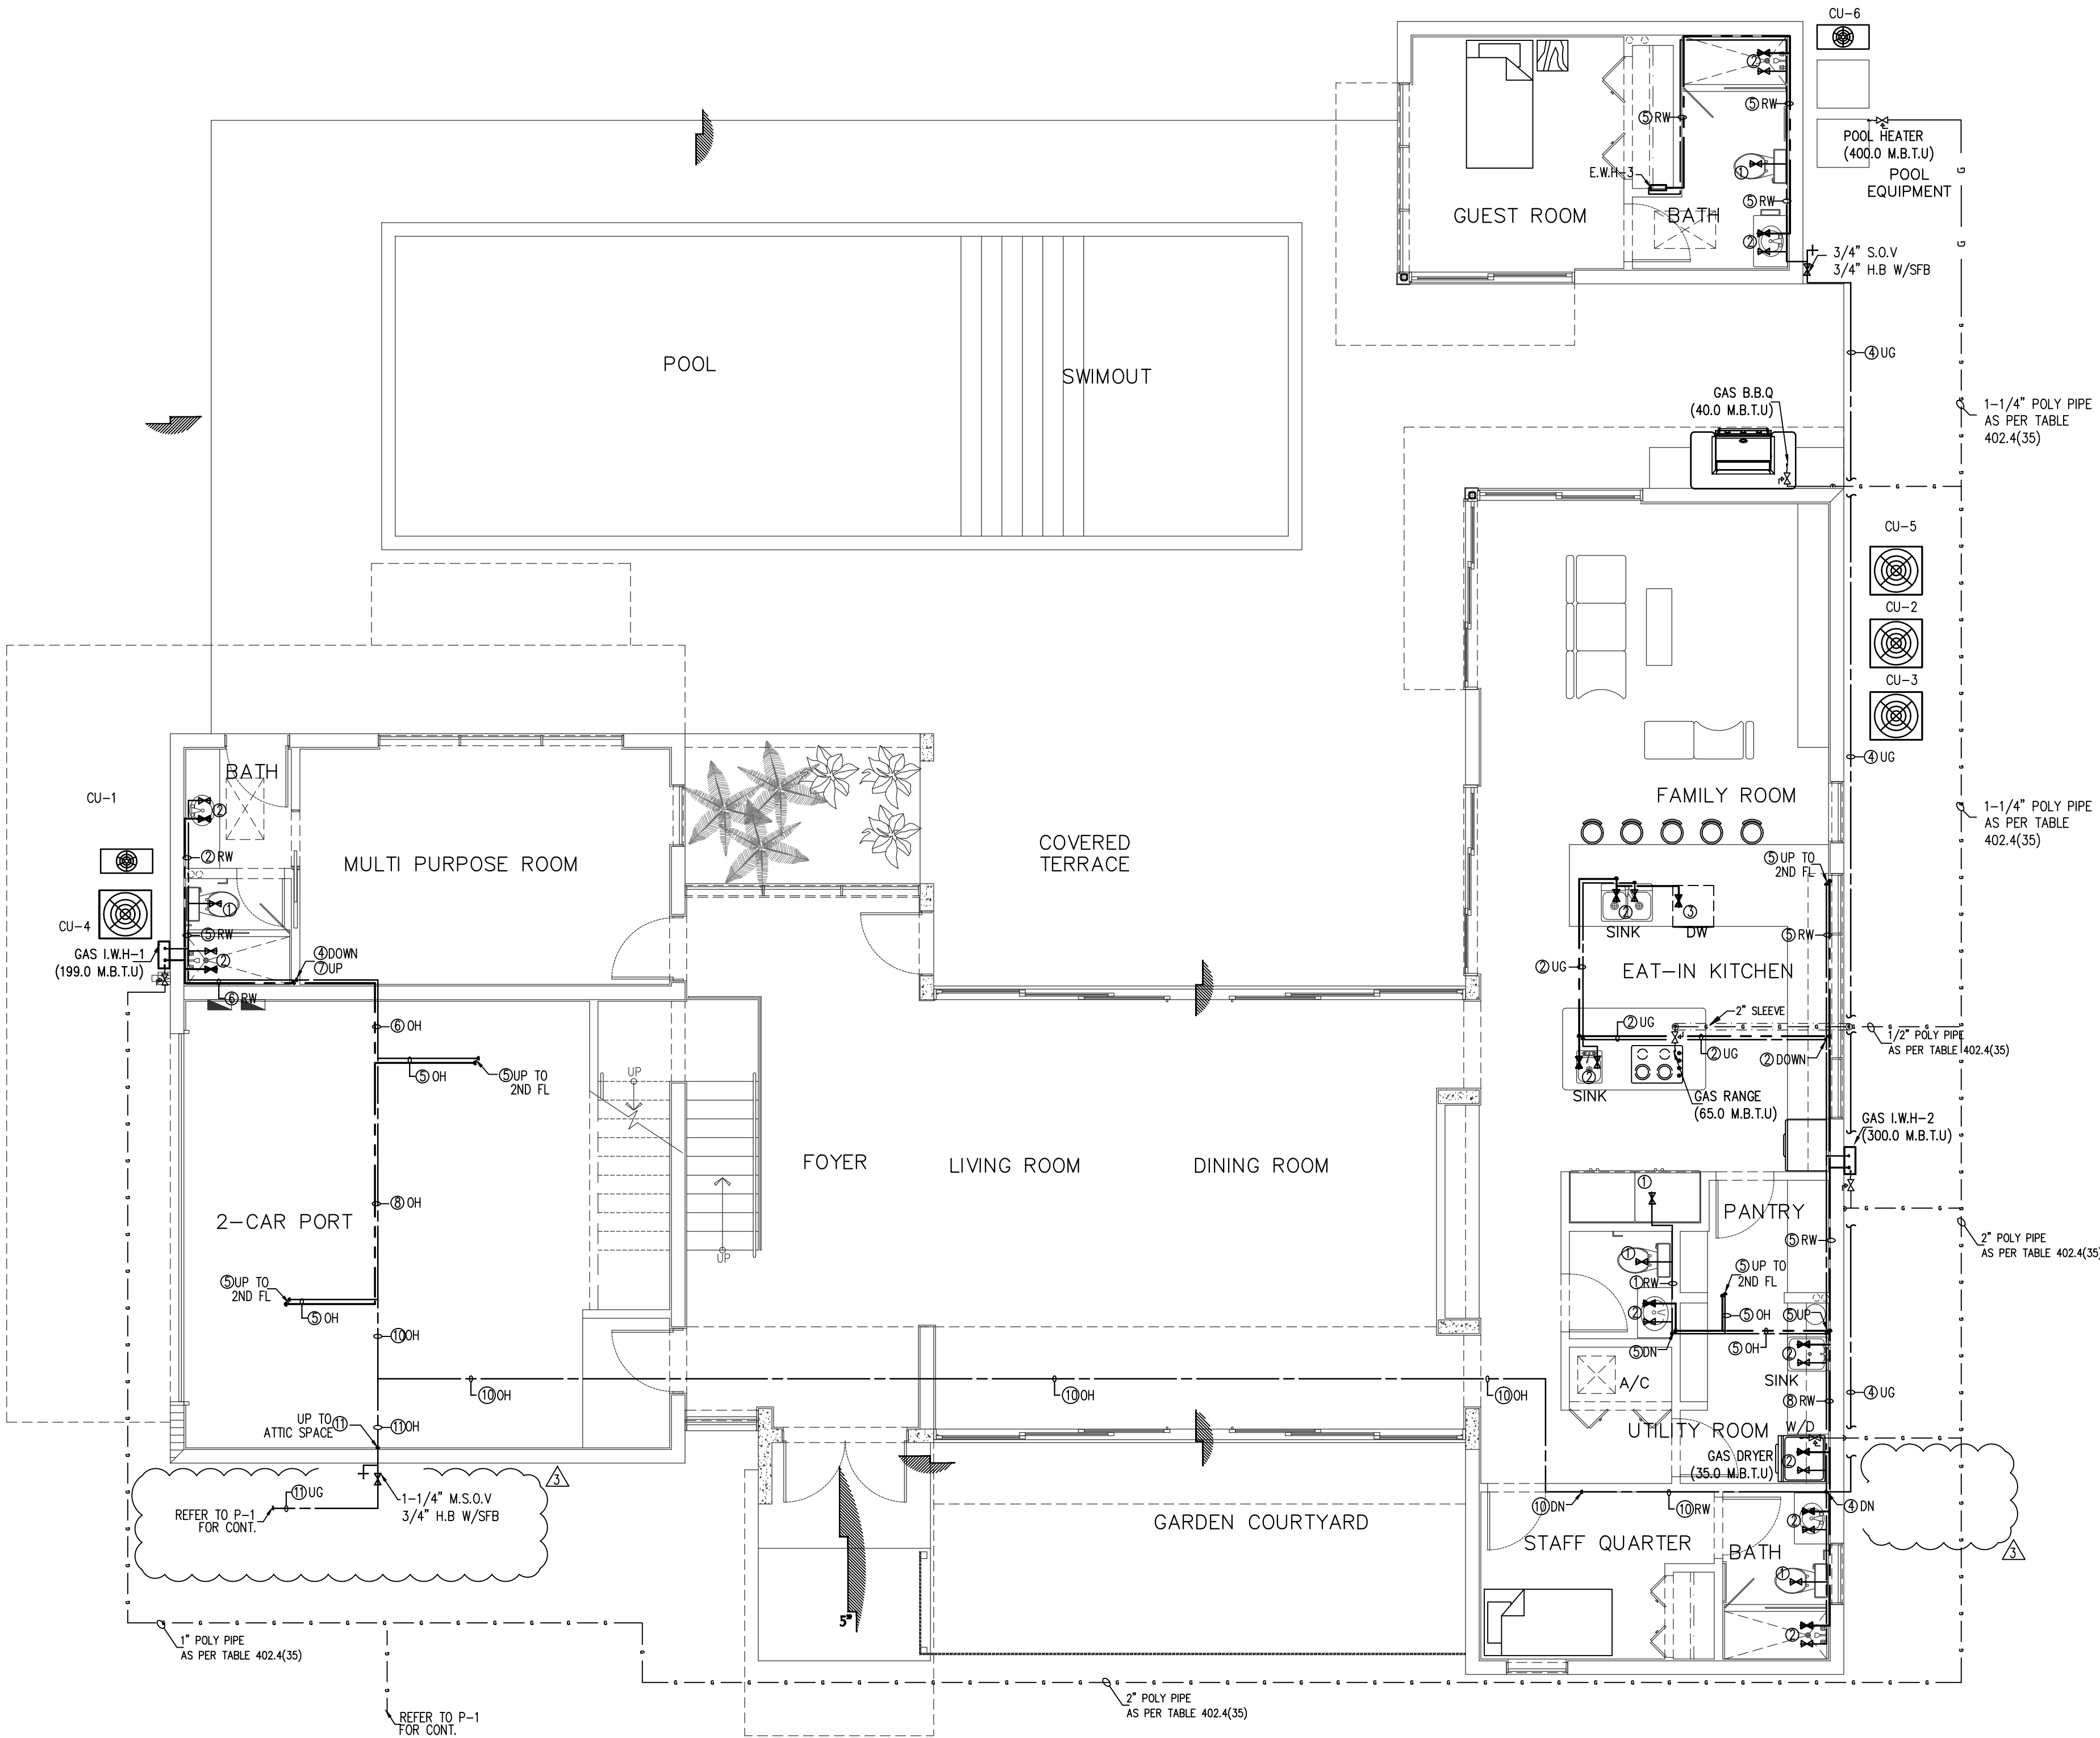

WATER FIRST FLOOR PLAN
SCALE: 3/16" = 1'-0"

RAMOSMARTINEZarchitects

MIAMI 655 W. FLAGLER ST. SUITE 205 MIAMI, FL 33130
REGISTRATION: A.A.28000528
WEBSITE: www.rmarq.com
TELEPHONE: 305-548-3006
NEW YORK 11 ERIE STREET 2nd FLOOR JERSEY CITY, NJ 07302

NEW RESIDENCE
FOR
ELIGES INVESTORS CONSTRUCTION
AT
9841 SW 73rd COURT
PINECREST, FLORIDA 33156

STRUCTURAL ENGINEER: EASTERN ENGINEERING 3401 NW 86th AVE. SUITE 370 MIAMI, FLORIDA 33122 305-599-8133
SEAL:

MECHANICAL ENGINEER:

CIVIL ENGINEER:

LANDSCAPE ARCHITECT:

ARCHITECT:
HUMBERTO RAMOS
A/E 0077833

COPYRIGHT - 2021 - RAMOSMARTINEZarchitects, inc.
THE DESIGNS, IDEAS AND DETAIL INDICATED OR REPRESENTED BY THIS DRAWING, CREATED AND DEVELOPED FOR USE ON THIS PROJECT, ARE OWNED BY AND THE LEGAL PROPERTY OF RAMOSMARTINEZ architects, inc. USE, REPRODUCTION, DISTRIBUTION OR ALTERATION IS PROHIBITED WITHOUT WRITTEN AUTHORIZATION BY THE ARCHITECT.

KEY PLAN:



COMM. NO.: 17-117 NO. REVISION: DATE:

DATE: JANUARY, 2022

DRAWN BY: 03-11-24 B.D.C

CONTENT:

SHEET NUMBER:

P-4

ORLANDO RANGEL
P.E. 60225
9940 S.W. 31th STREET MIAMI, FLORIDA 33165
TEF: 786-541 3511