


RENOVATION AND ADDITION
FOR:
CHRISTOPHER AND LISA MONTERO
LOCATED AT:
6445 SW 107 STREET
VILLAGE OF PINECREST, FLORIDA

J L D
ARCHITECT
CORPORATION
AA-26003440
8592 s.w. 169th terrace
miami, florida 33157
(305) 310-5992

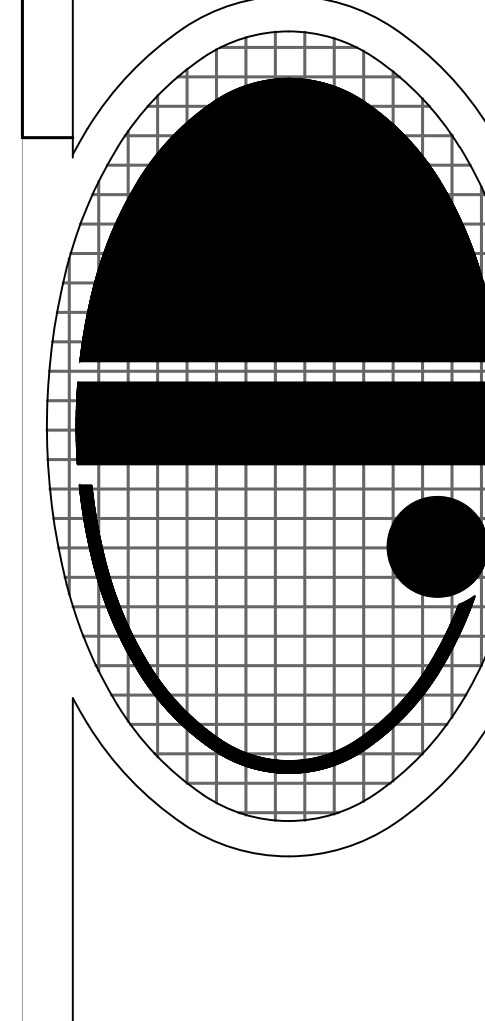


JOSE L. DIAZ, ARCHITECT
AR-0015547

DRAWN
CHECKED
DATE 11/14/22
SCALE
JOB NO.
SHEET

E-2


OF SHEET

COPYRIGHT © 2022 JOSE L. DIAZ ARCHITECT The architectural design and detail drawings for this building, and for overall project, are the legal property of and all rights are reserved by the architect. Their use for reproduction, construction or distribution is prohibited unless otherwise stated by the architect.

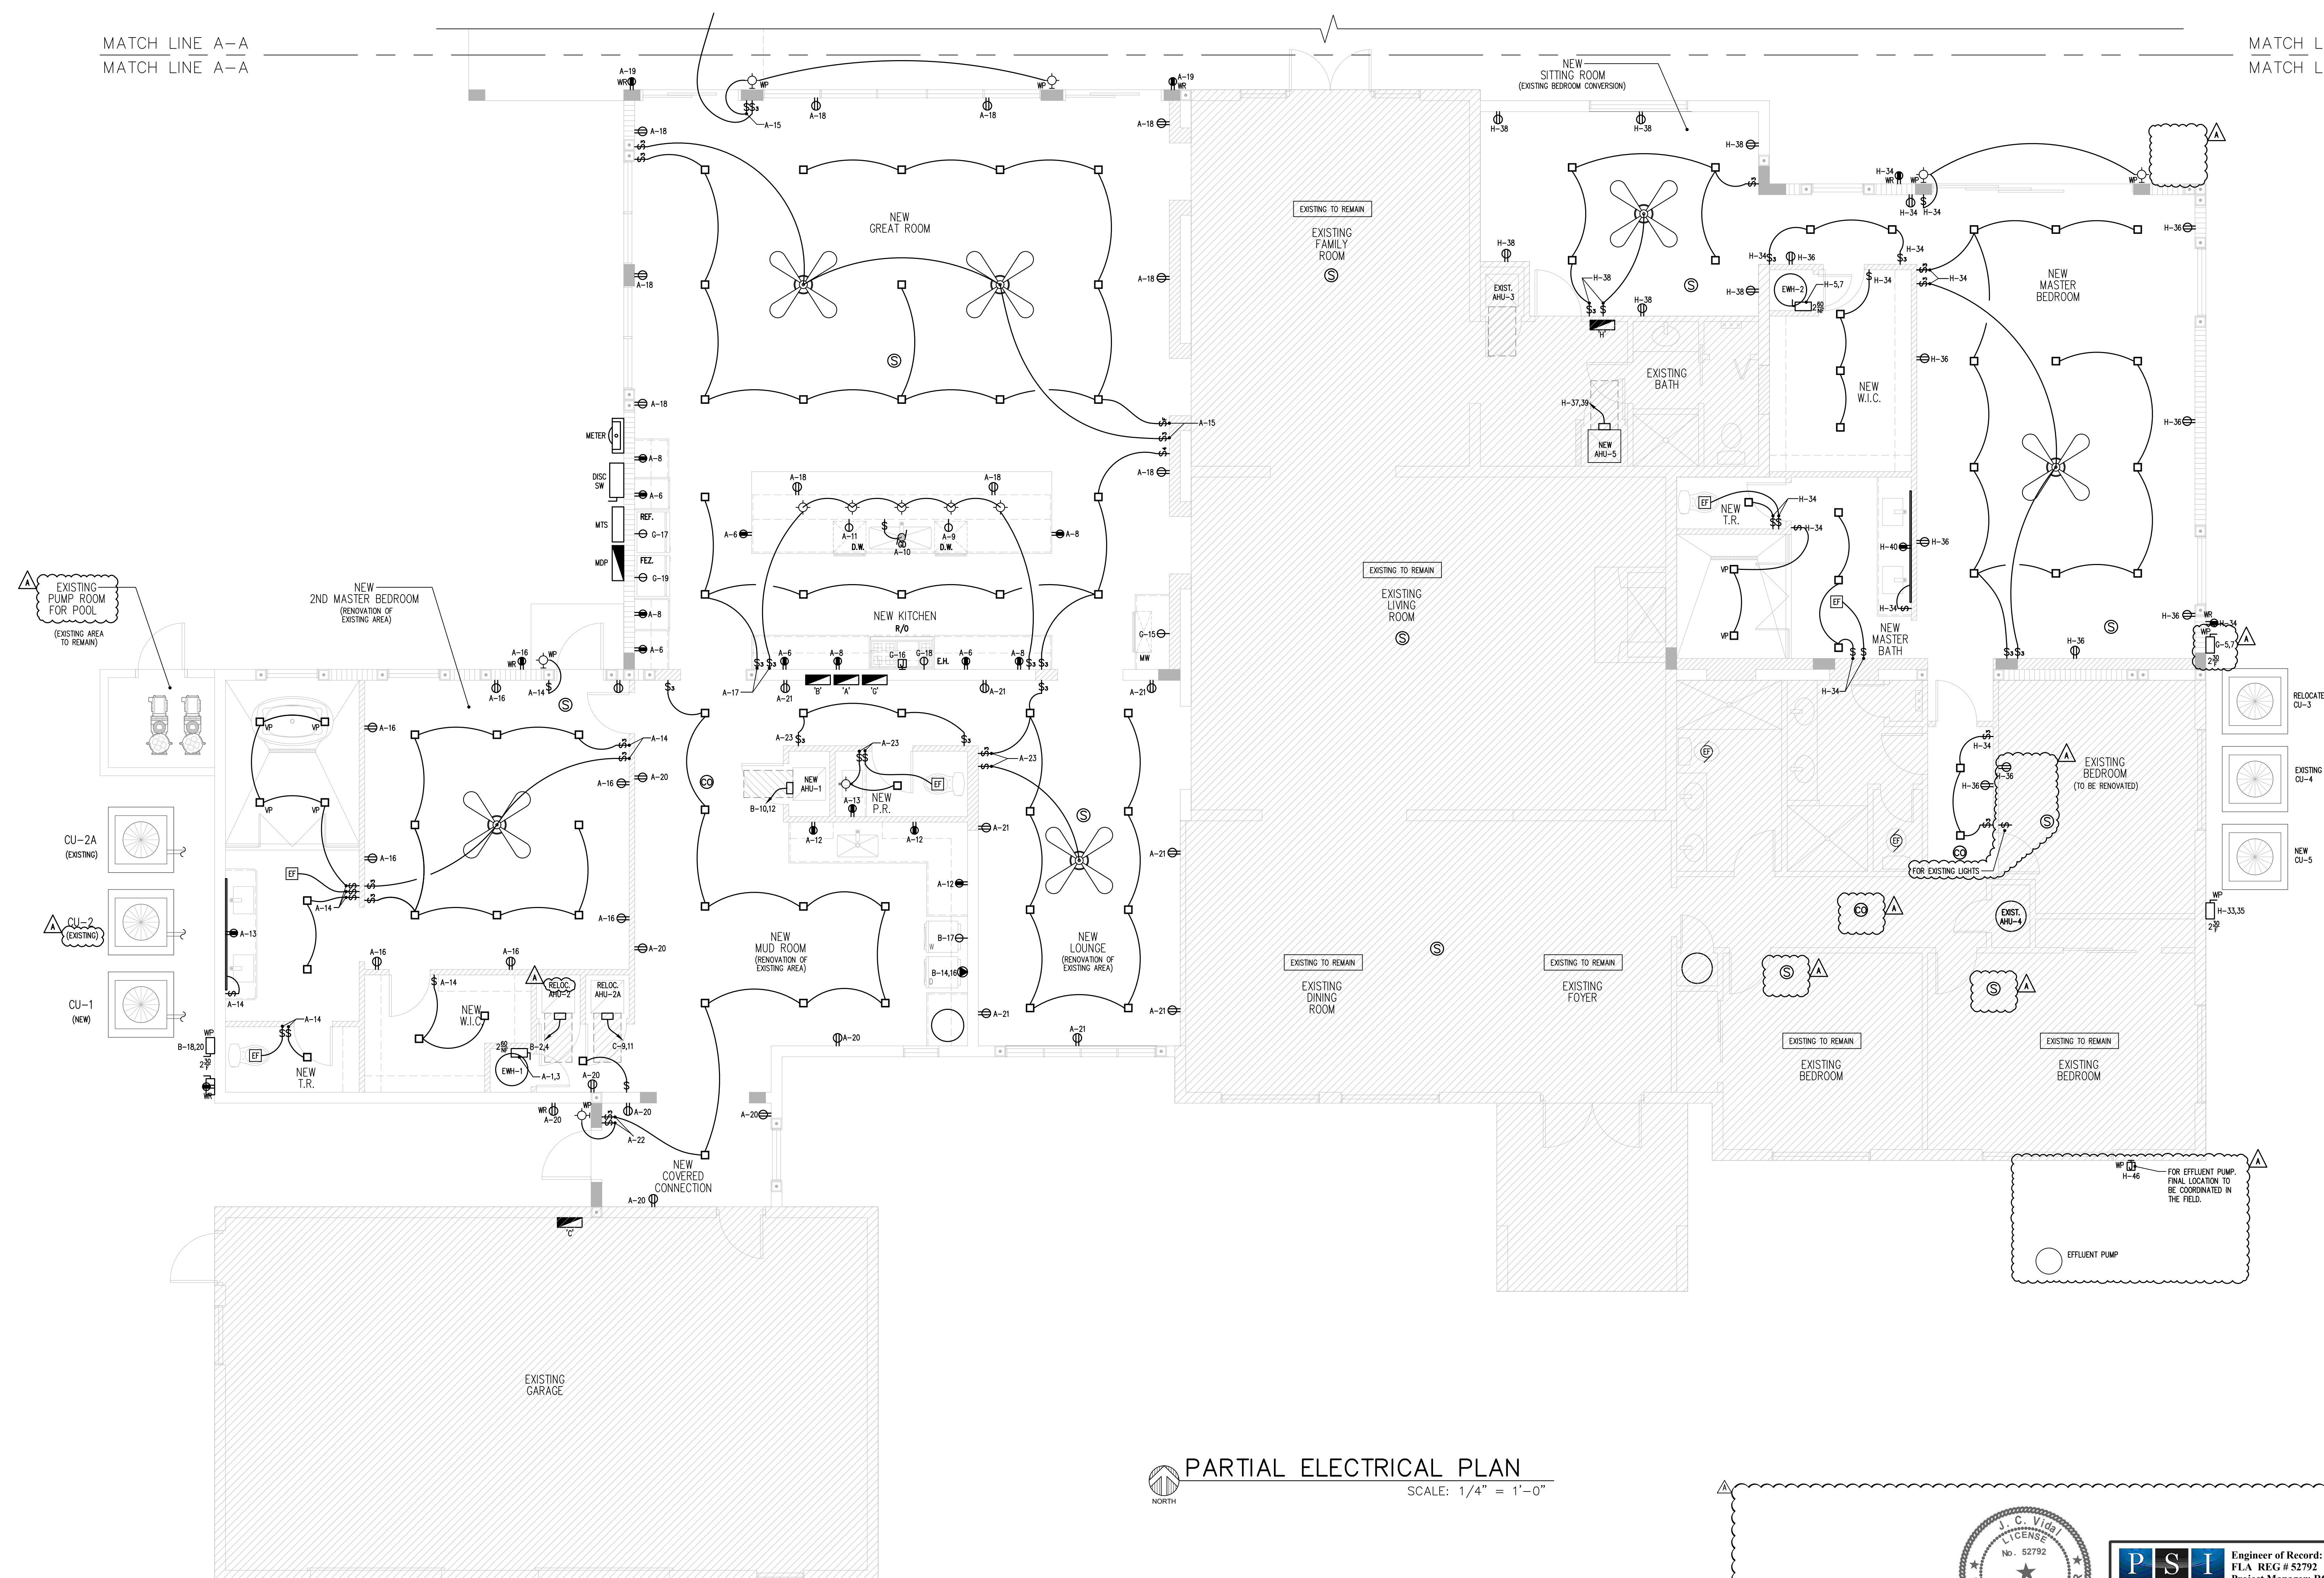


PARTIAL ELECTRICAL PLAN

SCALE: 1/4" = 1'-0"

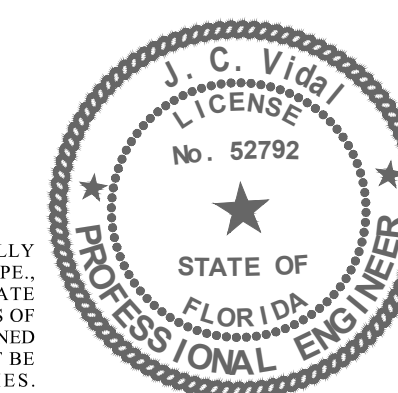

THIS DRAWING HAS BEEN ELECTRONICALLY
SIGNED AND SEALED BY JULIO C. VIDAL P.
USING A DIGITAL SIGNATURE ON THE DATA
ADJACENT TO THE SEAL. PRINTED COPIES
OF THIS DOCUMENT ARE NOT CONSIDERED SIGNED
AND SEALED AND THE SIGNATURE MUST BE
VERIFIED ON ANY ELECTRONIC COPY.

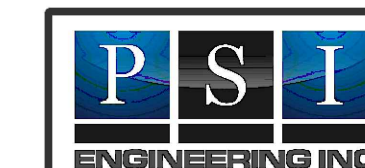

Engineer of Record: JULIO VIDAL PE
FLA REG # 52792
Project Manager: ROGER PEREZ

10556 NW 26 STREET, SUITE D-202 DORAL, FL 33172 PH: 786-615-7520, FAX: 786-752-3284
 CERTIFICATE OF AUTHORIZATION # 30280 email:roger.nreez@nsiengineeringinc.com