


RENOVATION AND ADDITION
FOR:
CHRISTOPHER AND LISA MONTERO
LOCATED AT:
6445 SW 107 STREET
VILLAGE OF PINECREST, FLORIDA

J L D
ARCHITECT
CORPORATION
AA-26003440
8592 s.w. 169th terrace
miami, florida 33157
(305) 310-5992

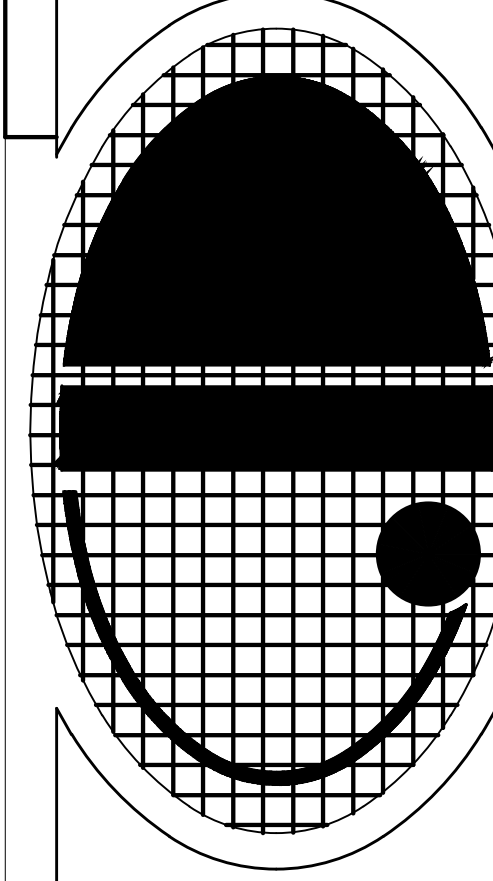


2021-25_6201 Maynada SULD_Sest.jpg

JOSE L. DIAZ, ARCHITECT
AR-0015547


DRAWN	
CHECKED	
DATE	11/14/22
SCALE	
JOB NO.	

P-2 }
OF SHEETS

COPYRIGHT © 2022 JOSE L. DIAZ ARCHITECT The architectural design and detail drawings for this building, and/or overall project, are the legal property of and all rights are reserved by the architect. Their use for reproduction, construction or distribution is prohibited unless authorized in writing by the architect.

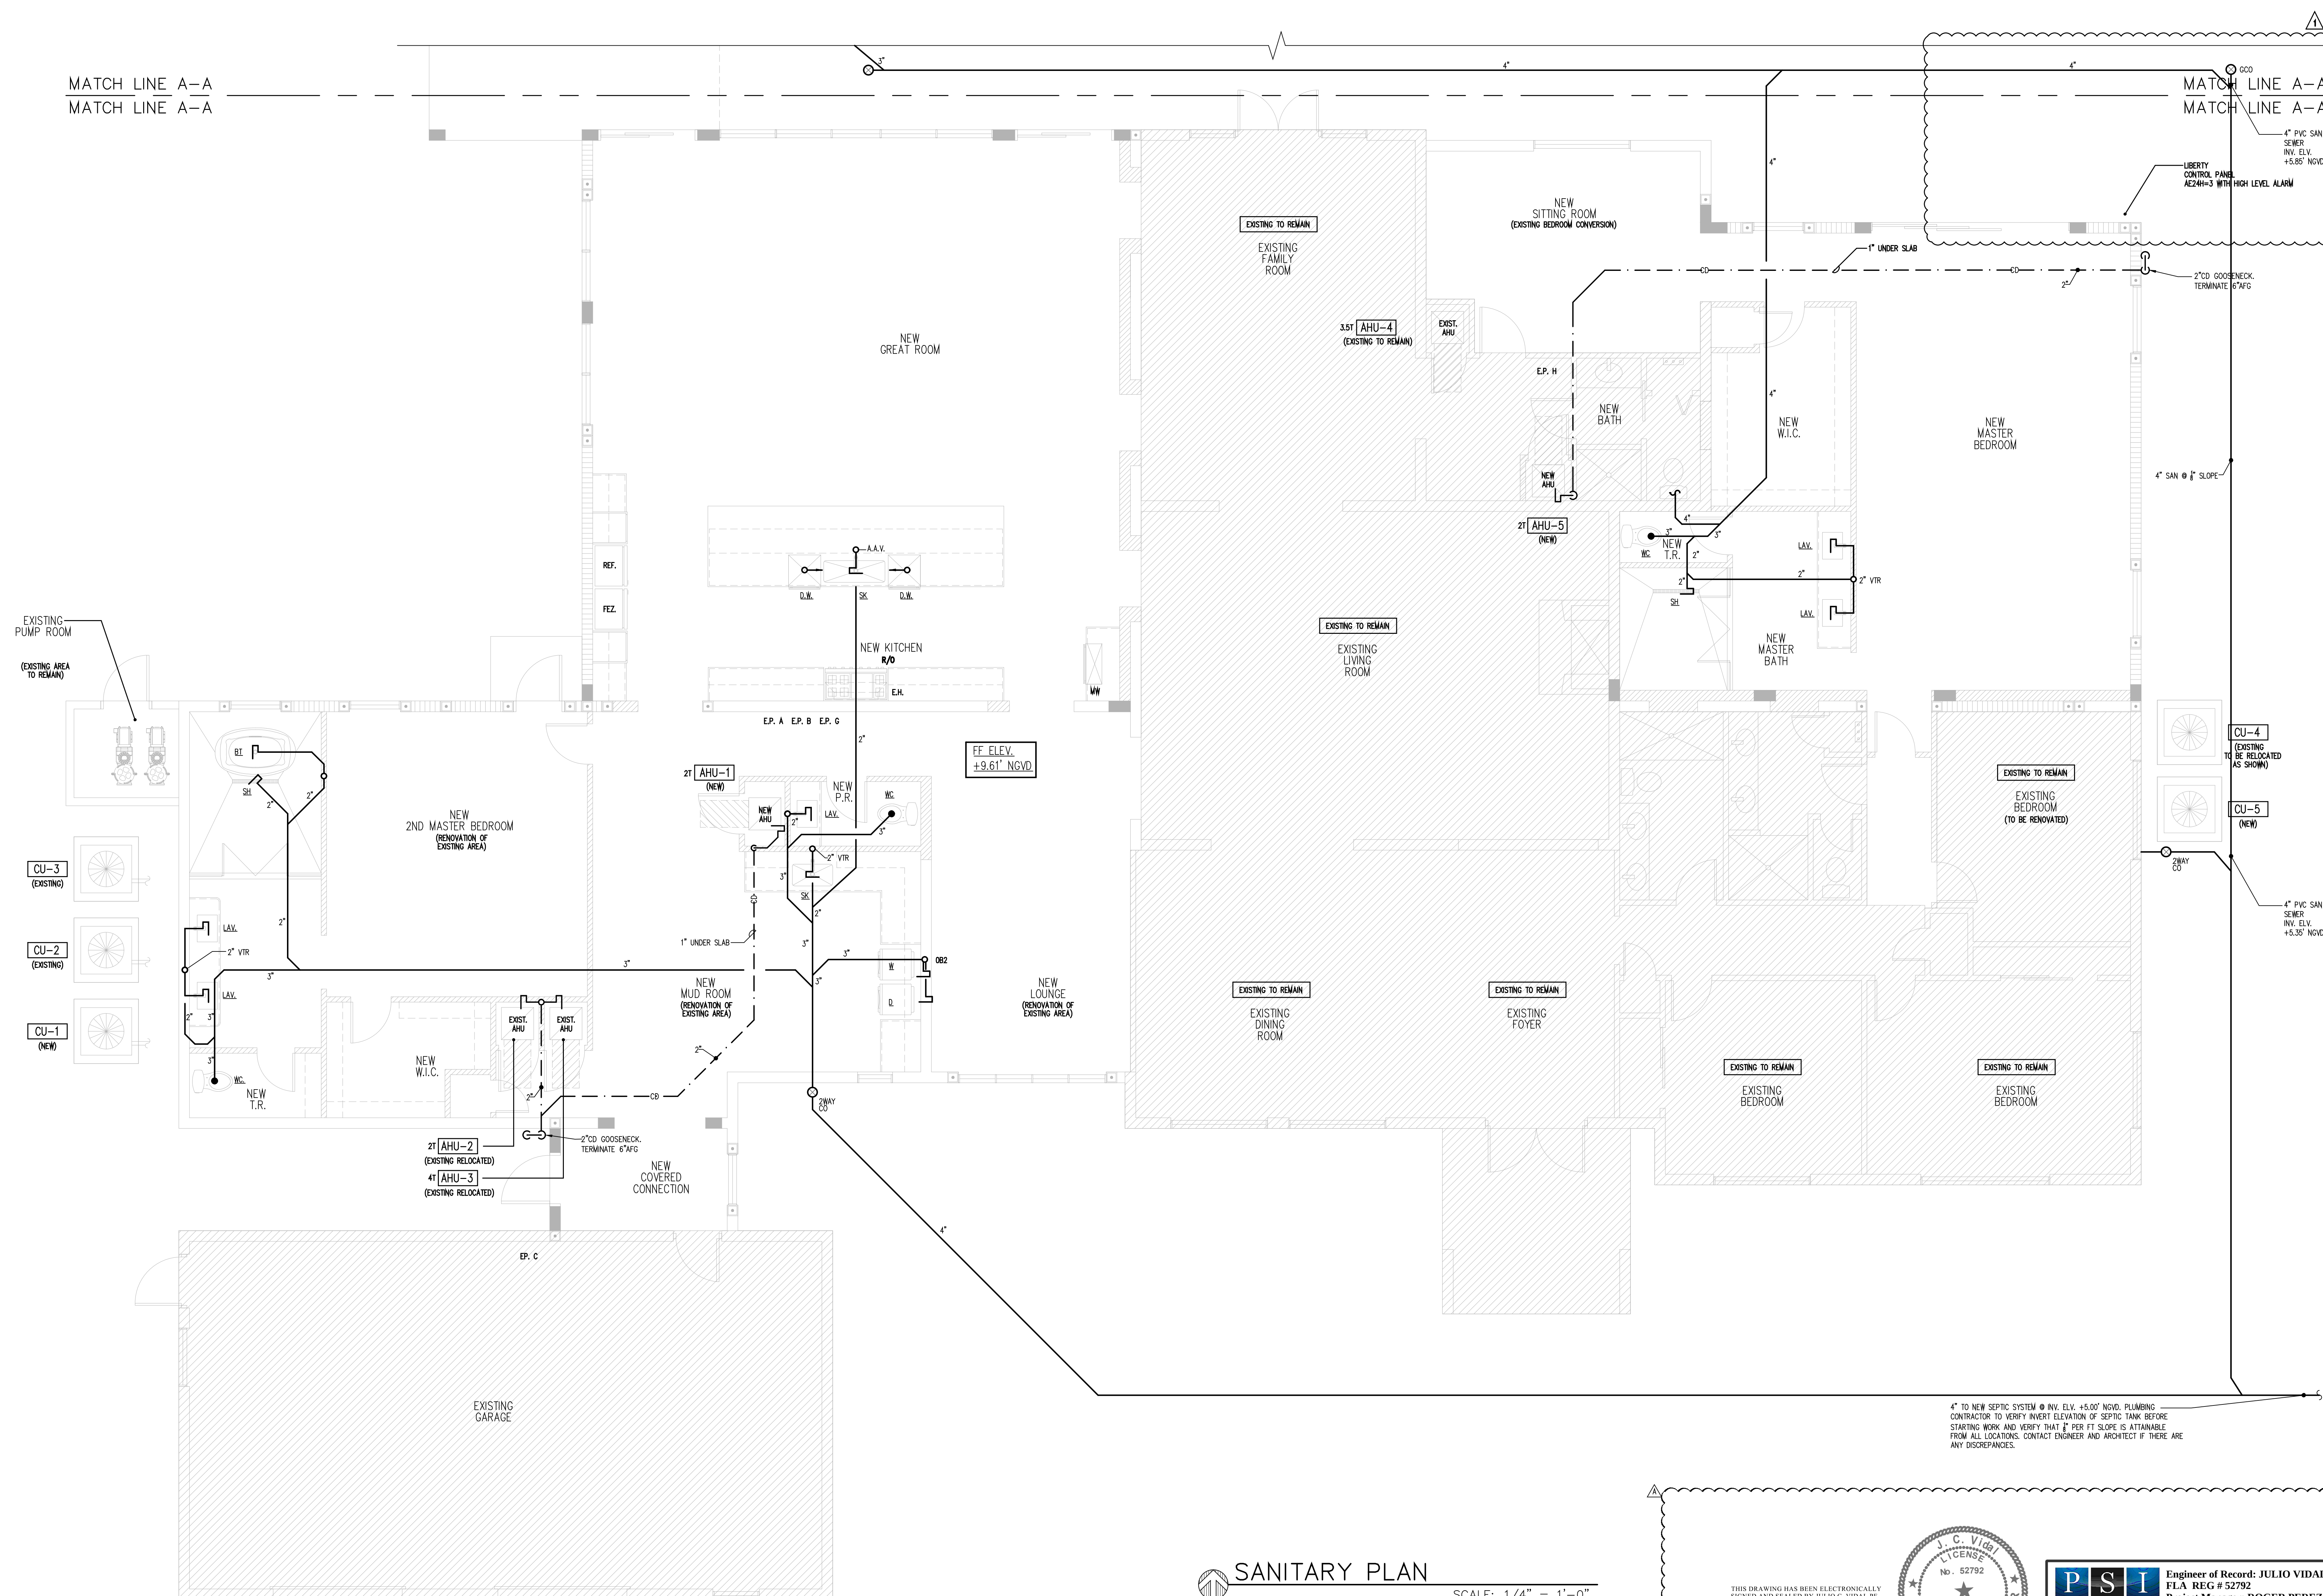

4" TO NEW SEPTIC SYSTEM @ INV. ELV. +5.00' NGVD. PLUMBING CONTRACTOR TO VERIFY INVERT ELEVATION OF SEPTIC TANK BEFORE STARTING WORK AND VERIFY THAT $\frac{1}{8}$ " PER FT SLOPE IS ATTAINABLE FROM ALL LOCATIONS. CONTACT ENGINEER AND ARCHITECT IF THERE ARE ANY DISCREPANCIES.

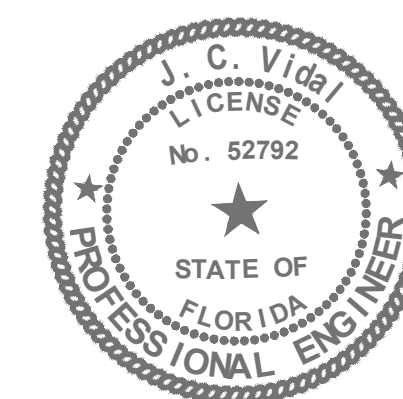

PSI
ENGINEERING INC

Engineer of Record: JULIO VIDAL P
FLA REG # 52792
Project Manager: ROGER PEREZ

10556 NW 26 STREET, SUITE D-202 DORAL, FL 33172 PH: 786-615-7520, FAX: 786-752-326

SANITARY PLAN

SCALE: $1/4" = 1'-0"$