


RENOVATION AND ADDITION
FOR:
CHRISTOPHER AND LISA MONTERO
LOCATED AT:
6445 SW 107 STREET
VILLAGE OF PINECREST, FLORIDA

J L D
ARCHITECT
CORPORATION
AA-26003440
8592 s.w. 169th terrace
miami, florida 33157
(305) 310-5992

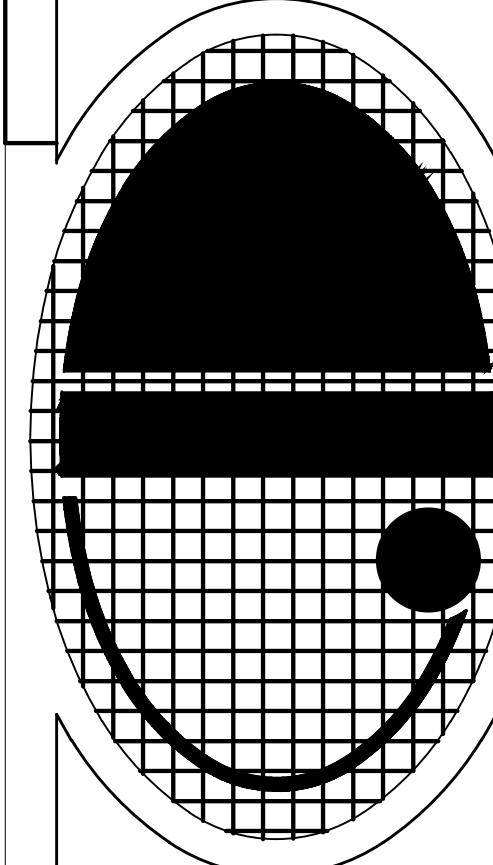


2021-25_6201 Maynada SQUID_Seal.jpg

JOSE L. DIAZ, ARCHITECT
AR-0015547


DRAWN _____
CHECKED _____
DATE 11/14/22
SCALE _____
JOB NO. _____
SHEET _____
P-3
OF _____ SHEETS

COPYRIGHT © 2022 JOSE L. DIAZ ARCHITECT The architectural design and detail drawings for this building, and/or overall project, are the legal property of and all rights are reserved by the architect. Their use for reproduction, construction or distribution is prohibited unless authorized in writing by the architect.

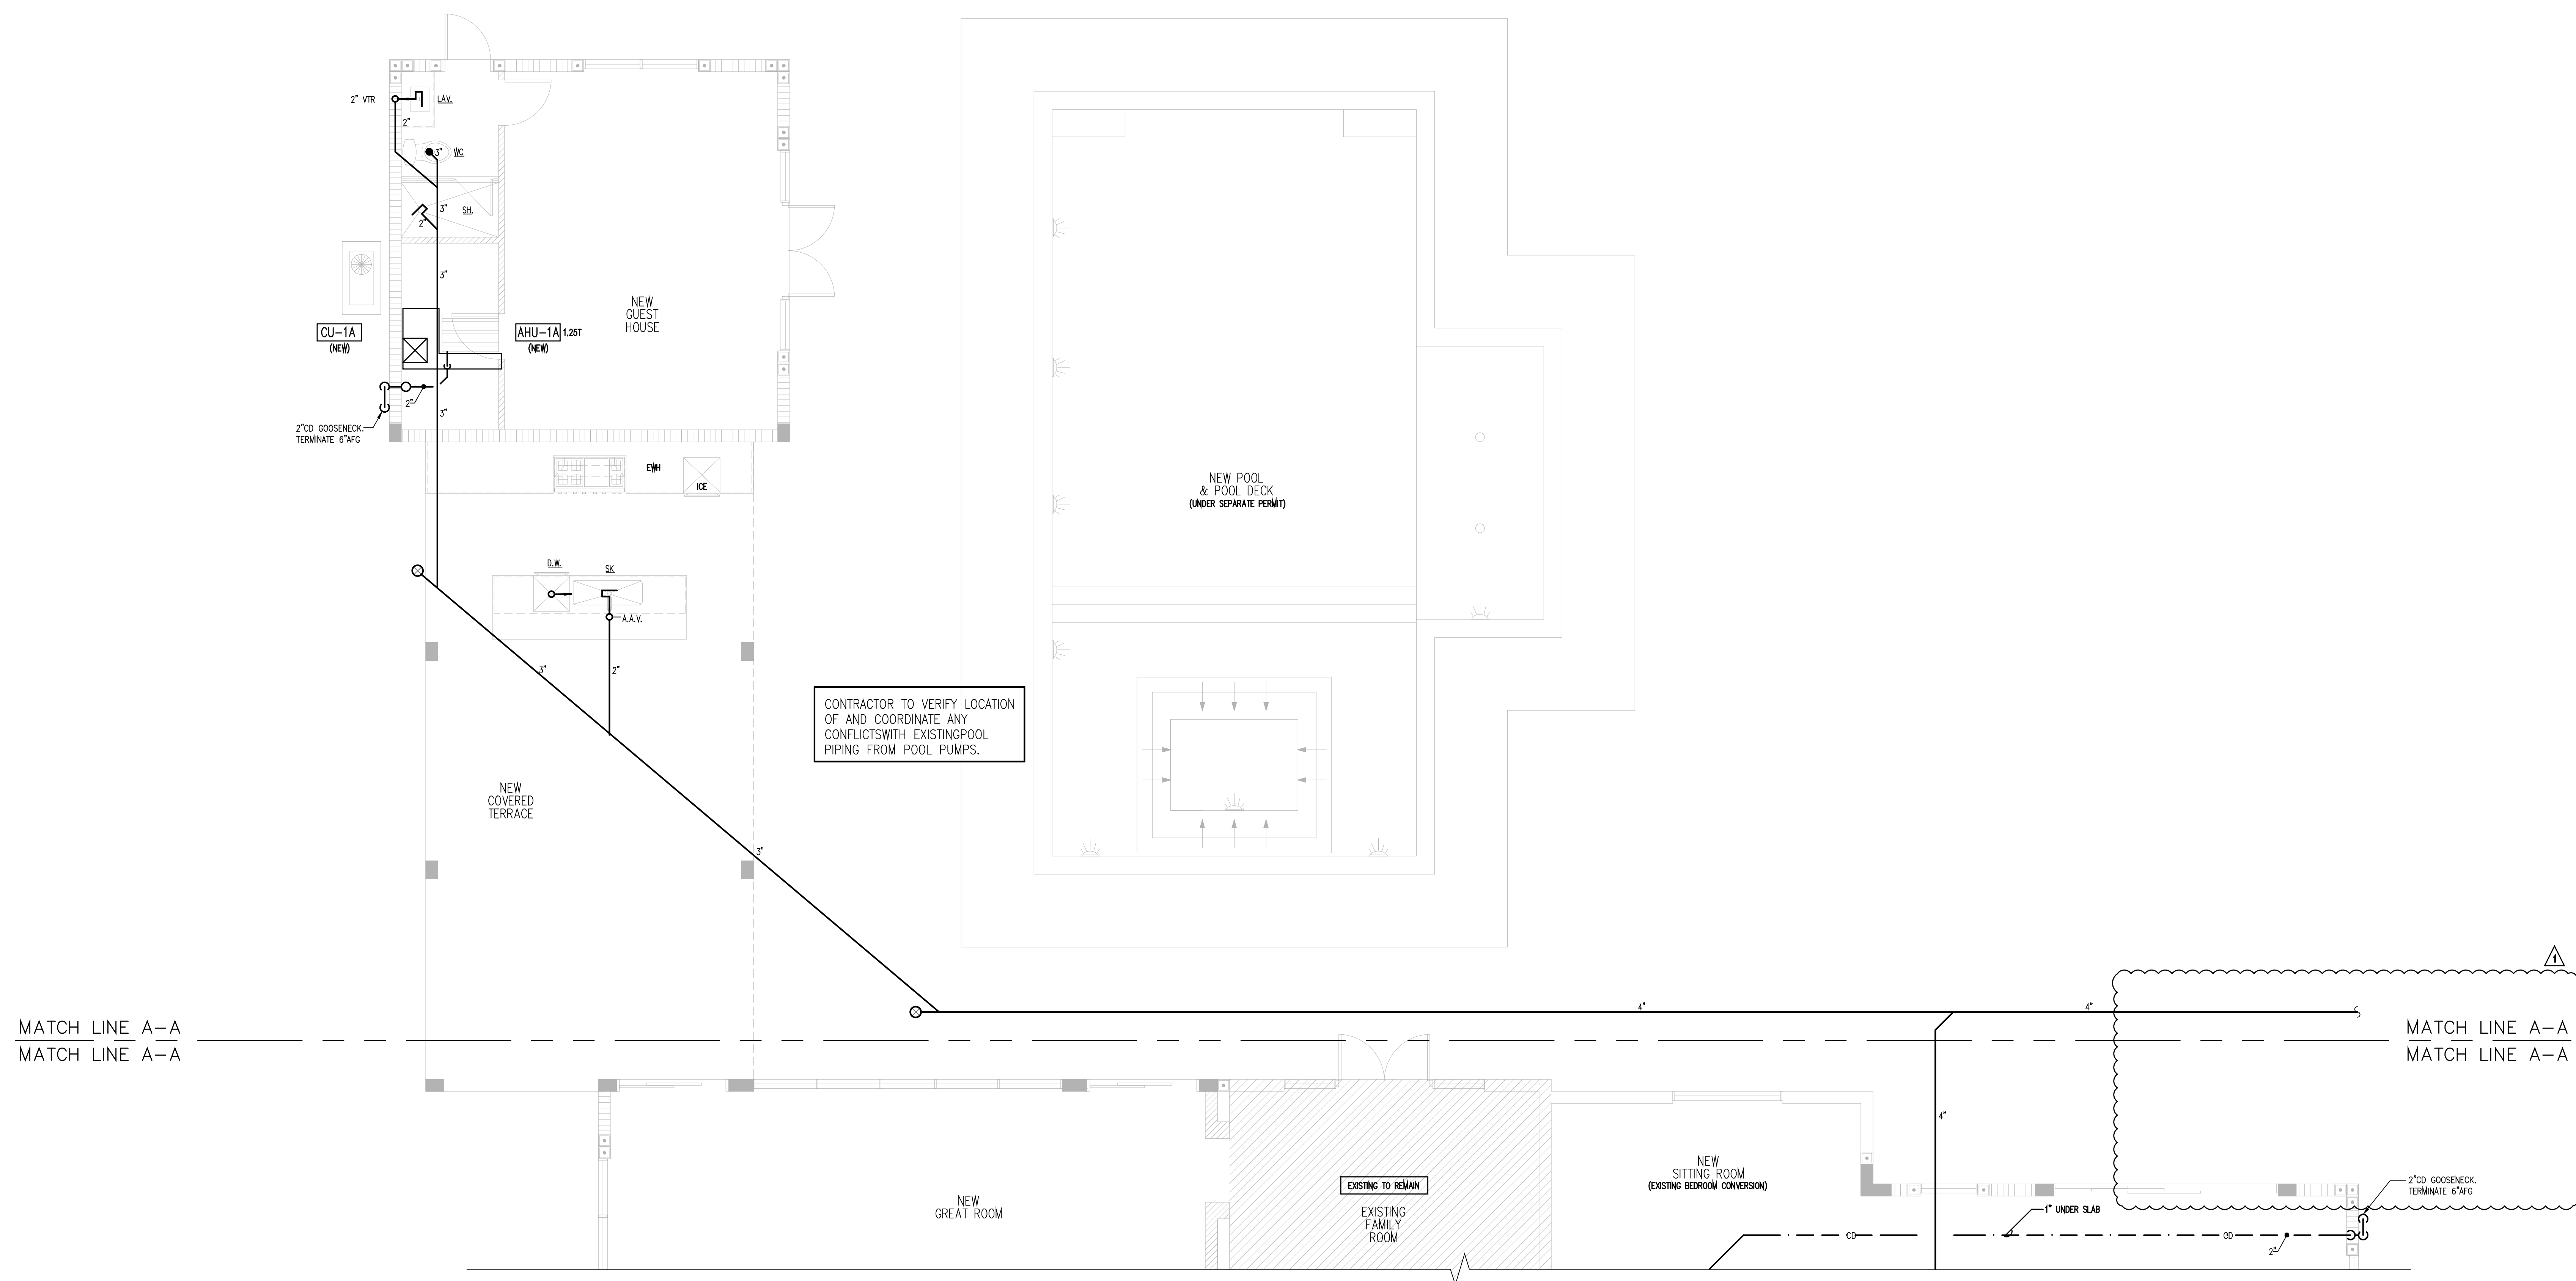

SANITARY PLAN

SCALE: 1/4" = 1'-0"

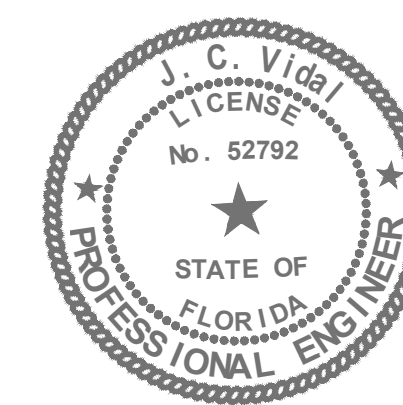

PSI
ENGINEERING INC.

Engineer of Record: JULIO VIDAL PE
FLA REG # 52792
Project Manager: ROGER PEREZ

10556 NW 26 STREET, SUITE D-202 DORAL, FL 33172 PH: 786-615-7520, FAX: 786-752-3284
 CERTIFICATE OF AUTHORIZATION # 30280 email: roger.perez@psiengineeringinc.com