


COPYRIGHT © 2023 PASCUAL, PEREZ, KILIDDJIAN & ASSOCIATES — ARCHITECTS — PLANNERS
The architectural design and detail drawings for this building and / or overall project are the legal property of and all rights are reserved by the Architect. Their use for reproduction, construction or distribution is prohibited unless authorized in writing by Architect.

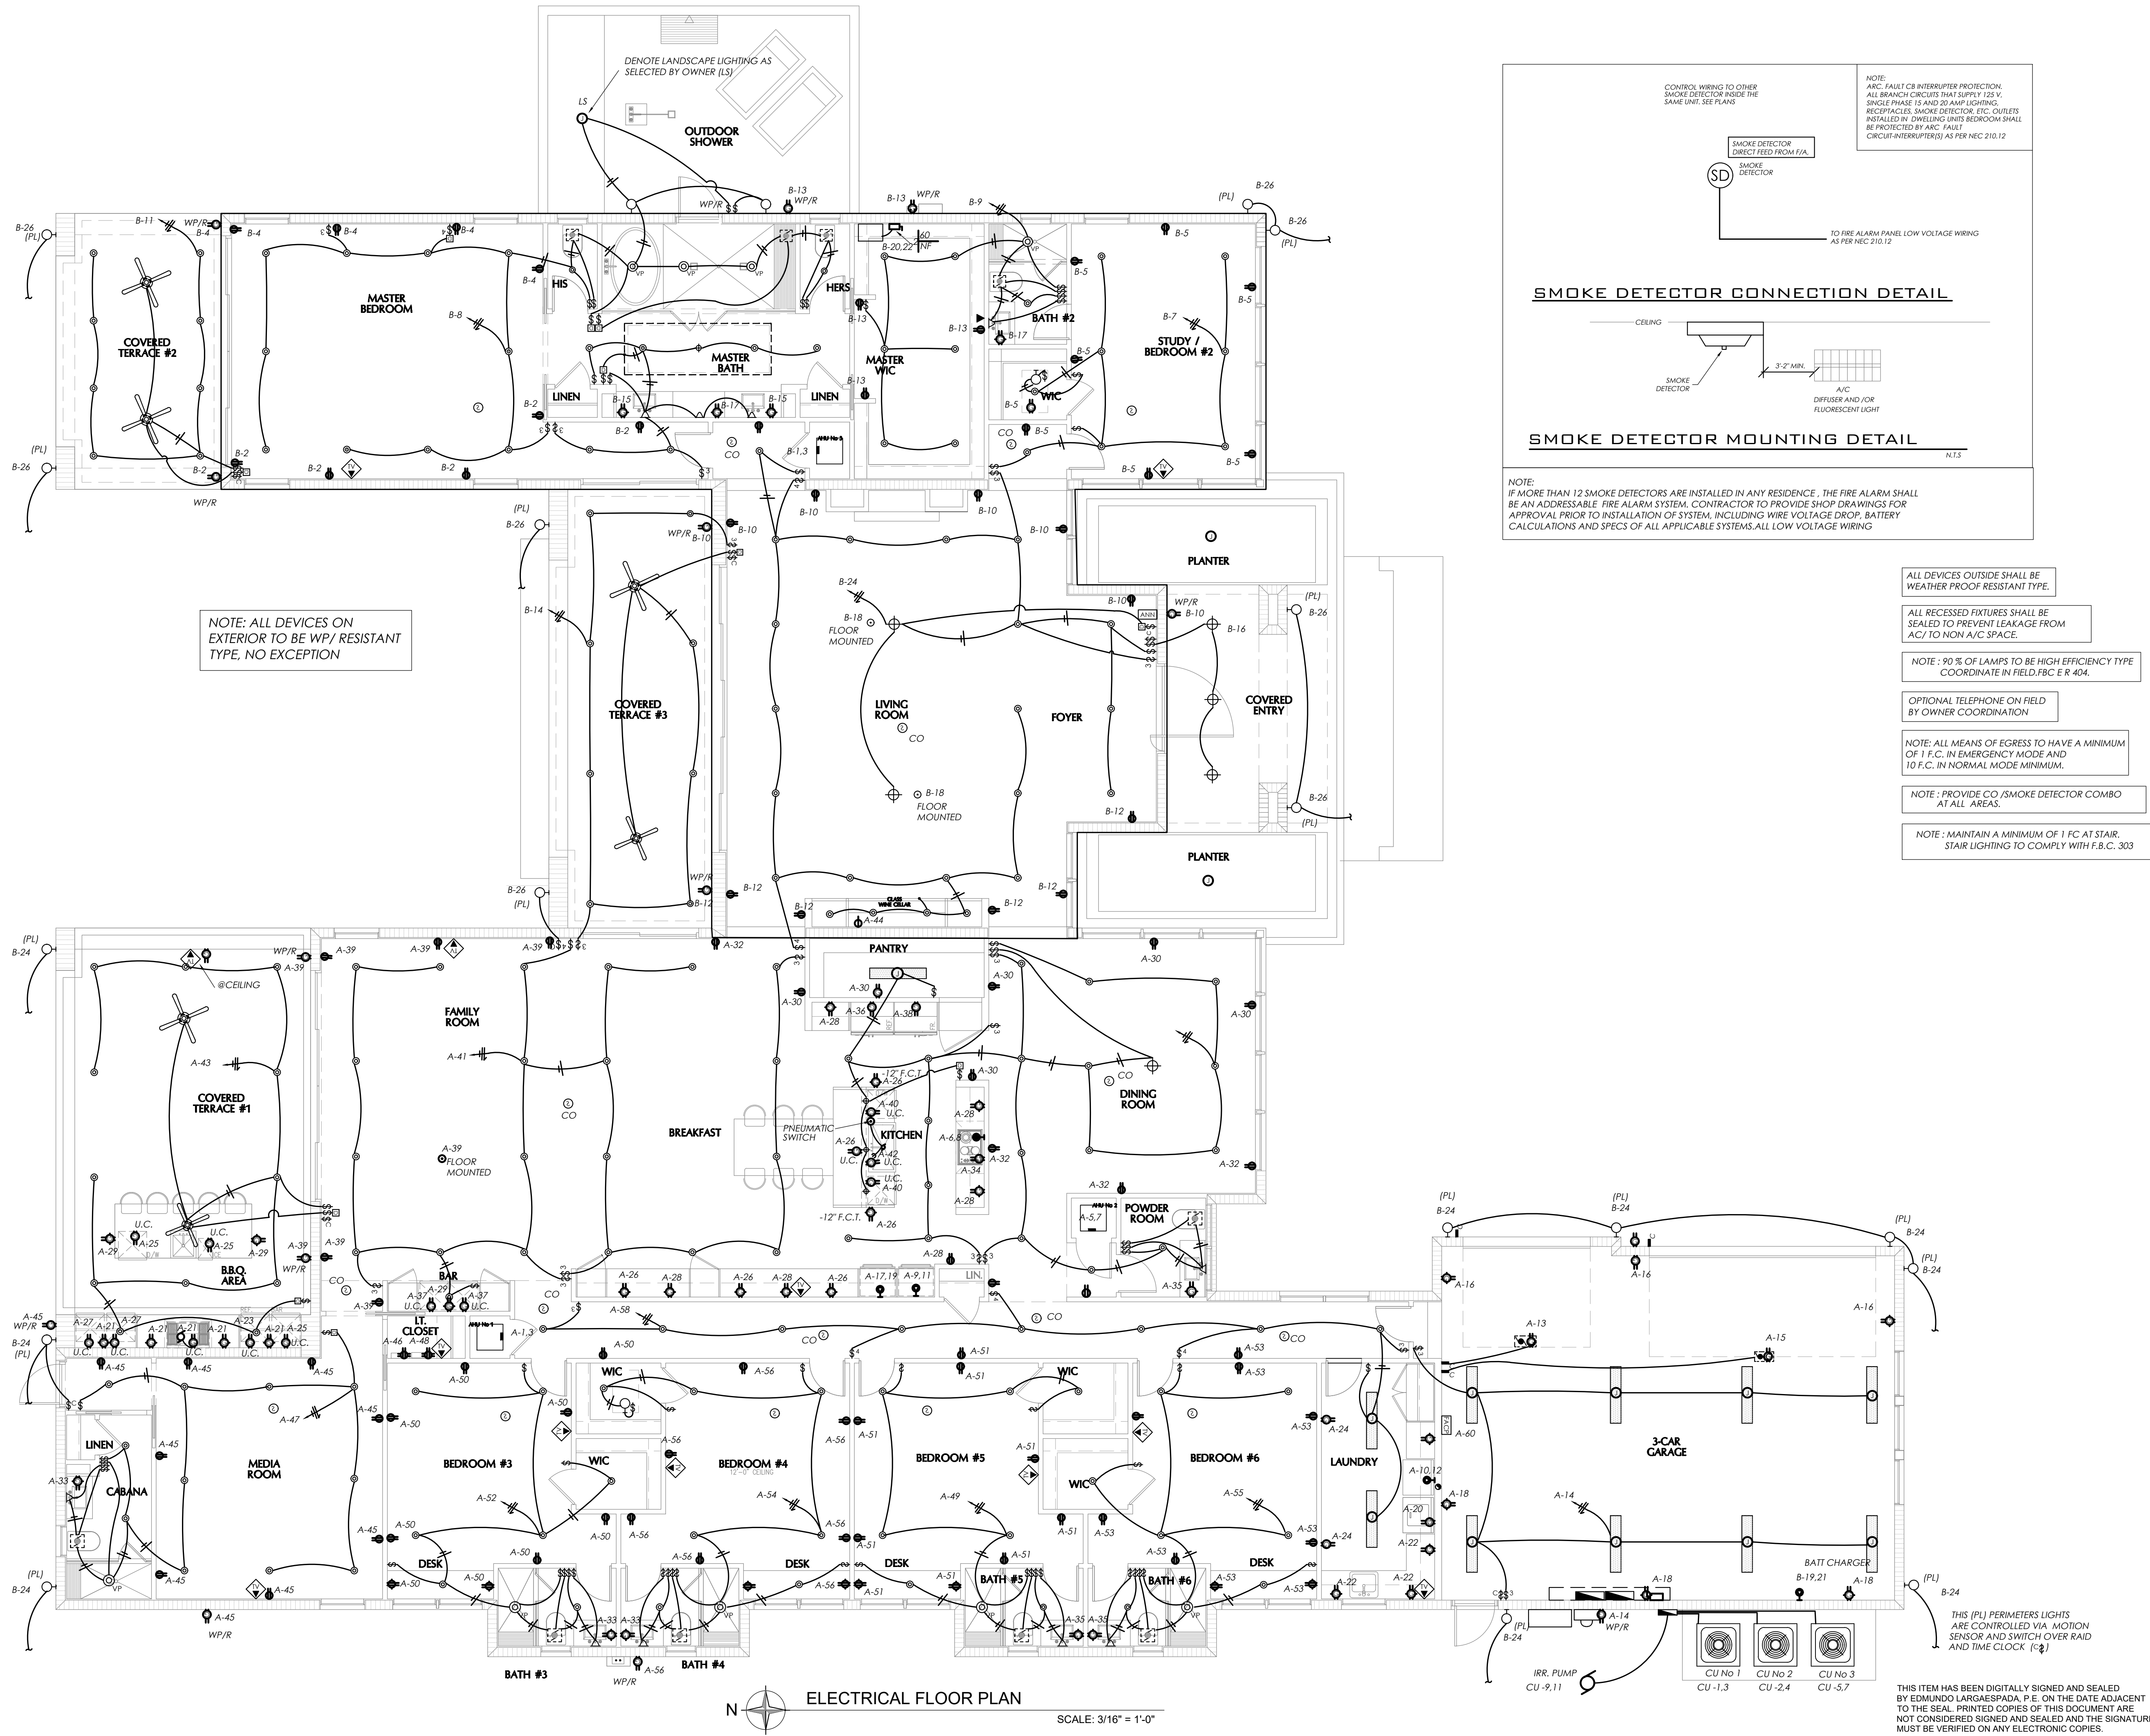

**PASCUAL
PEREZ
KILIDDJIAN
STARR**

ARCHITECTS + PLANNERS

LICENSE # AA 26001357
EDGARDO PEREZ, AIA
LICENSE No.: AR 0015394
MARIO P. PASCUAL, AIA
LICENSE No.: AR 0008254
PETER KILIDDJIAN, RA
LICENSE No.: AR 0093067
ANDREW STARR, RA
LICENSE No.: AR 0095130

AT THE BEACON CENTER
1330 NW 84th AVENUE
DORAL, FLORIDA 33126
TELEPHONE: (305) 592-1343
FACSIMILE: (305) 592-6865
<http://www.ppkarch.com>

COPYRIGHT © PASCUAL, PEREZ, KILIDDJIAN
STARR, ARCHITECTS - PLANNERS
The architectural design and detail drawings
of this building and/or overall project are the
legal property of, and all rights are reserved
by the Architect. Their use for reproduction,
construction or distribution is prohibited unless
authorized in writing by the Architect.

REVISIONS:

OWNER:
HERITAGE HOME BUILDERS, LLC
9350 SOUTH DIXIE HIGHWAY
SUITE 1500
MIAMI, FL 33156
PHONE: 305.665.3077

NEW CONSTRUCTION AT PINECREST RESIDENCE:
BY HERITAGE HOME BUILDERS, LLC
7725 SOUTHWEST 114 STREET
VILLAGE OF PINECREST, FL 33156

SEAL:

CMBeng.
Consulting • Design
CMB eng llc • Miami, Florida 33185
14850 SW 26 St. #215 • CMB@CMBeng.com
O. 786.375.5348

L.C. No. 35097
Edmundo Largaespada, P.E.
Professional Engineer
P.E. No. 0058915

ELECTRICAL FLOOR PLAN

DATE: 03/23/2023
SCALE: AS SHOWN
DRAWN:
CHECK BY:
JOB NO.: 23_0012

E-2

SHEET NO.: