


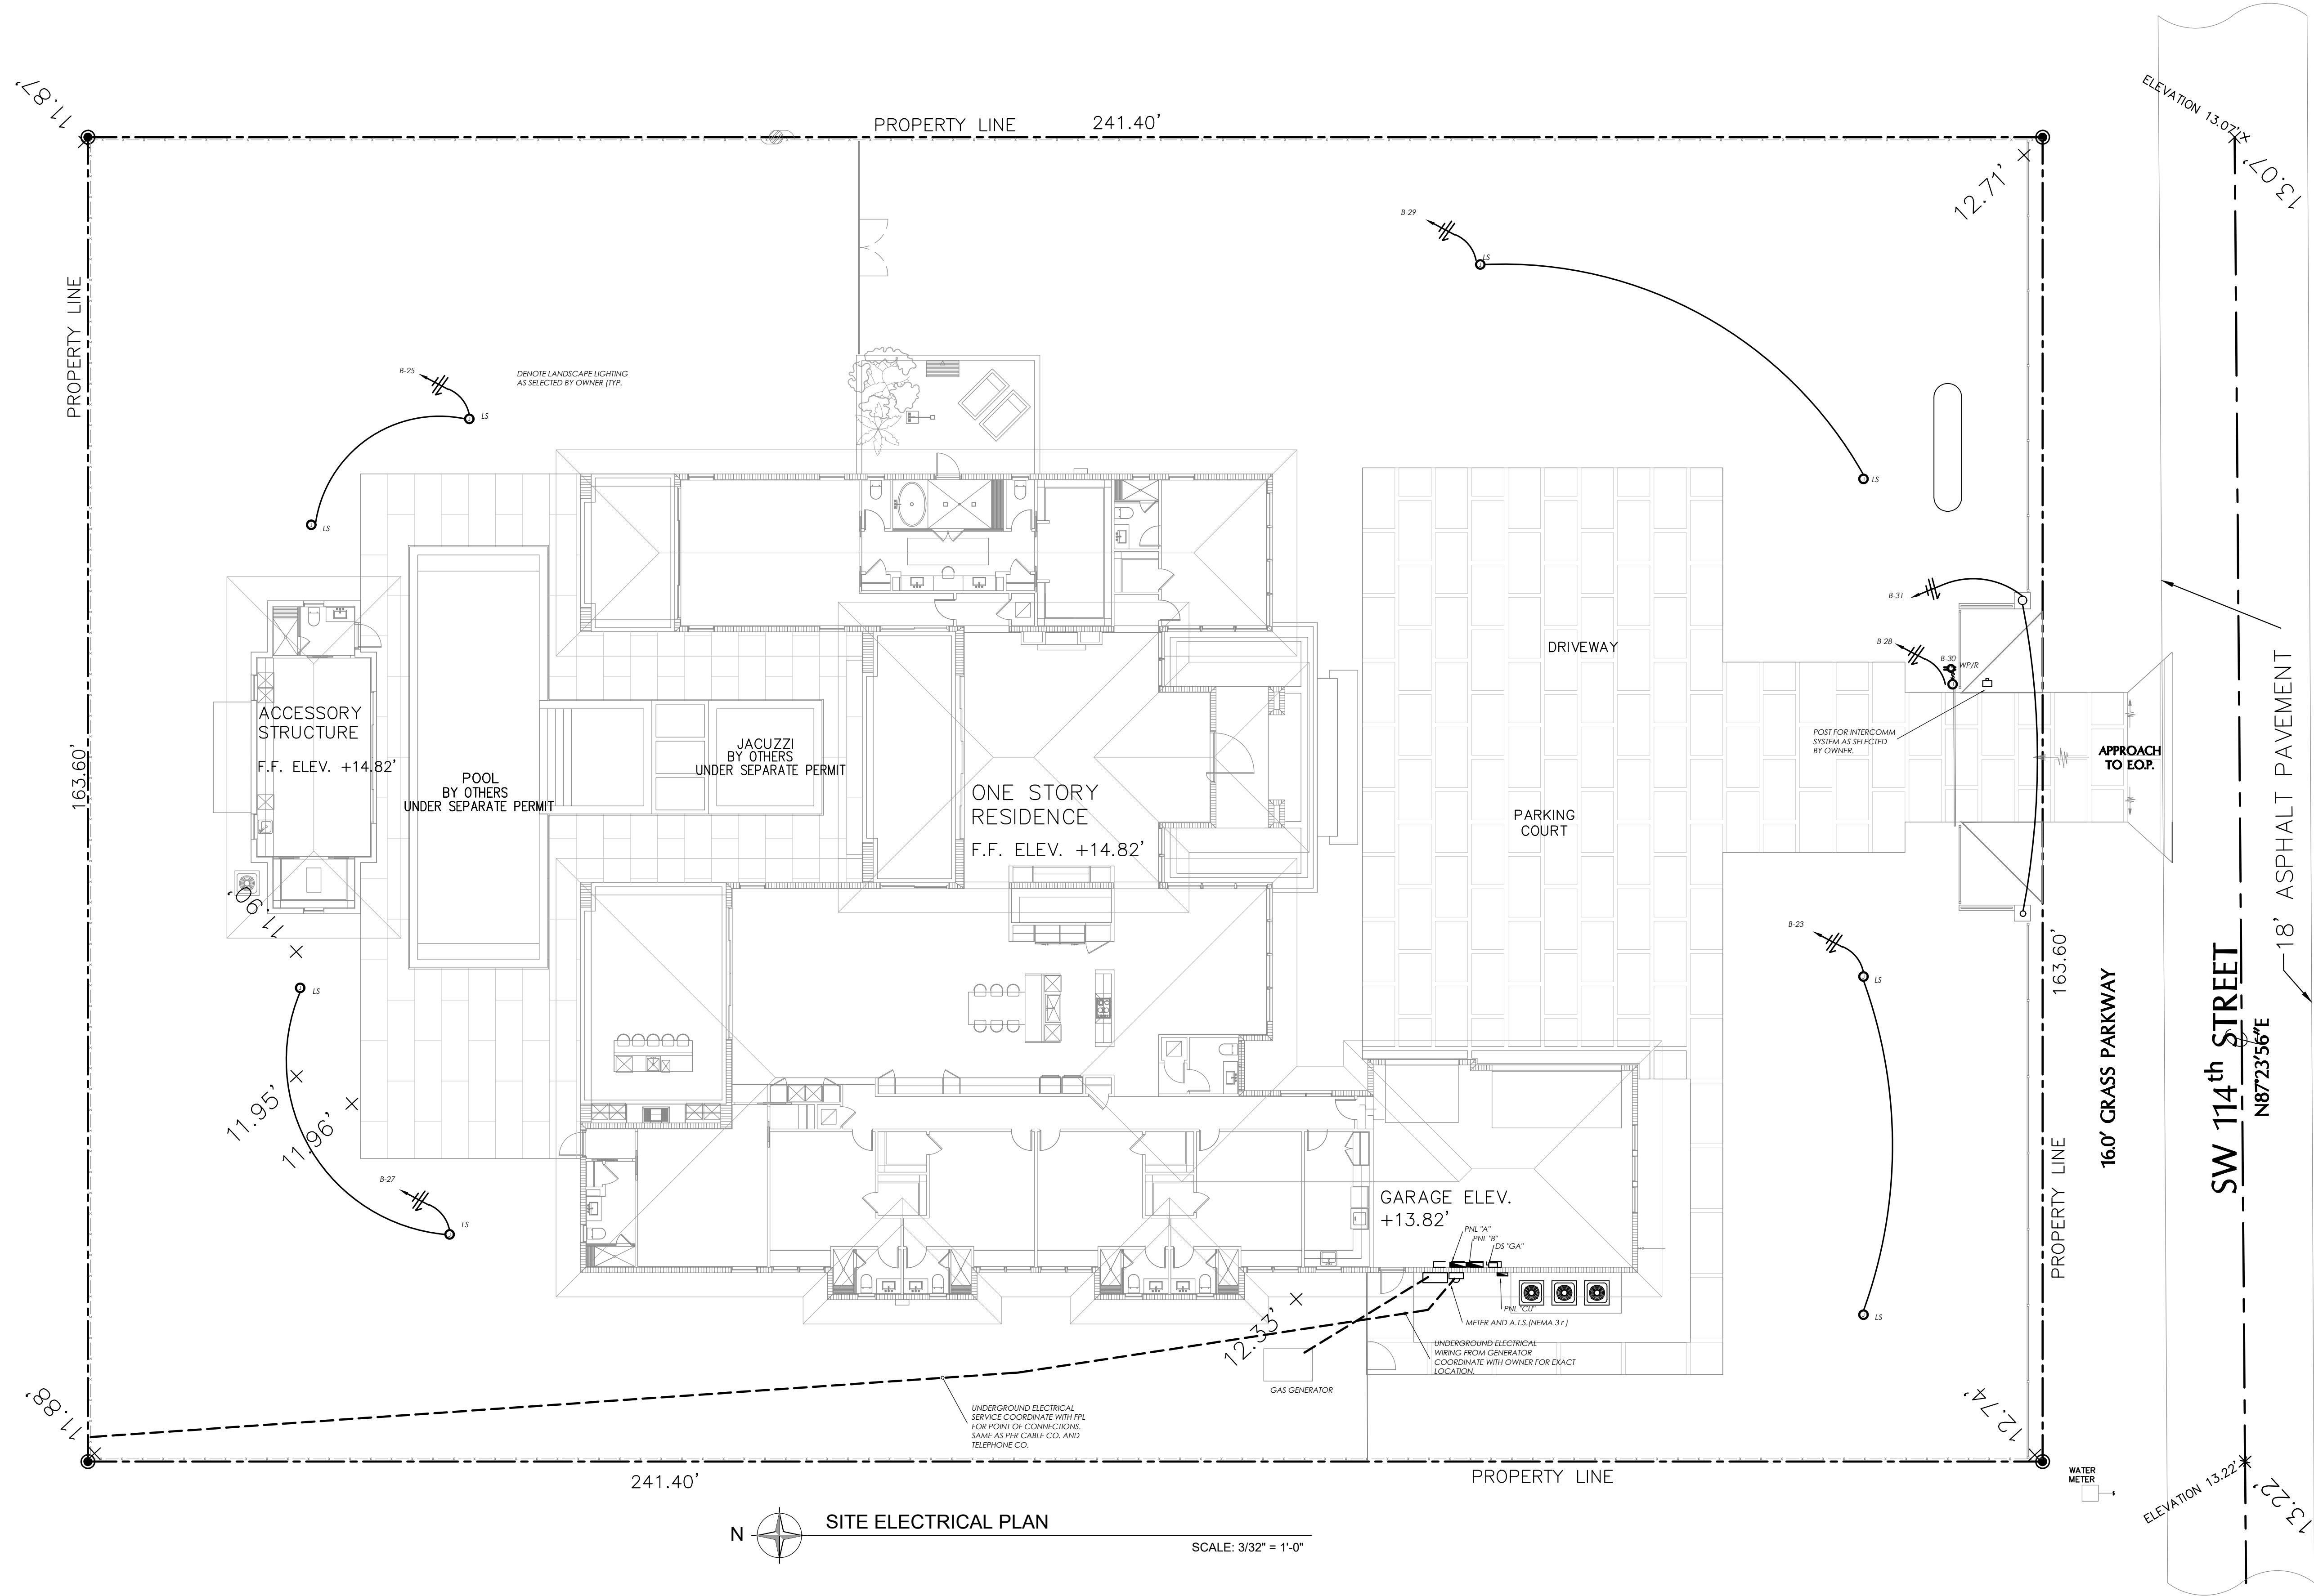

CMBeng
Consulting • Design
CMB eng llc • Miami, Florida 33185
14850 SW 26 St. #215 • Miami, Florida 33185
O. 786.375.5348 • CMB@CMBeng.com

L.C. No. 35097
Edmundo Largaespada, P.E.
Professional Engineer
P.E. No. 0058915

Project No.: 23_0012

THIS ITEM HAS BEEN DIGITALLY SIGNED AND SEALED
BY EDMUNDO LARGAESPADA, P.E. ON THE DATE ADJACENT
TO THE SEAL. PRINTED COPIES OF THIS DOCUMENT ARE
NOT CONSIDERED SIGNED AND SEALED AND THE SIGNATURE
MUST BE VERIFIED ON ANY ELECTRONIC COPIES.

**SITE
ELECTRICAL FLOOR PLAN**
DATE : 03/23/2023
SCALE : AS SHOWN
DRAWN :
CHECK BY:
JOB NO. : 23_0012

E-1

SHEET NO. :

NEW CONSTRUCTION AT PINECREST RESIDENCE:
BY HERITAGE HOME BUILDERS, LLC
7725 SOUTHWEST 114 STREET
VILLAGE OF PINECREST, FL 33156

SEAL:

OWNER:
HERITAGE HOME BUILDERS, LLC
9350 SOUTH DIXIE HIGHWAY
SUITE 1500
MIAMI, FL 33156
PHONE: 305.665.3077

REVISIONS:

COPYRIGHT © PASCUAL, PEREZ, KILIDDJIAN
& ASSOCIATES — ARCHITECTS — PLANNERS
The architectural design and detail drawings
of this building and/or overall project are the
legal property of, and all rights are reserved
by the Architect. Their use for reproduction,
construction or distribution is prohibited unless
authorized in writing by the Architect.

AT THE BEACON CENTER
1330 NW 84th AVENUE
DORAL, FLORIDA 33126
TELEPHONE: (305) 592-1343
FACSIMILE: (305) 592-4845
http://www.ppkarch.com

LICENSE # AA 26001357
EDGARDO PEREZ, AIA
LICENSE No.: AR 0015394
MARIO P. PASCUAL, AIA
LICENSE No.: AR 0008254
PETER KILIDDJIAN, RA
LICENSE No.: AR 0093067
ANDREW STARR, RA
LICENSE No.: AR 0095130

**PASCUAL
PEREZ
KILIDDJIAN
STARR**
ARCHITECTS + PLANNERS