


HEAT PUMP	
MANUFACTURER: MITSUBISHI	
UNIT TAG: MS- G.H. (CASSETTE)	
MODEL: INDOOR UNIT: SLZ-KF18NA OUTDOOR UNIT: SUZ-KA18NA2	
TYPE	CEILING MOUNTED
COOLING CAPACITY BTU/ H	17,700
HEATING CAPACITY BTU/	19,700
SUPPLY CFM	300-420-475
O.A.I CFM	SEE CALC.
SEER 2/HSPF 2	21.0/ 10.0
MAXIMUM FUSE	24.0 AMP
MCA	14.0 AMP
POWER SUPPLY: PHASE, CYCLE, VOLTAGE 1 / 60HZ / 208-230	
REF. PIPE:	DISCHARGE: 1/2" SUCTION: 1/4"
REF. PIPE:	LENGTH: 100 FT MAX HEIGHT: 50 FT MAX
DIMENSION: INDOOR WxDxH: 22-7/16" x 22-7/16" x 9-5/16" OUTDOOR WxDxH: 33½" x 13-1/4" x 34-5/8"	
REFRIGERANT:	R410A

FAN SPECS.



EF - 1 SHALL BE: CEILING MOUNTED MANUF.: BROAN MODEL: 688 50 CFM RATED AMP: 0.9 ELECTRICAL SERVICE: 115/1/60 4 SONES	EF - 2 SHALL BE: CEILING MOUNTED MANUF.: BROAN MODEL: LP50100DC 100 CFM RATED AMPS: 0.4 ELECTRICAL SERVICE: 115/1/60 1.2 SONES
--	--

EQUIVALENT MANUFACTURED:
GREENHECK, LOREN COOK, NUTONE ETC.

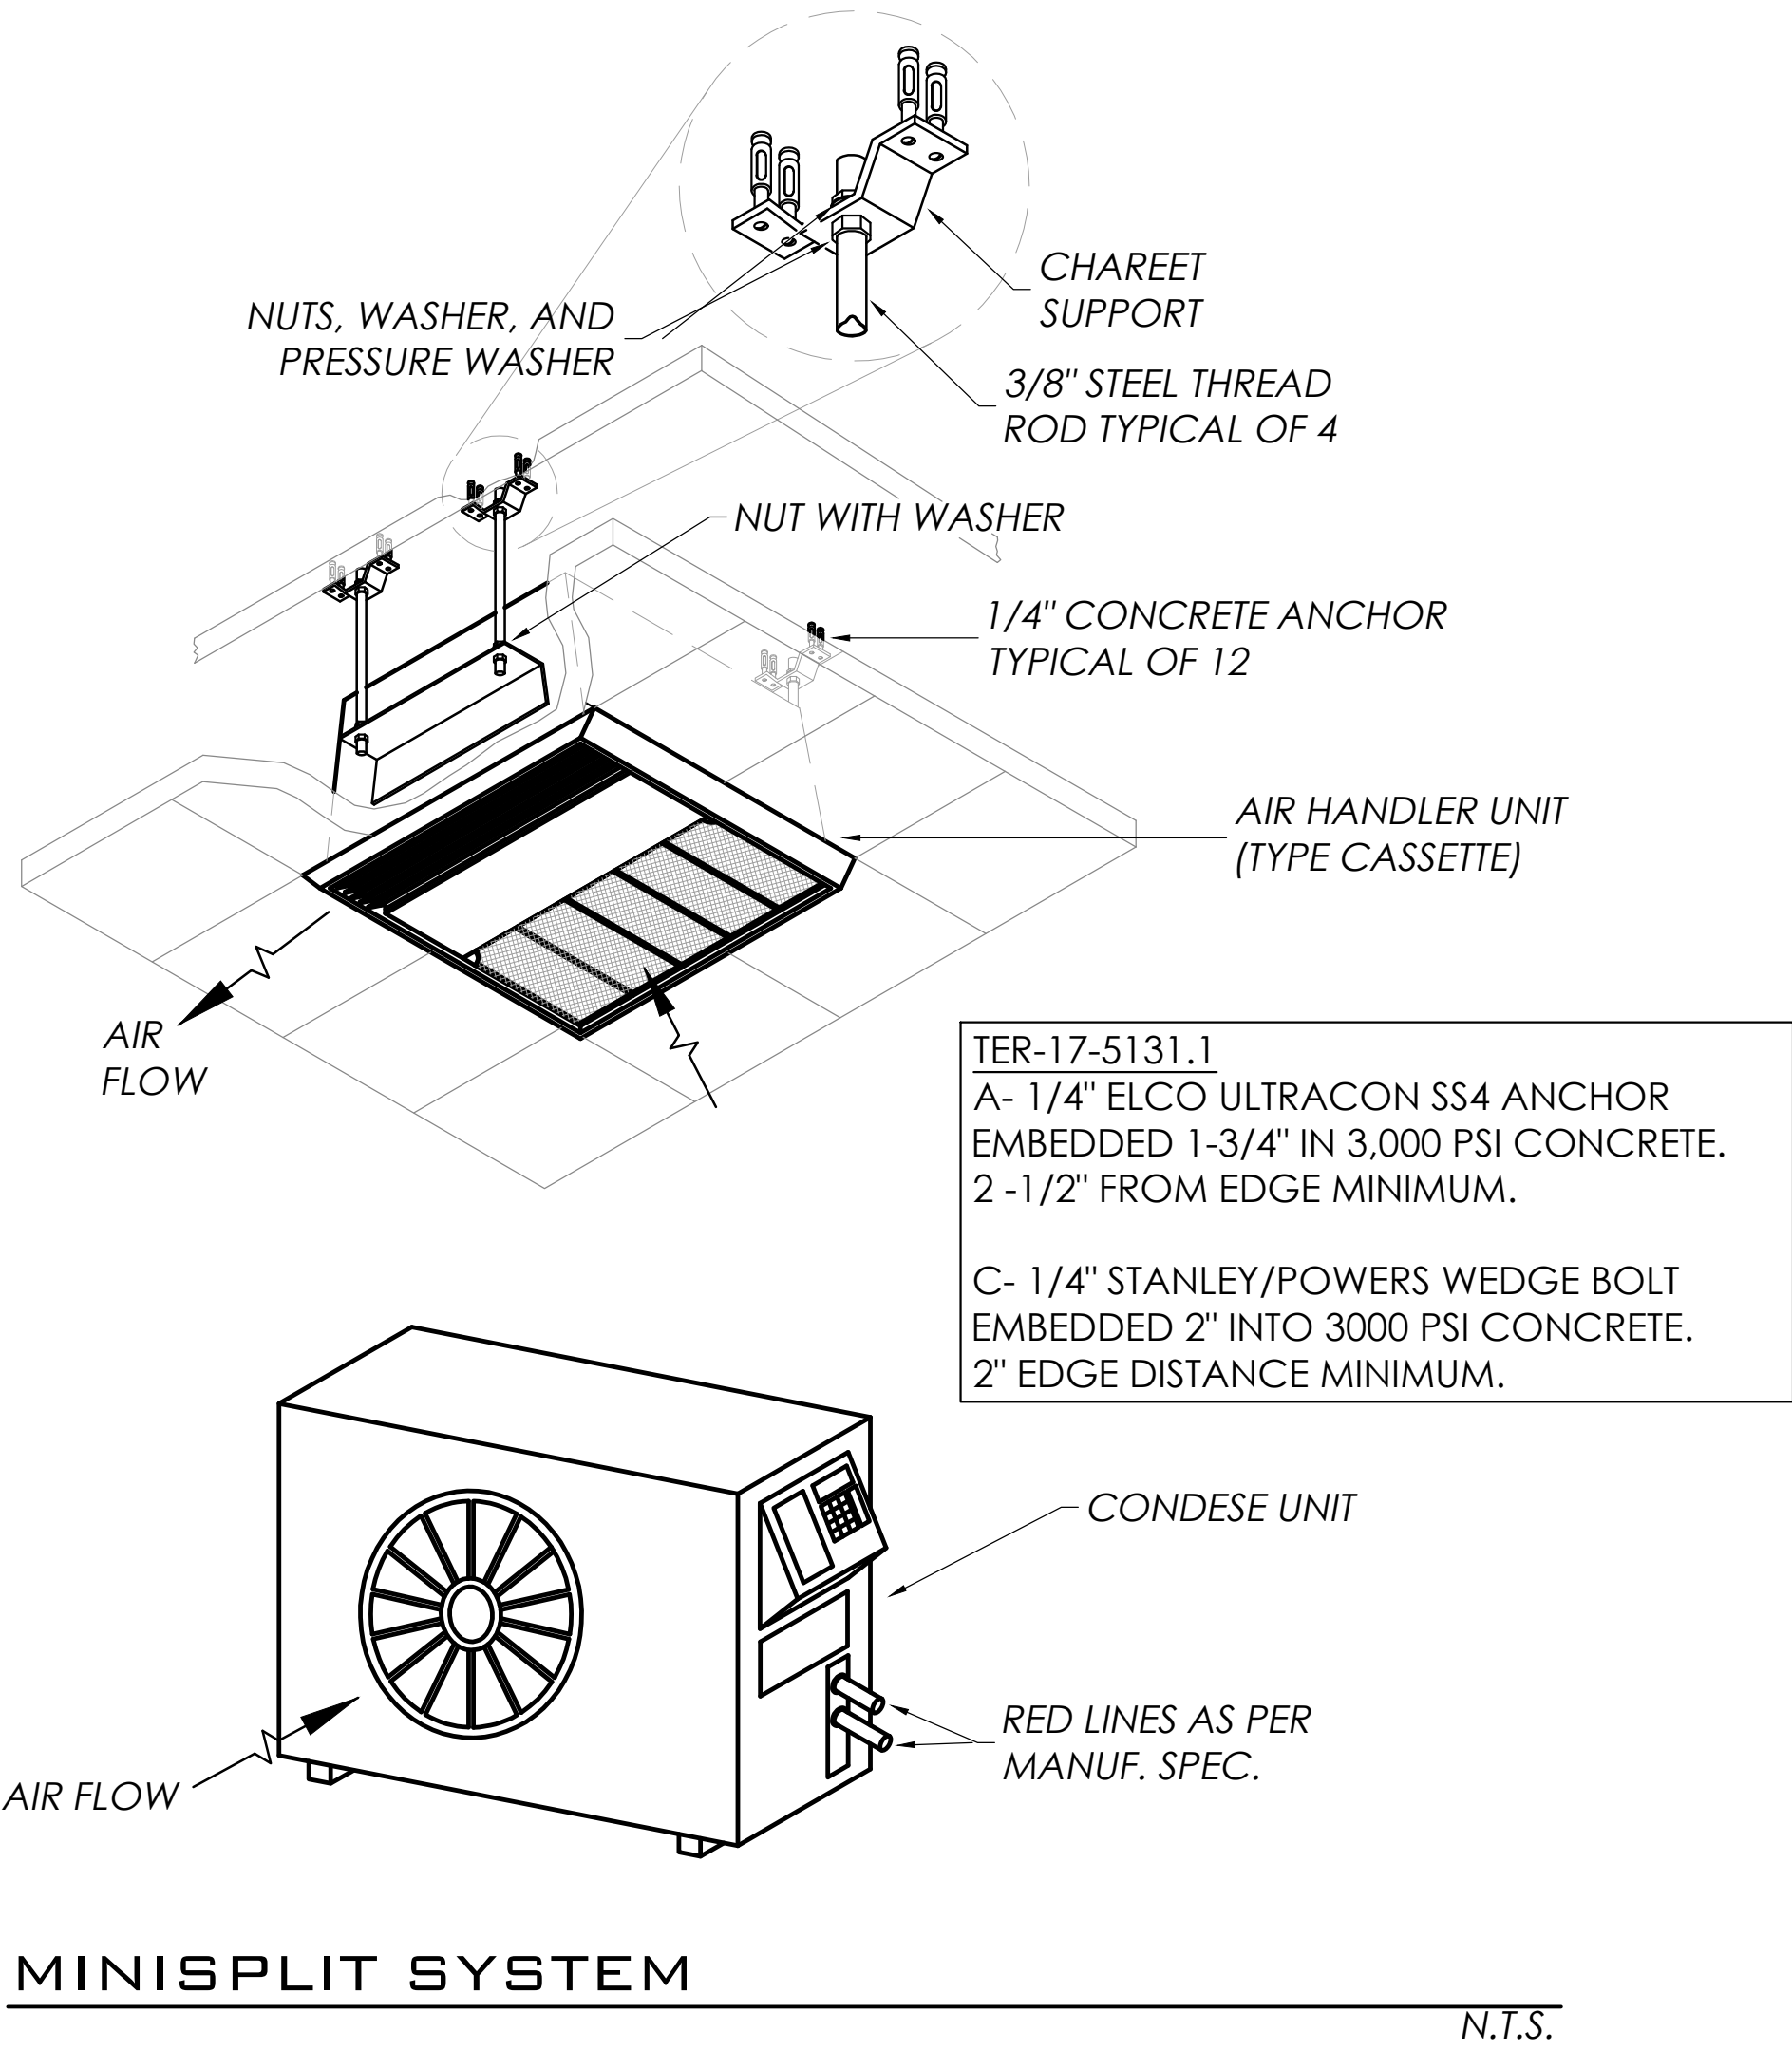


MINISPLIT SYSTEM

N.T.S.

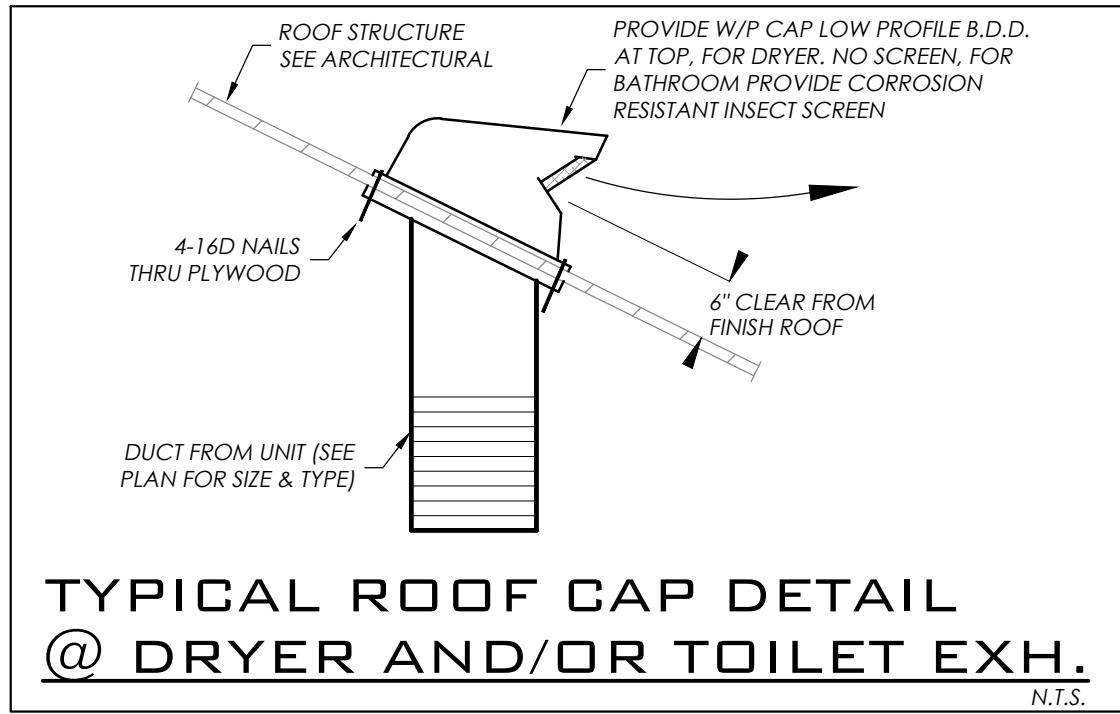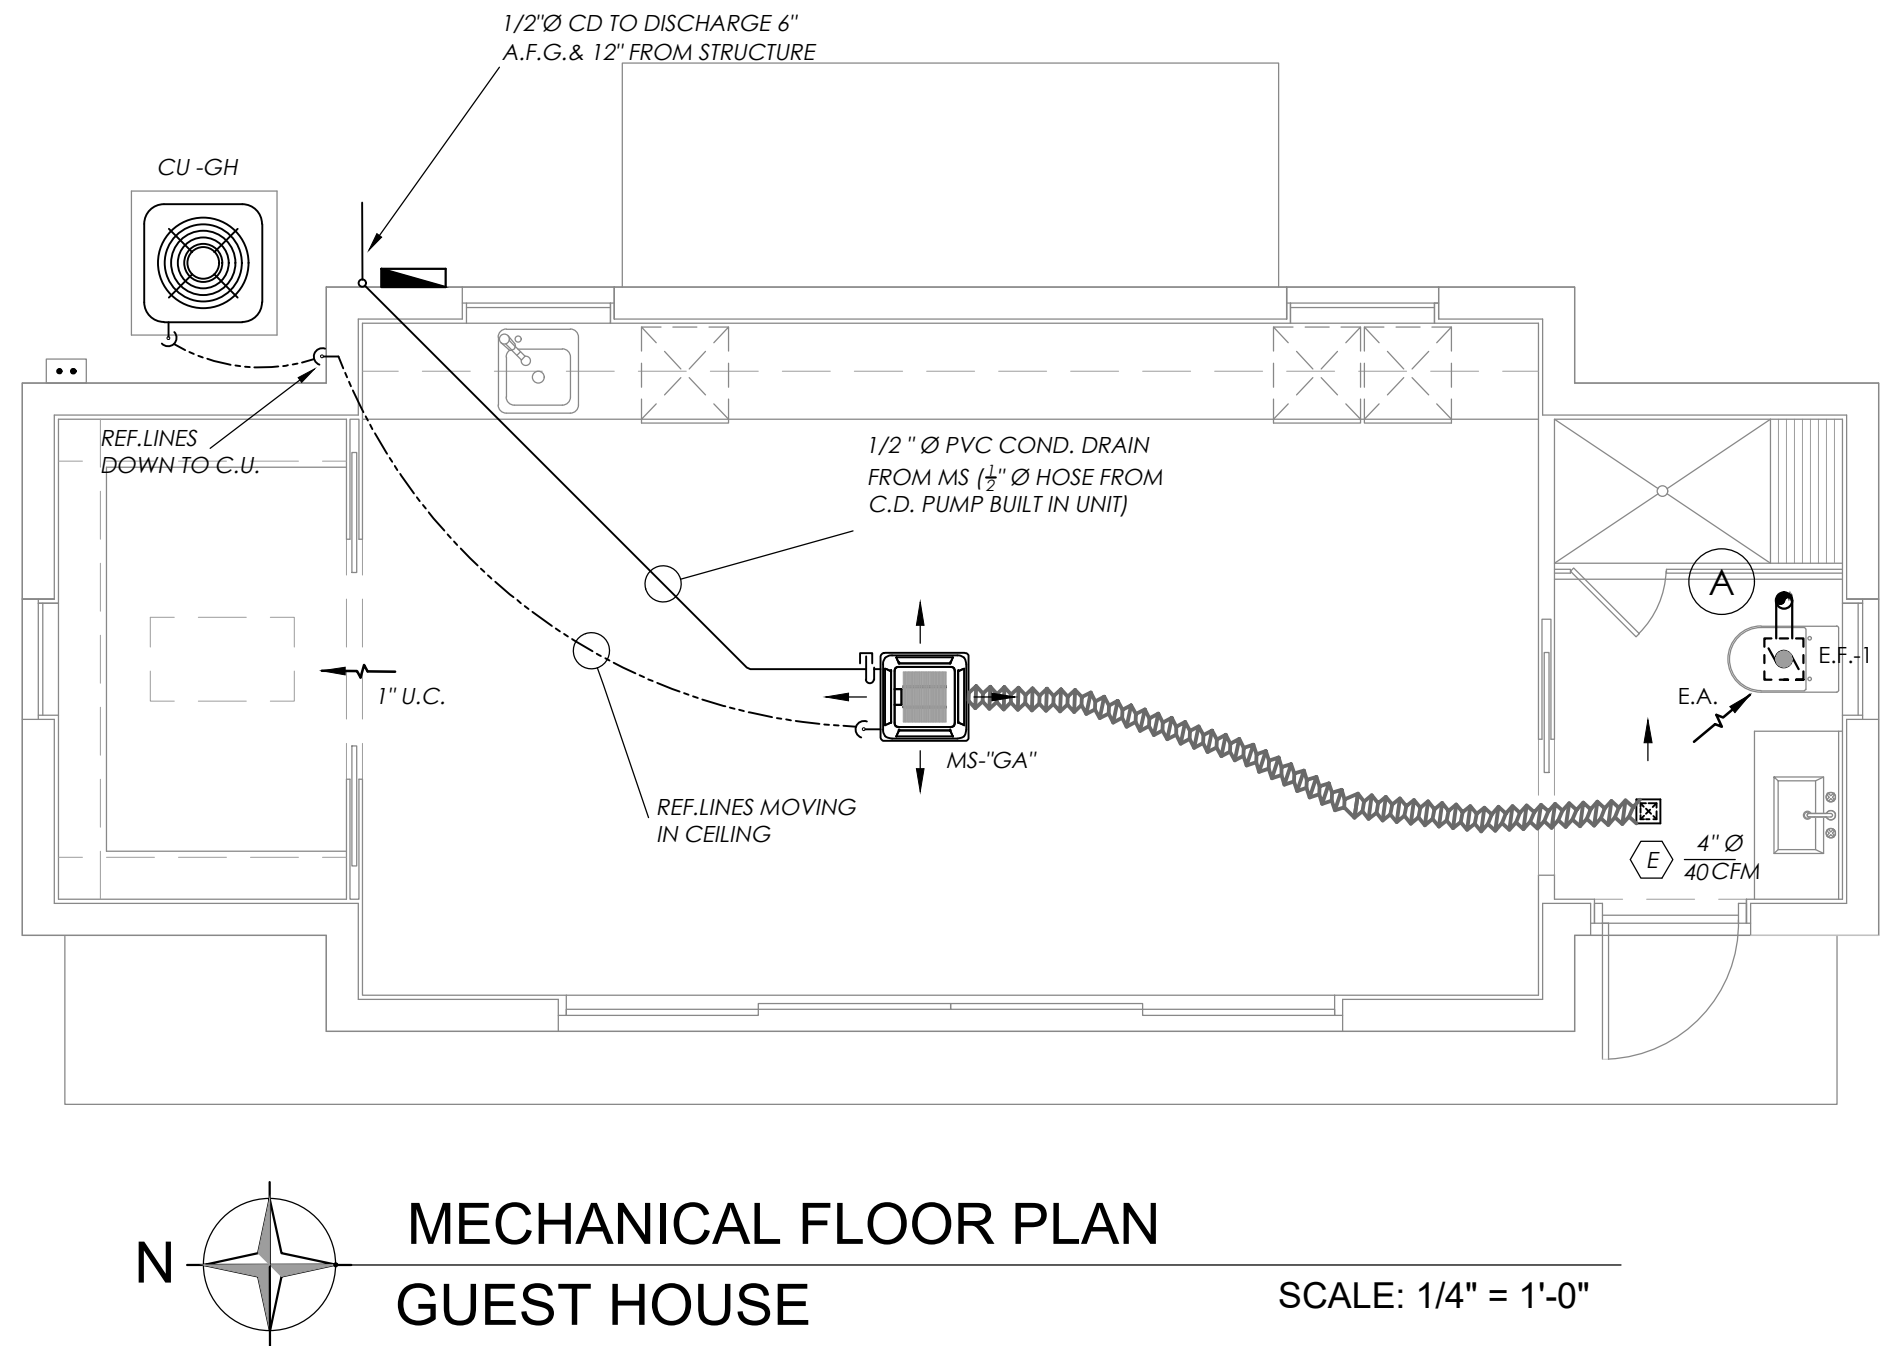


TYPICAL ROOF CAP DETAIL @ DRYER AND/OR TOILET EXH.

N.T.S.

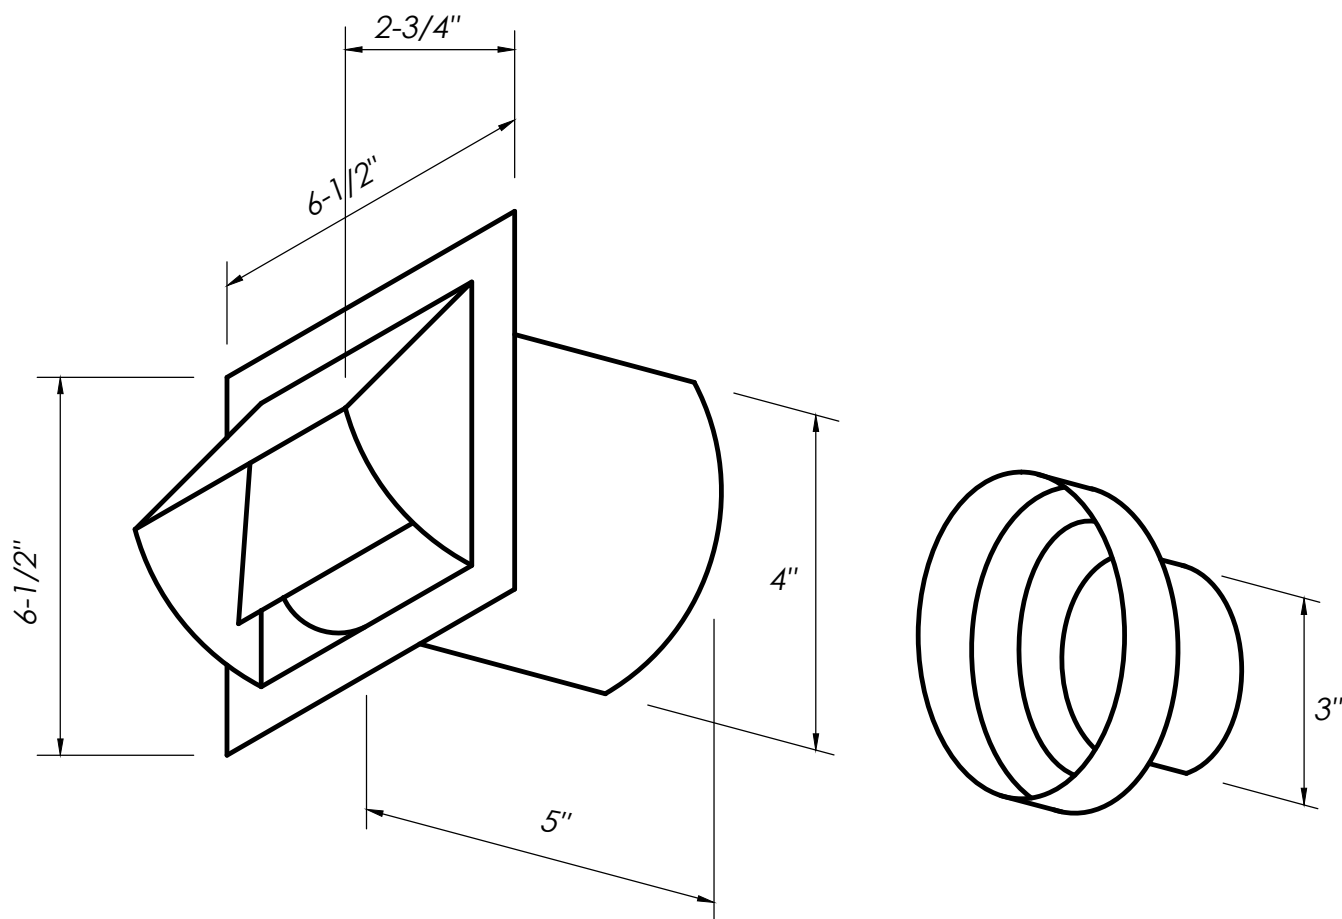

WALL CAP FOR DRYER AND BATHROOM EXHAUST

N.T.S.

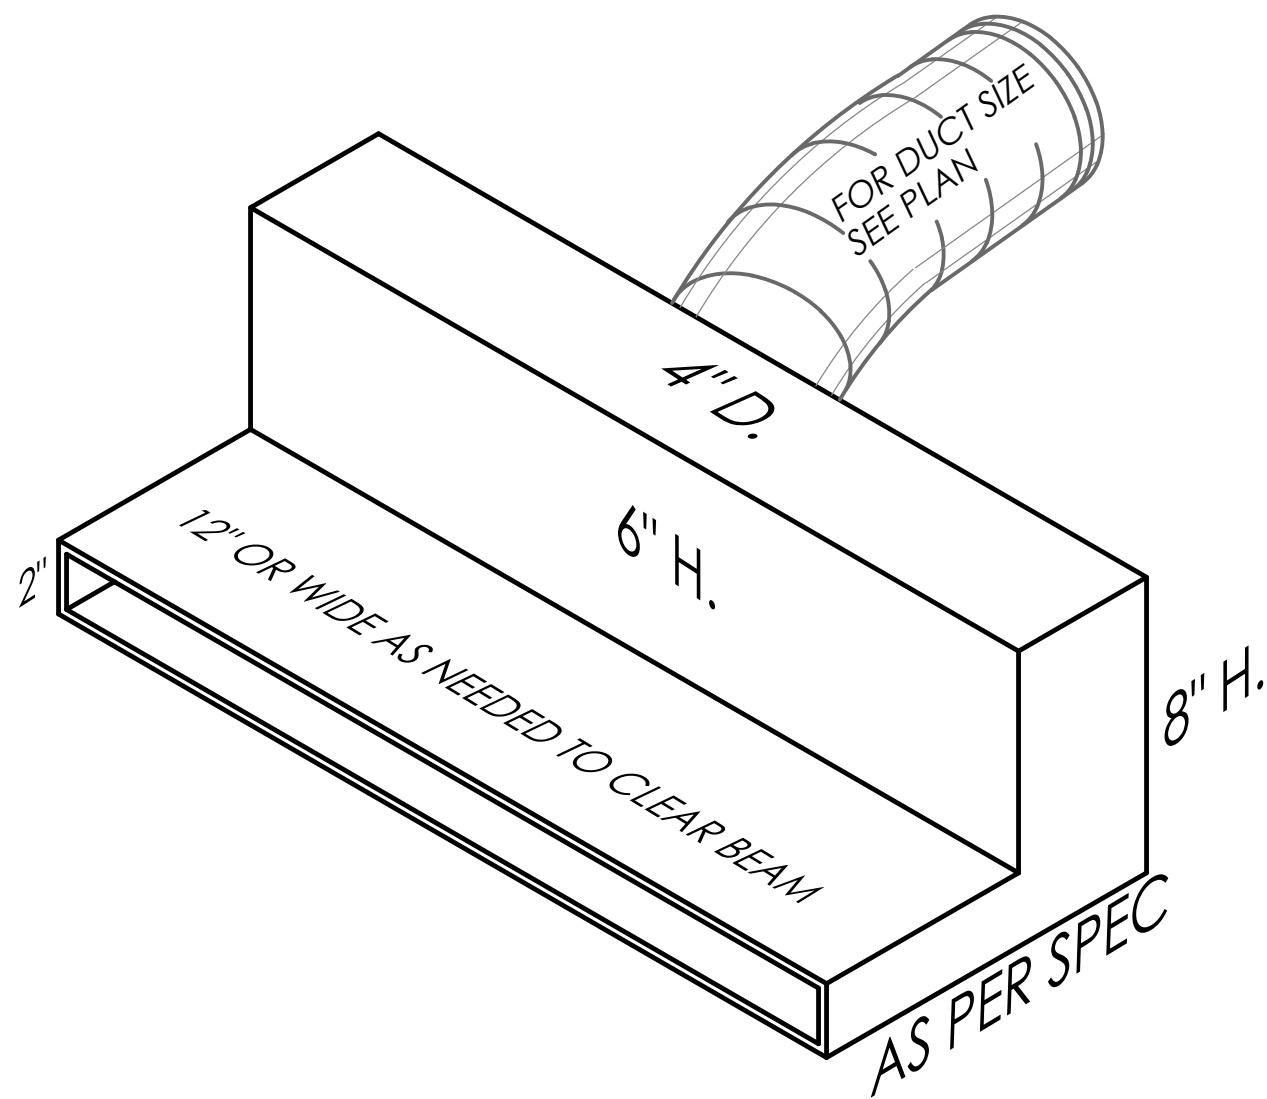

DISTRIBUTION BOX WITH BEAM ABOVE

N.T.S.

CMBeng

Consulting • Design
CMB eng llc
14850 SW 26 St. #215 Miami, Florida 33185
O. 786.375.5348 • CMB@CMBeng.com

L.C. No. 35097
www.CMBeng.com

Edmundo Largaespada, P.E.
Professional Engineer
P.E. No. 0058915

Project No.: 23_0012

THIS ITEM HAS BEEN DIGITALLY SIGNED AND SEALED BY EDMUNDO LARGAESPADA, P.E. ON THE DATE ADJACENT TO THE SEAL. PRINTED COPIES OF THIS DOCUMENT ARE NOT CONSIDERED SIGNED AND SEALED AND THE SIGNATURE MUST BE VERIFIED ON ANY ELECTRONIC COPIES.

NEW CONSTRUCTION AT PINECREST RESIDENCE:
BY HERITAGE HOME BUILDERS, LLC
7725 SOUTHWEST 114 STREET
VILLAGE OF PINECREST, FL 33156

SEAL:

GUEST HOUSE
MECHANICAL FLOOR PLAN

DATE: 03/23/2023

SCALE: AS SHOWN

DRAWN:

CHECK BY:

JOB NO.: 23_0012

SHEET NO.:

M-2

PASCUAL
PEREZ
KILIDDJIAN
STARR

ARCHITECTS • PLANNERS

LICENSE # AA 26001357
EDGARD PEREZ, AIA
LICENSE No.: AR 0015394
MARIO P. PASCUAL, AIA
LICENSE No.: AR 0008254
PETER KILIDDJIAN, RA
LICENSE No.: AR 0093067
ANDREW STARR, RA
LICENSE No.: AR 0095130

AT THE BEACON CENTER
1330 NW 84th AVENUE
DORAL, FLORIDA 33126
TELEPHONE: (305) 592-1343
FACSIMILE: (305) 592-6865
http://www.ppkarch.com

COPYRIGHT © PASCUAL, PEREZ, KILIDDJIAN
& STARR, ARCHITECTS - PLANNERS
The architectural design and detail drawings
of this building and/or overall project are the
legal property of, and all rights are reserved
by the Architect. Their use for reproduction,
construction or distribution is prohibited unless
authorized in writing by the Architect.

REVISIONS:

OWNER:
HERITAGE HOME BUILDERS, LLC
9350 SOUTH DIXIE HIGHWAY
SUITE 1500
MIAMI, FL 33156
PHONE: 305.665.3077