


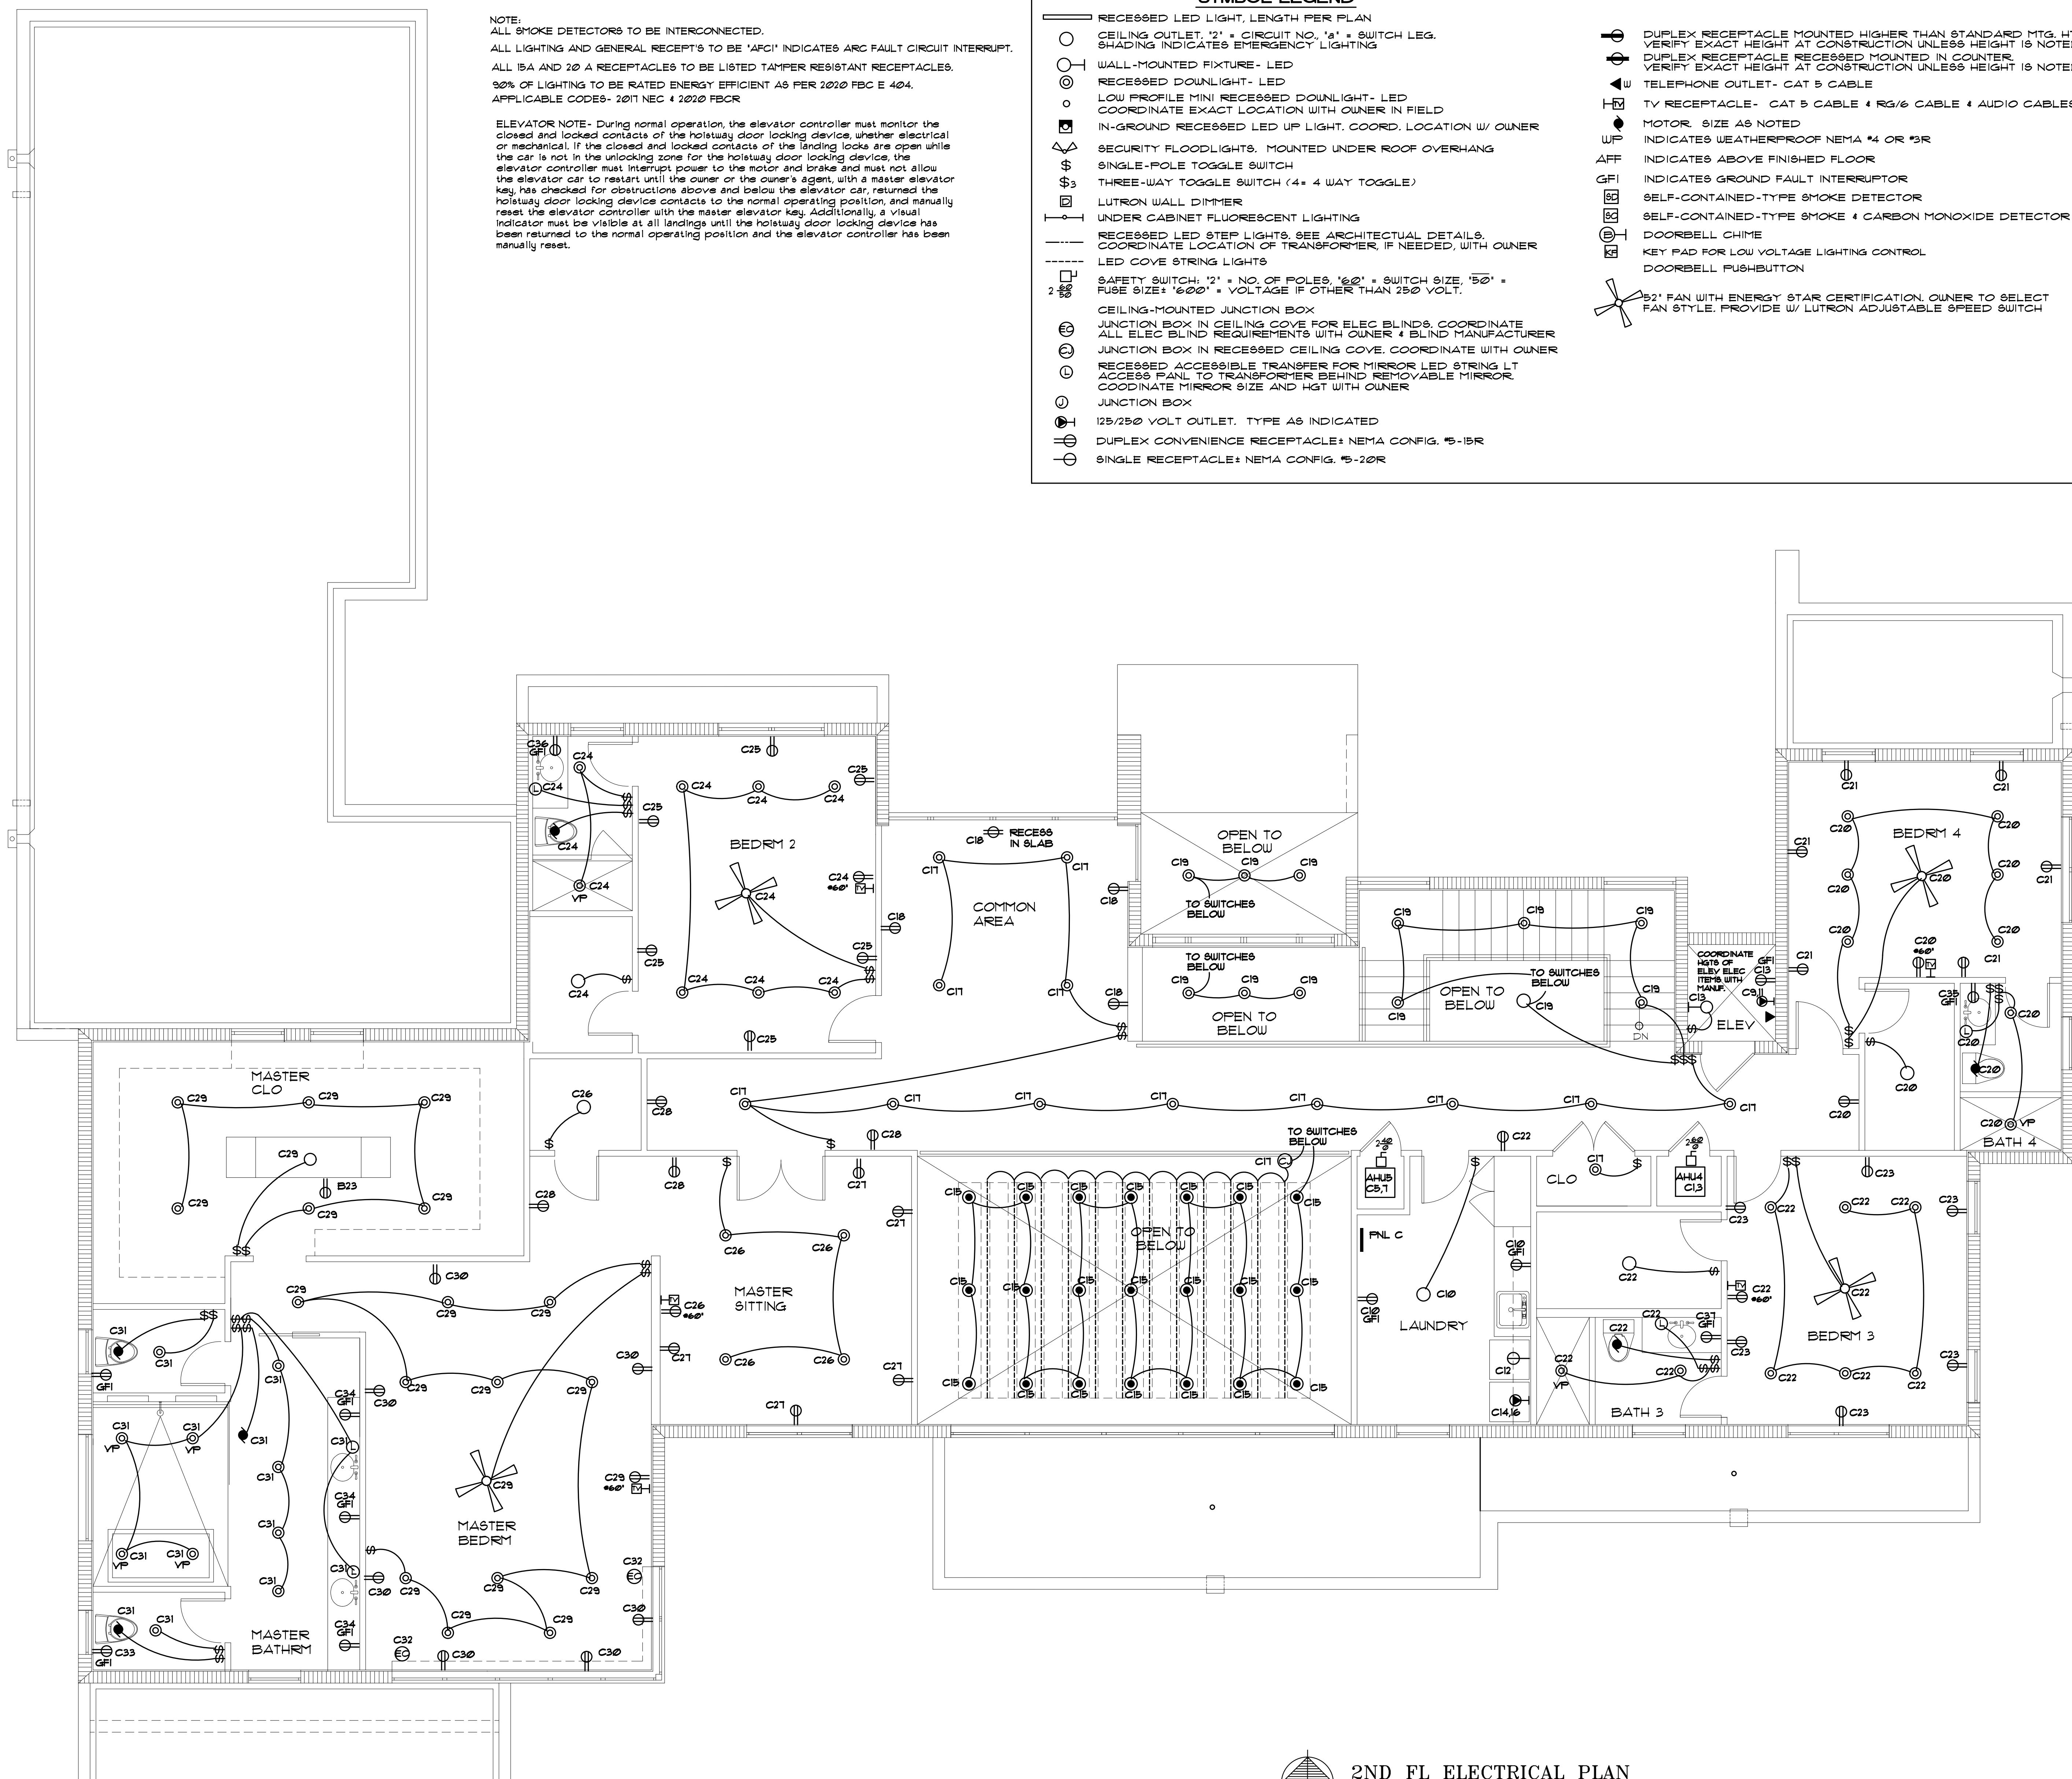


2ND FL ELECTRICAL PLAN  
SCALE: 1/4" = 1'-0"

REVISION BY


MARK REARDON, RA  
architect  
LIC# AS-000521  
mark@reardonarchitect.com  
phone: 786-355-6910

15790 SW 88TH AVE  
MIAMI, FL 33157  
AR 0017521  
786-355-6910

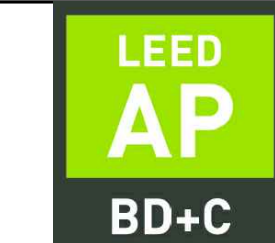

NOTE: ALL DRAWINGS FOR THIS PROJECT ARE TO BE READ IN CONJUNCTION WITH EACH OTHER. THESE INCLUDE, BUT ARE NOT LIMITED TO: ARCHITECTURAL, SURVEYING, STRUCTURAL, CIVIL, MECHANICAL, ELECTRICAL, SPECIALTY DRAWINGS, & WRITTEN SPECIFICATIONS

THE G.C. IS TO VERIFY ALL EXISTING SITE CONDITIONS AND THOROUGHLY CHECK ELEVATIONS & DIMENSIONS BEFORE COMMENCING WORK. REPORT TO THE ARCHITECT OR ENGINEER ANY DISCREPANCIES, ERRORS OR CONDITIONS THAT WILL ALTER CONSTRUCTION AS INTENDED BY THESE DRAWINGS. ARCHITECT IS NOT RESPONSIBLE FOR ANY WORK AND/OR MATERIALS FURNISHED ON THE JOB.

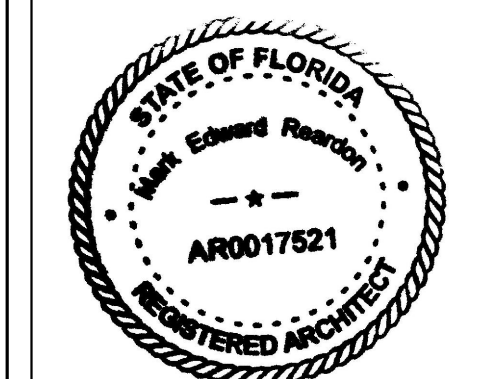

NEW HOUSE FOR:  
5900 LLC  
5900 SW 114 TER  
PINECREST, FL

DRAWN BY:  
MER  
DATE:  
5/15/23  
SCALE:  
AS NOTED  
SHEET NO.:

E-2