


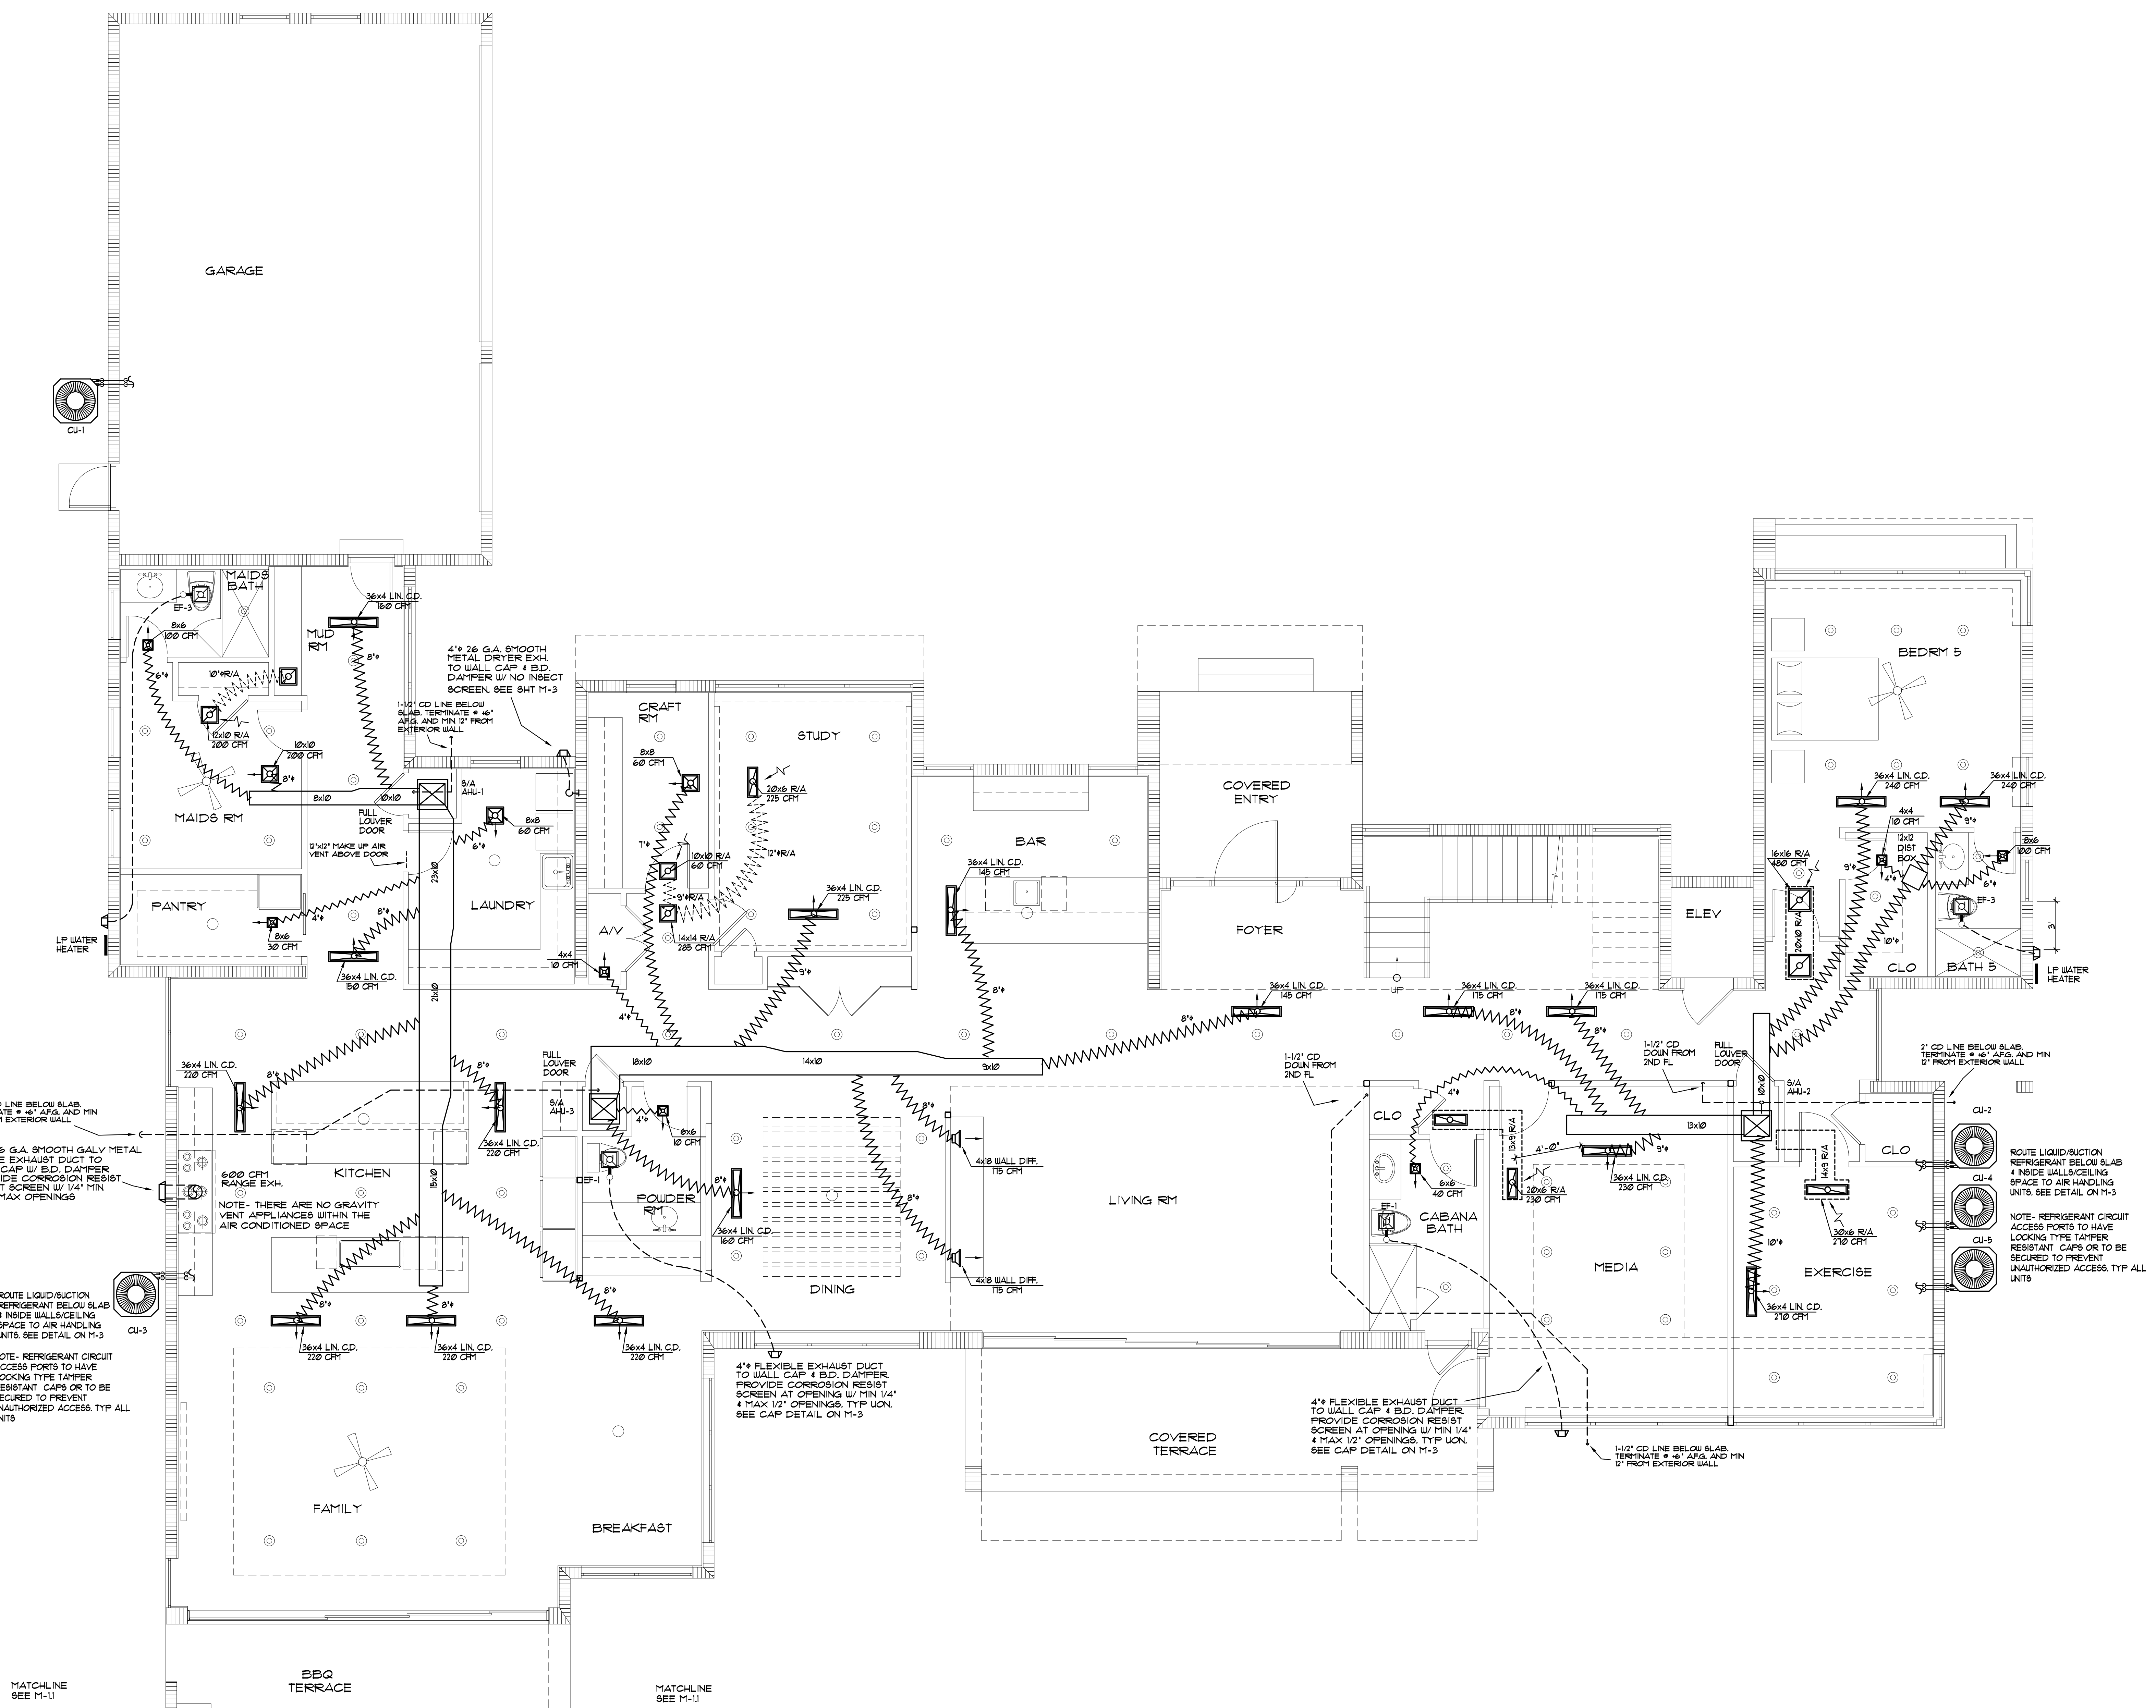

1ST FL MECHANICAL PLAN
SCALE: 1/4" = 1'-0"