
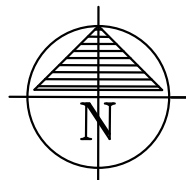


SYMBOL LEGEND	
	RECESSED LED LIGHT, LENGTH PER PLAN
	CEILING OUTLET, '2' = CIRCUIT NO., 'a' = SWITCH LEG, SHADING INDICATES EMERGENCY LIGHTING
	WALL-MOUNTED FIXTURE- LED
	RECESSED DOWNLIGHT- LED
	LOW PROFILE MINI RECESSED DOWNLIGHT- LED
	COORDINATE EXACT LOCATION WITH OWNER IN FIELD
	IN-GROUND RECESSED LED UP LIGHT, COORD. LOCATION W/ OWNER
	SECURITY FLOODLIGHTS, MOUNTED UNDER ROOF OVERHANG
	SINGLE-POLE TOGGLE SWITCH
	THREE-WAY TOGGLE SWITCH (4+ 4 WAY TOGGLE)
	LUTRON WALL DIMMER
	UNDER CABINET FLUORESCENT LIGHTING
	RECESSED LED STEP LIGHTS, SEE ARCHITECTUAL DETAILS, COORDINATE LOCATION OF TRANSFORMER, IF NEEDED, WITH OWNER
	LED COVE STRING LIGHTS
	SAFETY SWITCH, '2' = NO. OF POLES, '60' = SWITCH SIZE, '50' = FUSE SIZE, '600' = VOLTAGE IF OTHER THAN 250 VOLT.
	CEILING-MOUNTED JUNCTION BOX
	JUNCTION BOX IN CEILING COVE FOR ELEG BLINDS, COORDINATE ALL ELEG BLIND REQUIREMENTS WITH OWNER & BLIND MANUFACTURER
	JUNCTION BOX IN RECESSED CEILING COVE, COORDINATE WITH OWNER
	RECESSED ACCESSIBLE TRANSFER FOR MIRROR LED STRING LT
	ACCESS FAN LT TO TRANSFORMER BEHIND REMOVABLE MIRROR, COORDINATE MIRROR SIZE AND HGT WITH OWNER
	JUNCTION BOX
	125/250 VOLT OUTLET, TYPE AS INDICATED
	DUPLEX CONVENIENCE RECEPTACLE, NEMA CONFIG. #5-15R
	SINGLE RECEPTACLE, NEMA CONFIG. #5-20R
	DUPLEX RECEPTACLE MOUNTED HIGHER THAN STANDARD MTG. HT., VERIFY EXACT HEIGHT AT CONSTRUCTION UNLESS HEIGHT IS NOTED.
	DUPLEX RECEPTACLE RECESSED MOUNTED IN COUNTER, VERIFY EXACT HEIGHT AT CONSTRUCTION UNLESS HEIGHT IS NOTED.
	TELEPHONE OUTLET- CAT 5 CABLE
	TV RECEPTACLE- CAT 5 CABLE & RG/6 CABLE & AUDIO CABLES
	MOTOR, SIZE AS NOTED
	INDICATES WEATHERPROOF NEMA #4 OR #3R
	INDICATES ABOVE FINISHED FLOOR
	INDICATES GROUND FAULT INTERRUPTOR
	SELF-CONTAINED-TYPE SMOKE DETECTOR
	SELF-CONTAINED-TYPE SMOKE & CARBON MONOXIDE DETECTOR
	DOORBELL CHIME
	KEY PAD FOR LOW VOLTAGE LIGHTING CONTROL
	DOORBELL PUSHBUTTON
	32' FAN WITH ENERGY STAR CERTIFICATION, OWNER TO SELECT FAN STYLE, PROVIDE W/ LUTRON ADJUSTABLE SPEED SWITCH

NOTE:
ALL SMOKE DETECTORS TO BE INTERCONNECTED.
ALL LIGHTING AND GENERAL RECEPT'S TO BE 'AFCI' INDICATES ARC FAULT CIRCUIT INTERRUPT.
ALL 15A AND 20 A RECEPTABLES TO BE LISTED TAMPER RESISTANT RECEPTABLES.
90% OF LIGHTING TO BE RATED ENERGY EFFICIENT AS PER 2010 FBC E 404.
APPLICABLE CODES- 2011 NEC & 2010 FBCR

ELEVATOR NOTE- During normal operation, the elevator controller must monitor the closed and locked contacts of the hoistway door locking device, whether electrical or mechanical. If the closed and locked contacts of the landing locks are open while the car is not in the unlocking zone for the hoistway door locking device, the elevator controller must interrupt power to the motor and brake and must not allow the elevator car to restart until the owner or the owner's agent, with a master elevator key, has checked for obstructions above and below the elevator car, returned the hoistway door locking device contacts to the normal operating position, and manually reset the elevator controller with the master elevator key. Additionally, a visual indicator must be visible at all landings until the hoistway door locking device has been returned to the normal operating position and the elevator controller has been manually reset.

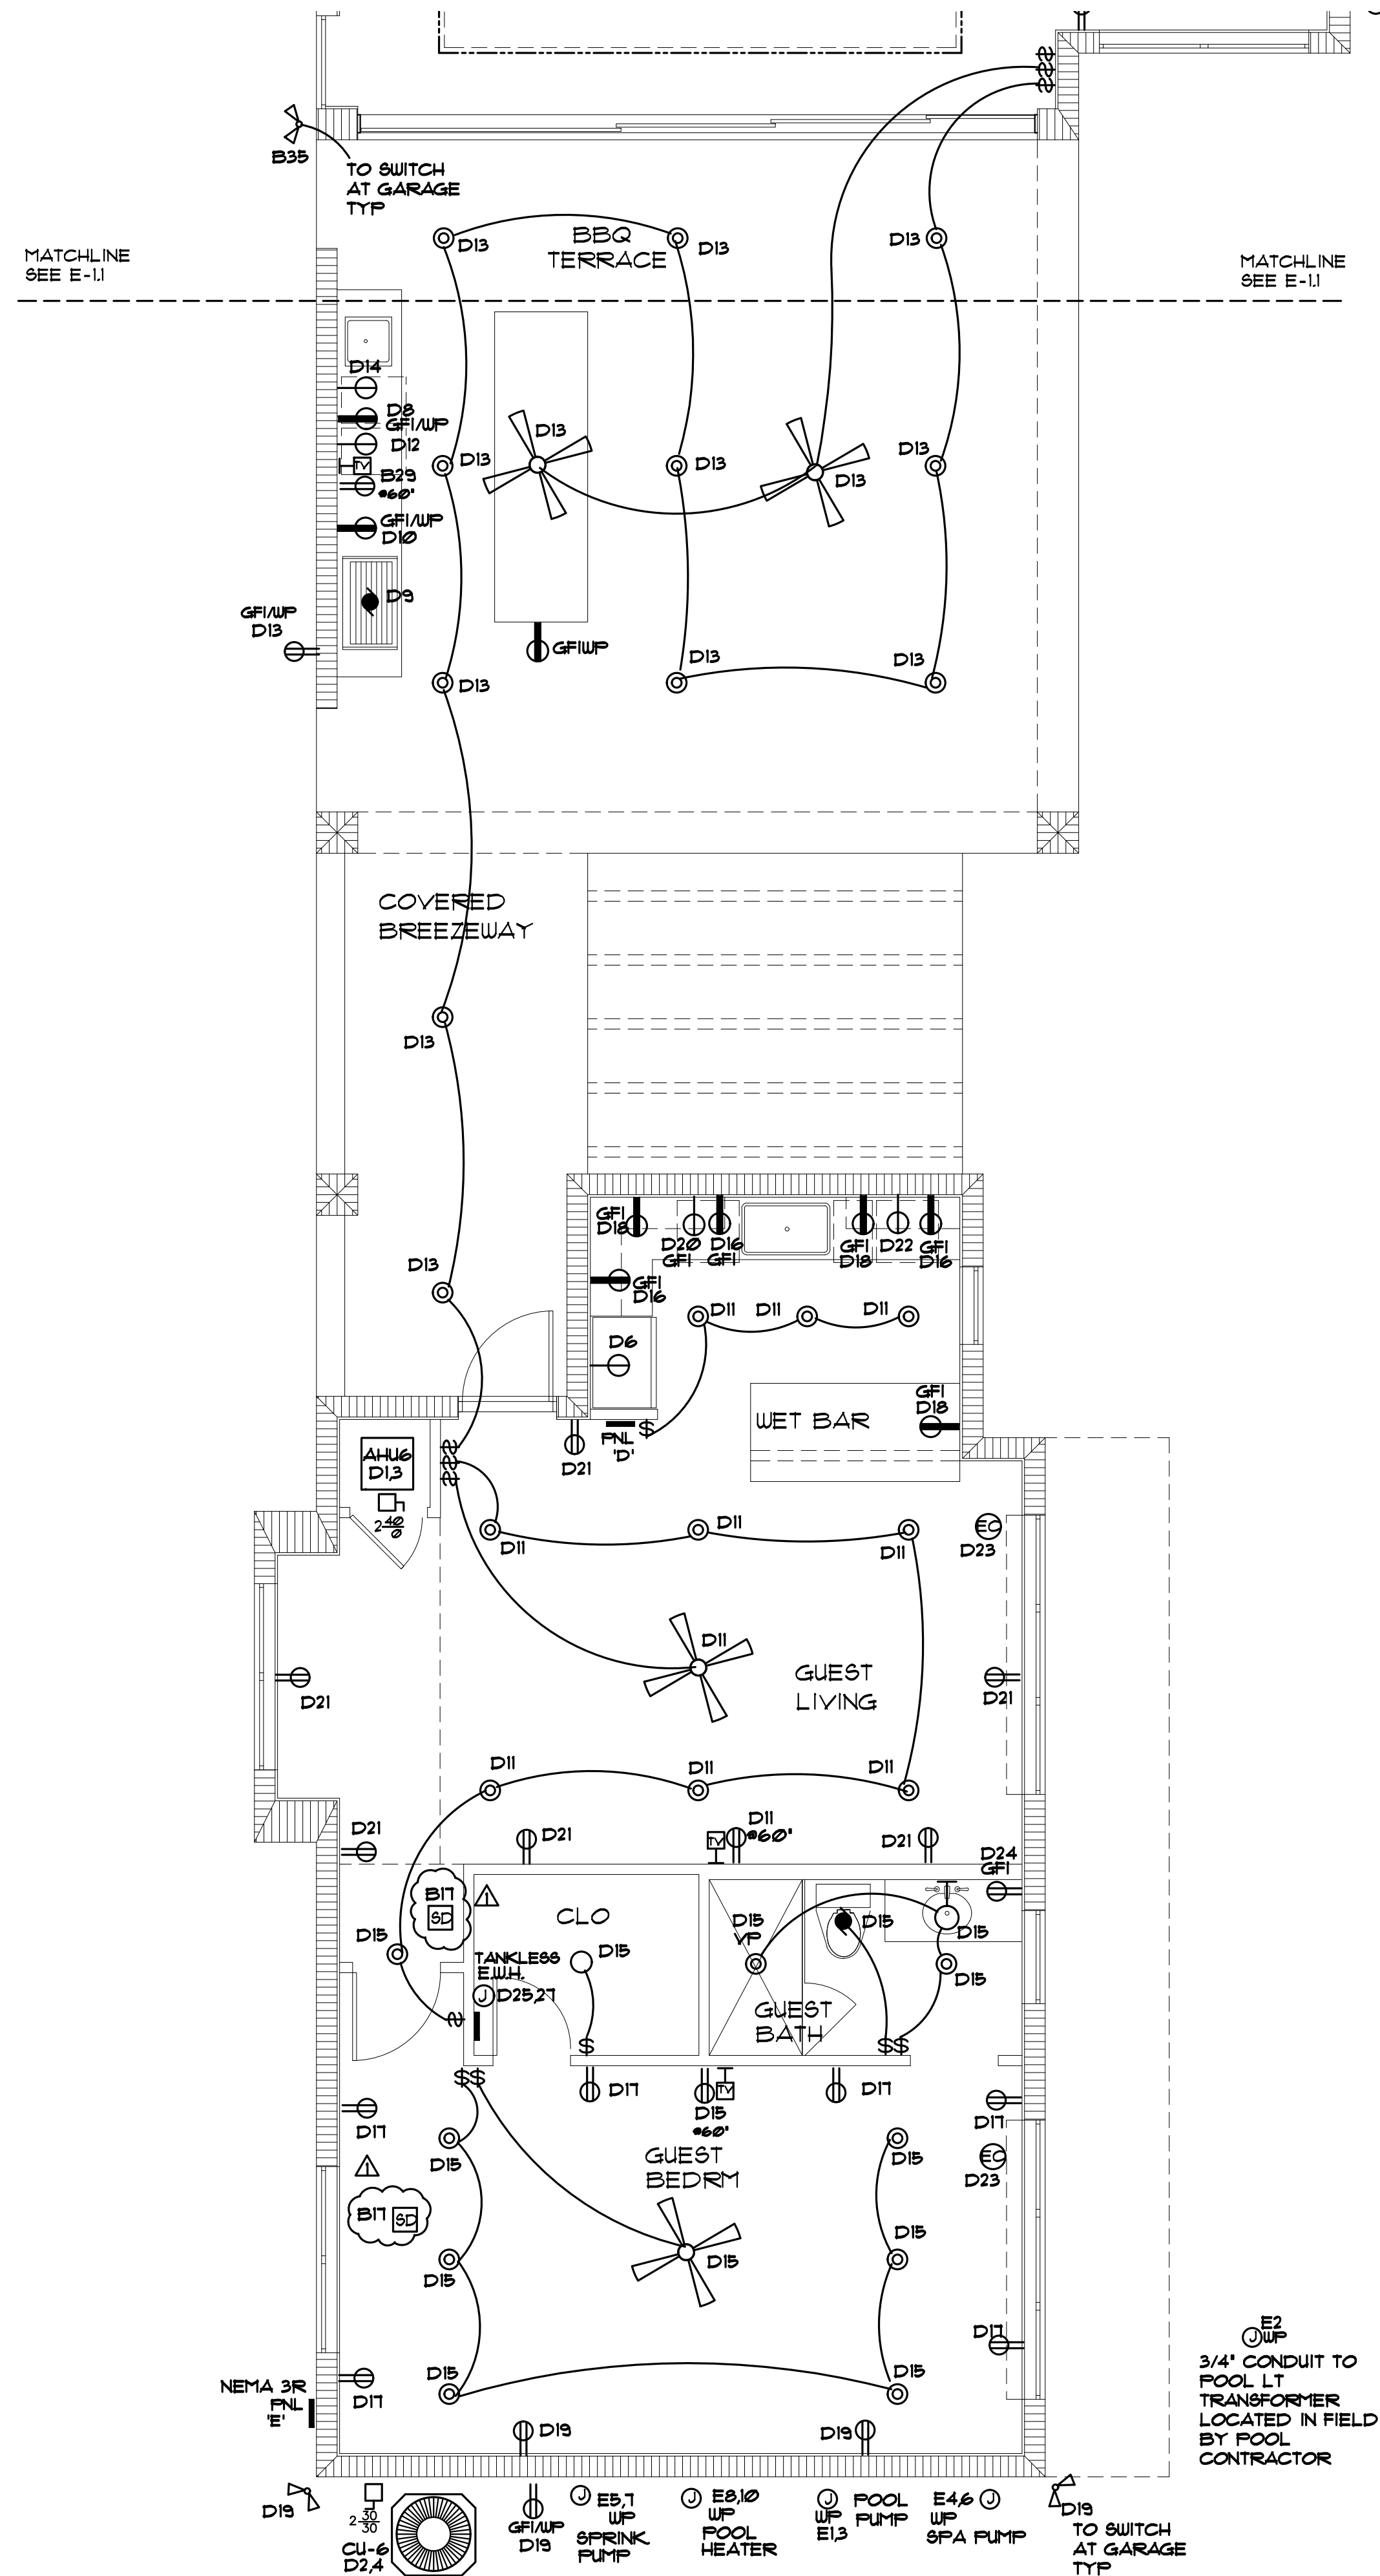

1ST FL ELECTRICAL PLAN
SCALE: 1/4" = 1'-0"

REVISION BY

1- 9/19/23 bld dept comm

MARK REARDON architect

mark@reardonarchitect.com

phone: 786-355-6910

15790 SW 88TH AVE

MIAMI, FL 33157

AR 0017521

786-355-6910

LEED AP

BD+C

NOTE: ALL DRAWINGS FOR THIS PROJECT ARE TO BE READ IN CONJUNCTION WITH EACH OTHER. THESE INCLUDE, BUT ARE NOT LIMITED TO: ARCHITECTURAL, SURVEYING, STRUCTURAL, CIVIL, MECHANICAL, ELECTRICAL, SPECIALTY DRAWINGS, & WRITTEN SPECIFICATIONS

THE G.C. IS TO VERIFY ALL EXISTING SITE CONDITIONS AND THOROUGHLY CHECK ELEVATIONS & DIMENSIONS BEFORE COMMENCING WORK. REPORT TO THE ARCHITECT OR ENGINEER ANY DISCREPANCIES, ERRORS OR CONDITIONS THAT WILL ALTER CONSTRUCTION AS INTENDED BY THESE DRAWINGS. ARCHITECT IS NOT RESPONSIBLE FOR ANY WORK AND/OR MATERIALS FURNISHED ON THE JOB.

STATE OF FLORIDA

Professional Seal

AR0017521

NEW HOUSE FOR:

5900 LLC

5900 SW 114 TER

PINECREST, FL

DRAWN BY:

MER

DATE:

5/15/23

SCALE:

AS NOTED

SHEET NO.:

E-1.1