



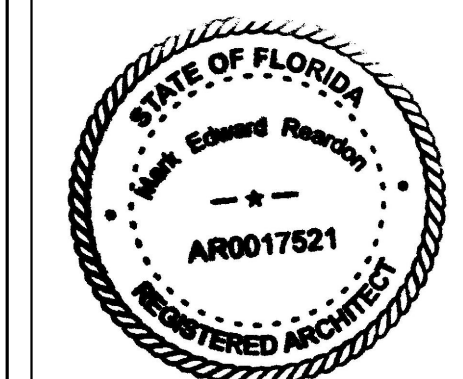


THE G.C. IS TO VERIFY ALL EXISTING SITE CONDITIONS AND THOROUGHLY CHECK ELEVATIONS & DIMENSIONS BEFORE COMMENCING WORK. REPORT TO THE ARCHITECT OR ENGINEER ANY DISCREPANCIES, ERRORS OR CONDITIONS THAT WILL ALTER CONSTRUCTION AS INTENDED BY THESE DRAWINGS. ARCHITECT IS NOT RESPONSIBLE FOR ANY WORK AND/OR MATERIALS FURNISHED ON THE JOB.



DRAWN BY:
MER
DATE:
5/15/23
SCALE:
AS NOTED
SHEET NO.:

	DUPLEX RECEPTACLE MOUNTED HIGHER THAN STANDARD MTG. HT. VERIFY EXACT HEIGHT AT CONSTRUCTION UNLESS HEIGHT IS NOTED.
	DUPLEX RECEPTACLE RECESSED MOUNTED IN COUNTER. VERIFY EXACT HEIGHT AT CONSTRUCTION UNLESS HEIGHT IS NOTED.
	TELEPHONE OUTLET- CAT 5 CABLE
	TV RECEPTACLE- CAT 5 CABLE & RG/6 CABLE & AUDIO CABLES
	MOTOR SIZE AS NOTED
	INDICATES WEATHERPROOF NEMA #4 OR #3R
	INDICATES ABOVE FINISHED FLOOR
	INDICATES GROUND FAULT INTERRUPTOR
	SELF-CONTAINED-TYPE SMOKE DETECTOR
	SELF-CONTAINED-TYPE SMOKE & CARBON MONOXIDE DETECTOR
	DOORBELL CHIME
	KEY PAD FOR LOW VOLTAGE LIGHTING CONTROL
	DOORBELL PUSHBUTTON
	92" FAN WITH ENERGY STAR CERTIFICATION. QUINER TO SELECT FAN SPEED. PROVIDE W/ LUTRON ADJUSTABLE SPEED SWITCH

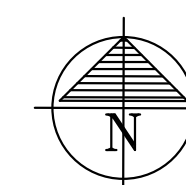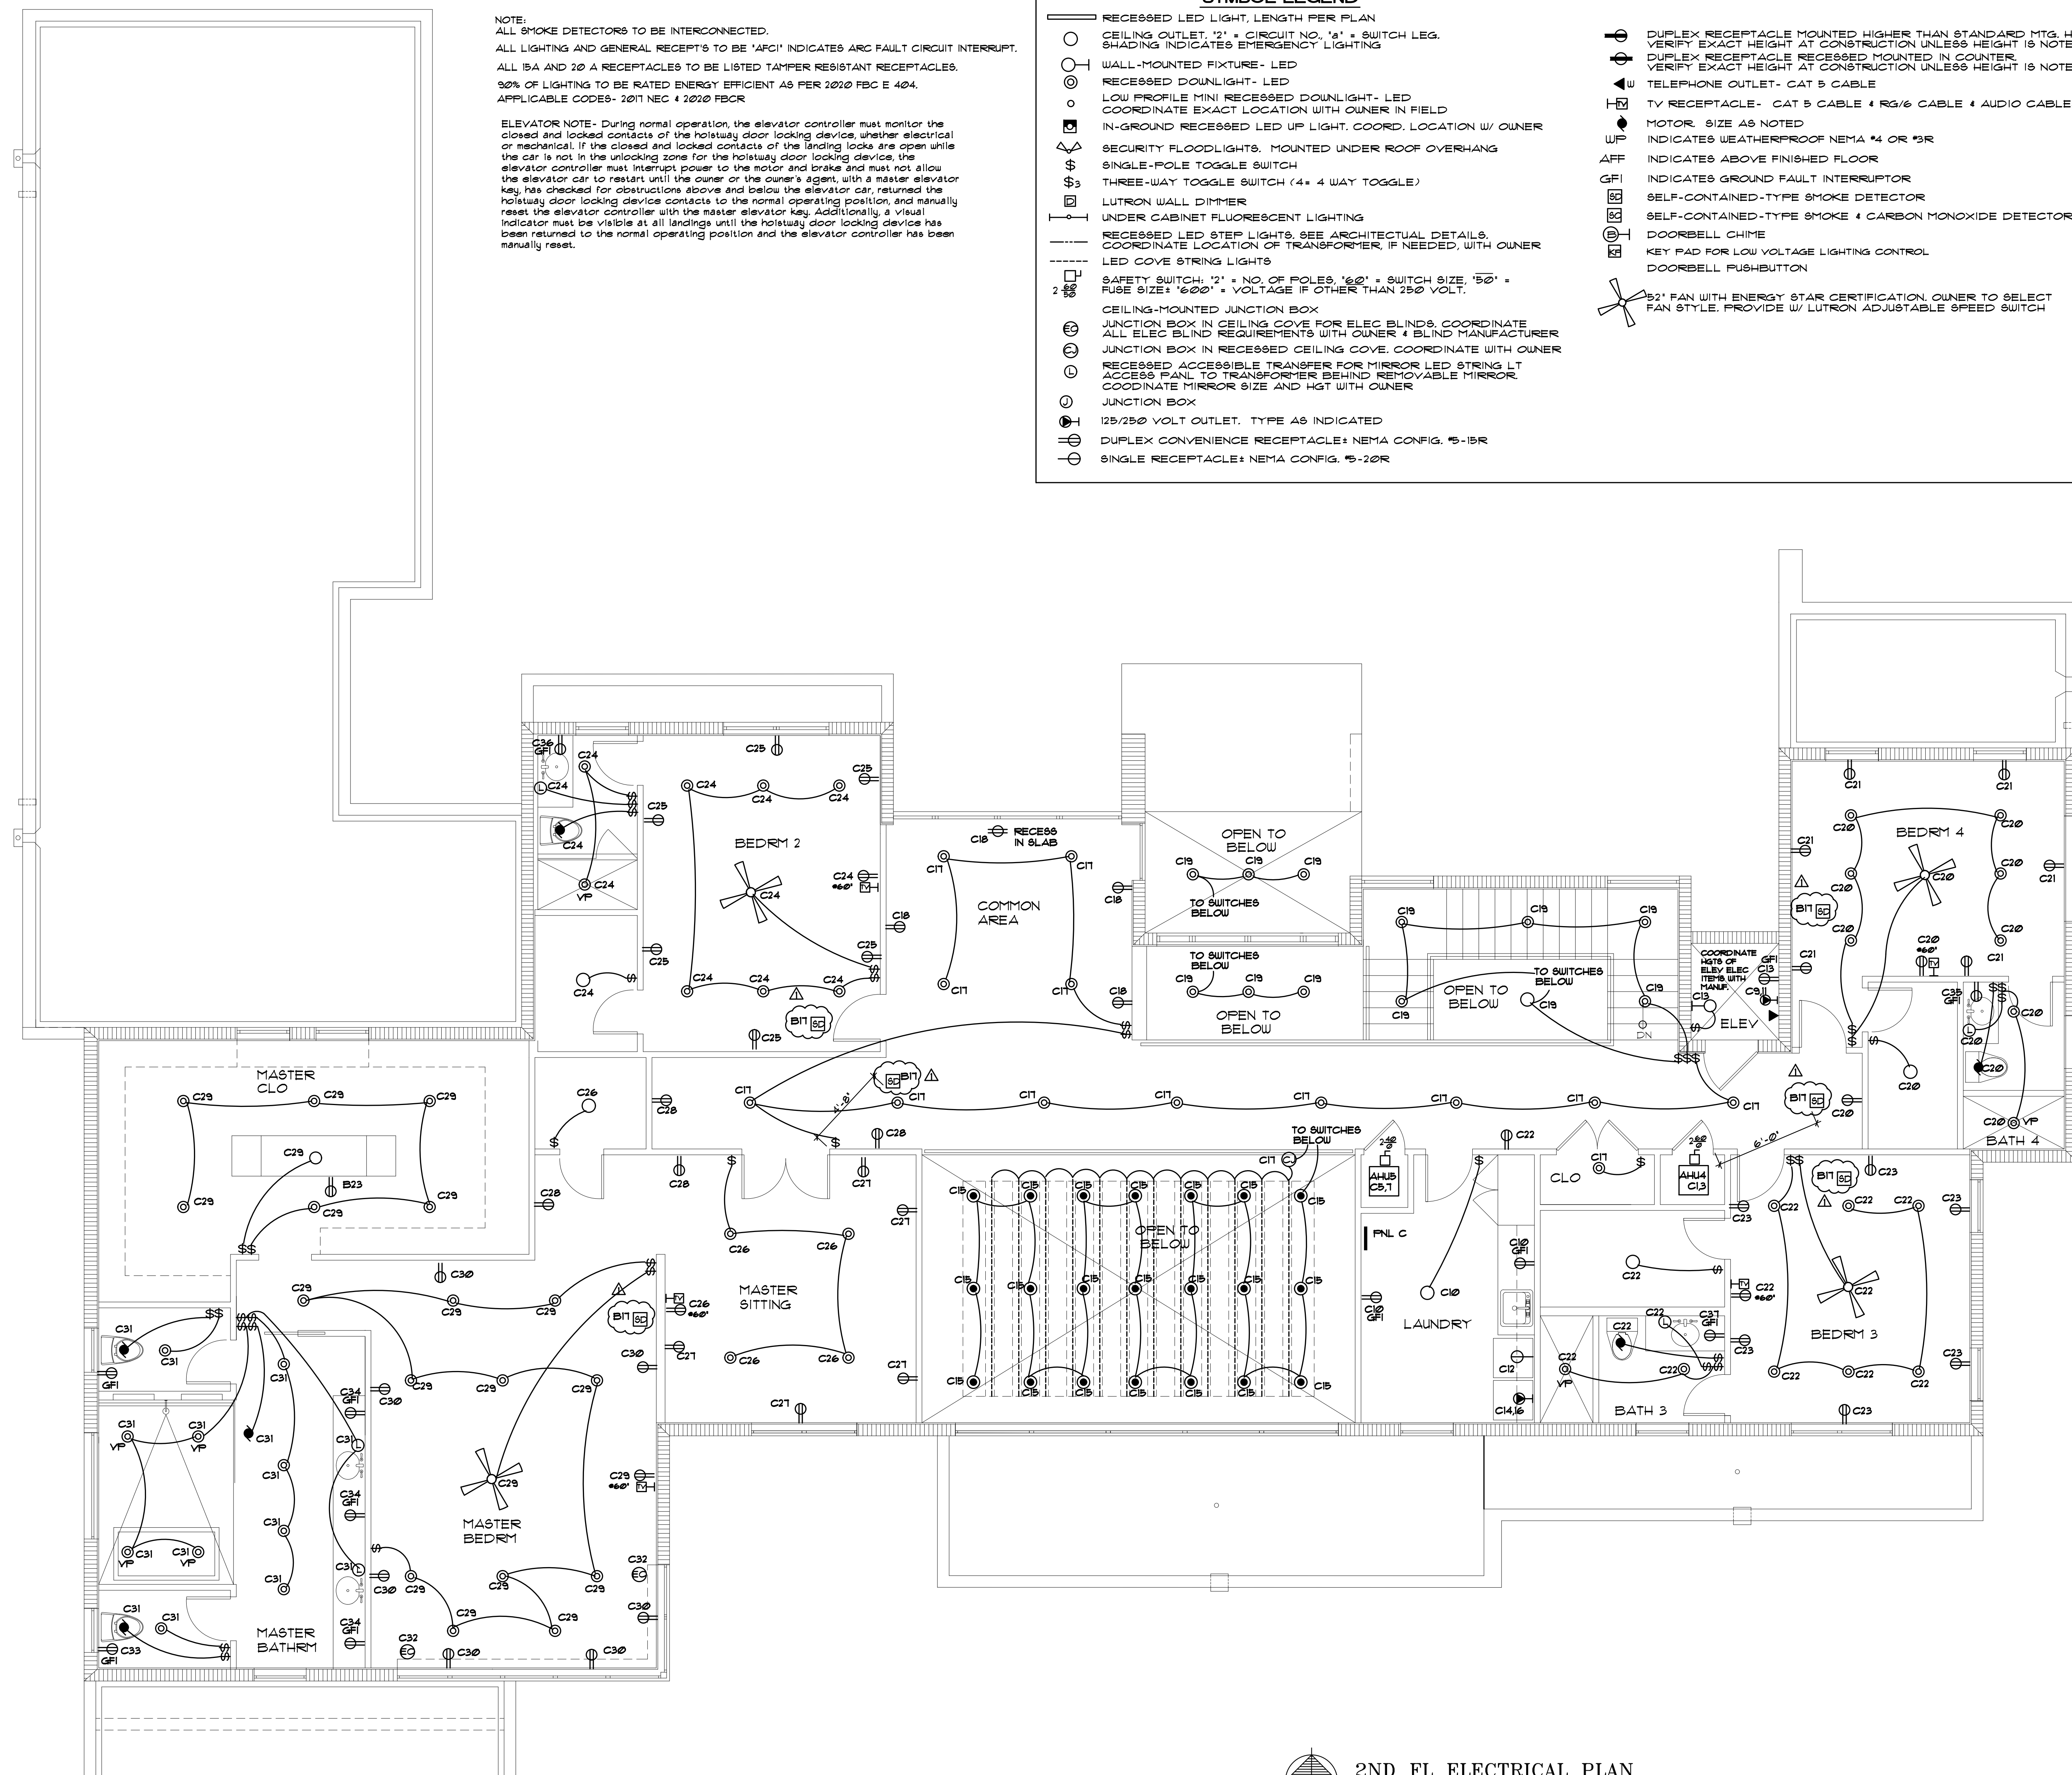

2ND FL ELECTRICAL PLAN
SCALE: 1/4" = 1'-0"