



SECTION 13 - TOWNSHIP 55 SOUTH - RANGE 40 EAST
LYING IN THE CITY OF PINECREST, FLORIDA

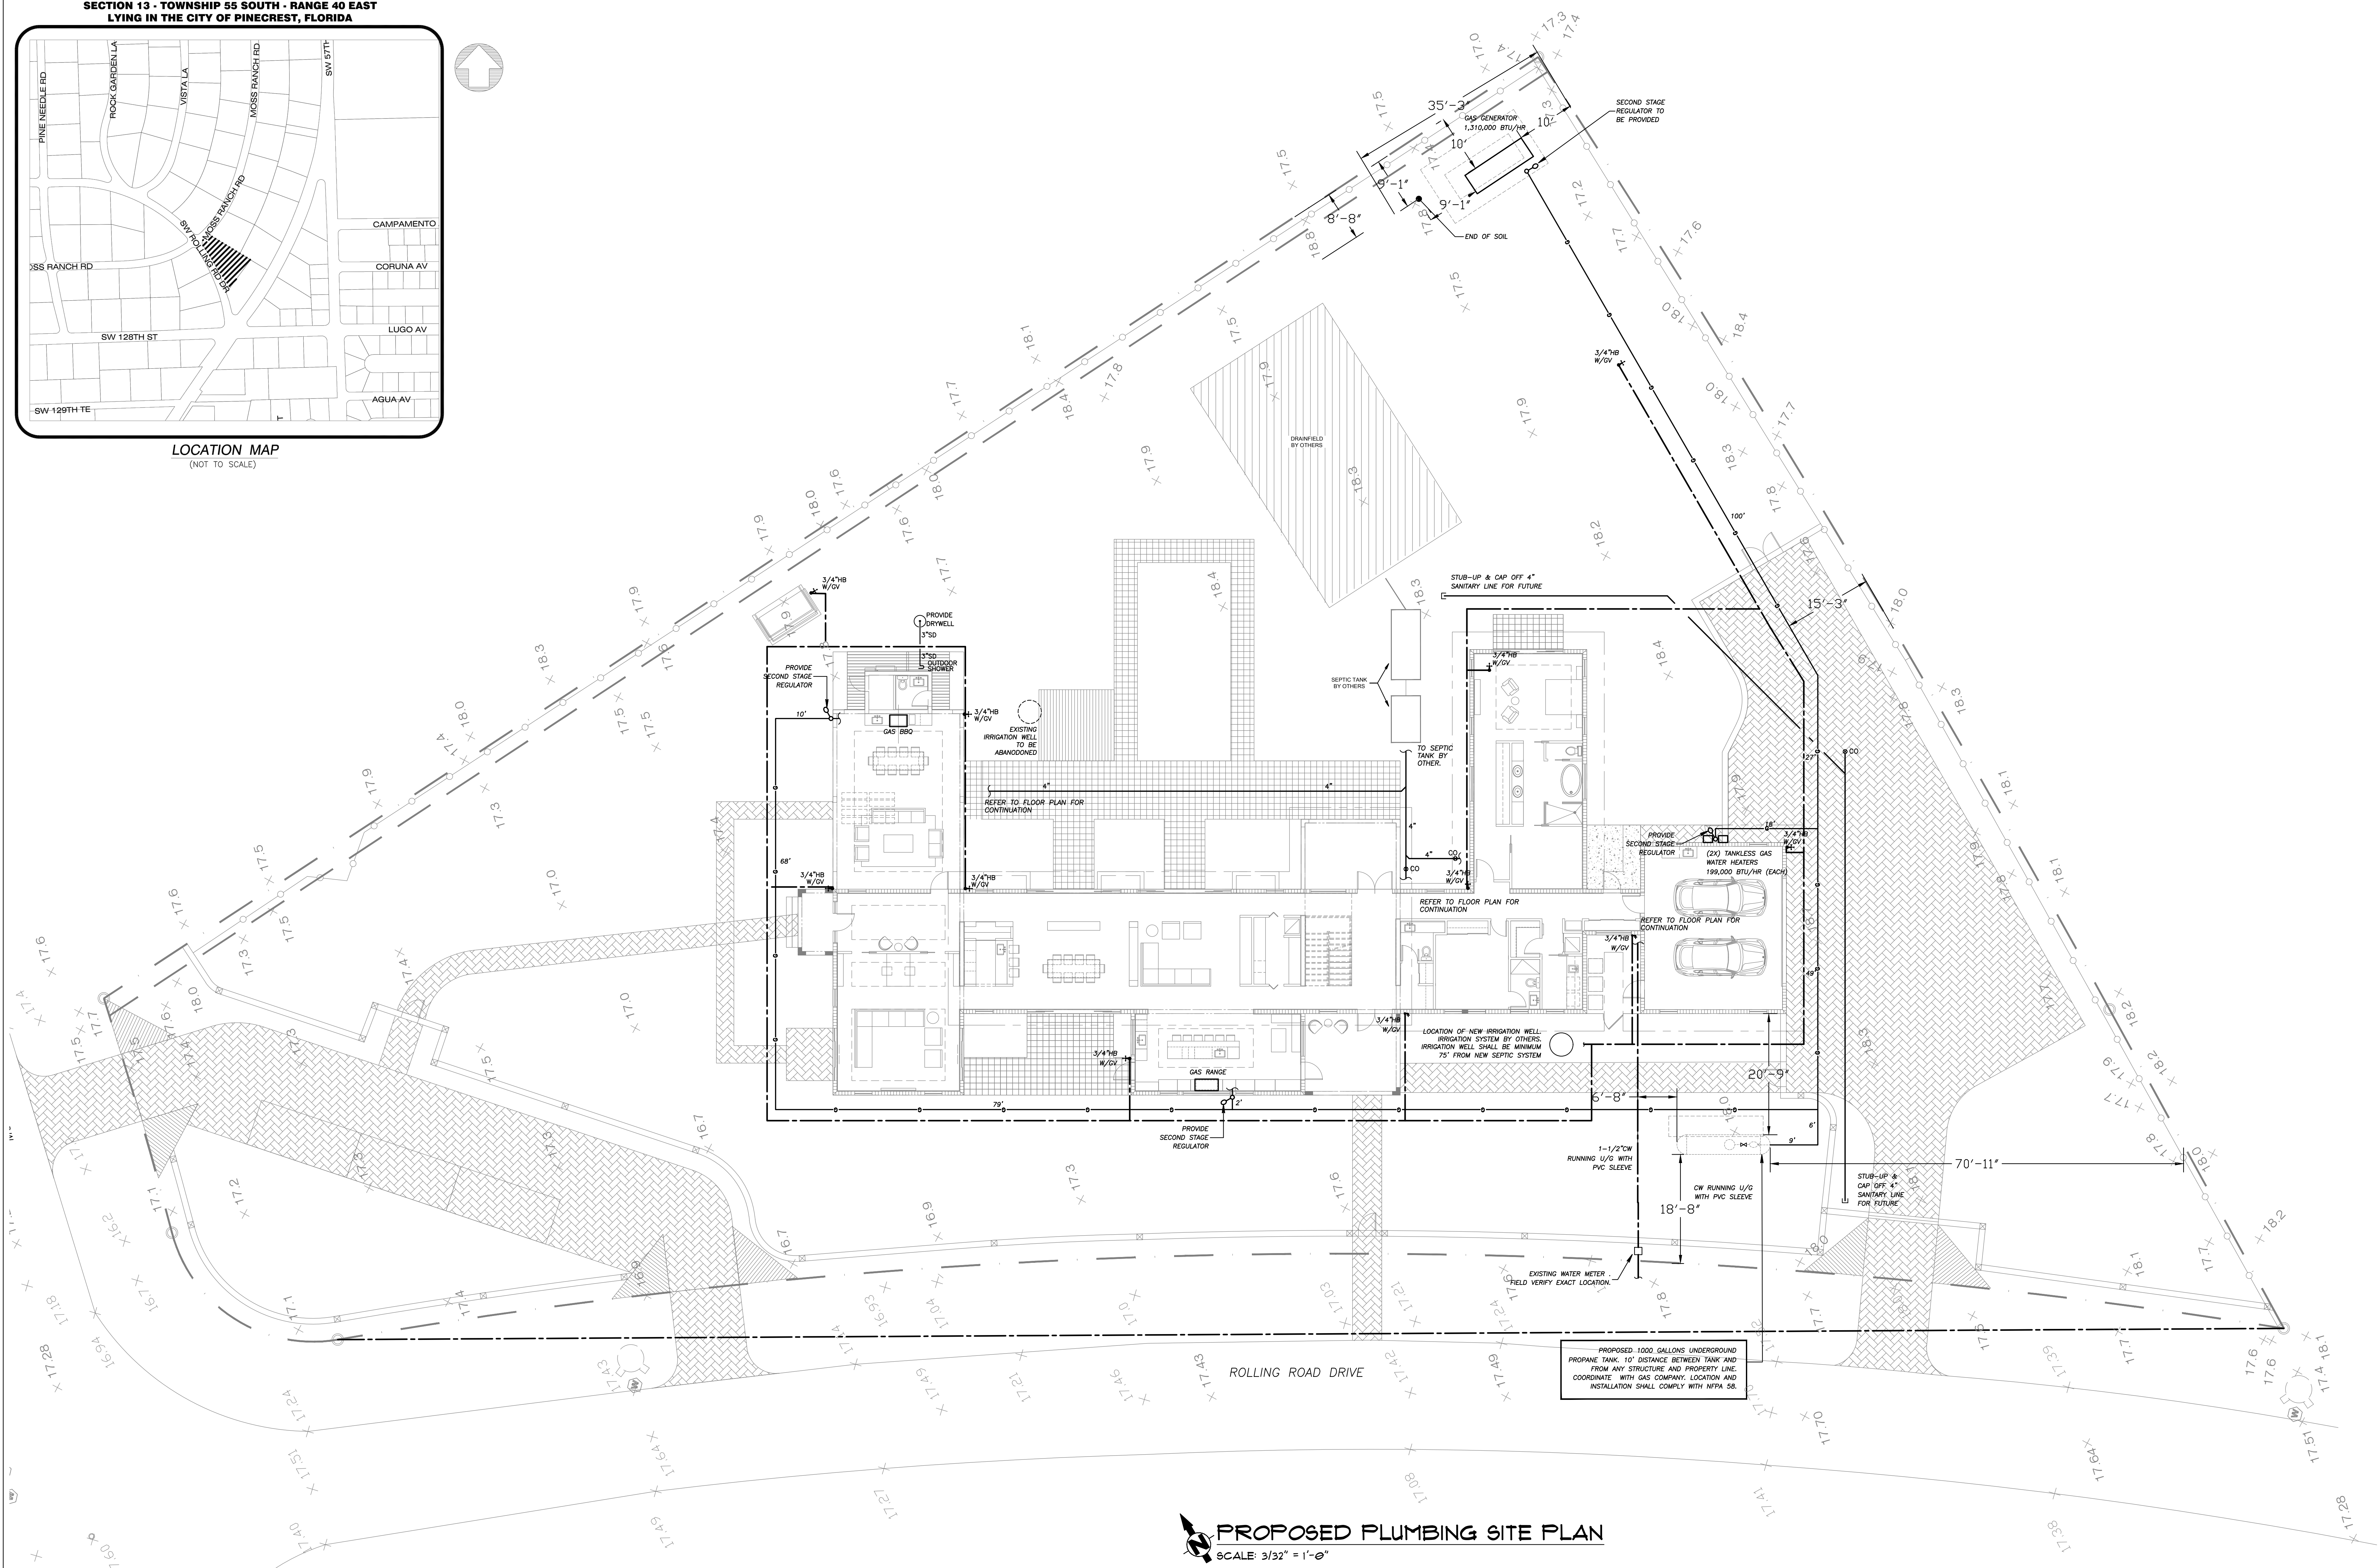

LOCATION MAP
(NOT TO SCALE)

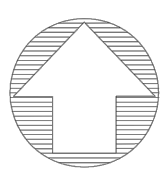

PROPOSED PLUMBING SITE PLAN
SCALE: 3/32" = 1'-0"



2020 Ponce de Leon, Suite 1002
Coral Gables, Florida 33134
Phone > 305 444 9800
Fax > 305 444 9827

Engineering Design:
Mechanical > Electrical
Plumbing > Fire Protection
www.arpe-eng.com

JOB # 22-1008
Amarilis Rodriguez, P.E.
License Number 60236
C.A. 26359

Signature _____
Date _____

PREPARED BY: ST

CHECKED BY: NAC

REV	DATE	DESCRIPTION
1	4/26/22	ISSUED FOR BIDDING
2		REVISION
3		
4		
5		

SCALE: AS SHOWN

JOB NO.: 22-PRO-0028

SHEET NO.	REV
P8-1	e



CASTRO RESIDENCE

PLUMBING SITE PLAN

12715 ROLLING ROAD DRIVE
PINECREST, FL 33156

SEAL