

CASTRO RESIDENCE

PLUMBING FLOOR PLAN

12715 ROLLING ROAD DRIVE
PINECREST, FL 33156

SEAL

PREPARED BY: ST

CHECKED BY: NAC

REV	DATE	DESCRIPTION
1	4/26/23	ISSUED FOR BIDDING
2		REVISED FOR BIDDING
3		
4		
5		

SCALE: AS SHOWN

JOB NO.: 22-PRO-0028


SHEET NO.	REV
P-1	1

JOB # 22-1008

Amarilis Rodriguez, P.E.

License Number 60236

C.A. 26359

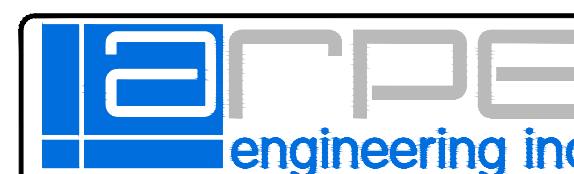


2020 Ponce de Leon, Suite 1002
Coral Gables, Florida 33134
Phone > 305 444 9800
Fax > 305 444 9827

Engineering Design:
Mechanical > Electrical
Plumbing > Fire Protection
www.arpe-eng.com

Signature _____
Date _____

PROPOSED SECOND FLOOR PLAN
SCALE: 1/4" = 1'-0"

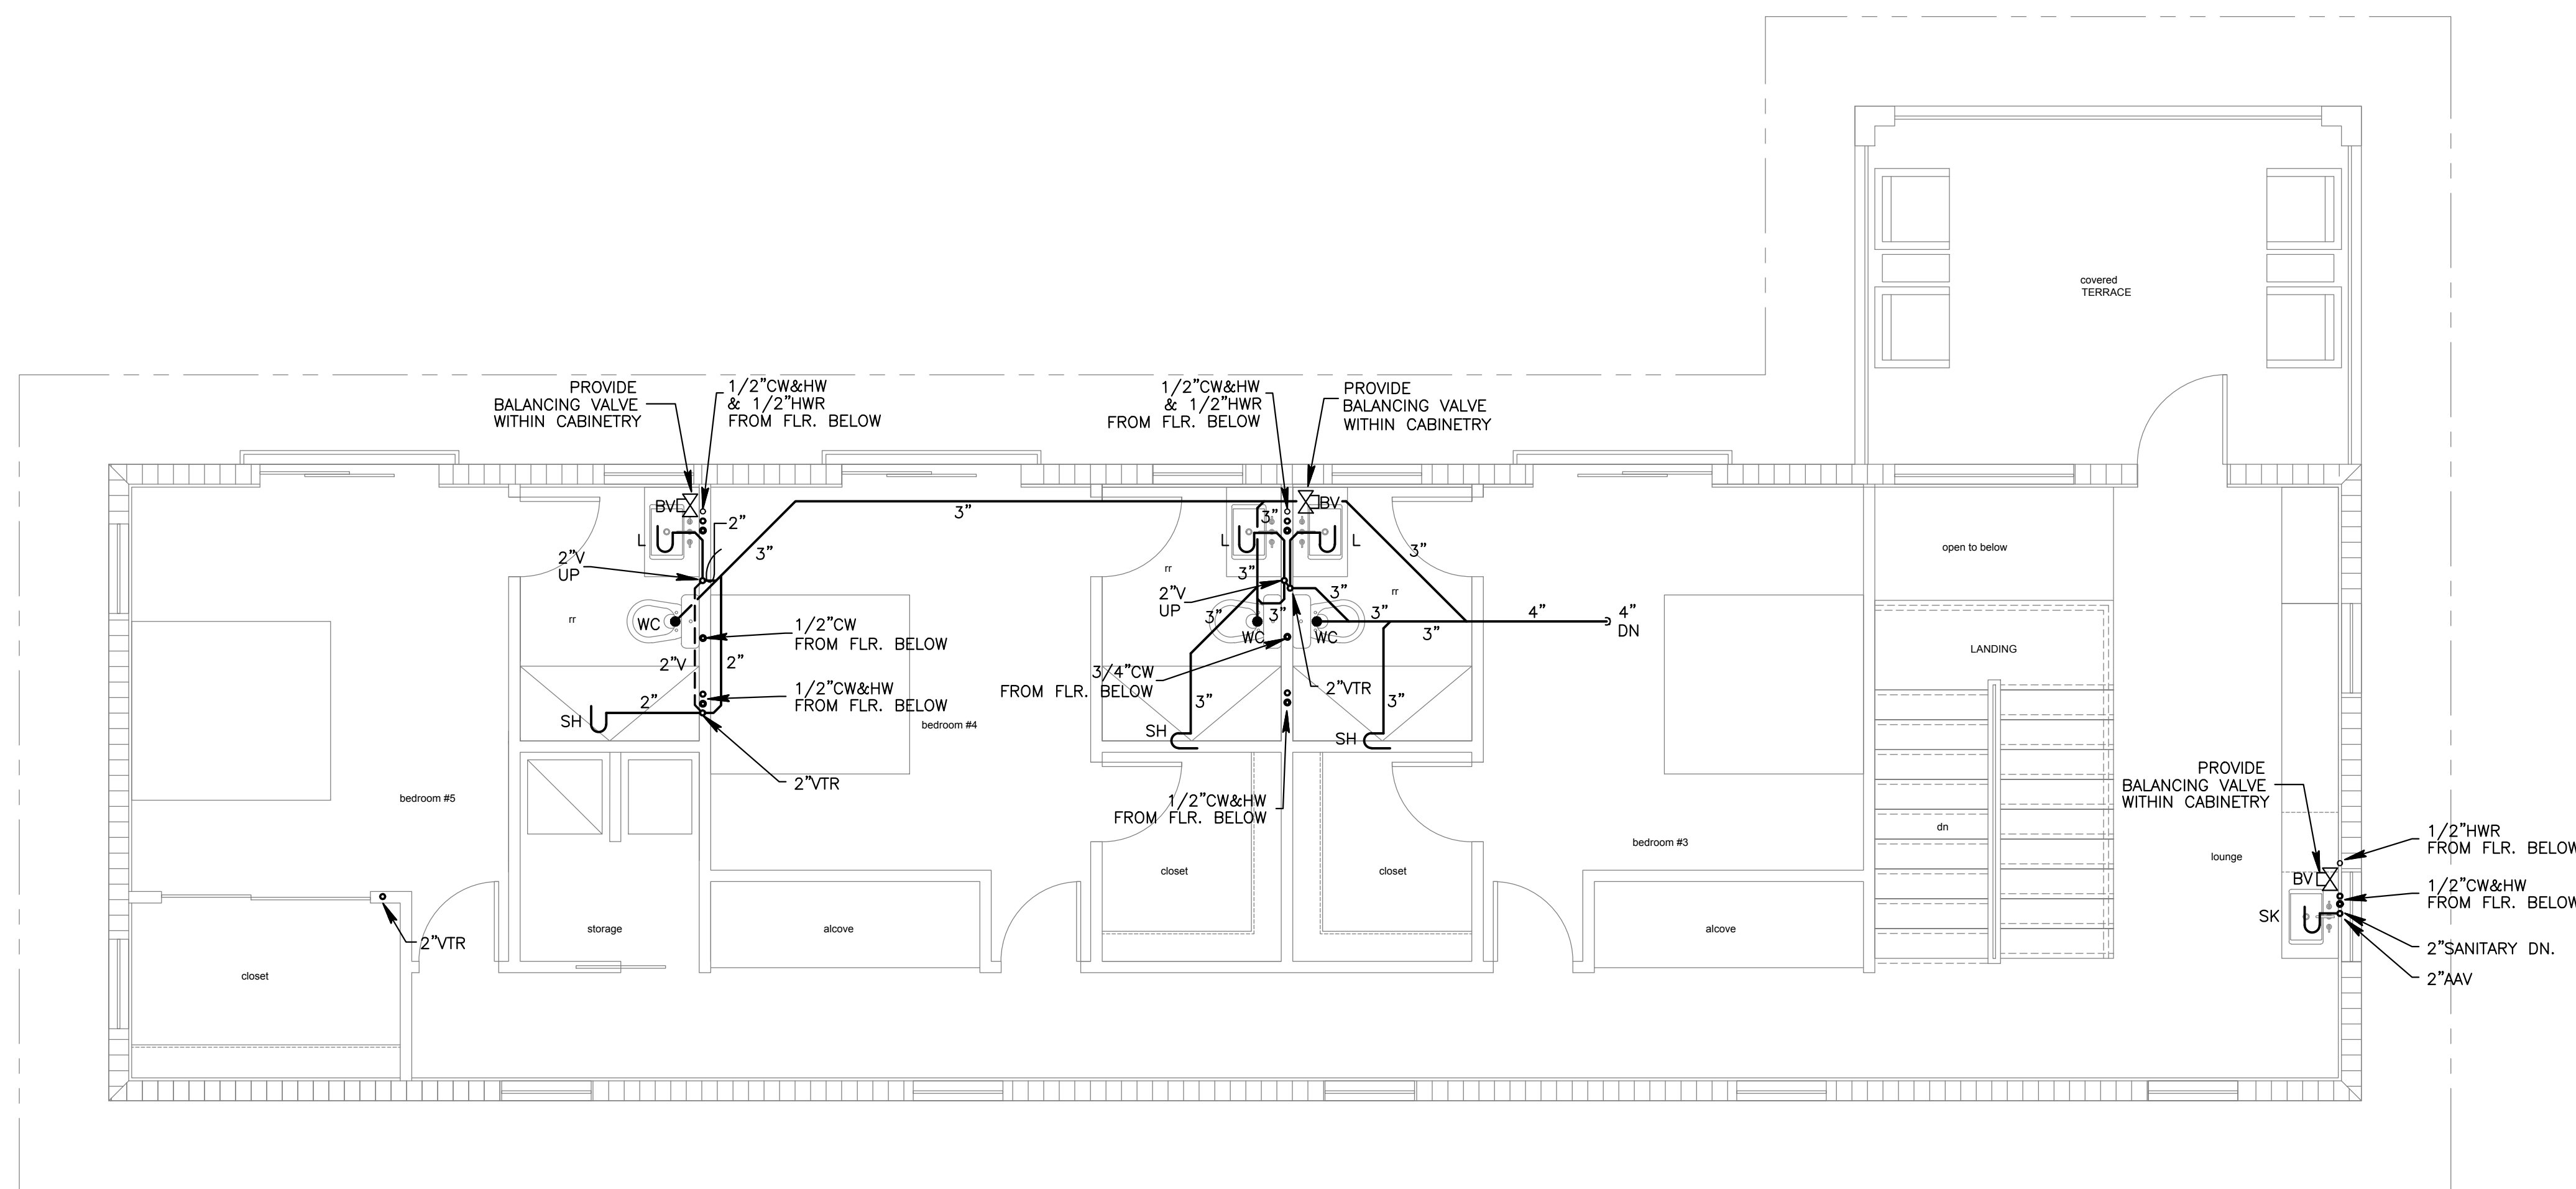

PROPOSED FIRST FLOOR PLAN
SCALE: 3/16" = 1'-0"

