

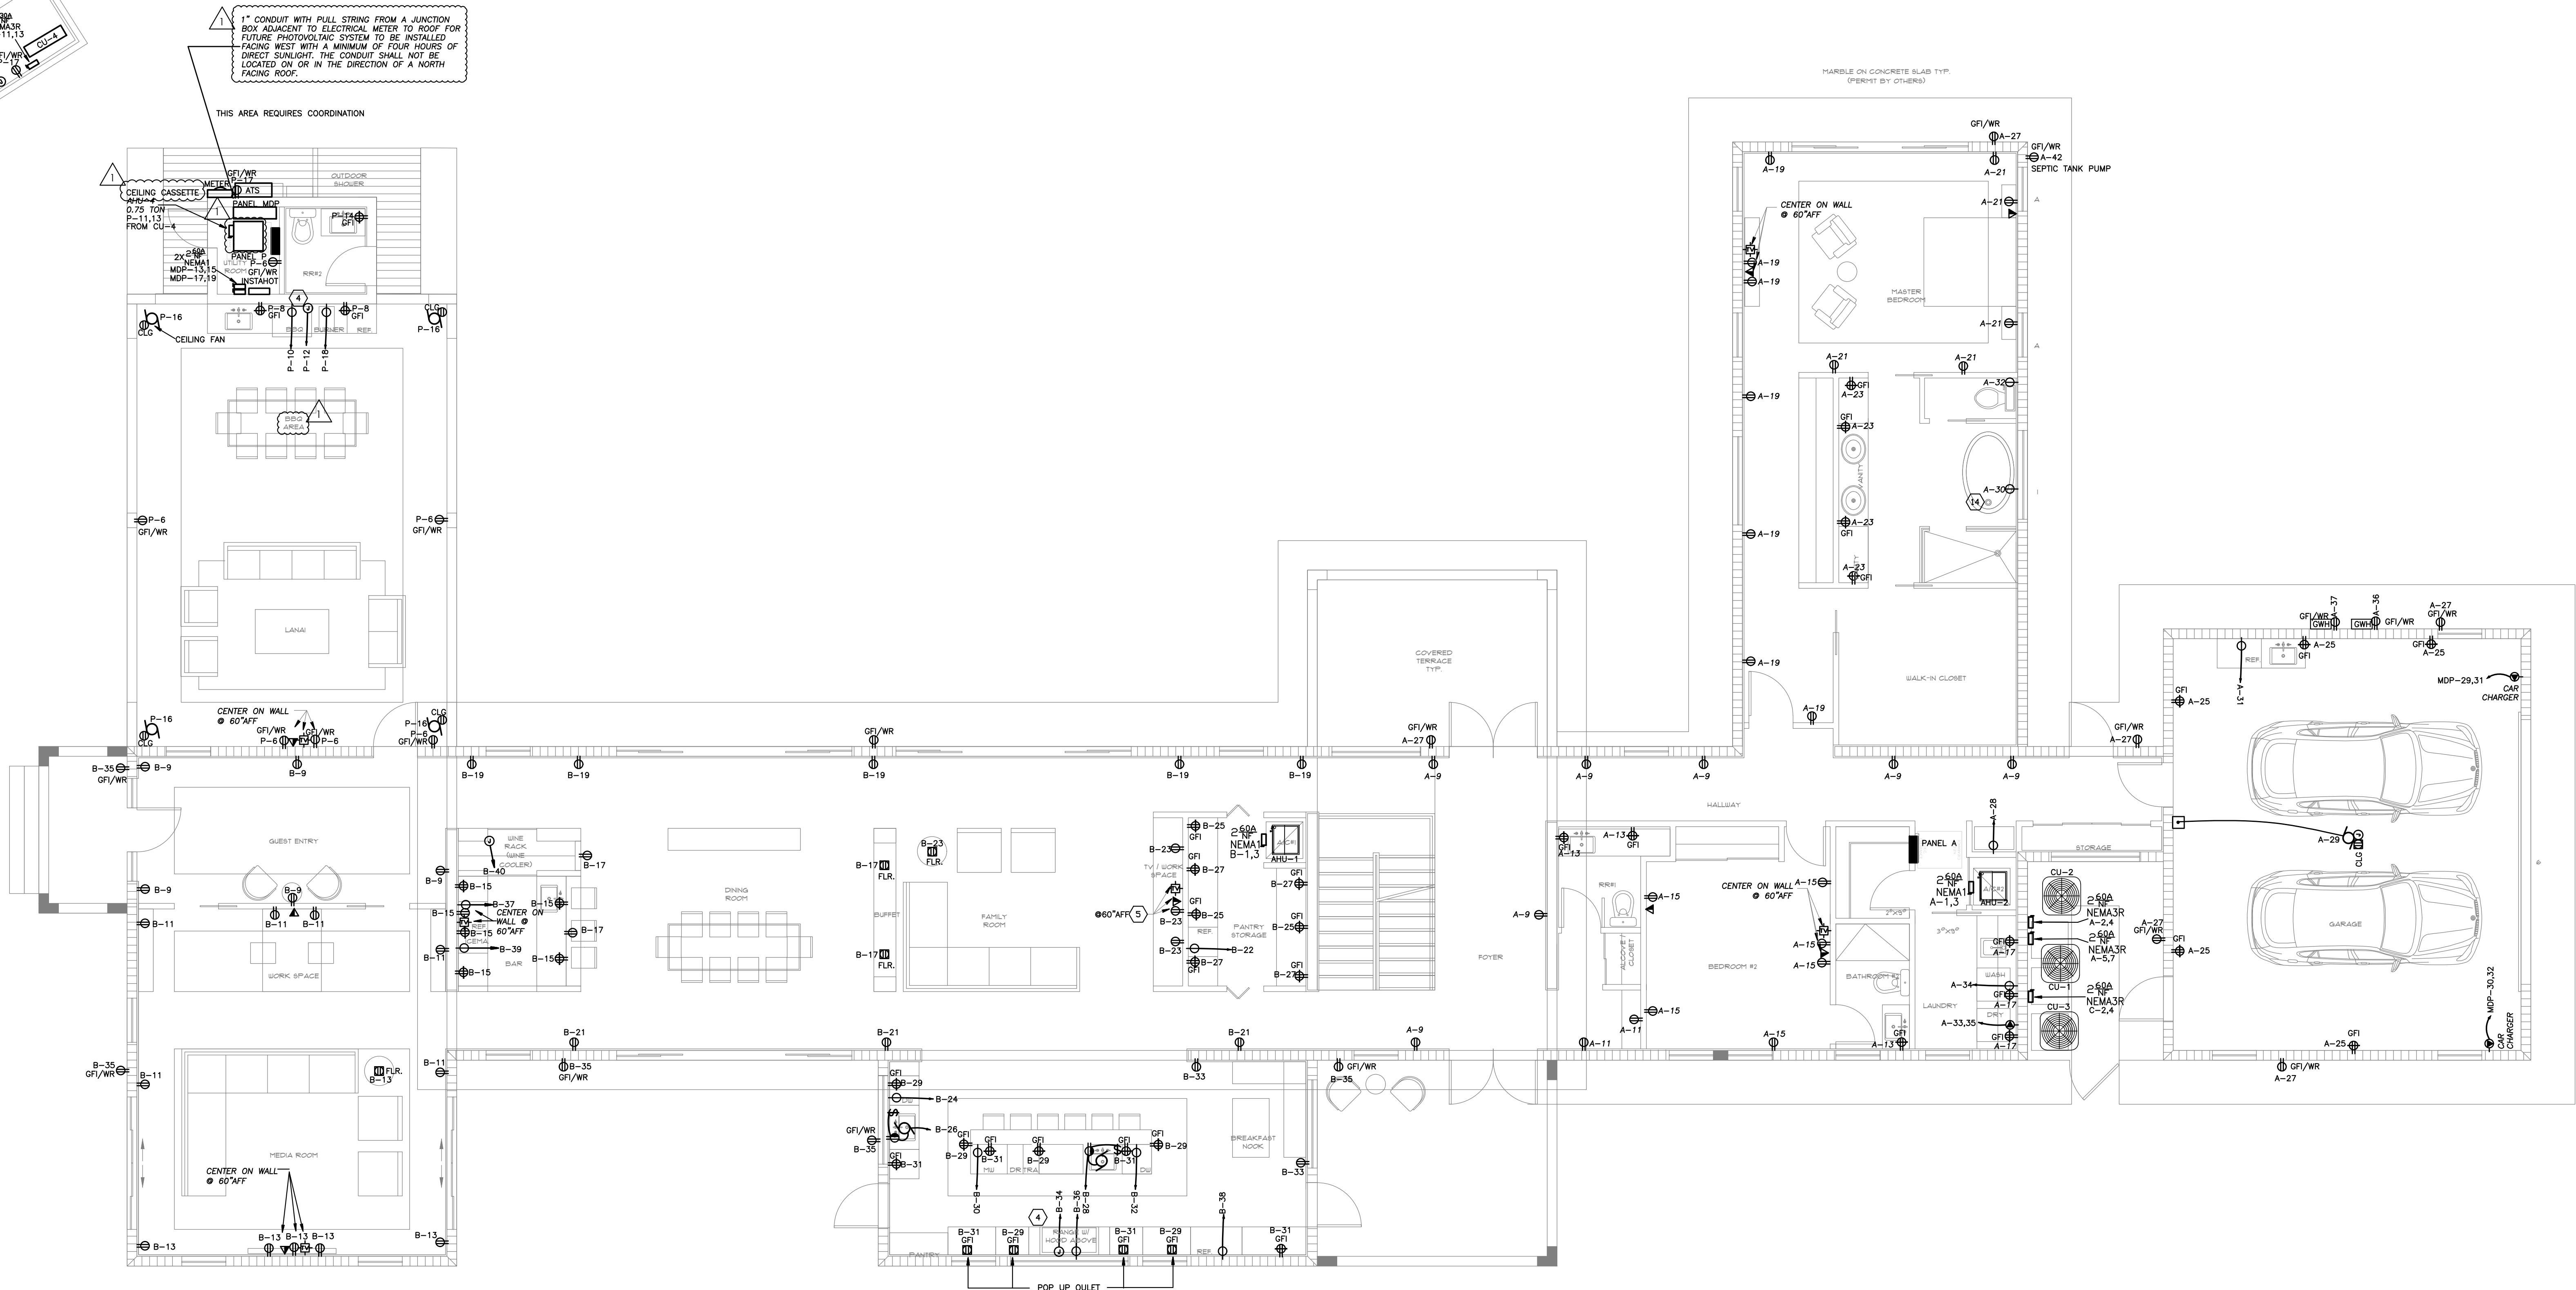


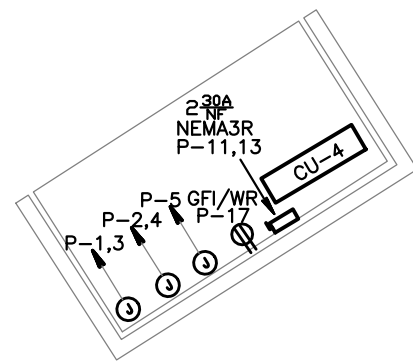

**POWER FIRST FLOOR PLAN**  
SCALE: 3/16" = 1'-0"

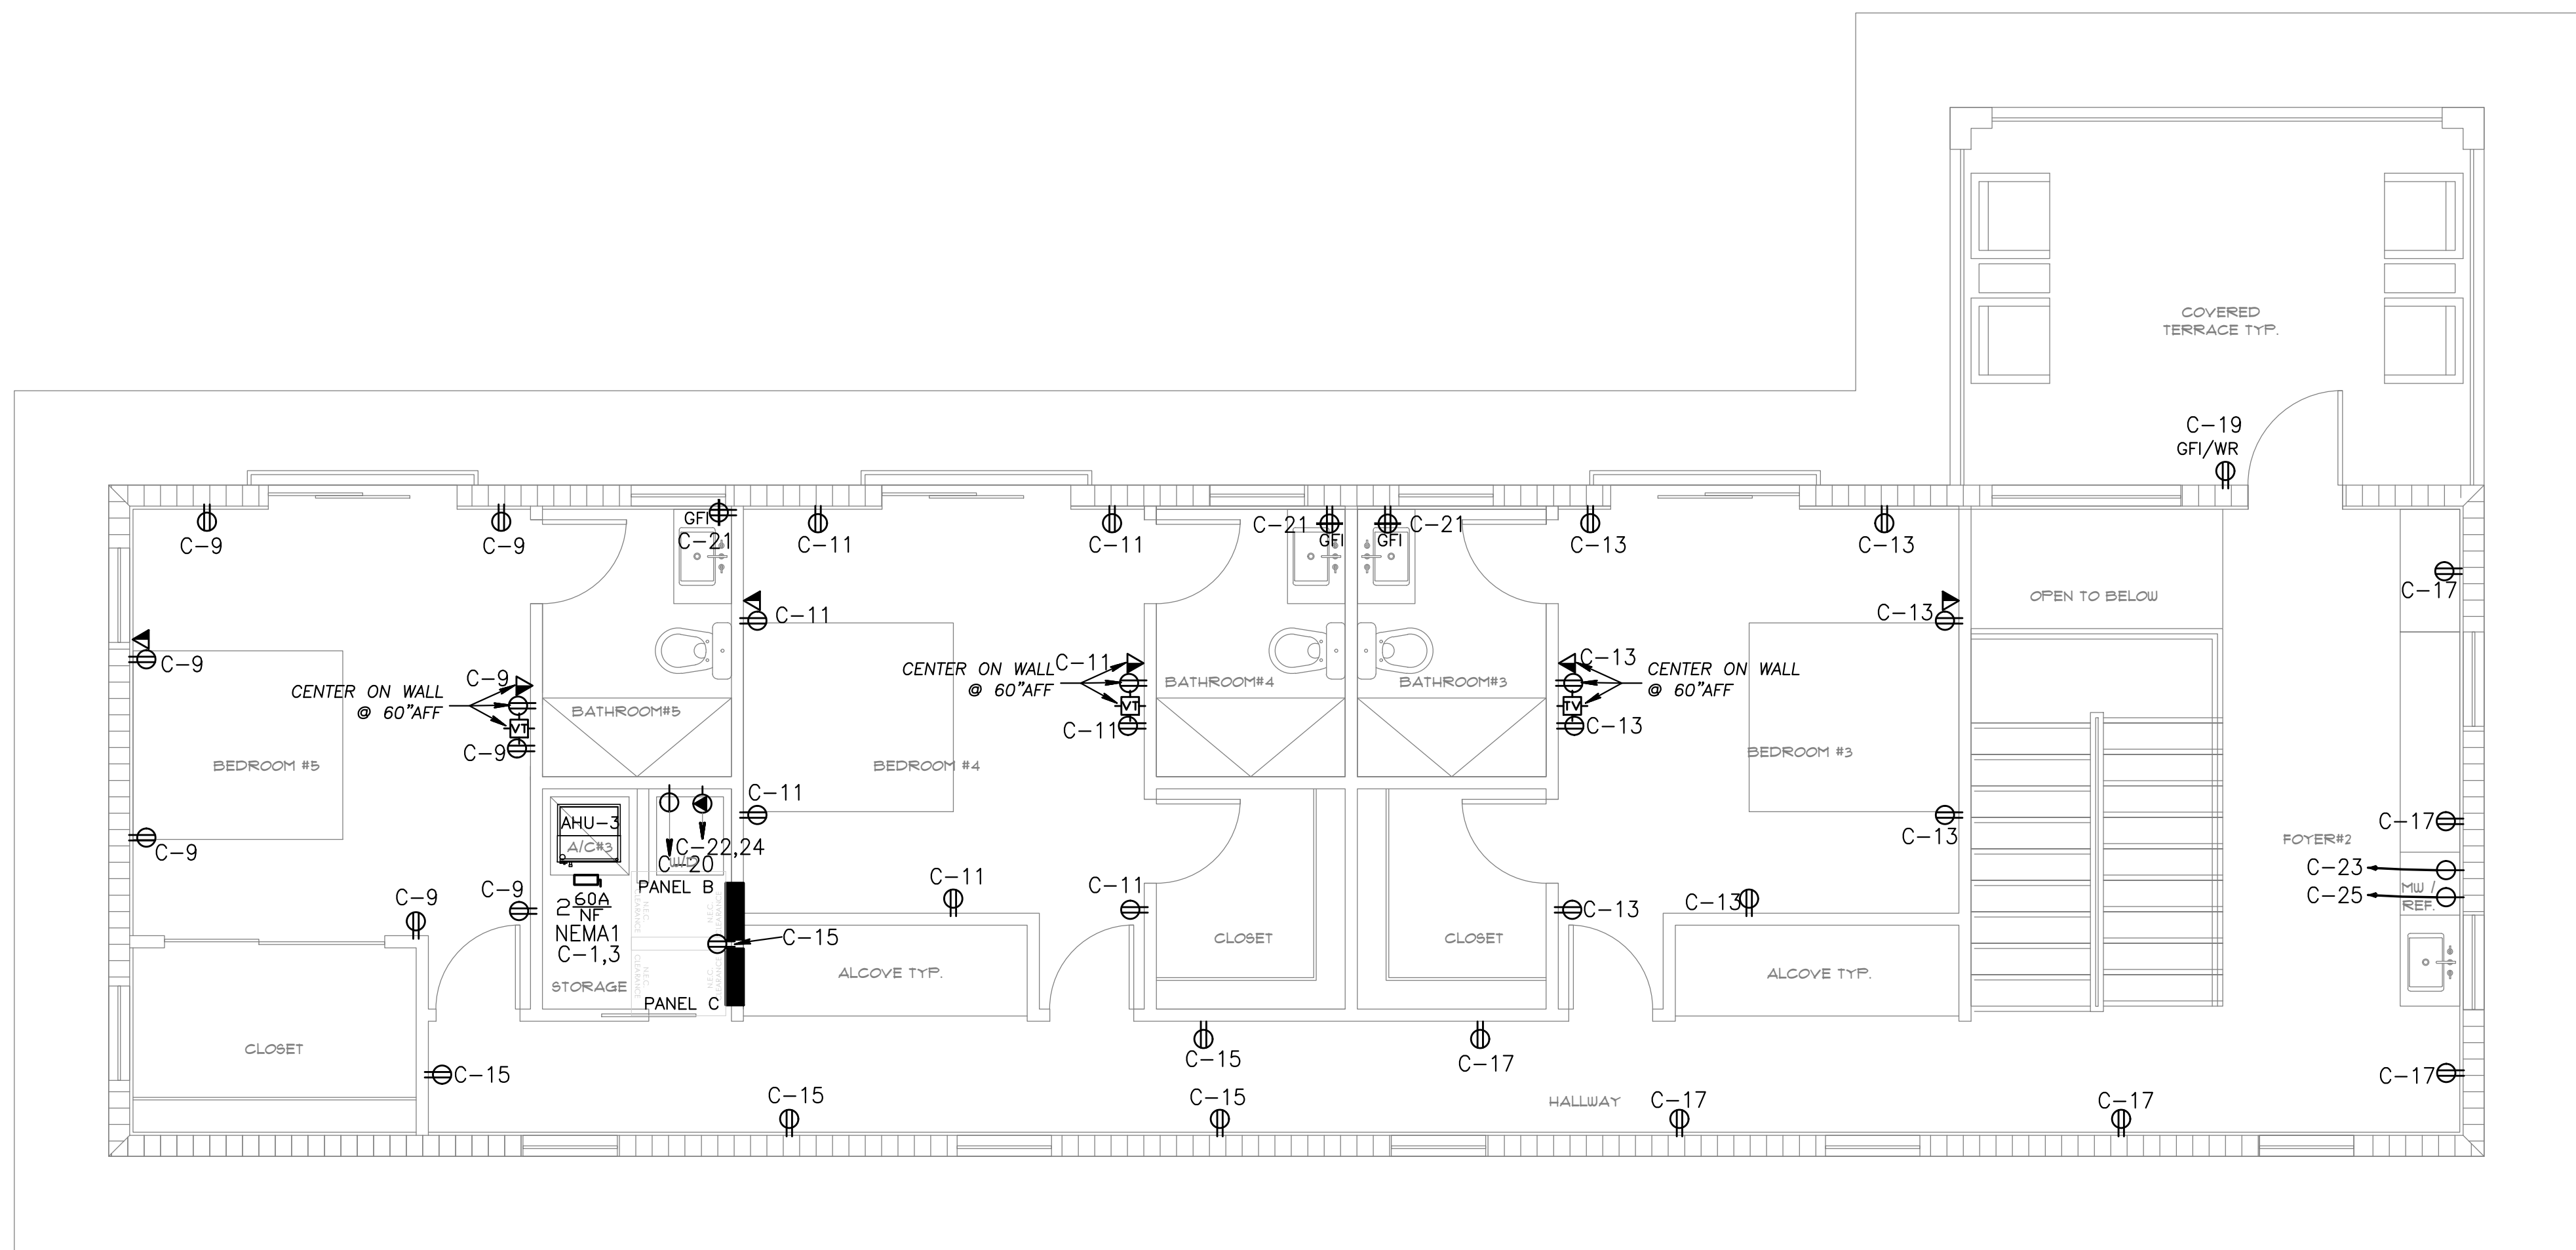

**POWER SECOND FLOOR PLAN**  
SCALE: 1/4" = 1'-0"

SEAL

PREPARED BY: BT

CHECKED BY: NAC

| REV | DATE       | DESCRIPTION                 |
|-----|------------|-----------------------------|
| 01  | 10/22      | ISSUED FOR BLDG DEPT REVIEW |
| 02  | 09/29/2022 | REV COMMENTS                |
|     |            |                             |
|     |            |                             |
|     |            |                             |

SCALE: AS SHOWN

JOB NO.: 22-FRC-0028

SHEET NO. REV

E-1

0

**arpe**  
engineering inc

2020 Ponce de Leon, Suite 1002  
Coral Gables, Florida 33134  
Phone > 305.444.9809  
Fax > 305.444.9827

Engineering Design:  
Mechanical • Electrical  
• Plumbing • Fire Protection

www.arpe-eng.com

Signature \_\_\_\_\_  
Date \_\_\_\_\_

JOB # 22-1008

Amarilis Rodriguez, P.E.  
License Number 60236  
C.A. 26359