



REV	DATE	DESCRIPTION
0	8/4/24	ISSUED FOR BLDG DEPT REVIEW
1	8/6/2020	REV COMMENTS
2	8/25/24	OWNER CHANGES

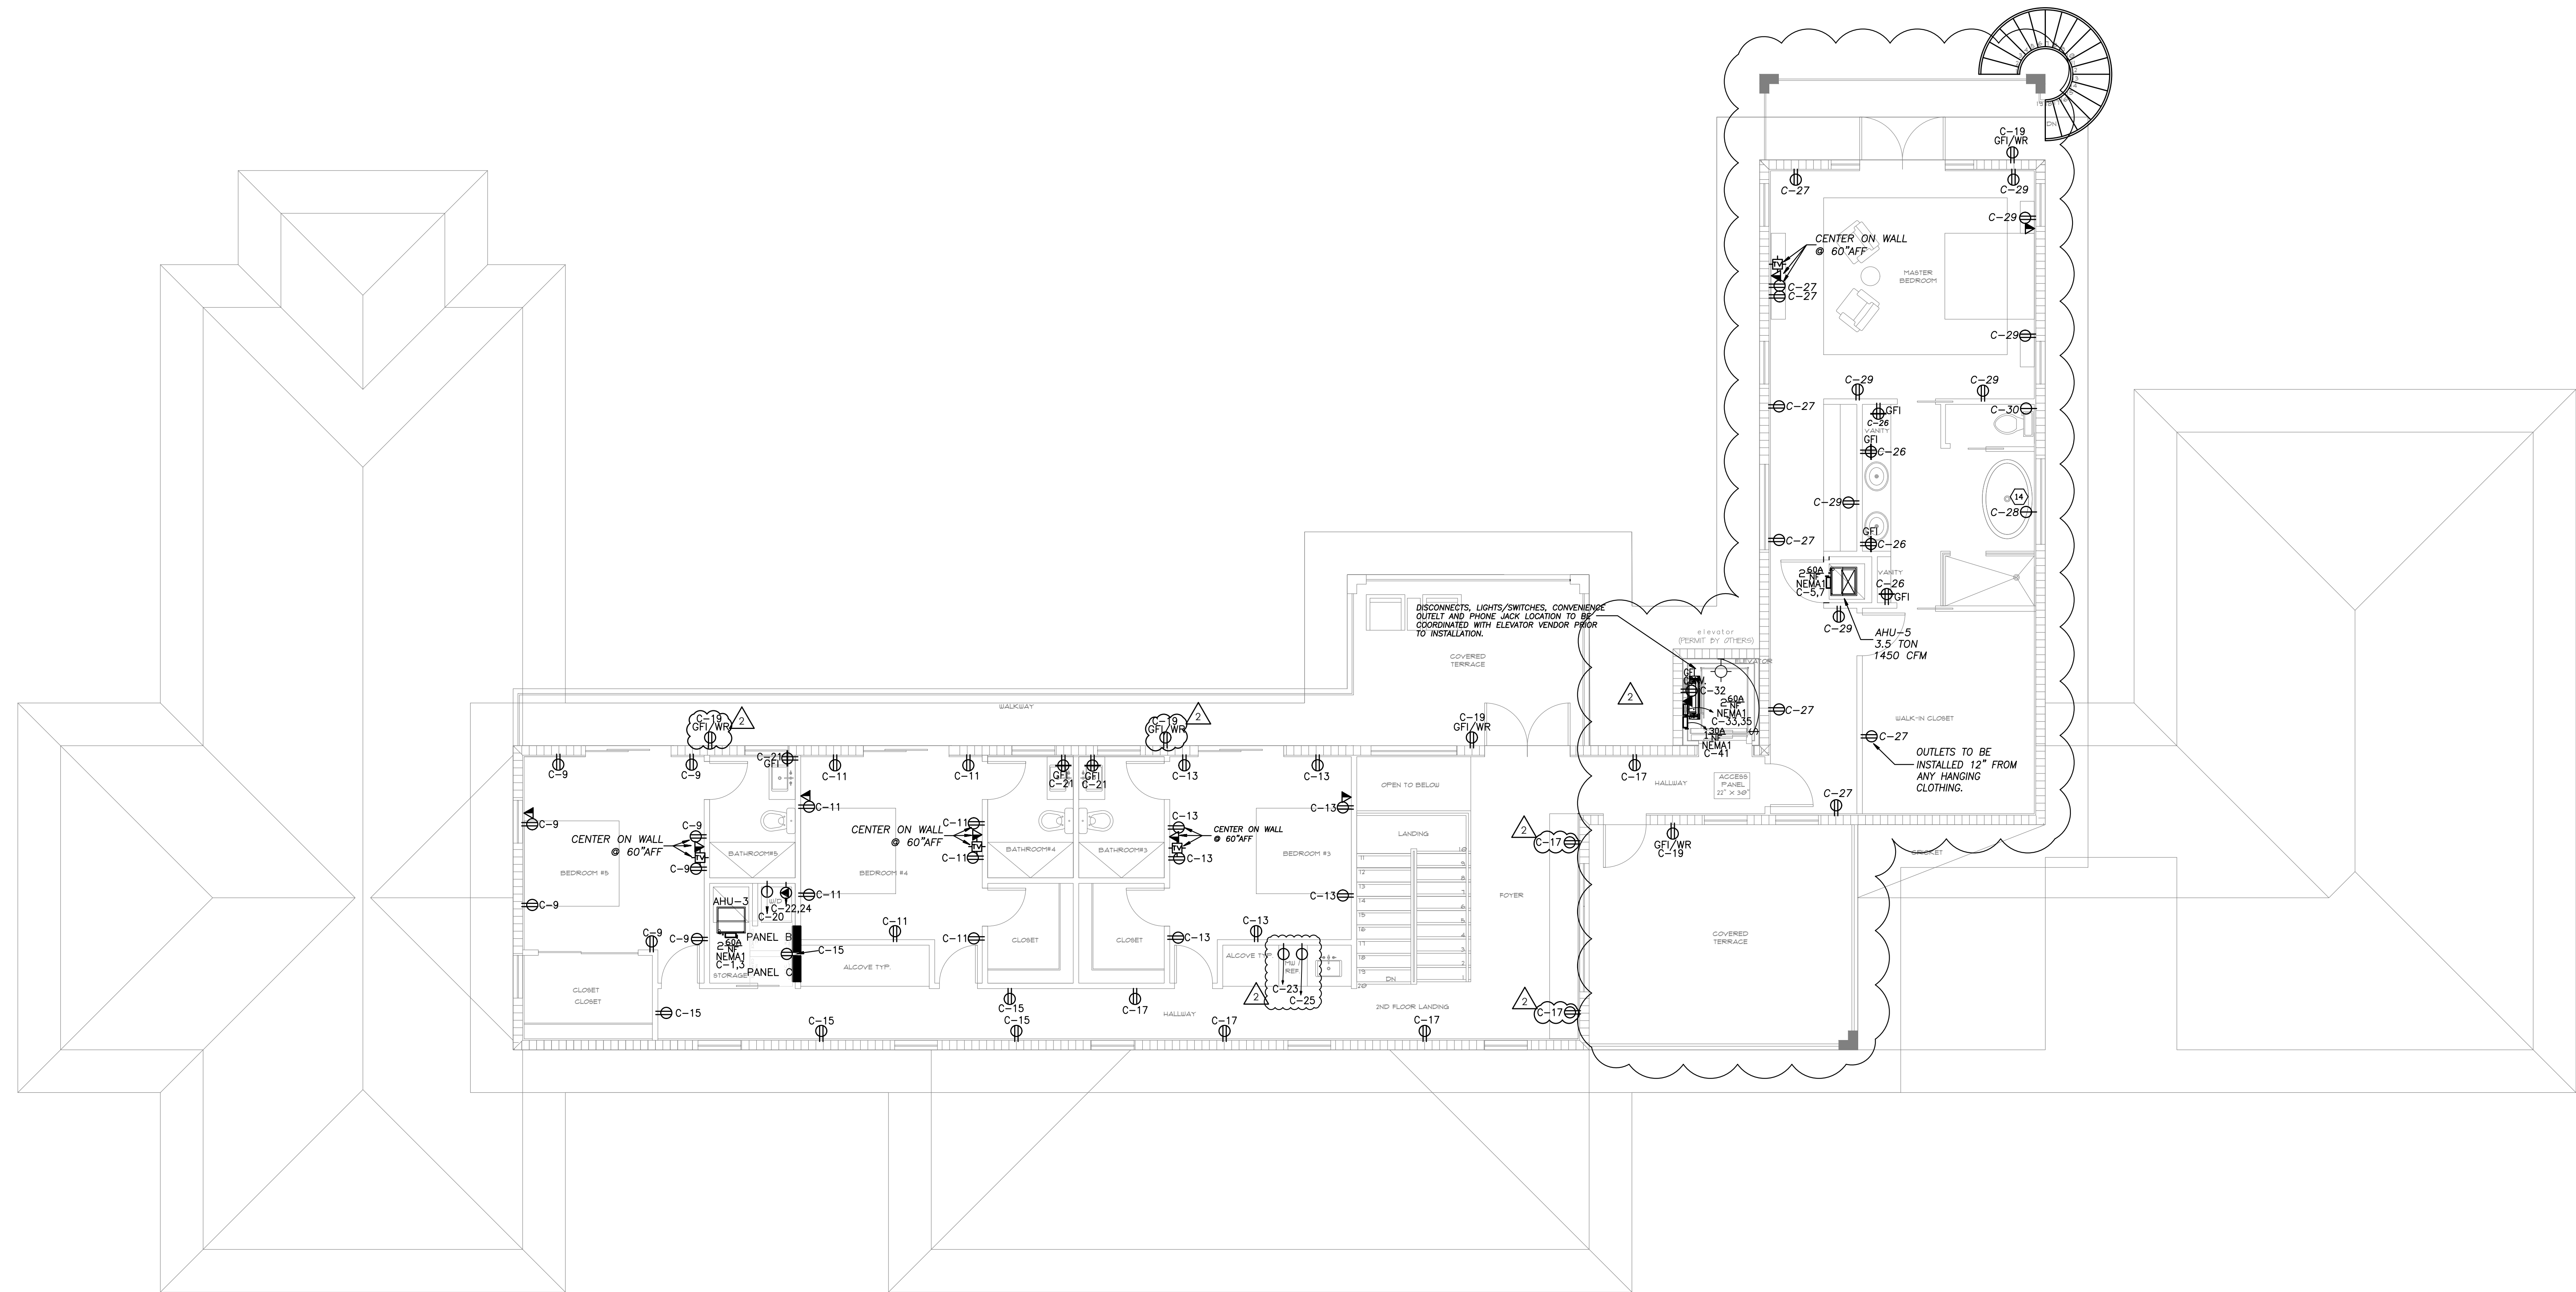

POWER SECOND FLOOR PLAN
SCALE: 3/16" = 1'-0"

2 NEW SHEET

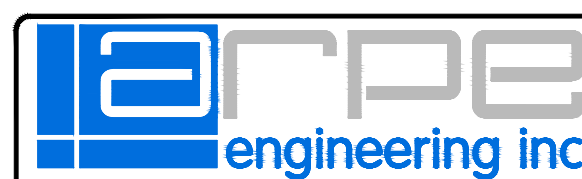

2020 Ponce de Leon, Suite 1002
Coral Gables, Florida 33134
Phone > 305 444 9809
Fax > 305 444 9827

Engineering Design:
> Mechanical > Electrical
> Plumbing > Fire Protection
www.arpe-eng.com

JOB # 22-1008

Amarilis Rodriguez, P.E.
License Number 60236
C.A. 28369

Signature _____
Date _____