



REV	DATE	DESCRIPTION
1	8/19/24	ISSUED FOR BLDG DEPT REVIEW
2	8/19/24	OWNER CHANGES

LEGEND	
	CEILING FIXTURE
	UNDER CABINET LIGHTING FIXTURE
	CHANDIELIER FIXTURE
	RECESSED LIGHT
	SMALL RECESSED LIGHT
	WALL MOUNT FIXTURE
	VAPOR PROOF FIXTURE
	PERIMETER LIGHTING
	CARBON MONOXIDE DETECTOR
	EXHAUST FAN
	208V RECEPTACLE
	WALL GFI RECEPTACLE
	UNDER CABINET RECEPTACLE
	WALL GFI RECEPTACLE
	WATERPROOF RECEPTACLE
	FLOOR MOUNT RECEPTACLE
	CEILING MOUNT RECEPTACLE
	FLUORESCENT LIGHT
	SINGLE POLE SWITCH
	3-WAY SWITCH
	4-WAY SWITCH
	DIMMER SWITCH
	CABLE TV
	INTERNET/TELEPHONE
	GARAGE DOOR OPENER
	DOOR CHIMES
	DOOR BELL
	FLOOD LIGHTS
	CEILING FAN/LIGHT
	ELECTRICAL PANEL
	ELECTRICAL METER
	ELECTRICAL DISCONNECT

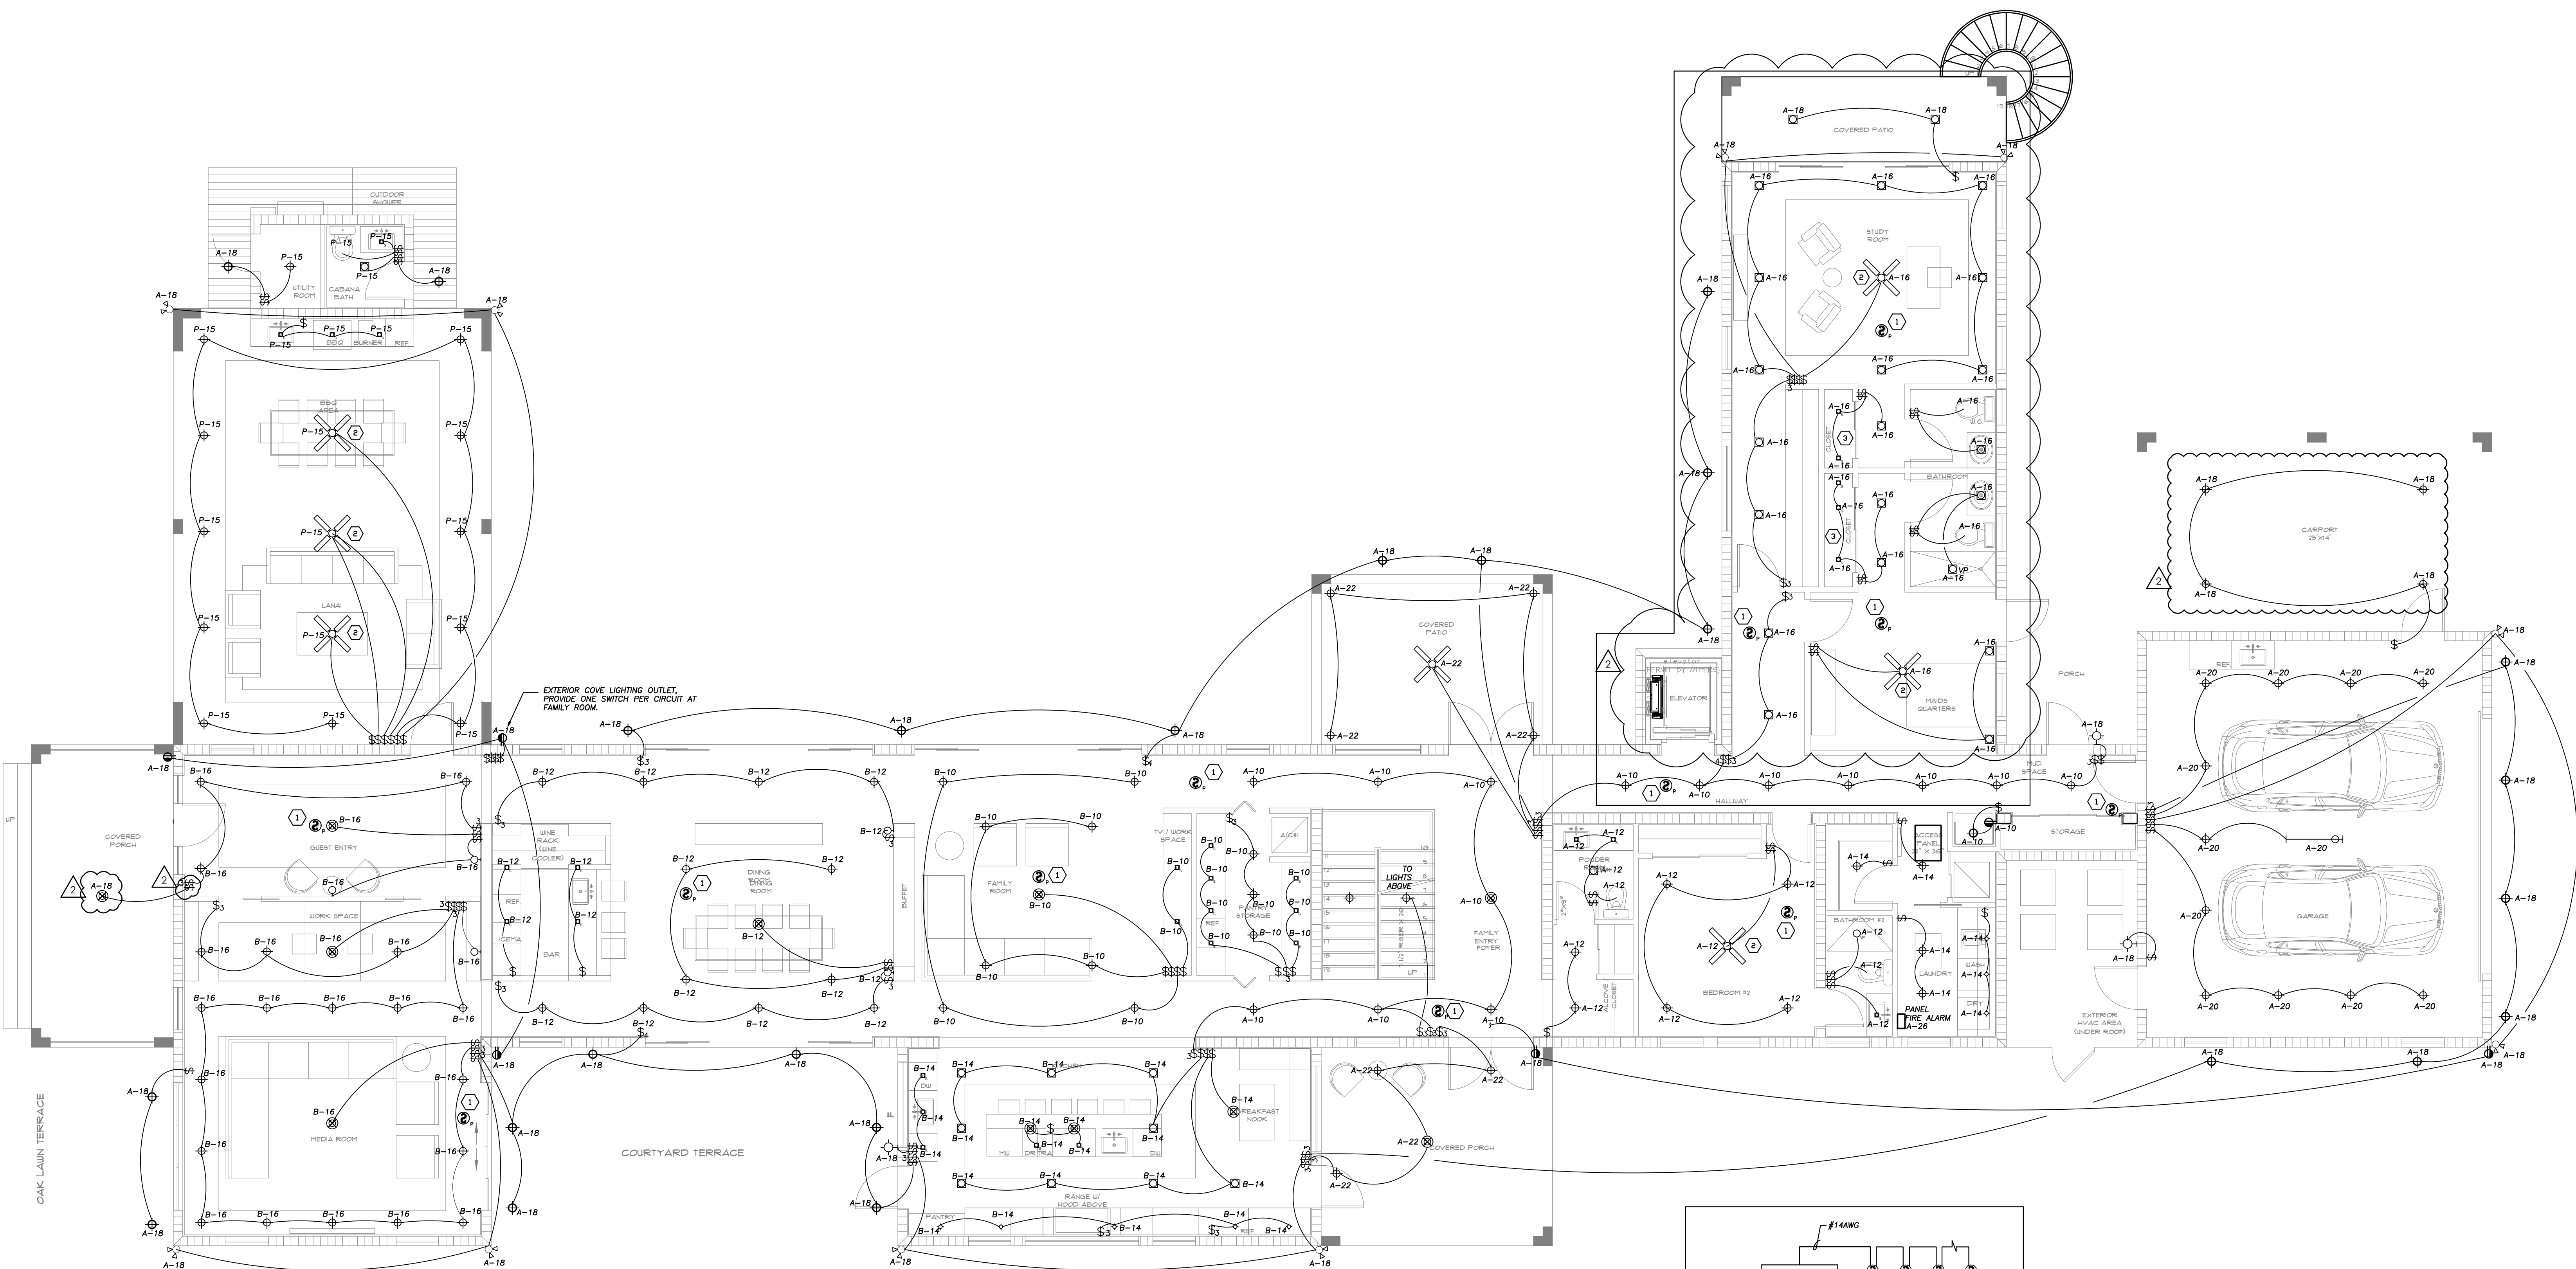

LIGHTING FIRST FLOOR PLAN
SCALE: 3/16" = 1'-0"

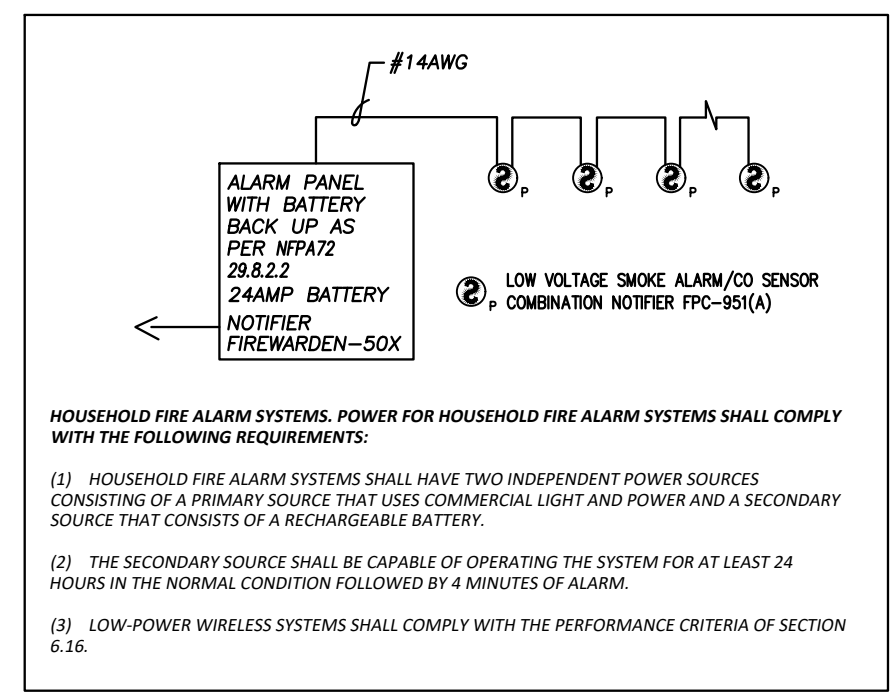

HOUSEHOLD FIRE ALARM SYSTEMS. POWER FOR HOUSEHOLD FIRE ALARM SYSTEMS SHALL COMPLY WITH THE FOLLOWING REQUIREMENTS:

(1) HOUSEHOLD FIRE ALARM SYSTEMS SHALL HAVE TWO INDEPENDENT POWER SOURCES CONSISTING OF A PRIMARY SOURCE THAT USES COMMERCIAL LIGHT AND POWER AND A SECONDARY SOURCE THAT CONSISTS OF A RECHARGEABLE BATTERY.

(2) THE SECONDARY SOURCE SHALL BE CAPABLE OF OPERATING THE SYSTEM FOR AT LEAST 24 HOURS IN THE NORMAL CONDITION FOLLOWED BY 4 MINUTES OF ALARM.

(3) LOW POWER WIRELESS SYSTEMS SHALL COMPLY WITH THE PERFORMANCE CRITERIA OF SECTION 6.8.

1 LOW VOLTAGE 24V SMOKE AND CARBON MONOXIDE ALARM COMBO. THIS CIRCUIT SHALL BE ARC FAULT PROTECTED. ALARMS SHALL BE INSTALLED A MINIMUM OF 3 FEET FROM ANY AIR SUPPLY OR RETURN AIR GRILL AND 3 FEET OF A DOOR TO A BATH CONTAINING A SHOWER OR TUB. CONTRACTOR SHALL VERIFY OPERATION OF ALL EXISTING SMOKE ALARMS AND REPLACE OR ADD AS NEEDED.