

REV.	DATE	DESCRIPTION
0	8/6/24	Issued for bidg dept review
1	8/26/25	City Comments
2	8/25/24	OWNER CHANGES

SHEET NO.	REV
P-1	0

NEW SHEET


arpe
engineering inc

2020 Ponce de Leon, Suite 1002
Coral Gables, Florida 33134
Phone > 305 444 9809
Fax > 305 444 9827

Engineering Design:
> Mechanical > Electrical
> Plumbing > Fire Protection
www.arpe-eng.com

Signature _____
Date _____

JOB # 22-1008
Amarilis Rodriguez, P.E.
License Number 60236
C.A. 2659

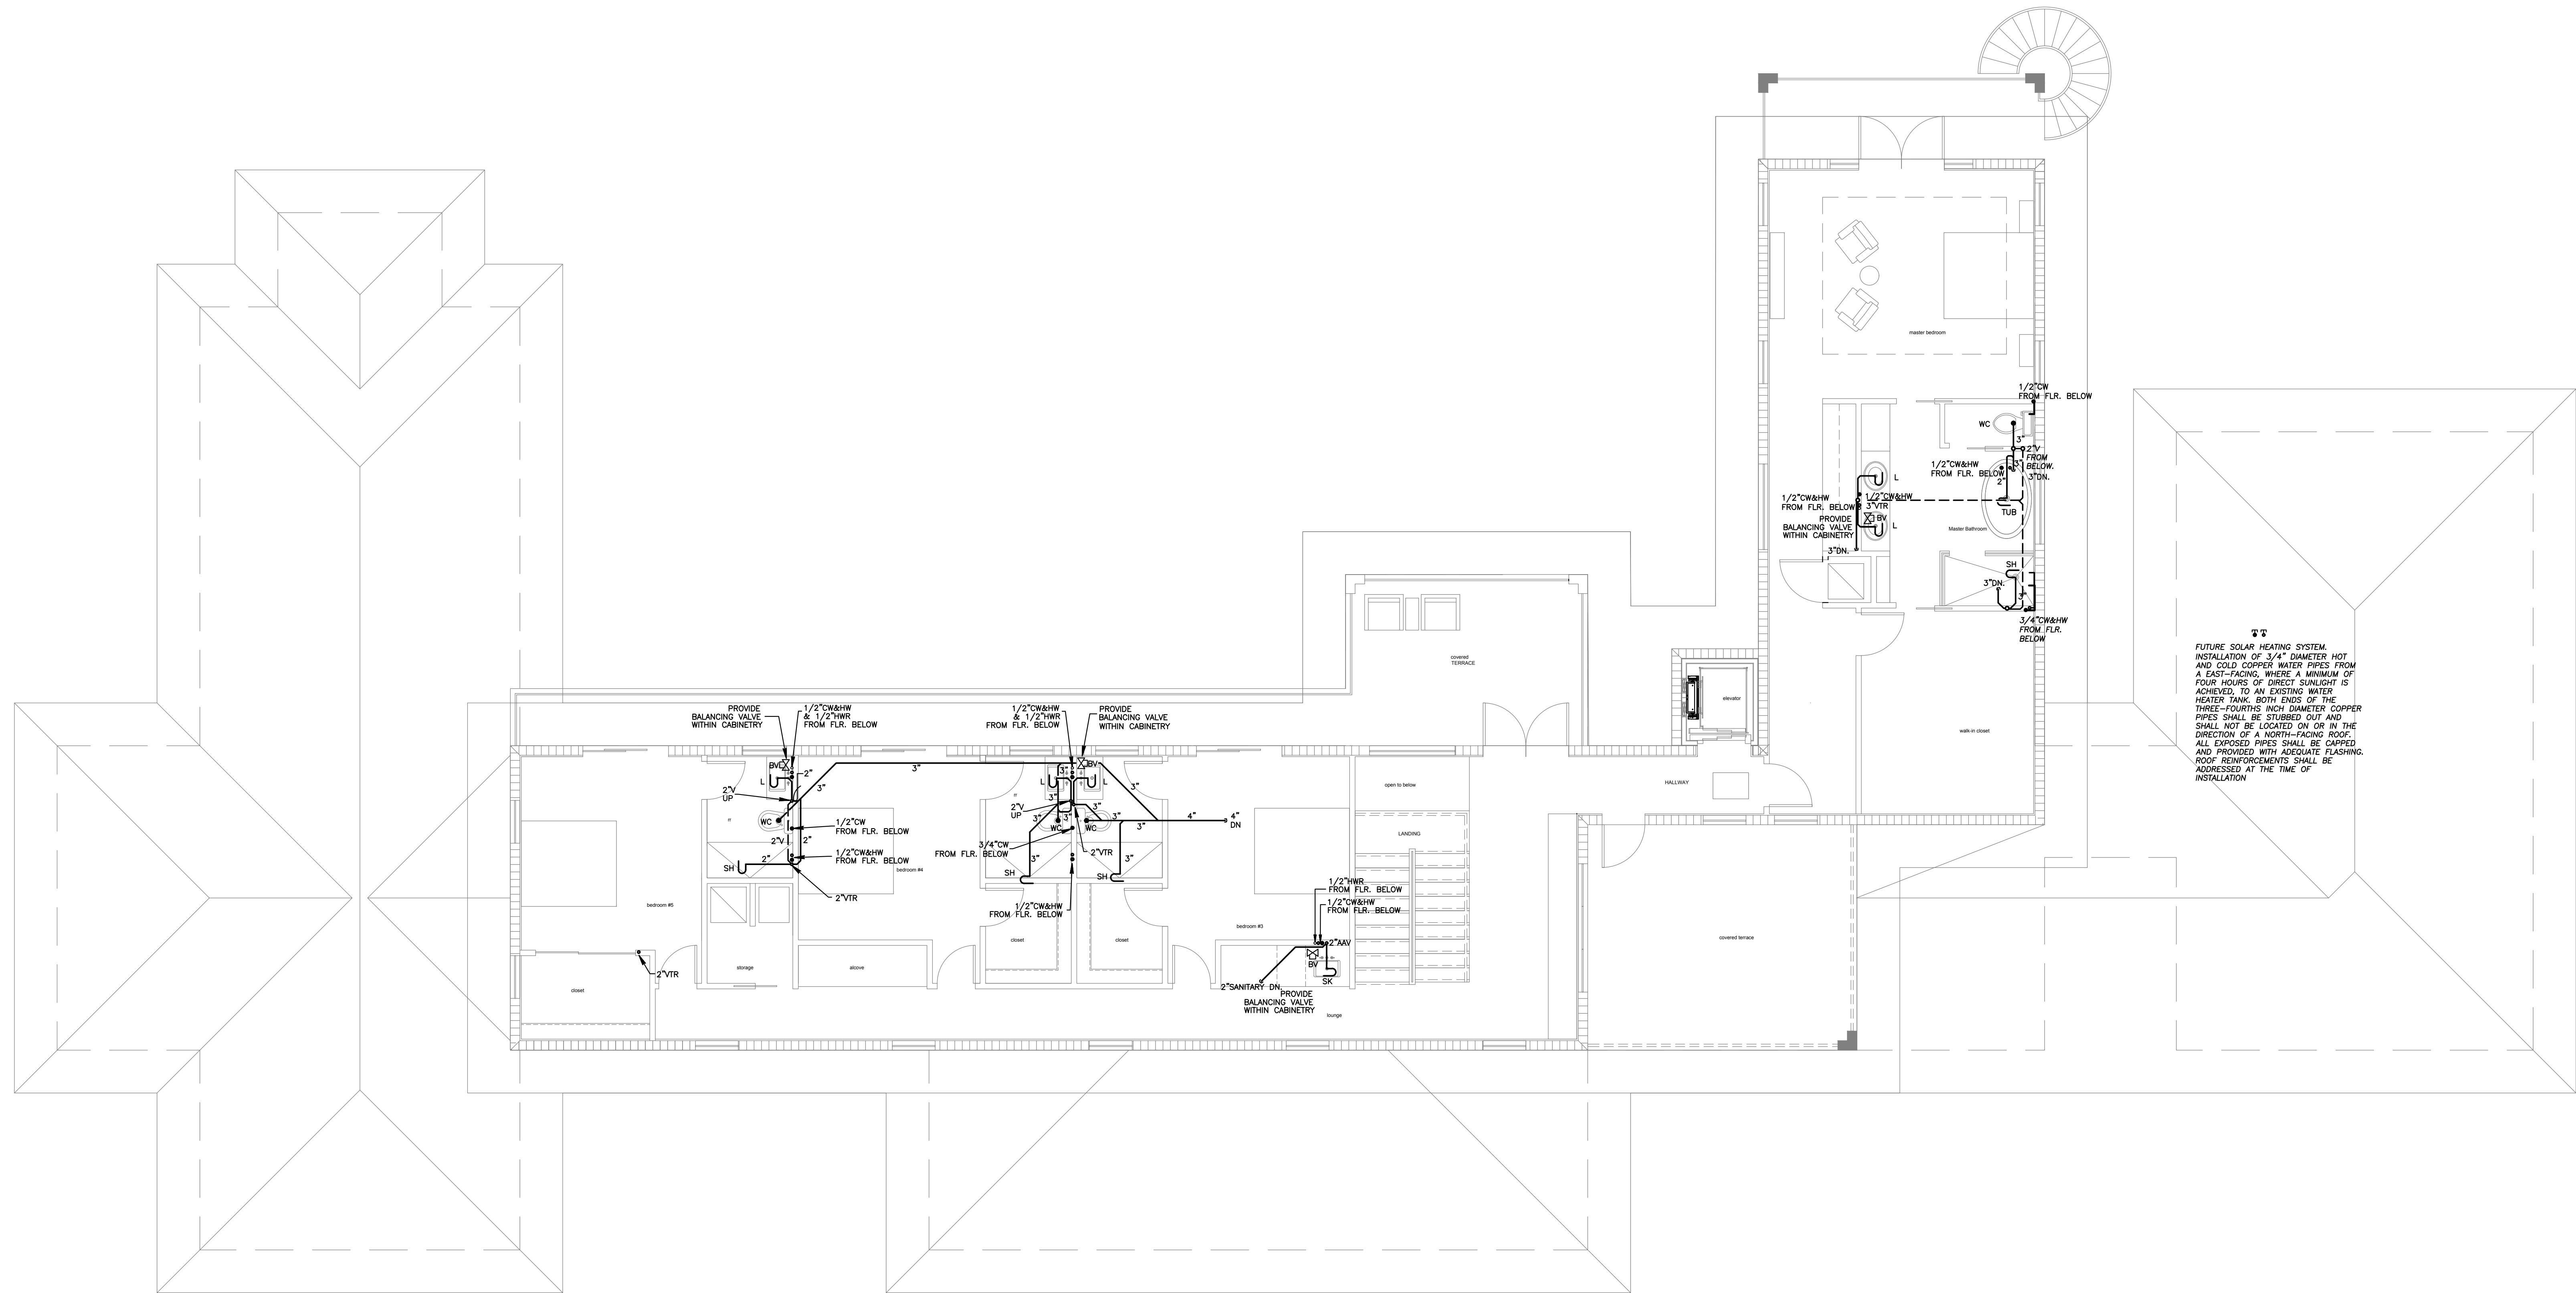

 **PROPOSED SECOND floor plan**
SCALE: 1/4" = 1'-0"