




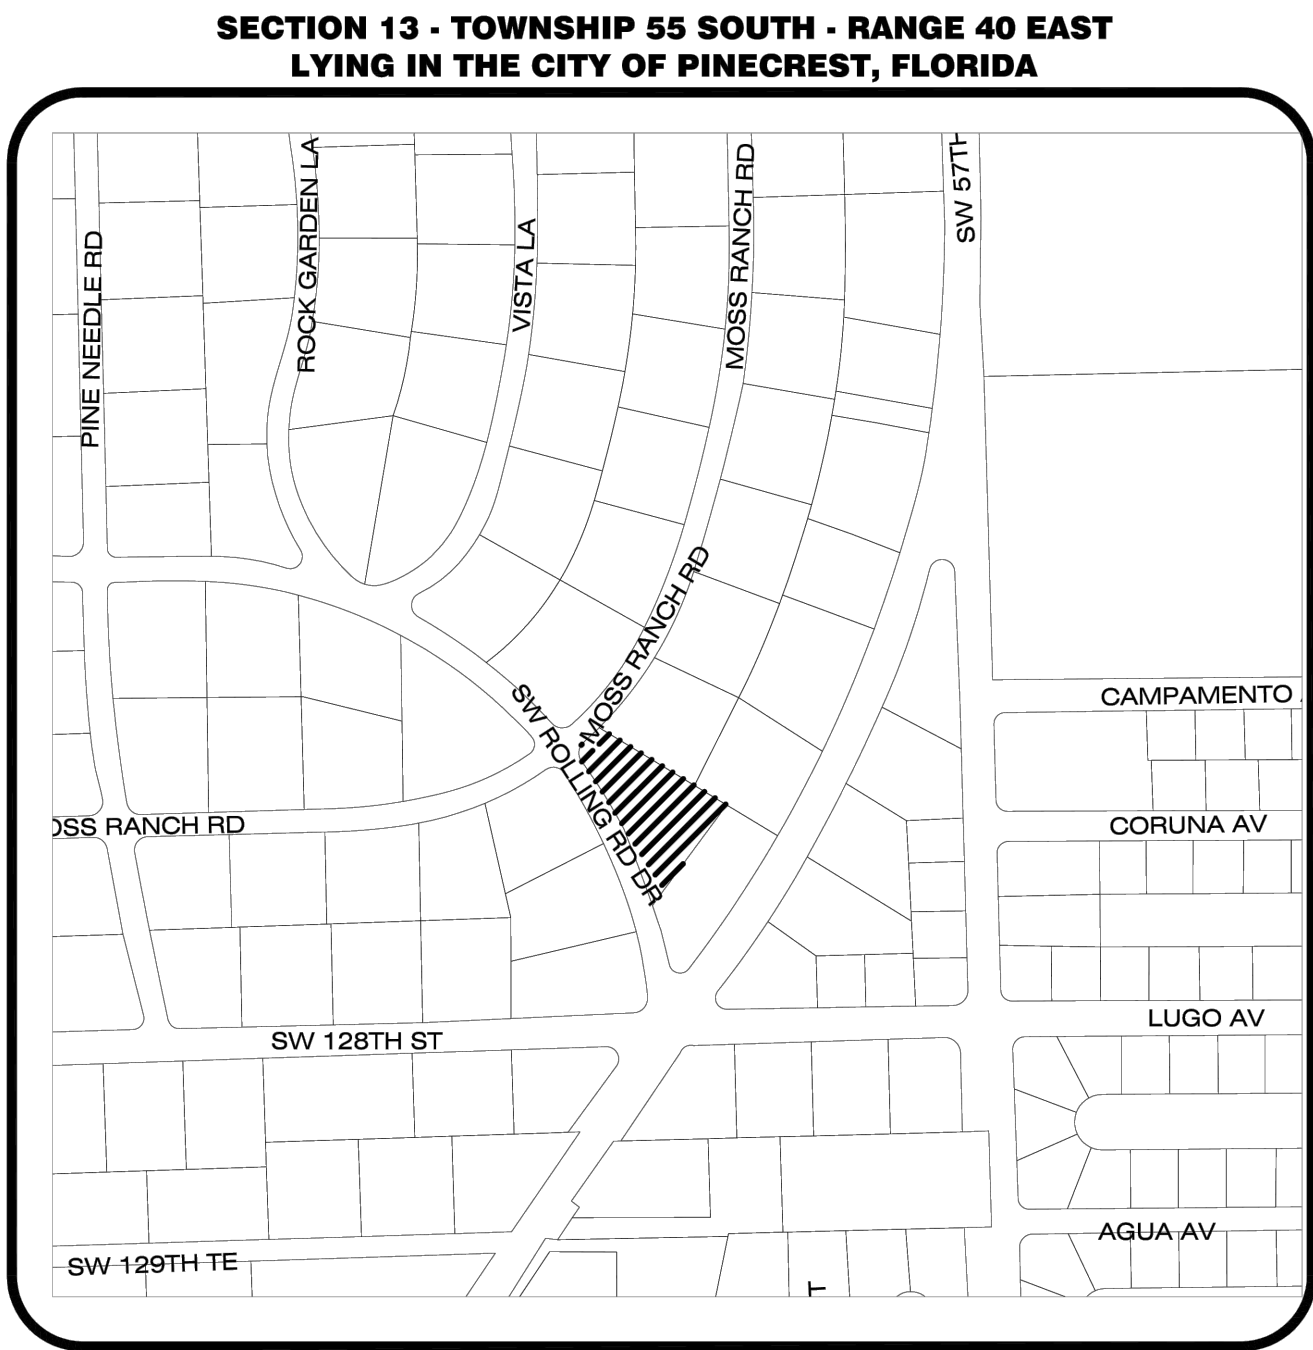

LOCATION MAP
(NOT TO SCALE)

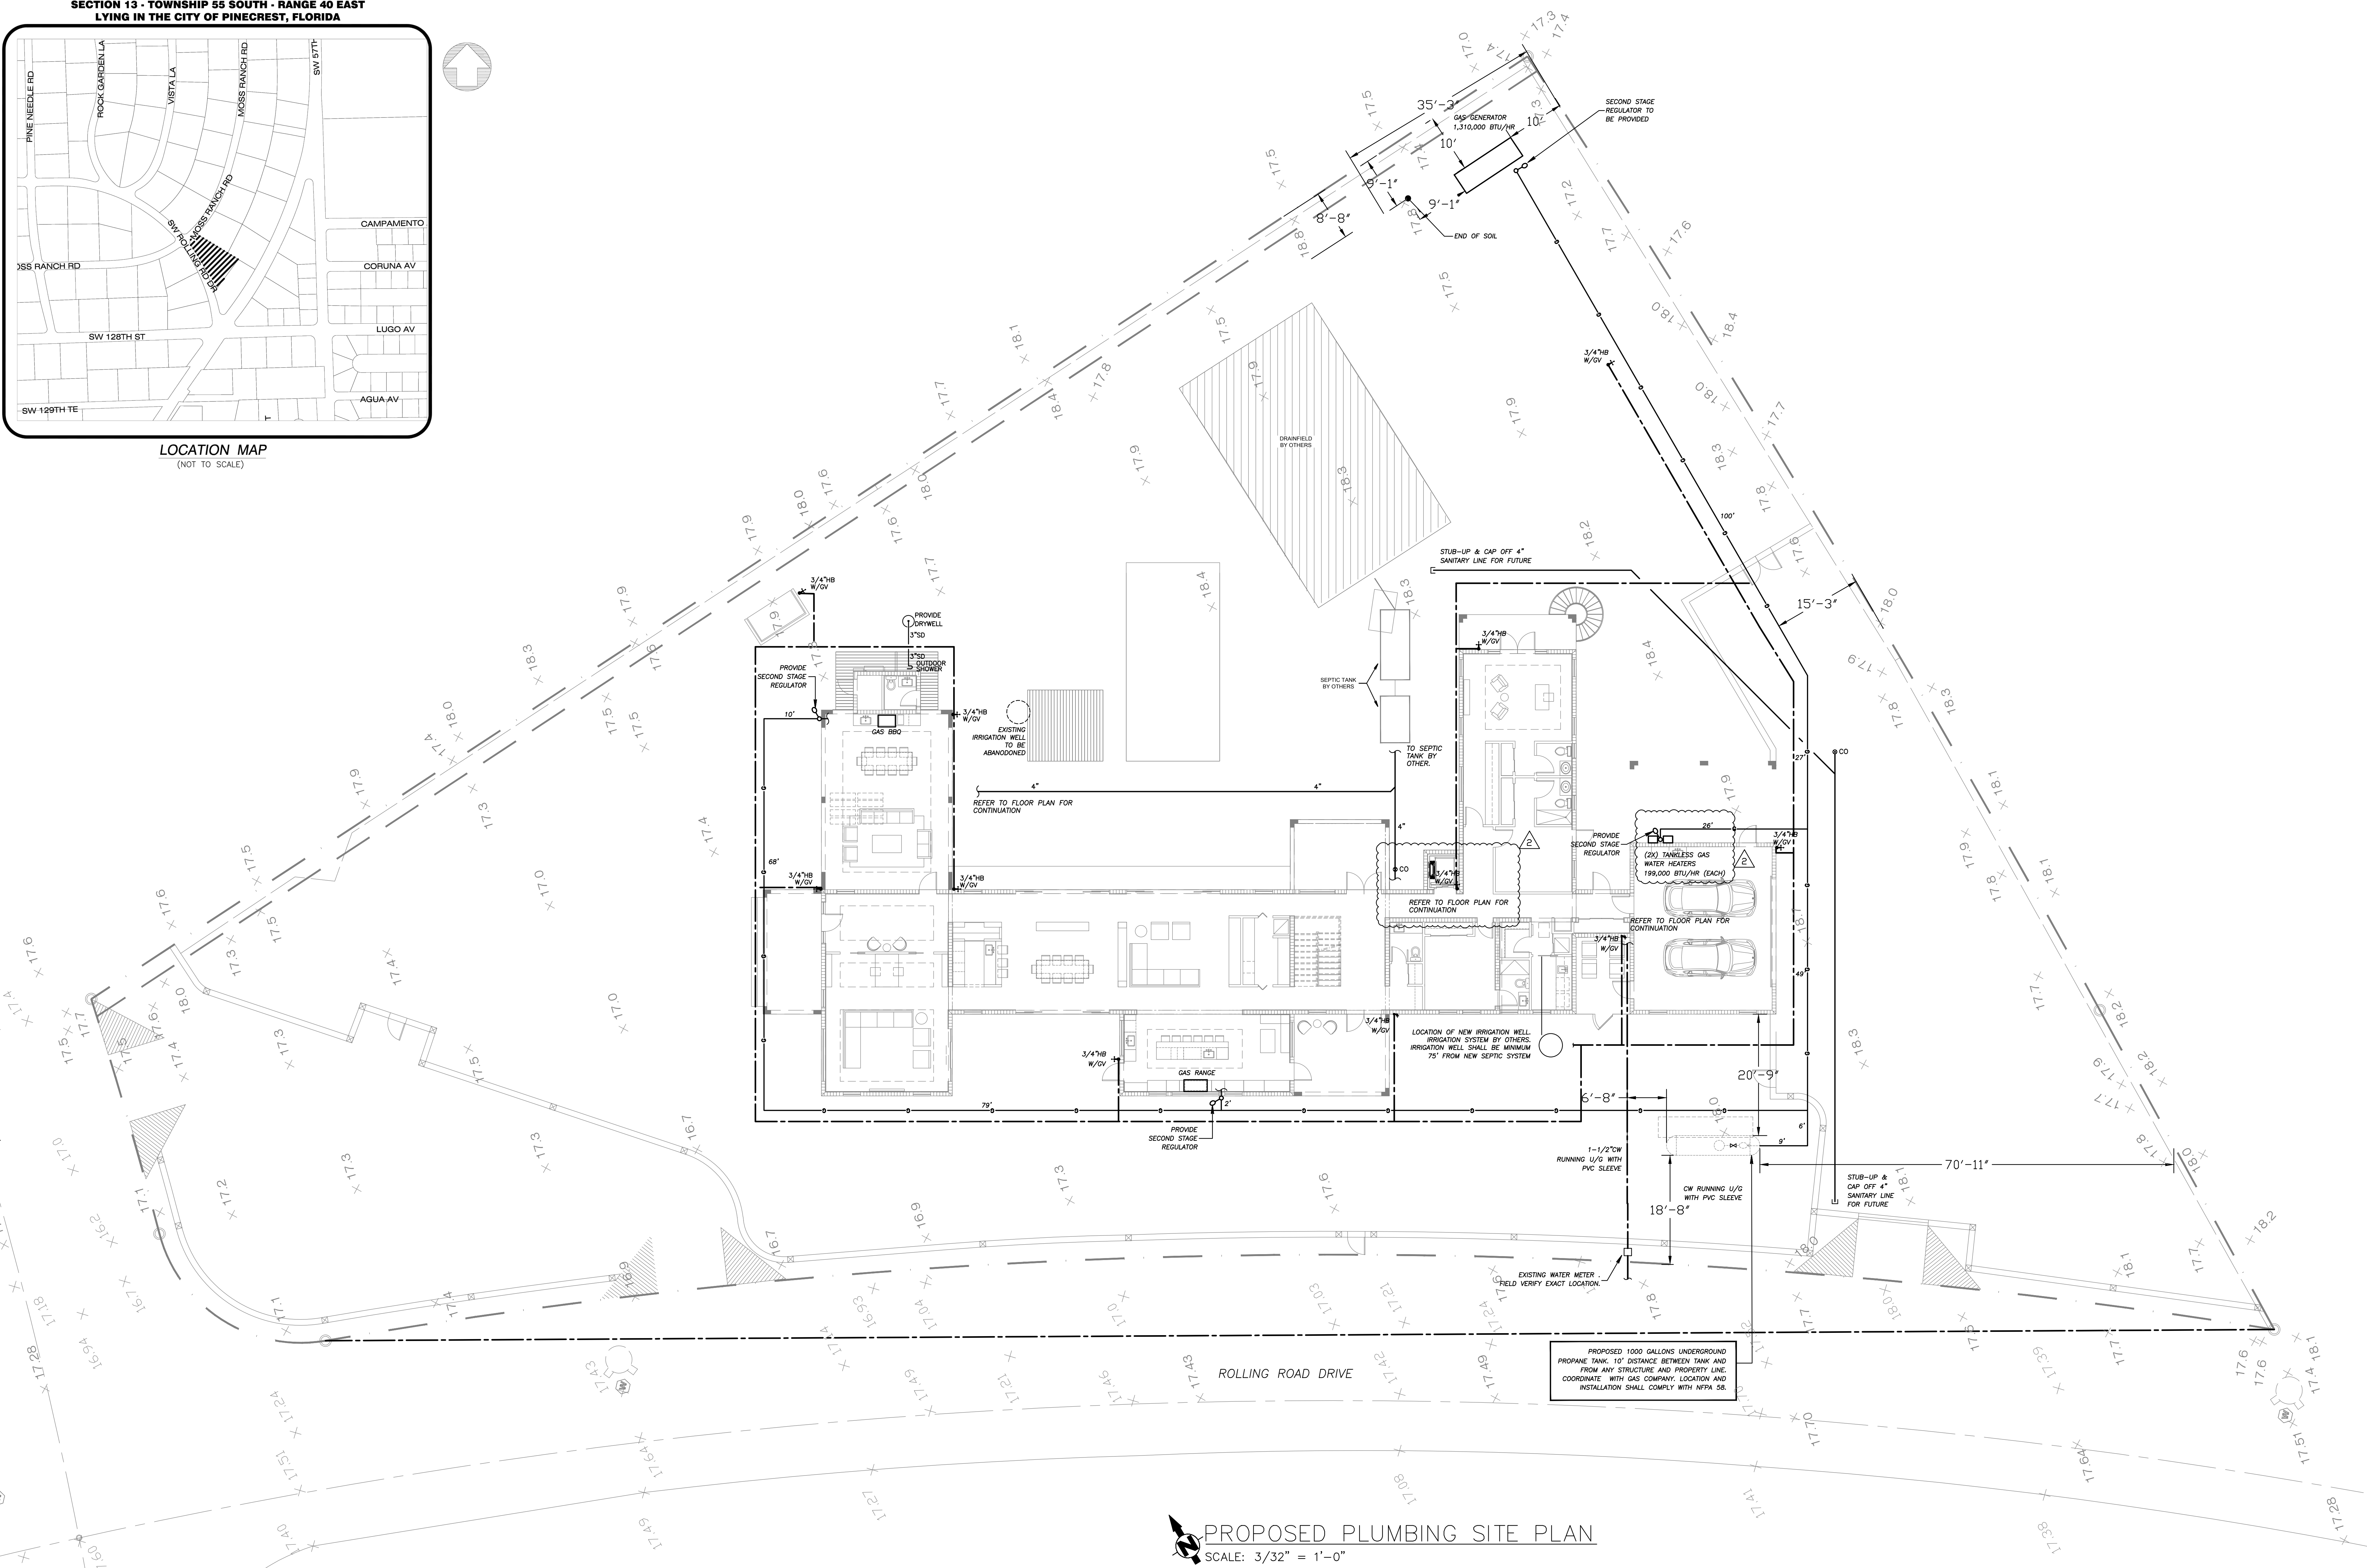

PROPOSED PLUMBING SITE PLAN
SCALE: 3/32" = 1'-0"

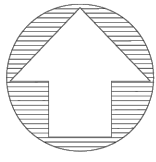

2020 Ponce de Leon, Suite 1002
Coral Gables, Florida 33134
Phone > 305.444.9809
Fax > 305.444.9827

Engineering Design
> Mechanical > Electrical
> Plumbing > Fire Protection
www.arpe-eng.com

JOB # 22-1008
Amarilis Rodriguez, P.E.
License Number 60236
C.A. 2659

Signature _____
Date _____



castro residence

PLUMBING SITE PLAN

12715 Rolling Road Drive
Pinecrest, FL 33156

SEAL	
PREPARED BY: sy	
CHECKED BY: NAC	
REV	DATE
0	8/6/24
2	8/7/24
OWNER CHANGES	
SCALE: AS SHOWN	
JOB NO.: 22-PRO-0028	
SHEET NO.	REV
PS-1	0