


CASTRO RESIDENCE

SECOND FLOOR
REFLECTED CEILING PLAN

12715 ROLLING ROAD DRIVE
PINECREST, FL 33156

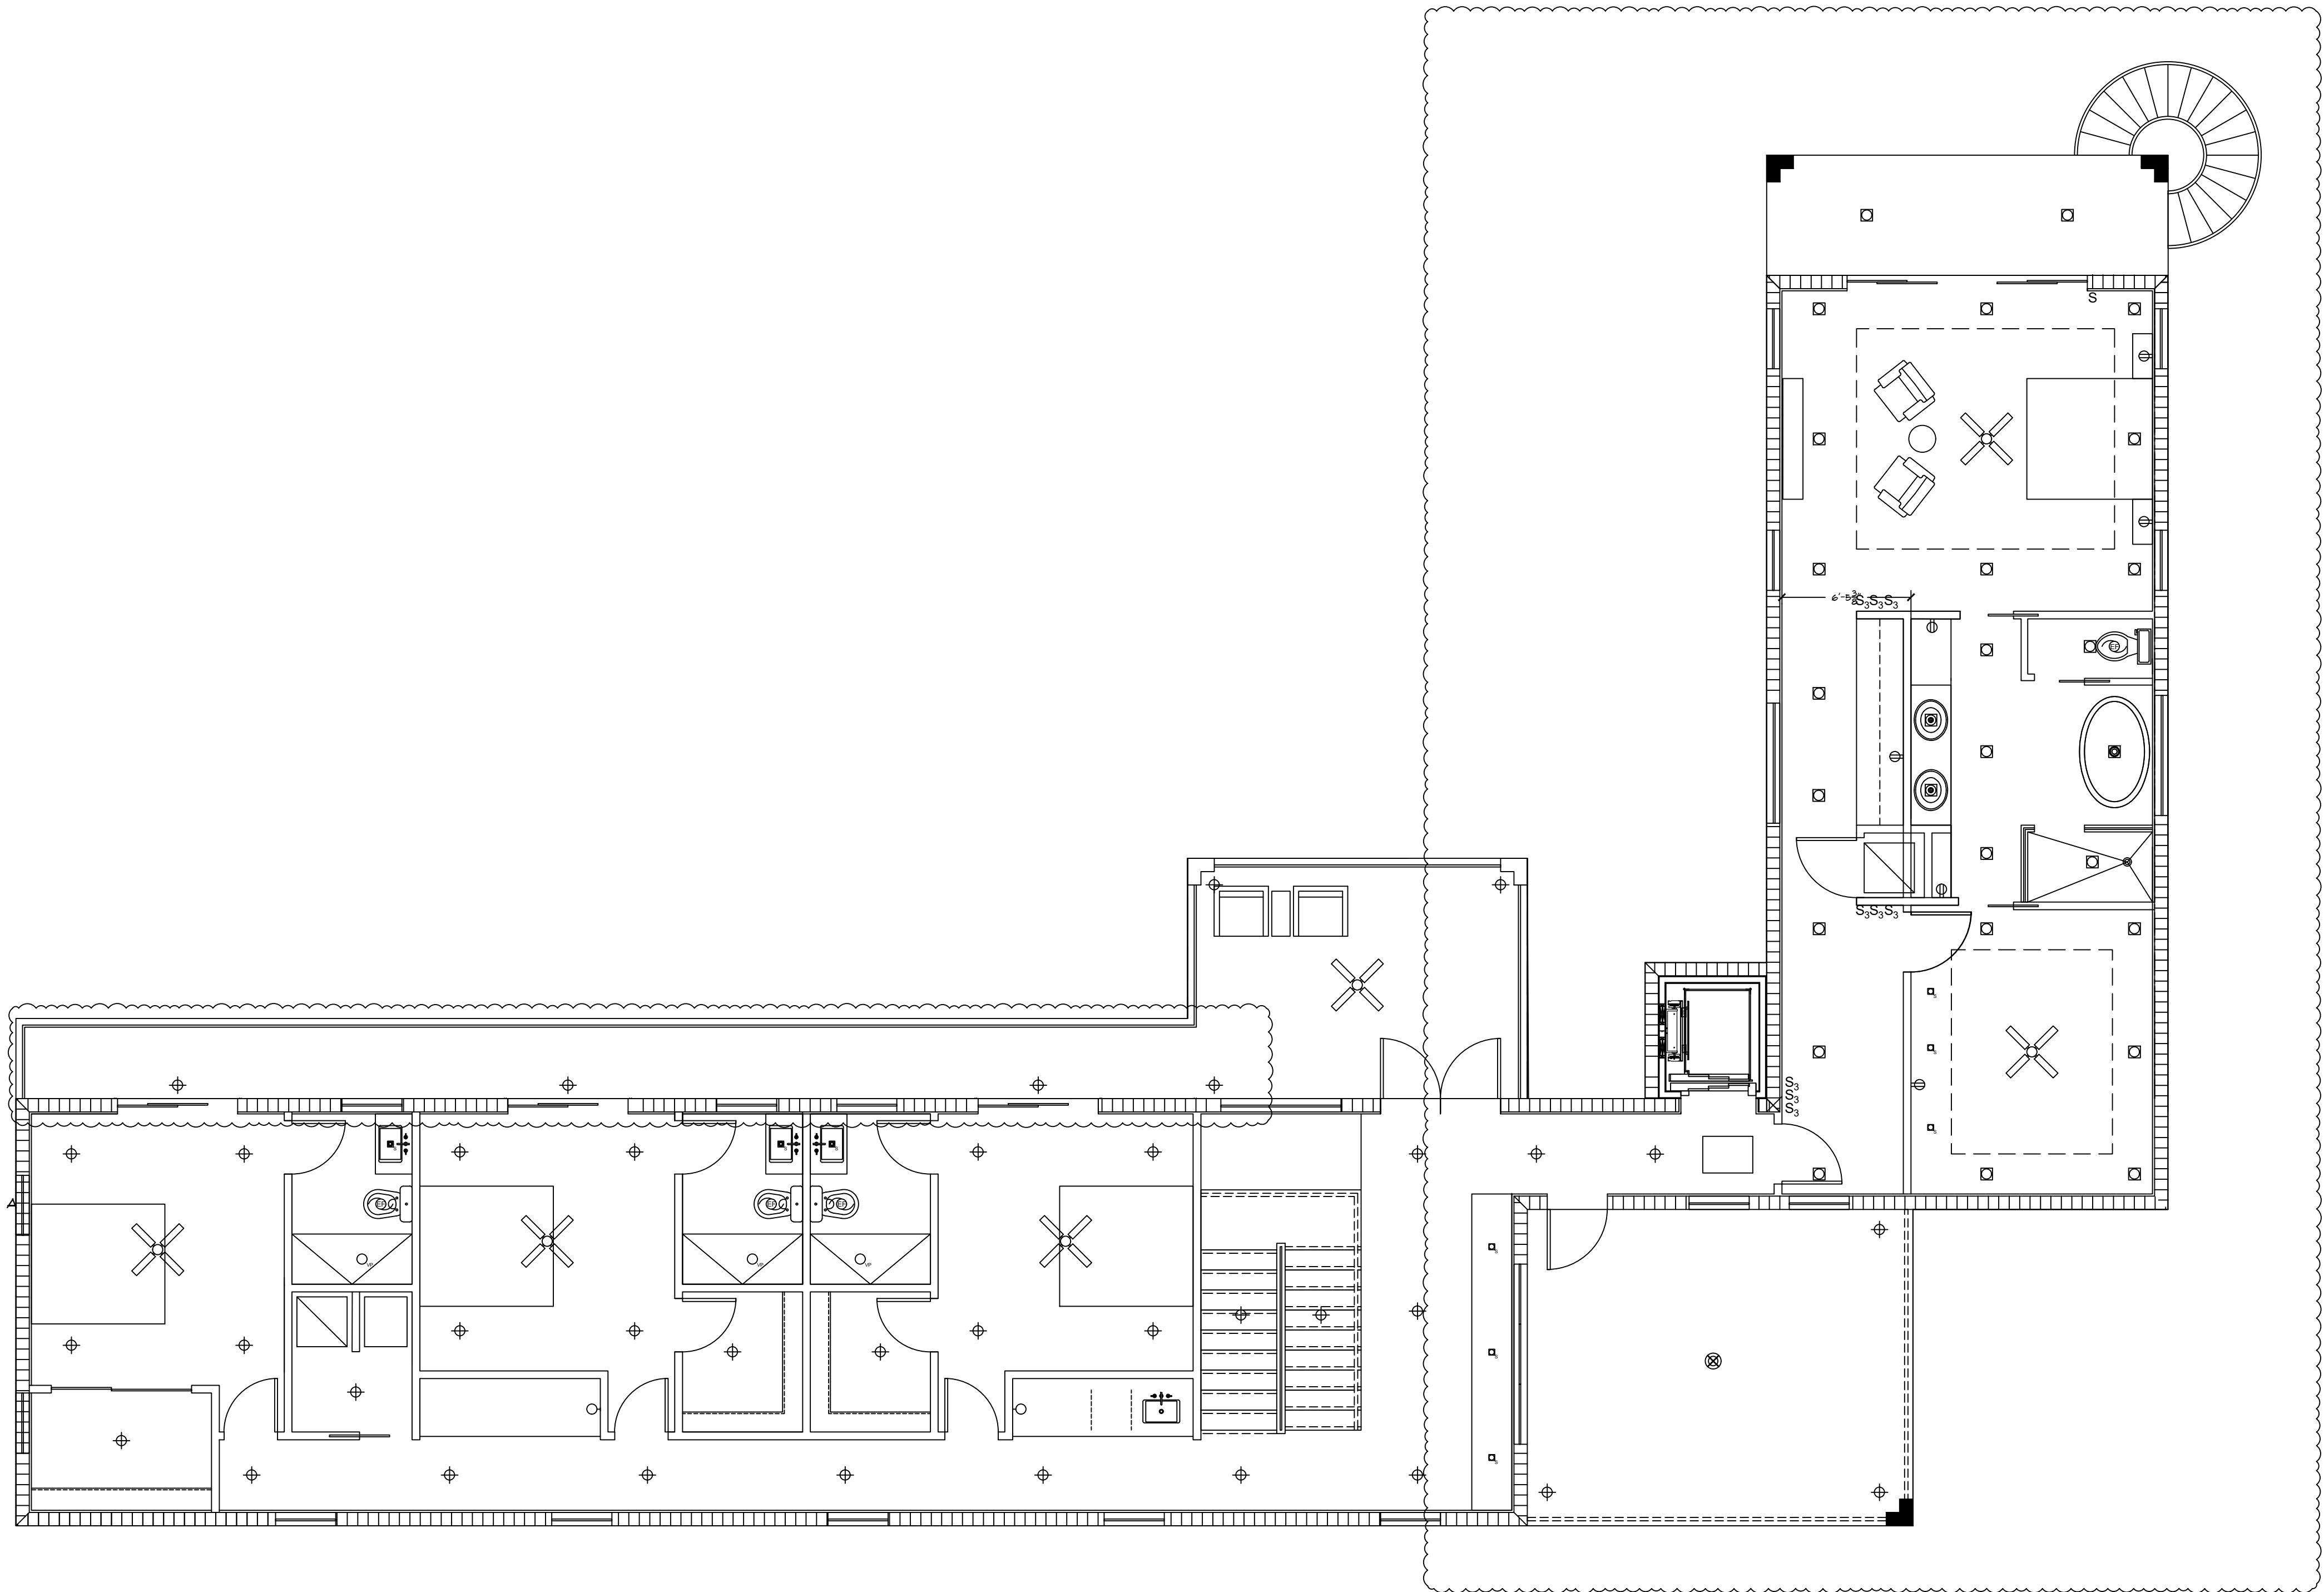

LEGEND	
⊕	CEILING FAN
⊕	UNDER CABINET LIGHTING FIXTURE
⊕	CLOSET LIGHT
⊕	RECESS LIGHT
⊕	WALL RECESS LIGHT
⊕	WALL FLOOR FAN
⊕	WALL FLOOR FAN
⊕	PERIMETER LIGHTING
⊕	CORNER/END DETECTOR
⊕	EXHAUST FAN
⊕	20W RECEPTACLE
⊕	WALL RECEPTACLE
⊕	UNDER CABINET RECEPTACLE
⊕	WALL SP RECEPTACLE
⊕	WATERPROOF RECEPTACLE
⊕	FLOOR FLOOR RECEPTACLE
⊕	CEILING FLOOR RECEPTACLE
⊕	FLUORESCENT LIGHT
⊕	SINGLE POLE SWITCH
⊕	3-WAY SWITCH
⊕	4-WAY SWITCH
⊕	DRYER SWITCH
⊕	CORNER
⊕	WIRELESS TELEPHONE
⊕	WIRELESS DOOR OPENER
⊕	DOOR CHIME
⊕	DOOR BELL
⊕	FLOOR LIGHT
⊕	CEILING FANLIGHT
⊕	ELECTRICAL PANEL
⊕	ELECTRICAL METER
⊕	ELECTRICAL DISCONNECT

PROPOSED SECOND FLOOR RCP
SCALE: 3/16" = 1'-0"

SEAL

PREPARED BY: SY

CHECKED BY: NAC

REV	DATE	DESCRIPTION
0	10/10	ISSUED FOR BIDDING
1	10/10	REVISED AS SHOWN

SCALE: AS SHOWN

JOB NO: 22-PRO-0020

SHEET NO.	REV
A-103.1	1