



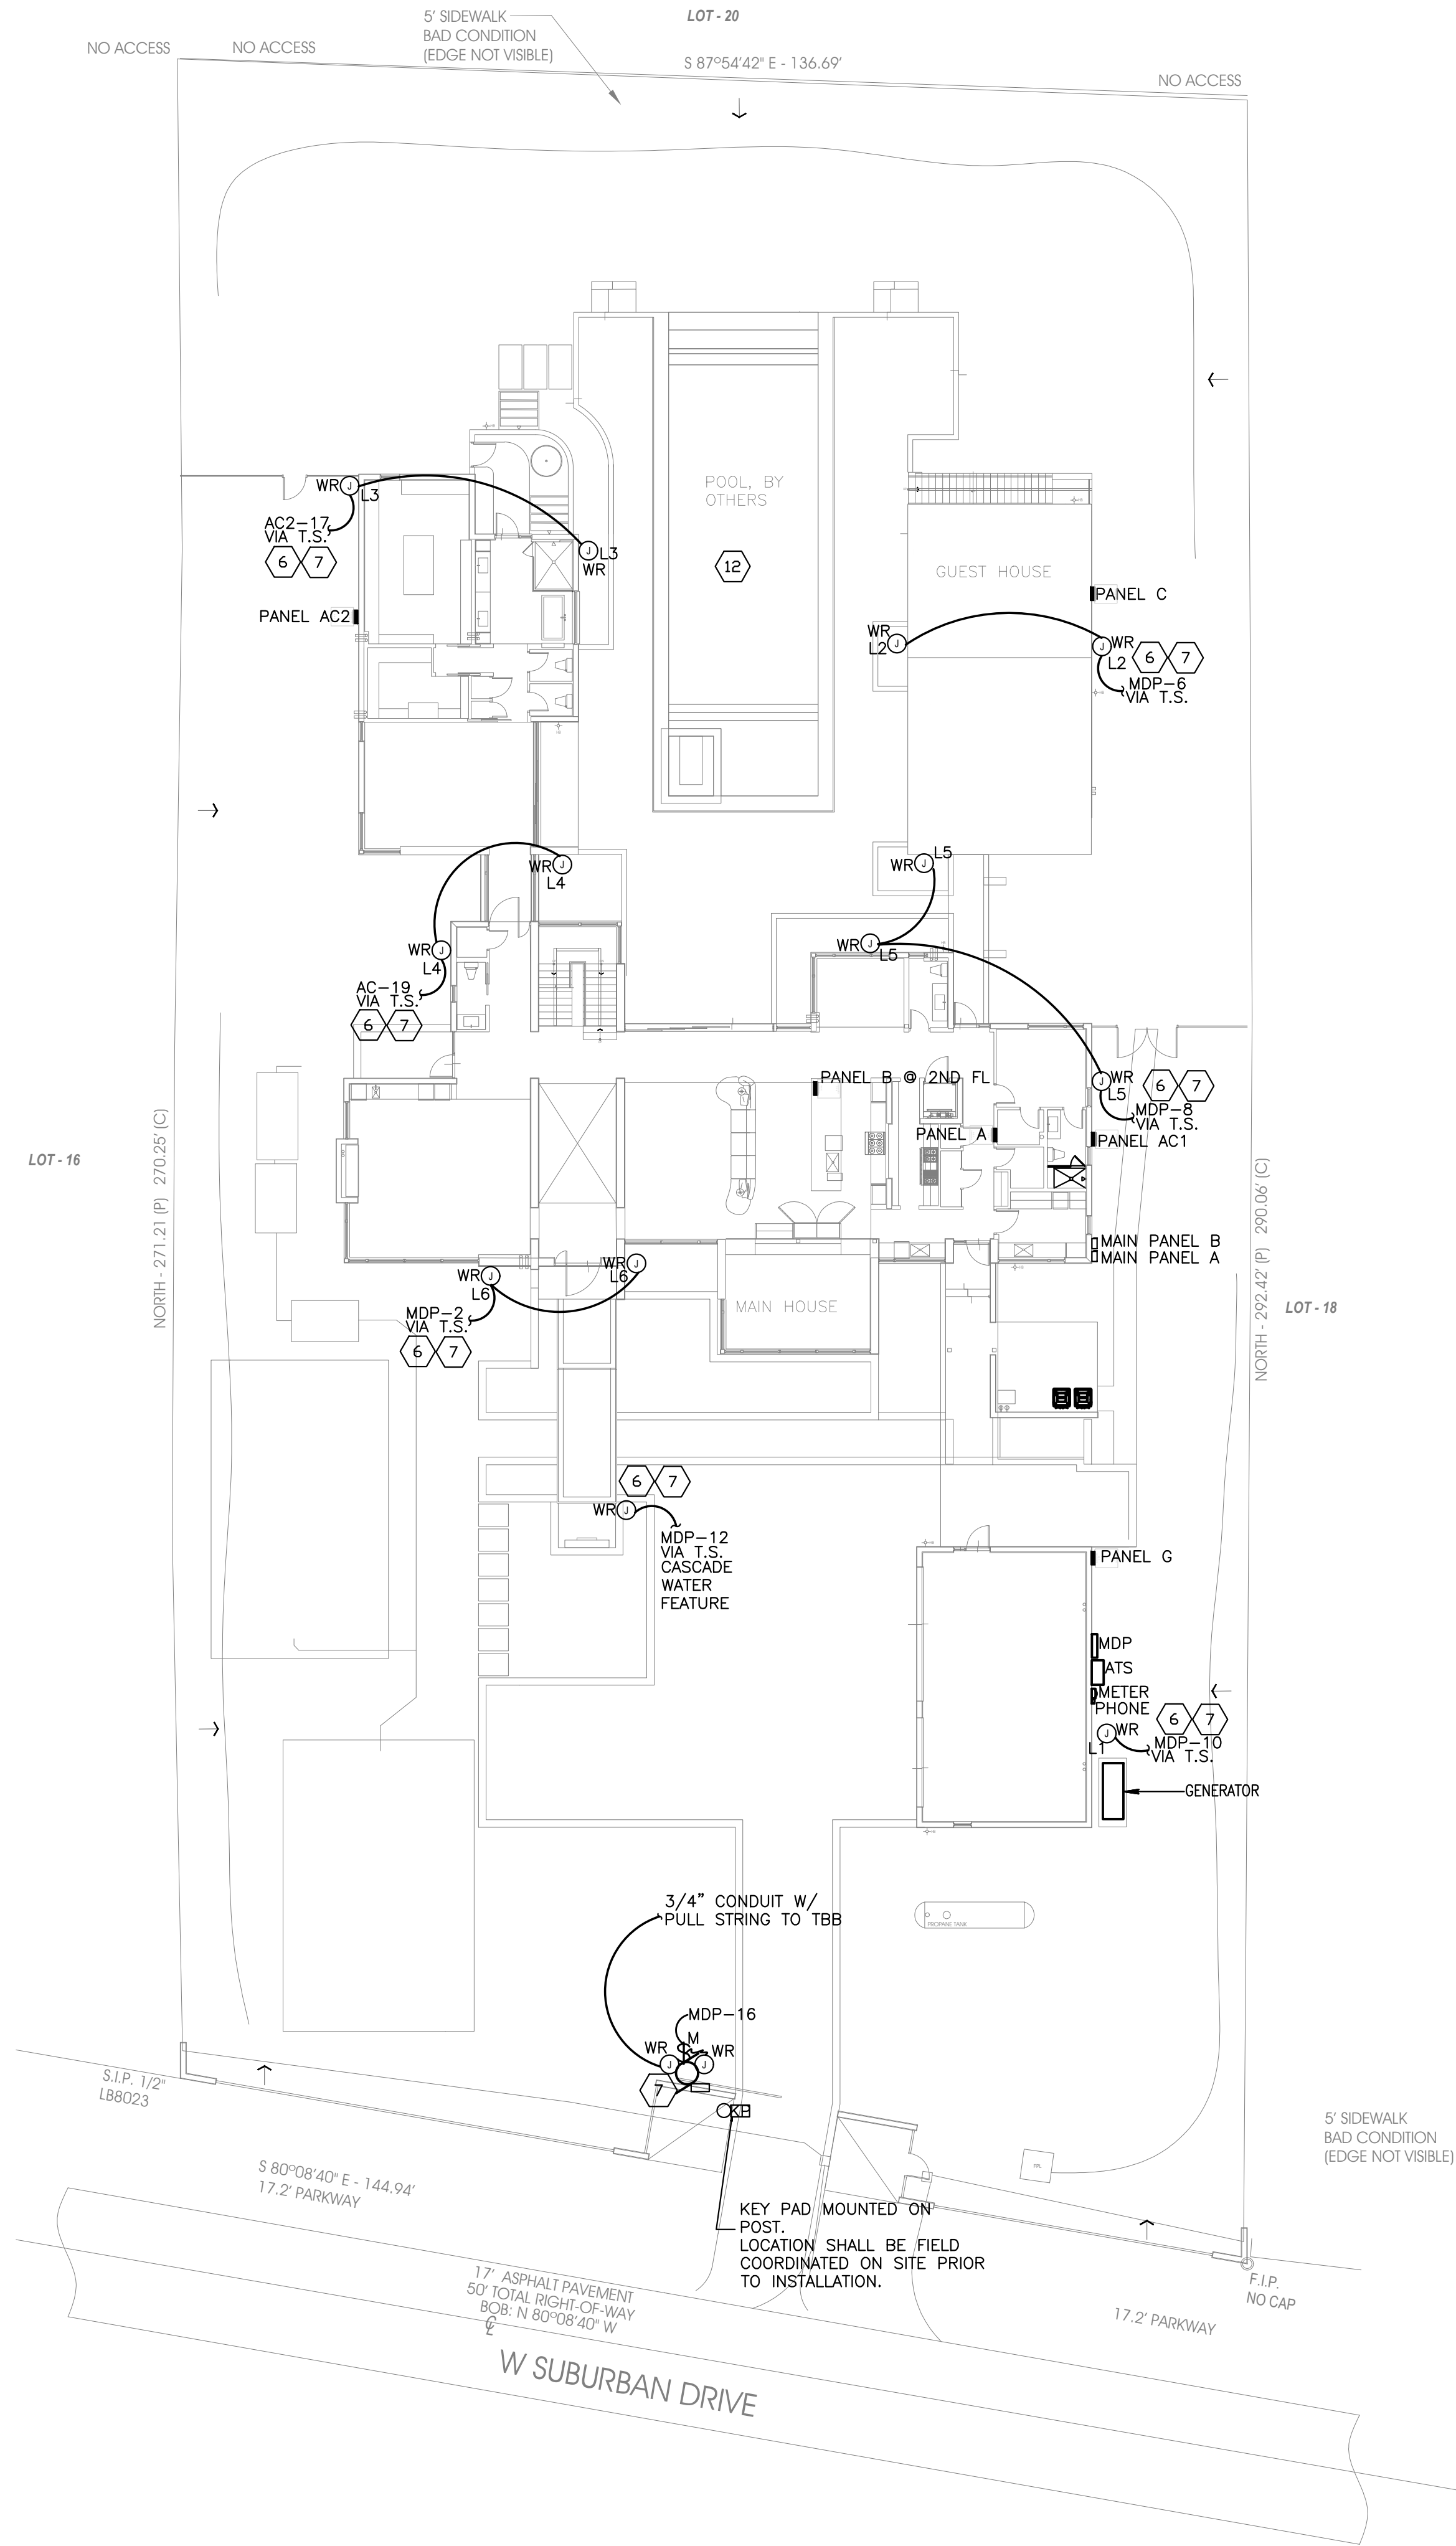

## ELECTRICAL SITE PLAN

SCALE: 1/16"=1'-0"

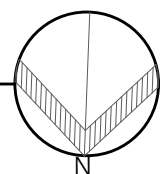

### ELECTRICAL CONSTRUCTION NOTES:

- 1 LOW VOLTAGE 24V SMOKE AND CARBON MONOXIDE ALARM COMBO. THIS CIRCUIT SHALL BE ARC FAULT PROTECTED. ALARMS SHALL BE INSTALLED A MINIMUM OF 3 FEET FROM ANY AIR SUPPLY OR RETURN AIR GRILL AND 3 FEET OF A DOOR TO A BATH CONTAINING A SHOWER OR TUB. CONTRACTOR SHALL VERIFY OPERATION OF ALL EXISTING SMOKE ALARMS AND REPLACE OR ADD AS NEEDED.
- 2 PROVIDE J BOX FOR CEILING FAN AT ALL CENTER LIGHT FIXTURE. TYPICAL ALL ROOMS.
- 3 LIGHT FIXTURES IN CLOSET SHALL NOT BE INSTALLED WITHIN 12" OF SHELF.
- 4 HOOD FAN COORDINATE MOUNTING PRIOR TO INSTALLATION.
- 5 CONTRACTOR SHALL COORDINATE ALL TELEPHONE AND CABLE TV OUTLET M.H. PRIOR TO INSTALLATION. TYPICAL ENTIRE HOUSE. WIRE ALL TELEPHONE OUTLETS WITH CAT 5.
- 6 CONTRACTOR SHALL COORDINATE WITH LANDSCAPE ARCH. FINAL LIGHTS LOCATION PRIOR TO INSTALLATION.
- 7 ALL OUTDOOR ELECTRICAL JB SHALL BE WEATHERPROOF NEMA 3X OR 4X IN COMPLIANCE WITH NEC 110.28 (CORROSIVE AGENTS)
- 8 TELEPHONE/DATA /CABLE TV. TERMINAL CABINET. CONTRACTOR SHALL RUN (2) 1 1/2" CONDUIT TO UTILITY EASEMENT AND COORDINATE WITH UTILITY COMPANIES PRIOR TO BIDDING.
- 9 ALL ELECTRICAL EQUIPMENT SHALL BE INSTALLED ABOVE FLOOD LEVEL, TYPICAL.
- 10 ELECTRICAL SERVICE LOCATION. CONTRACTOR SHALL COORDINATE WITH FPL ALL REQUIREMENTS PRIOR TO BIDDING. REFER TO RISER DIAGRAM FOR SERVICE CONDUCTOR SIZES.
- 11 RUN A SEPARATE HOME RUN FROM EACH DATA, CABLE AND TELEPHONE OUTLET TO TELEPHONE/CABLE BOARD.
- 12 POOL UNDER SEPARATE PERMIT. ELECTRICAL CONTRACTOR SHALL COORDINATE WITH POOL CONTRACTOR POWER REQUIREMENTS AND PROVIDE CB ACCORDINGLY AT PANEL P.
- 13 COORDINATE MOUNTING HEIGHT WITH WINDOW AND BASE BOARD. TYPICAL ALL WALL OUTLETS.
- 14 TO REAR LANDSCAPE LIGHTS. COORDINATE WITH LANDSCAPE DRAWING EXACT LOCATION PRIOR TO BIDDING. PROVIDE ONE SWITCH PER LANDSCAPE CIRCUIT.
- 15 TO FRONT LANDSCAPE LIGHTS. COORDINATE WITH LANDSCAPE DRAWING EXACT LOCATION PRIOR TO BIDDING. PROVIDE ONE SWITCH PER CIRCUIT.

This item has been digitally signed and sealed by Amarilis Rodriguez, PE, on  
Printed copies of this document are not considered signed and  
sealed and the signature must be verified on any electronic copies. JOB# 24-0407



2020 Ponce de Leon Blvd., Suite 1002  
Coral Gables, Florida 33134  
Phone > 305 444 9809  
Fax > 305 444 9827

Engineering Design:  
> Mechanical > Electrical  
> Plumbing > Fire Protection  
www.arpe-eng.com

Amarilis Rodriguez, P.E.  
License Number 60236  
C.A. 26359

Signature \_\_\_\_\_  
Date \_\_\_\_\_

### NOTES



500 South Dixie Highway, Suite 307  
Coral Gables, Florida 33146  
Tel: (305) 740-0120  
Email: locus@locusarchitecture.net  
License: AR 13937

### CONSULTANT(S)

| NO. | REVISION/SUBMISSION | DATE     |
|-----|---------------------|----------|
|     | OWNER REVIEW        | 03-11-24 |
|     | PERMIT SUBMITTAL    | 06-07-24 |

### PROJECT

**New 2-Story Residence:**  
6100 W Suburban Dr., Pinecrest, FL  
33156

### DRAWING

**Electrical  
Site Plan**

### SEAL

SCALE  
As Shown

### DRAWN

MM

### REVIEWED

AR

Nelson de Leon  
AR 13937

PROJ. NO.  
351

### SHEET NO.

**E-01.0**