

04



04

04  
03

04  
03

POWER PARTIAL SECOND FLOOR PLAN: 04

SCALE: 1/4" = 1'-0"

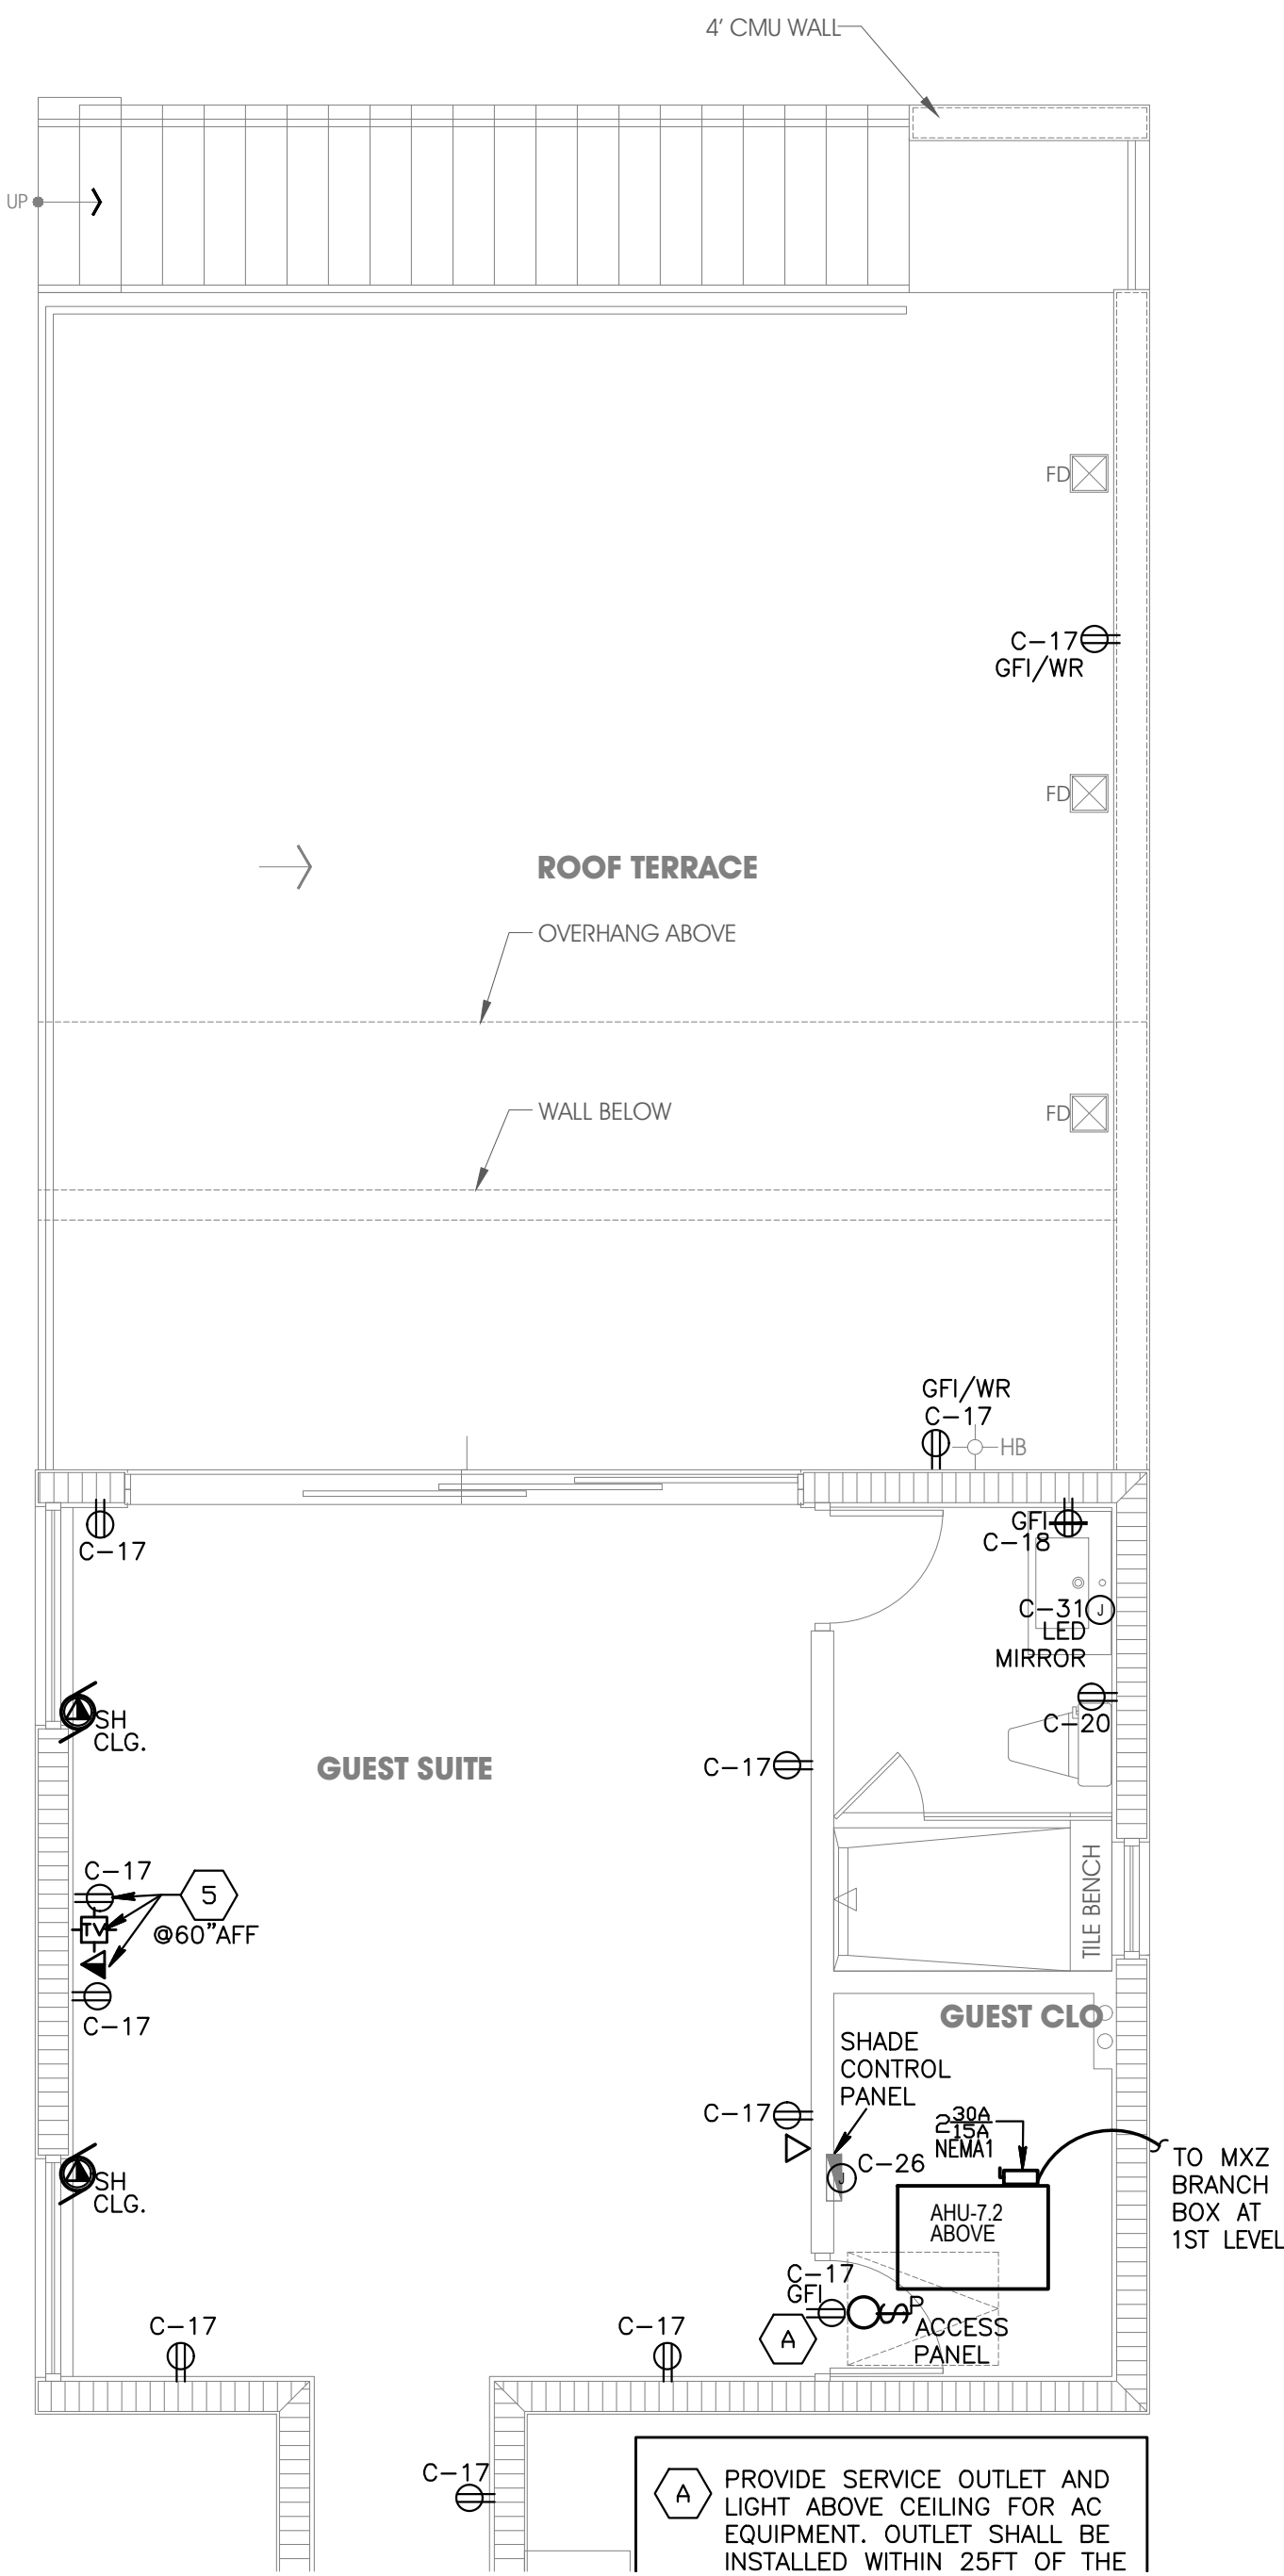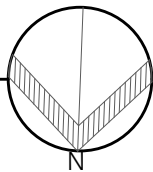

This item has been digitally signed and sealed by Amarilis Rodriguez, P.E. on  
Printed copies of this document are not considered signed and  
sealed and the signature must be verified on any electronic copies.

JOB# 24-0407

**arpe**  
engineering inc


2020 Ponce de Leon Blvd., Suite 1002  
Coral Gables, Florida 33134  
Phone > 305 444 9809  
Fax > 305 444 9827

Engineering Design:  
> Mechanical > Electrical  
> Plumbing > Fire Protection  
[www.arpe-eng.com](http://www.arpe-eng.com)

Amarilis Rodriguez, P.E.  
License Number 60236  
C.A. 26359

Signature \_\_\_\_\_  
Date \_\_\_\_\_

NOTES

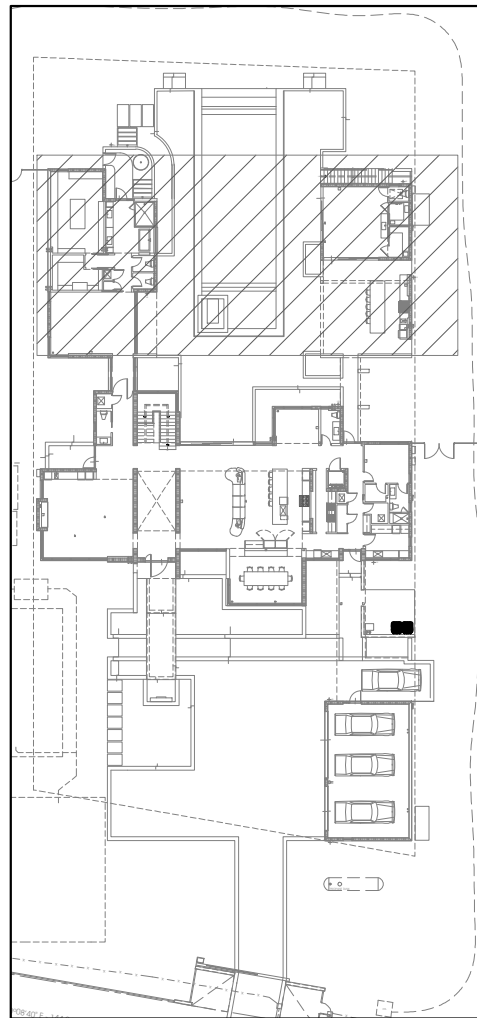

KEY PLAN

SCALE: NTS

**LOCUS**  
ARCHITECTURE  
INCORPORATED

500 South Dixie Highway, Suite 307  
Coral Gables, Florida 33146  
Tel: (305) 740-0120  
Email: locus@locusarchitecture.net  
License: AR 13937

CONSULTANT(S)

| NO. | REVISION/SUBMISSION | DATE     |
|-----|---------------------|----------|
|     | OWNER REVIEW        | 03-11-24 |
|     | PERMIT SUBMITTAL    | 06-07-24 |

PROJECT

**New 2-Story Residence:**  
6100 W Suburban Dr., Pinecrest, FL  
33156

DRAWING

Power PartialSecond Floor Plan: 04

SEAL

SCALE

As Shown

DRAWN

REVIEWED

Nelson de Leon  
AR 13937

PROJ. NO.  
351

SHEET NO.

**E-02.5**