


04
03

04
03

NOTES

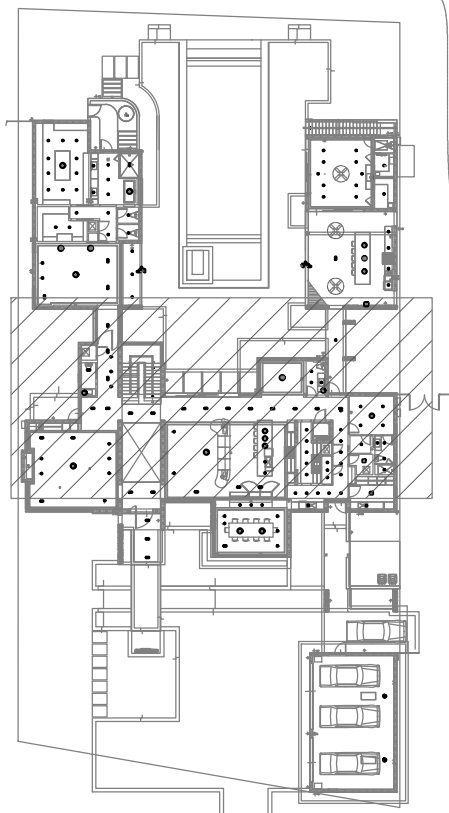

KEY PLAN

SCALE: 1/4" = 1'-0"

LOCUS
ARCHITECTURE
INCORPORATED

500 South Dixie Highway, Suite 307
Coral Gables, Florida 33146
Tel: (305) 740-0120
Email: locus@locusarchitecture.net
License: AR 13937

CONSULTANT(S)

NO.	REVISION/SUBMISSION	DATE
	OWNER REVIEW	03-11-24
	PERMIT SUBMITTAL	06-07-24

PROJECT

New 2-Story Residence:
6100 W Suburban Dr. Pinecrest,
FL 33156

DRAWING

Partial First Reflected
Mechanical Plan: 03

SEAL

SCALE

As Shown

DRAWN

REVIEWED

Nelson de
Leon
AR 13937

PROJ. NO.

351

SHEET NO.

M-01.2

03
02

03
02


8" DIAMETER
INTAKE VENT WITH
5" DIAMETER
FLUE INSIDE UP.

NOTE:
PLEASE REFER TO KEY NOTES IN M-1.1

NOTE:
APPLIANCES MUST BE LISTED AND
LABELED FOR HOUSEHOLD USE AND
SHALL BE INSTALLED ACCORDING TO
INSTRUCTIONS FROM MANUFACTURER.
A MANUAL OF INSTRUCTIONS SHALL
BE AVAILABLE DURING INSPECTION
FBC-R M1901.2

PARTIAL FIRST RCP: 03

SCALE: 1/4" = 1'-0"

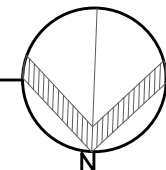

This item has been digitally signed and sealed by Amarilis Rodriguez, P.E. on
Printed copies of this document are not considered signed and
sealed and the signature must be verified on any electronic copies.

JOB# 24-0407

arpe
engineering inc

2020 Ponce de Leon Blvd., Suite 1002
Coral Gables, Florida 33134
Phone > 305 444 8809
Fax > 305 444 9827

Engineering Design:
> Mechanical > Electrical
> Plumbing > Fire Protection
www.arpe-eng.com

Amarilis Rodriguez, P.E.
License Number 60236
C.A. 26359

Signature _____
Date _____