



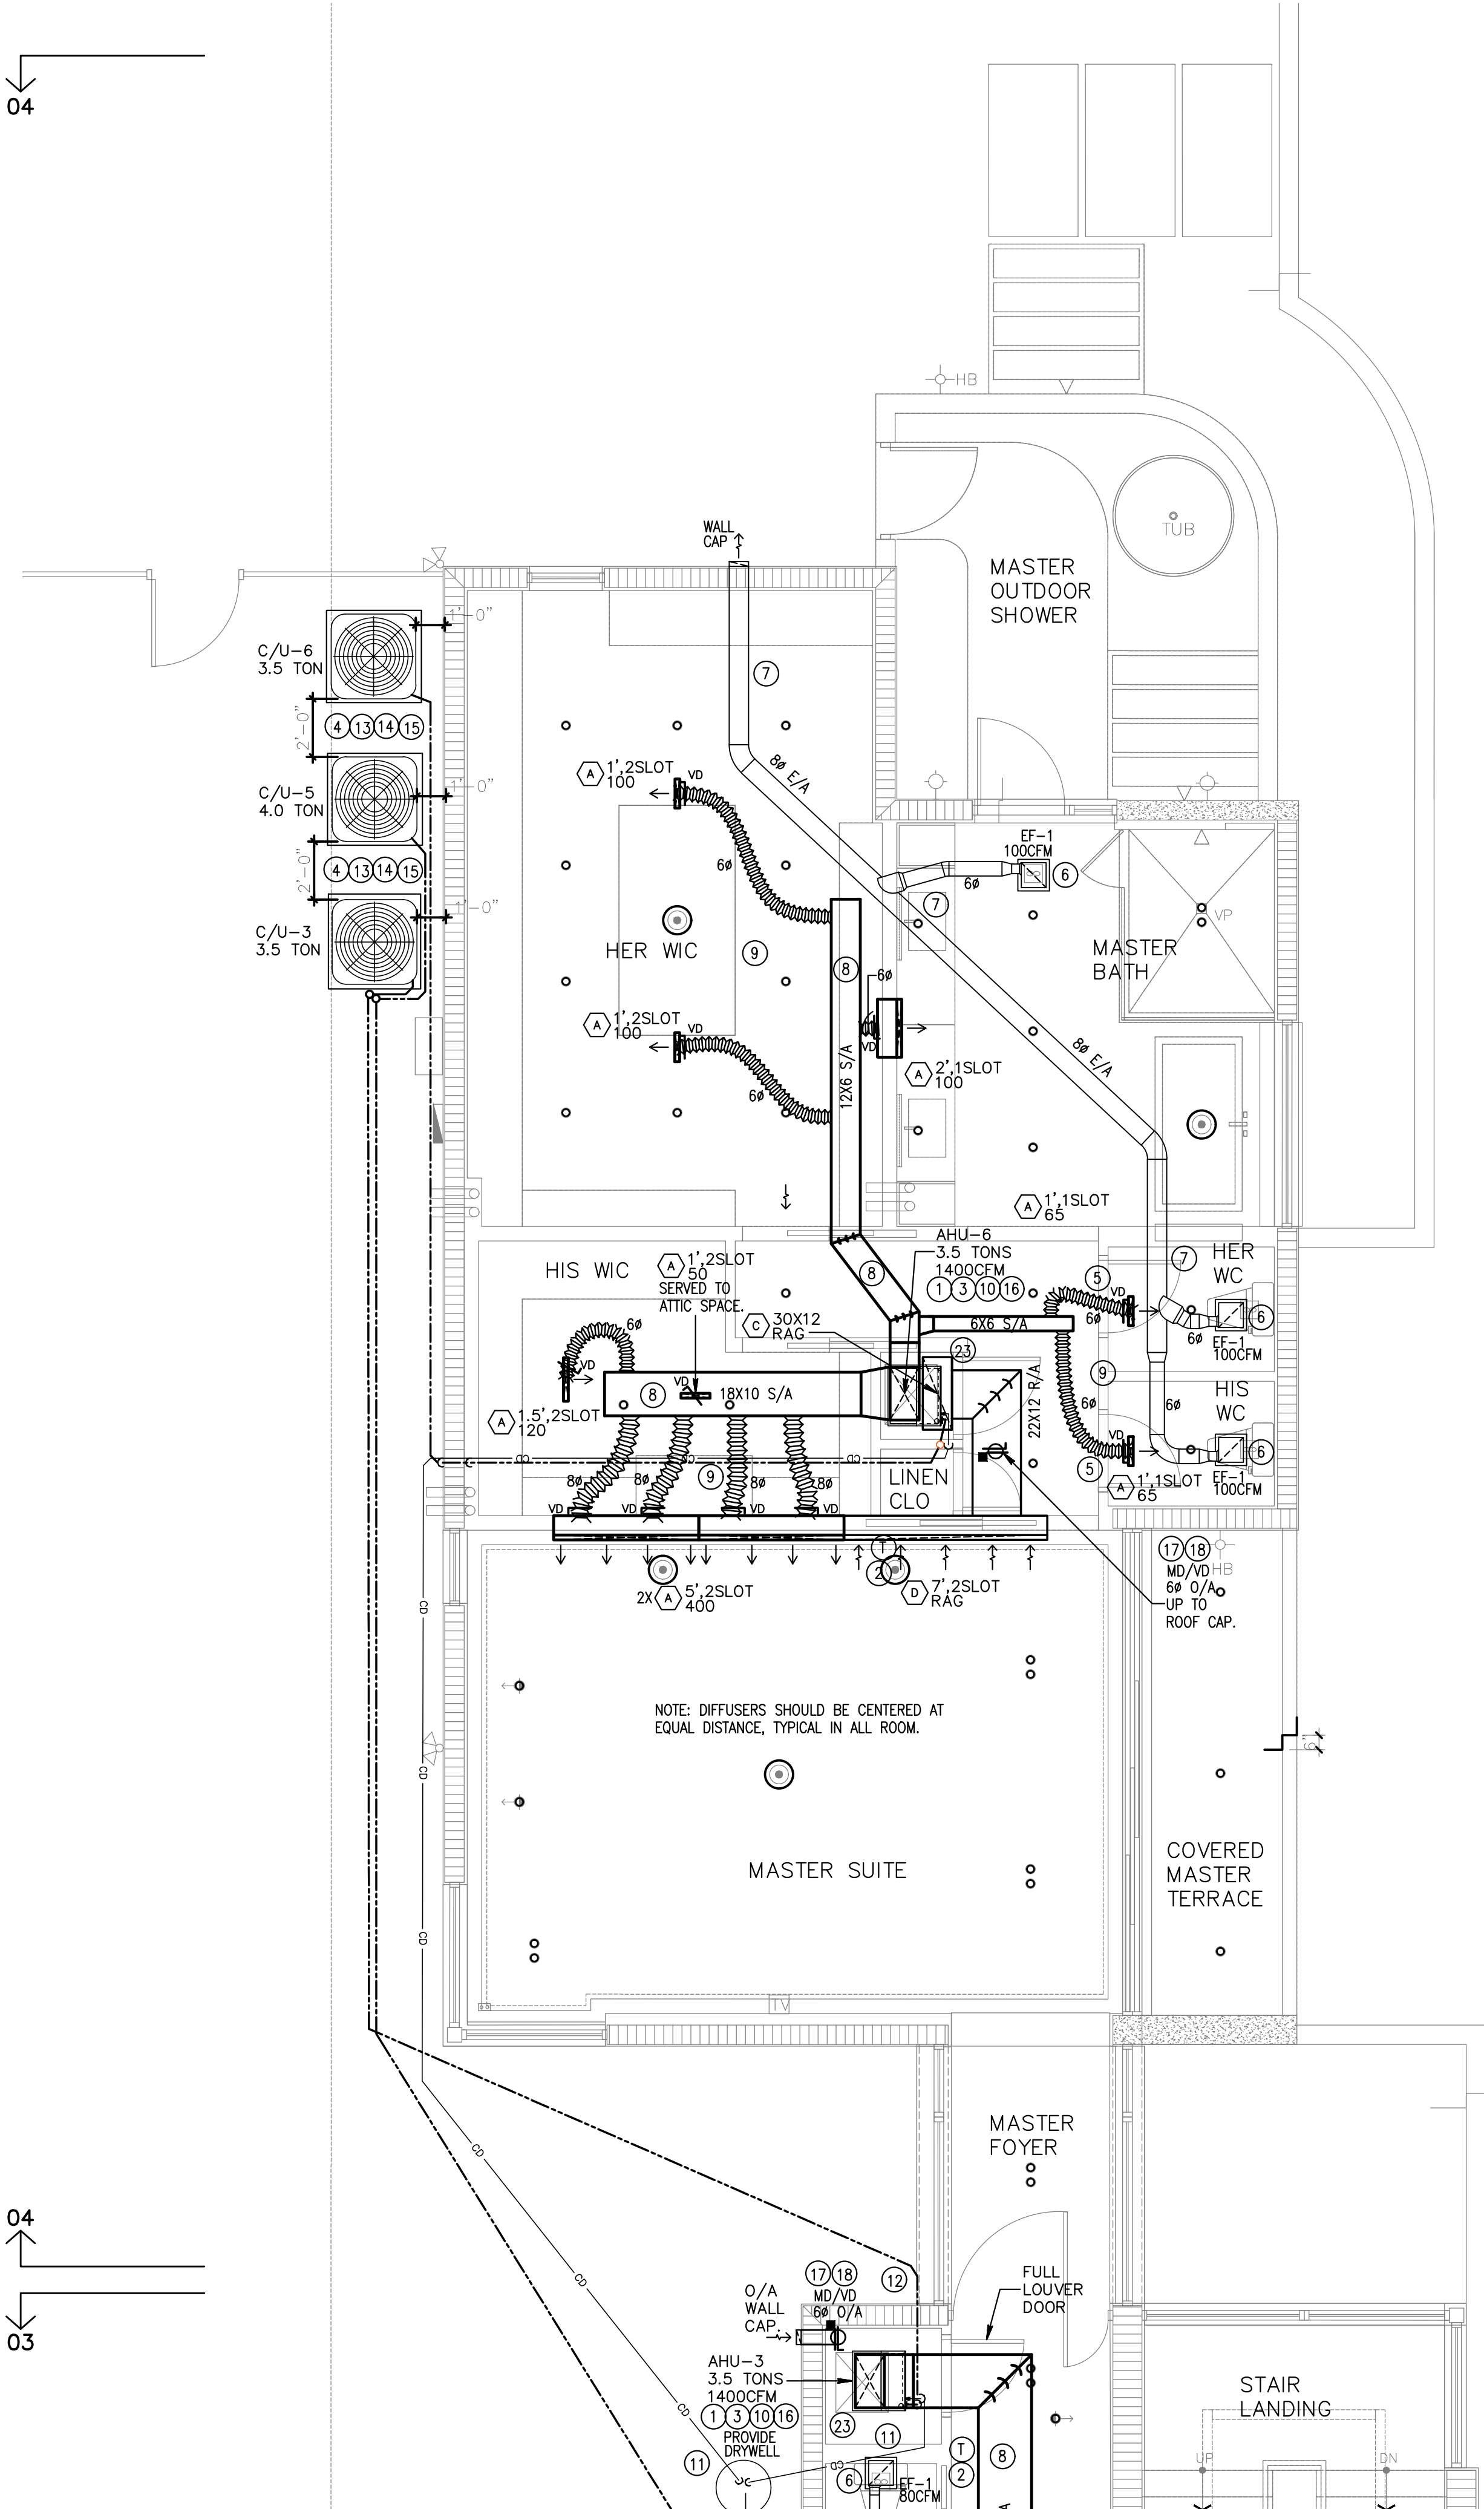

NOTE:
PLEASE REFER TO KEY NOTES IN M-1.1

PARTIAL FIRST RCP: 04
SCALE: 1/4" = 1'-0"

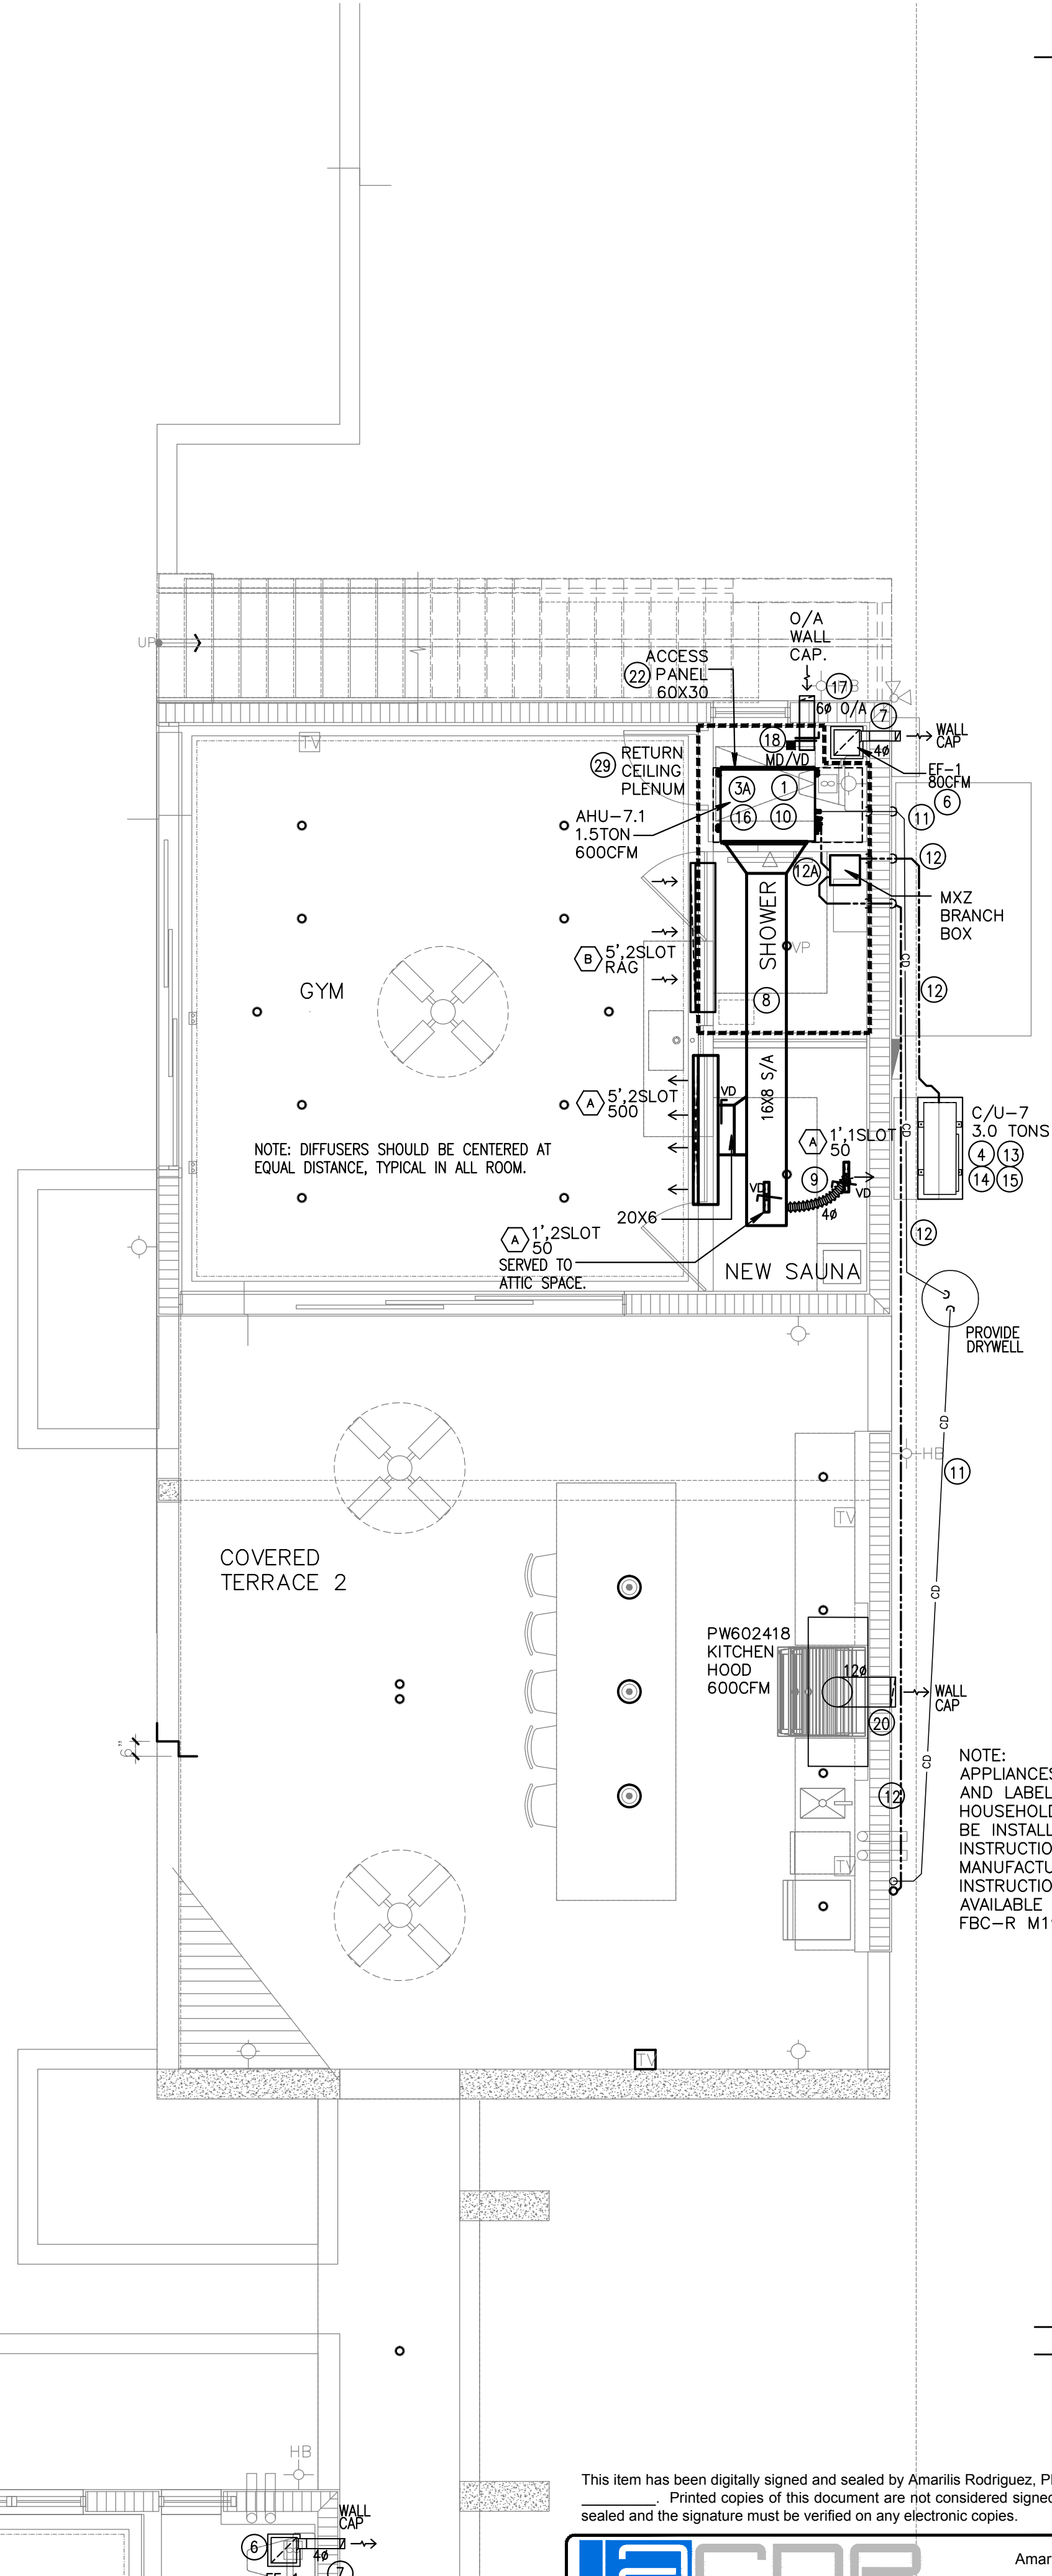

NOTE:
APPLIANCES MUST BE LISTED
AND LABELED FOR
HOUSEHOLD USE AND SHALL
BE INSTALLED ACCORDING TO
INSTRUCTIONS FROM
MANUFACTURER. A MANUAL OF
INSTRUCTIONS SHALL BE
AVAILABLE DURING INSPECTION
FBC-R M1901.2

This item has been digitally signed and sealed by Amarilis Rodriguez, P.E. on
Printed copies of this document are not considered signed and
sealed and the signature must be verified on any electronic copies.

JOB# 24-0407




2020 Ponce de Leon Blvd., Suite 1002
Coral Gables, Florida 33134
Phone > 305 444 9809
Fax > 305 444 9827

Amarilis Rodriguez, P.E.
License Number 60236
C.A. 26359

Signature _____
Date _____

NOTES

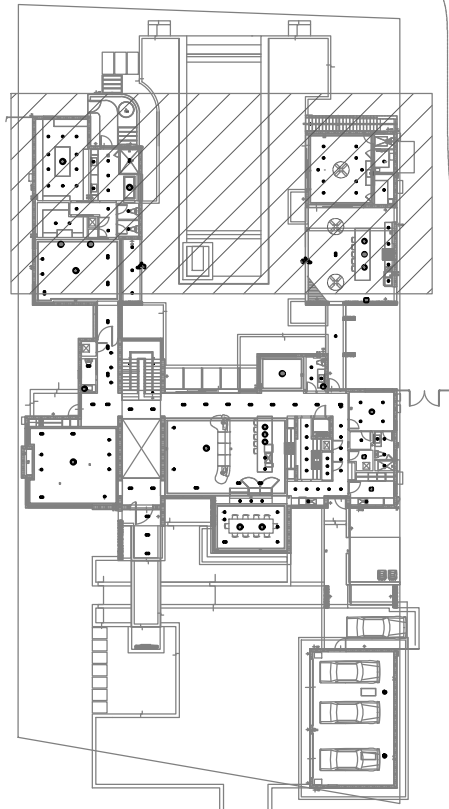

KEY PLAN
SCALE: 1/4" = 1'-0"



500 South Dixie Highway, Suite 307
Coral Gables, Florida 33146
Tel (305) 740-0120
Email locus@locusarchitecture.net
License AR 13937

CONSULTANT(S)

NO.	REVISION/SUBMISSION	DATE
1	OWNER REVIEW	03-11-24
2	PERMIT SUBMITTAL	06-07-24

PROJECT

New 2-Story Residence:
6100 W Suburban Dr. Pinecrest,
FL 33156

DRAWING

Partial First Reflected
Mechanical Plan: 04

SEAL

Nelson de
Leon
AR 13937

SHEET NO.

M-01.3

SCALE
As Shown

DRAWN

REVIEWED

PROJ. NO.
351