

 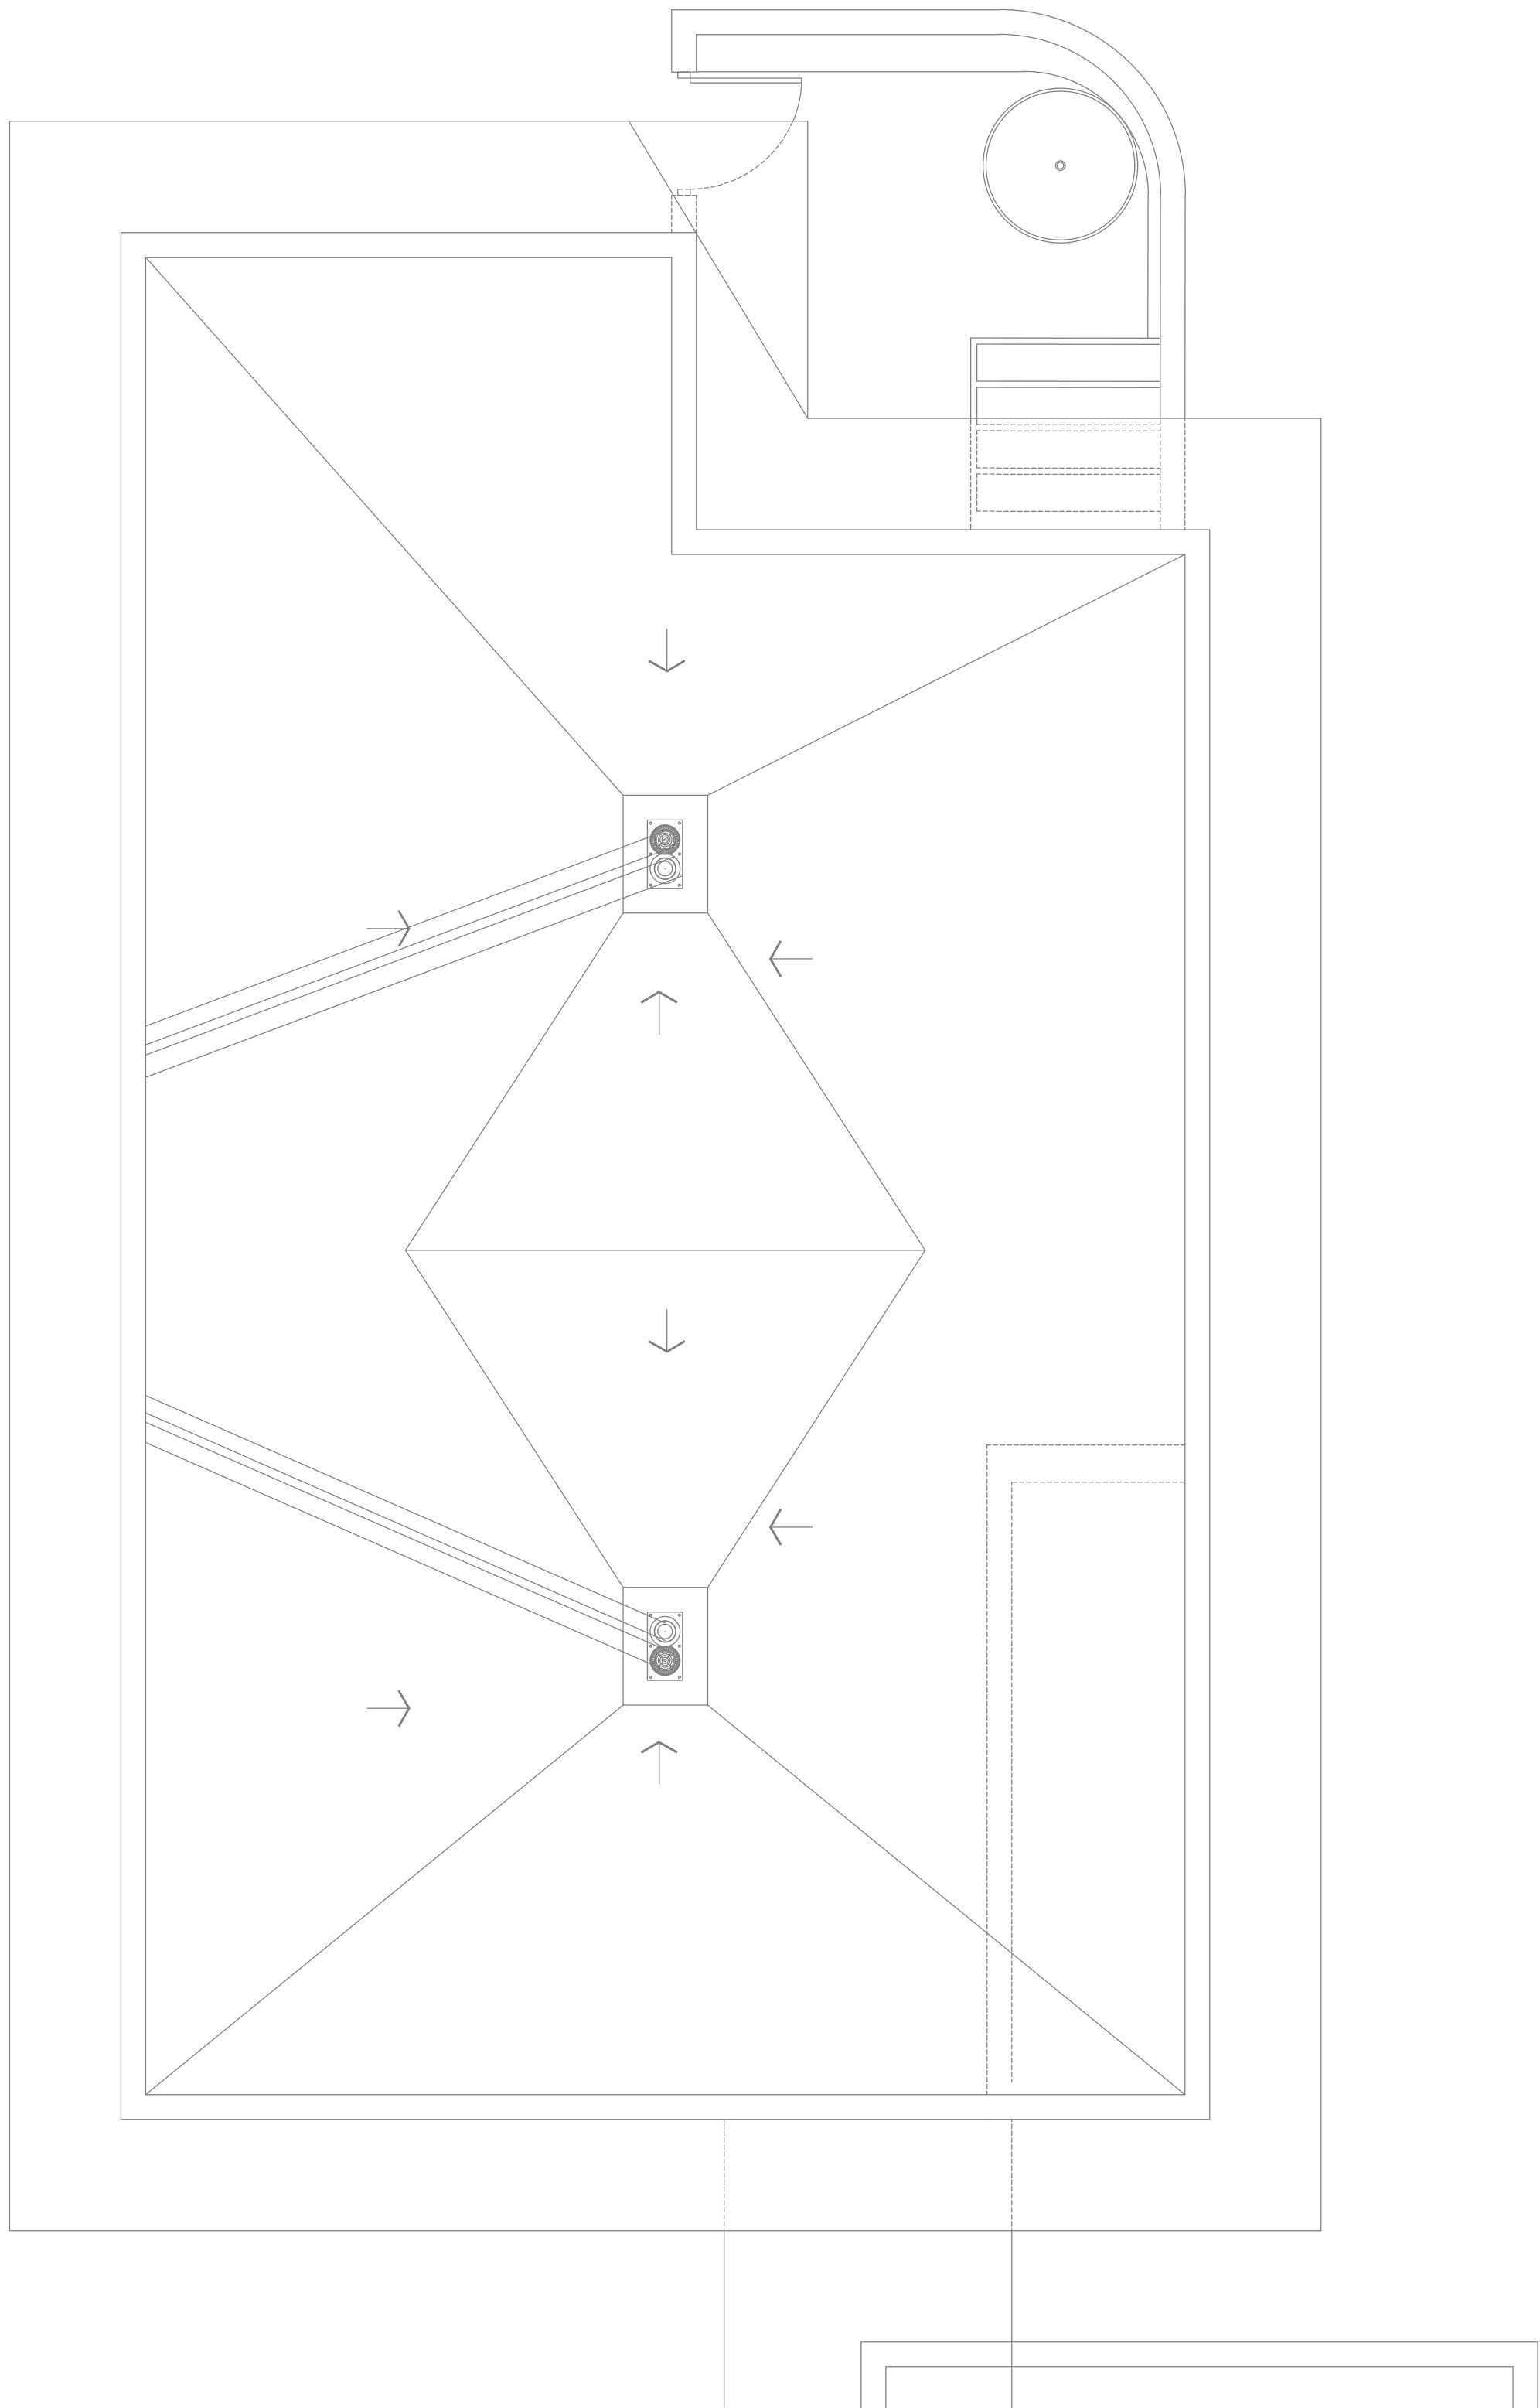


04

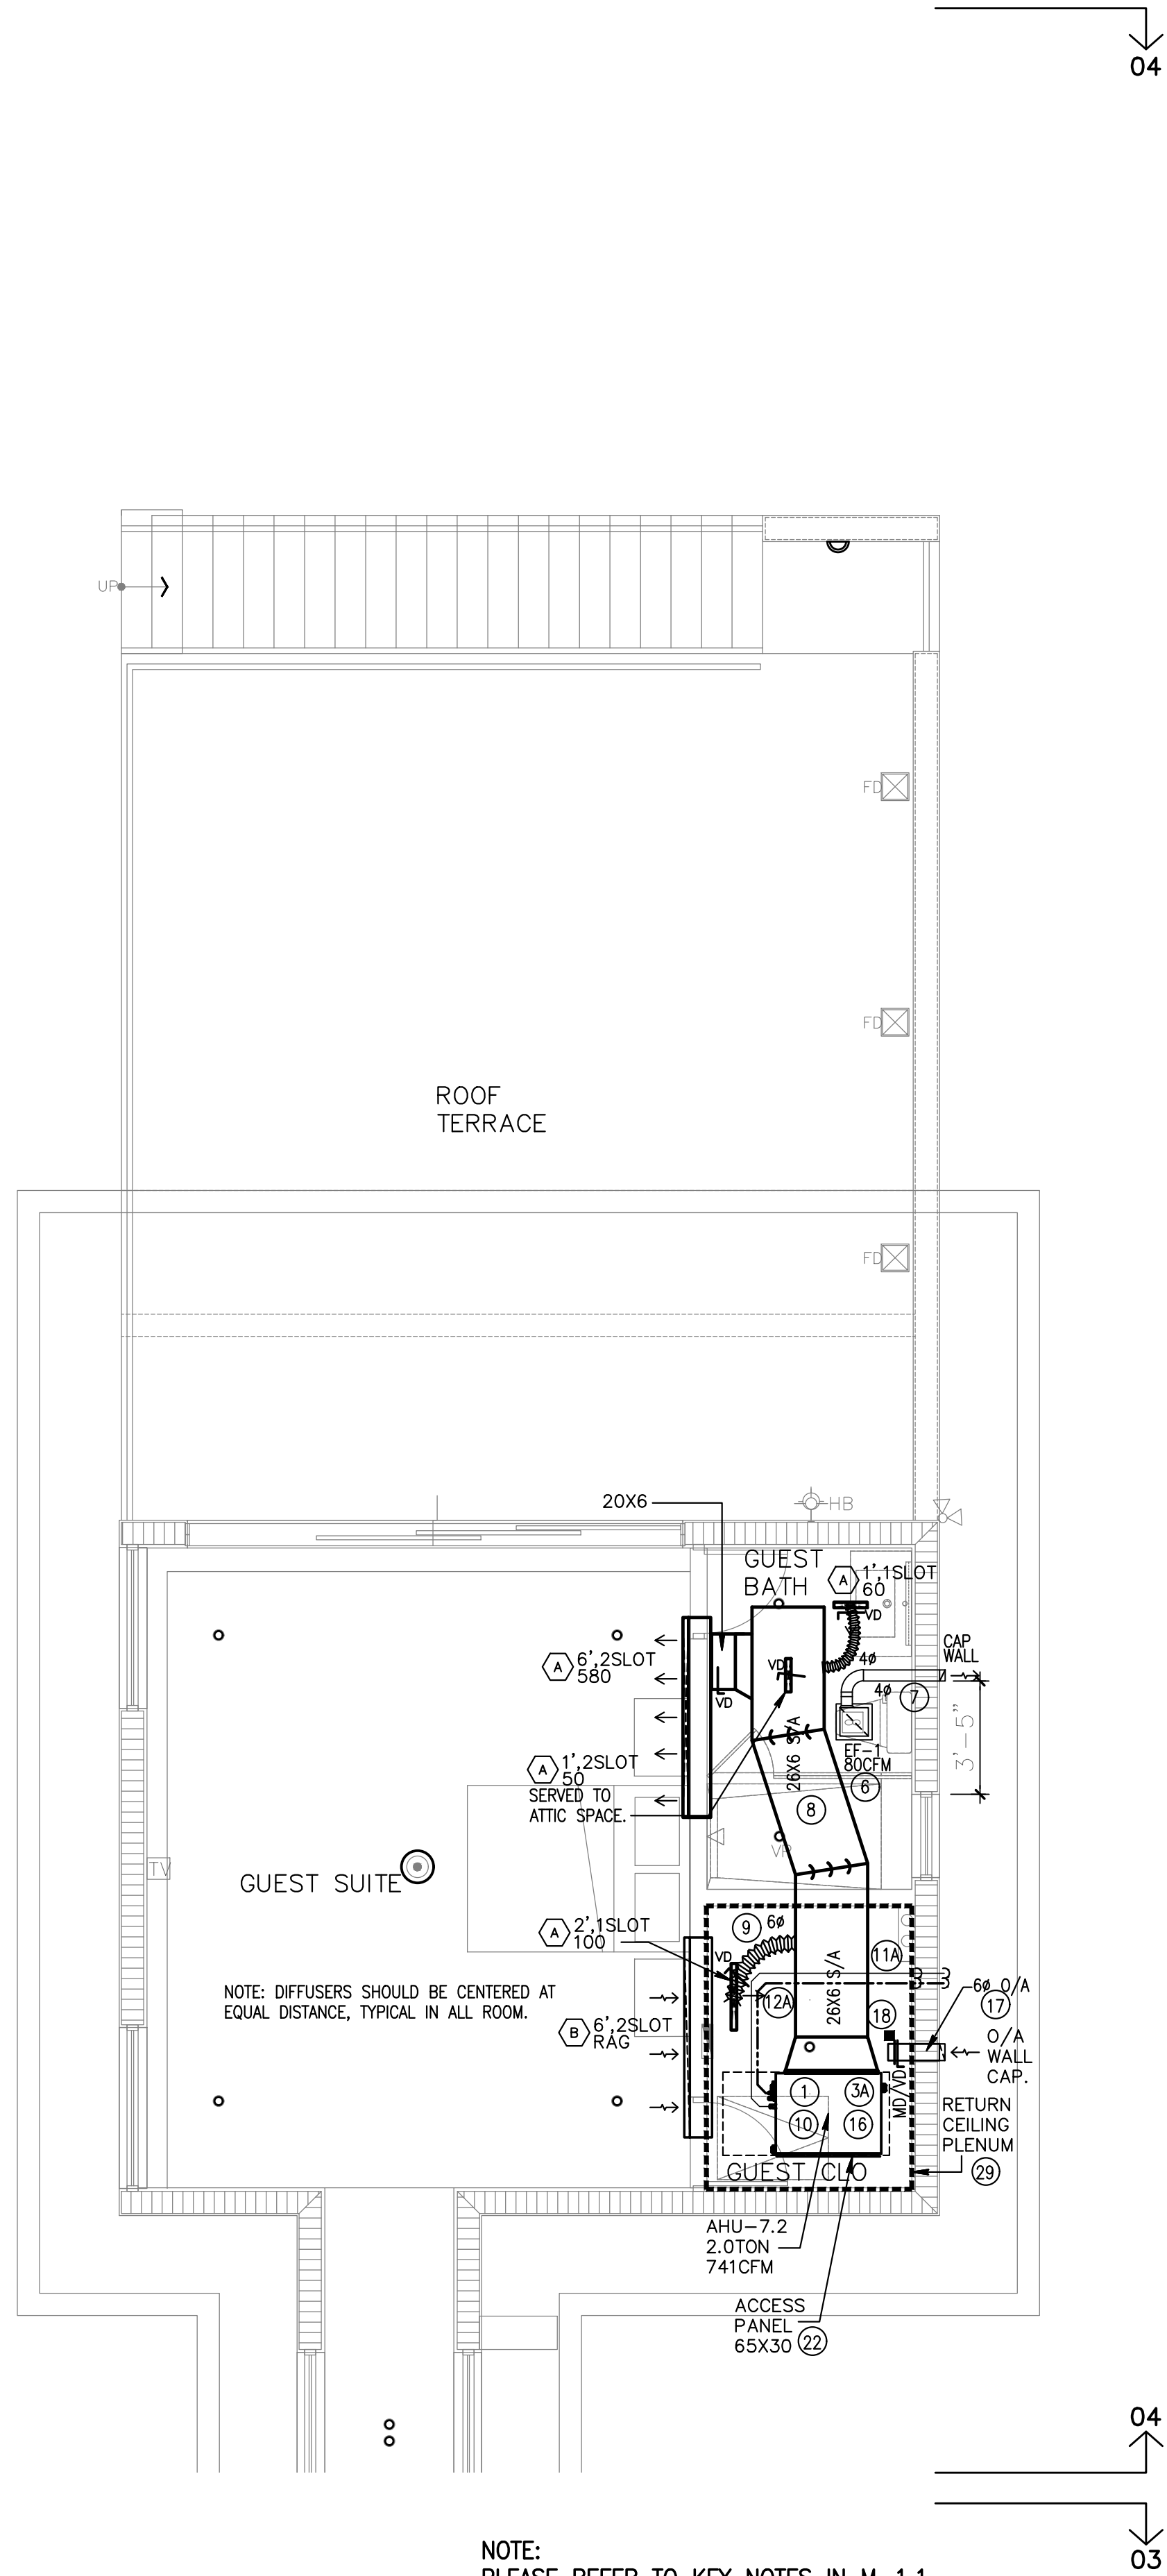

03



NOTE:
PLEASE REFER TO KEY NOTES IN M-1.1


This item has been digitally signed and sealed by Amarilis Rodriguez, P.E. on
Printed copies of this document are not considered signed and
sealed and the signature must be verified on any electronic copies. JOB# 24-0407

arpe
engineering inc
2020 Ponce de Leon Blvd., Suite 1002
Coral Gables, Florida 33134
Phone > 305 444 8809
Fax > 305 444 9827


Engineering Design:
> Mechanical > Electrical
> Plumbing > Fire Protection
www.arpe-eng.com

Amarilis Rodriguez, P.E.
License Number 60236
C.A. 26359
Signature _____
Date _____

PARTIAL SECOND RCP: 04
SCALE 1/4" = 1'-0"

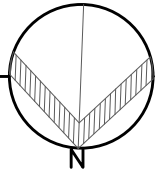

NOTES

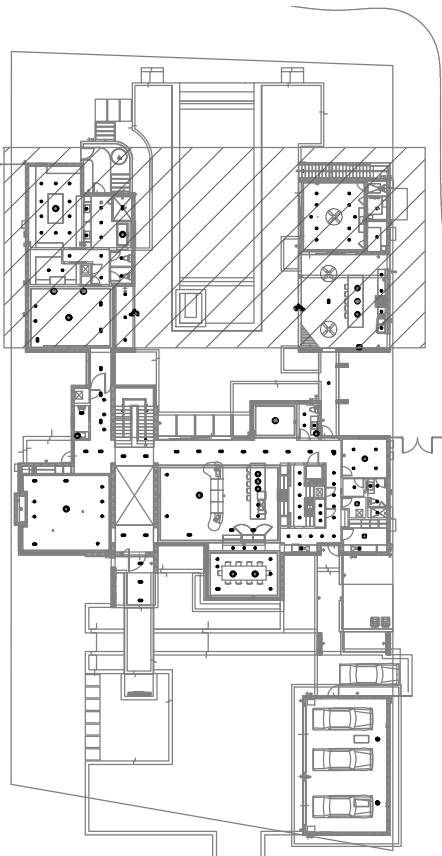

KEY PLAN
SCALE 1/4" = 1'-0"

LOCUS
ARCHITECTURE
INCORPORATED
500 South Dixie Highway, Suite 307
Coral Gables, Florida 33146
Tel (305) 740-0120
Email locus@locusarchitecture.net
License AR 13937

CONSULTANT(S)

NO.	REVISION/SUBMISSION	DATE
	OWNER REVIEW	03-11-24
	PERMIT SUBMITTAL	06-07-24

PROJECT

New 2-Story Residence:
6100 W Suburban Dr. Pinecrest,
FL 33156

DRAWING

Partial Second Reflected
Mechanical Plan: 04

SEAL	SCALE As Shown
	DRAWN
	REVIEWED

Nelson de
Leon
AR 13937

PROJ. NO.
351

SHEET NO.
M-01.5