




The emitter allows water captured by the downspouts and roof gutter systems to flow through the drainage pipe and away from the structural foundation to a safe area or useful area. The emitter does not rise high enough to interfere with mowers and its green color blends into the surrounding landscape. 3\"/>


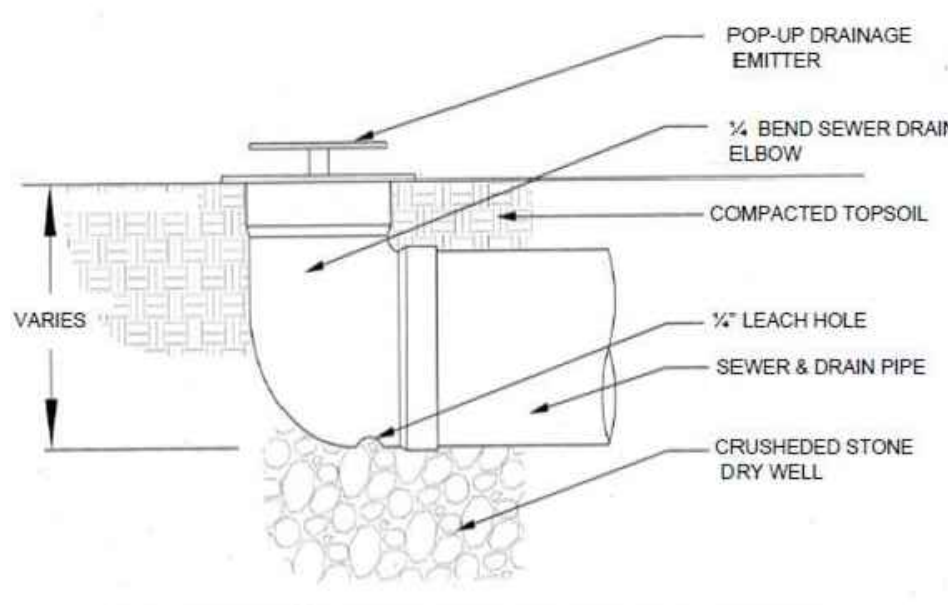


The emitter is open by hydrostatic pressure of water flowing through the drain pipe. As the flow diminishes, the emitter closes again.

POP-UP DRAINAGE EMITTER

SANITARY & STORM PARTIAL FIRST FLOOR PLAN: 02

SCALE: 1/4\"/>

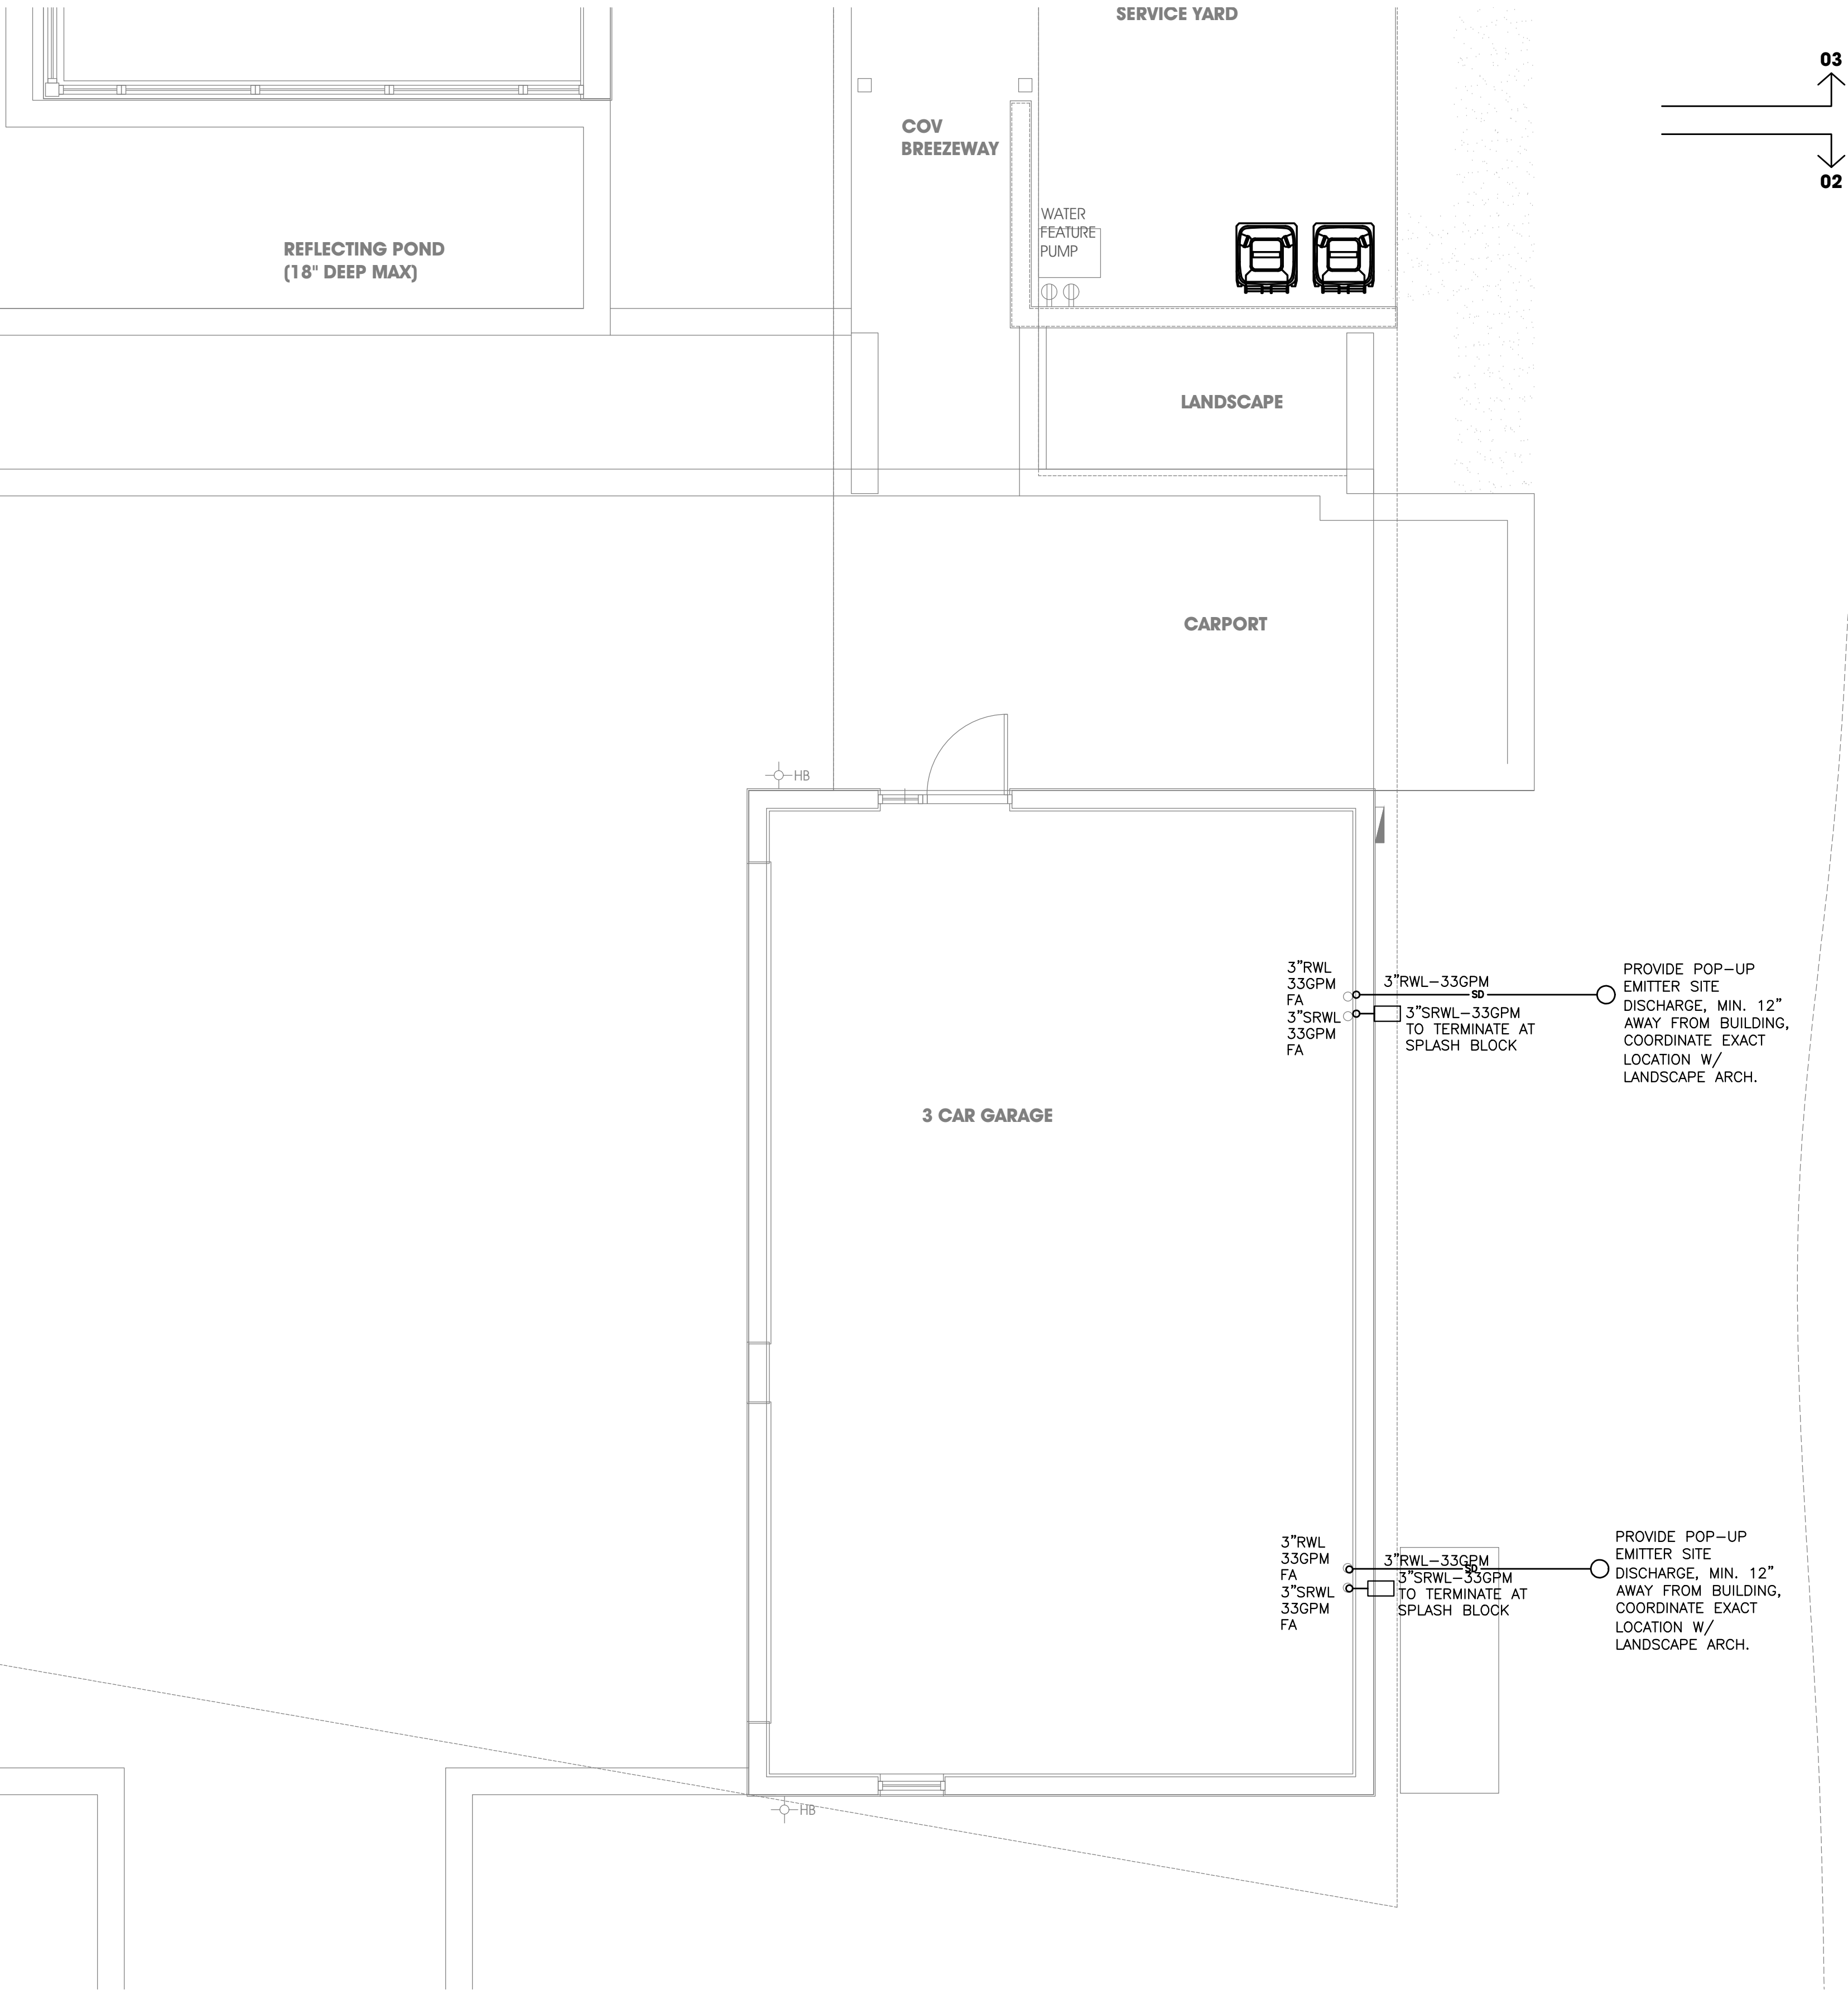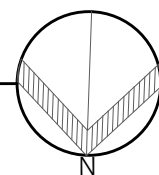

This item has been digitally signed and sealed by Amarilis Rodriguez, P.E. on 03-11-24. Printed copies of this document are not considered signed and sealed and the signature must be verified on any electronic copies.

JOB# 24-0407


2020 Ponce de Leon Blvd., Suite 1002
Coral Gables, Florida 33134
Phone > 305 444 8809
Fax > 305 444 9827

Engineering Design:
> Mechanical > Electrical
> Plumbing > Fire Protection
www.arpe-eng.com

Amarilis Rodriguez, P.E.
License Number 60236
C.A. 26359

Signature _____
Date _____

NOTES

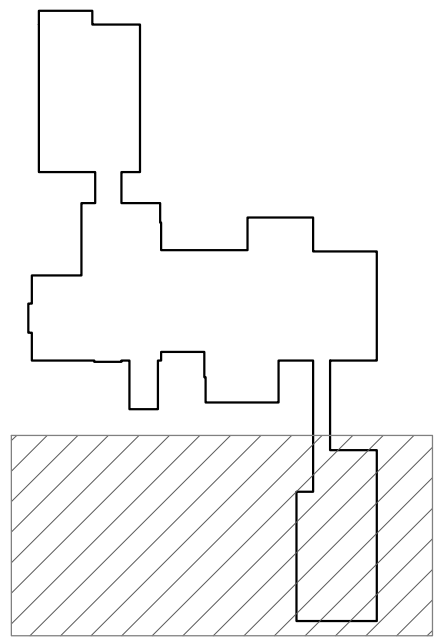

KEY PLAN

SCALE: 1/4\"/>

500 South Dixie Highway, Suite 307
Coral Gables, Florida 33146
Tel: (305) 740-0120
Email: locus@locusarchitecture.net
License: AR 13937

CONSULTANT(S)

NO.	REVISION/SUBMISSION	DATE
1	OWNER REVIEW	03-11-24
2	PERMIT SUBMITAL	06-07-24
3		
4		
5		
6		
7		
8		
9		
10		

PROJECT

New 2-Story Residence:
6100 W Suburban Dr, Pinecrest, FL 33156

DRAWING

Partial First Floor Plan: 02

SEAL	SCALE As Shown
	DRAWN
	REVIEWED
Nelson de Leon AR 13937	PROJ. NO. 351

SHEET NO.

P-02.1