


04



04

03

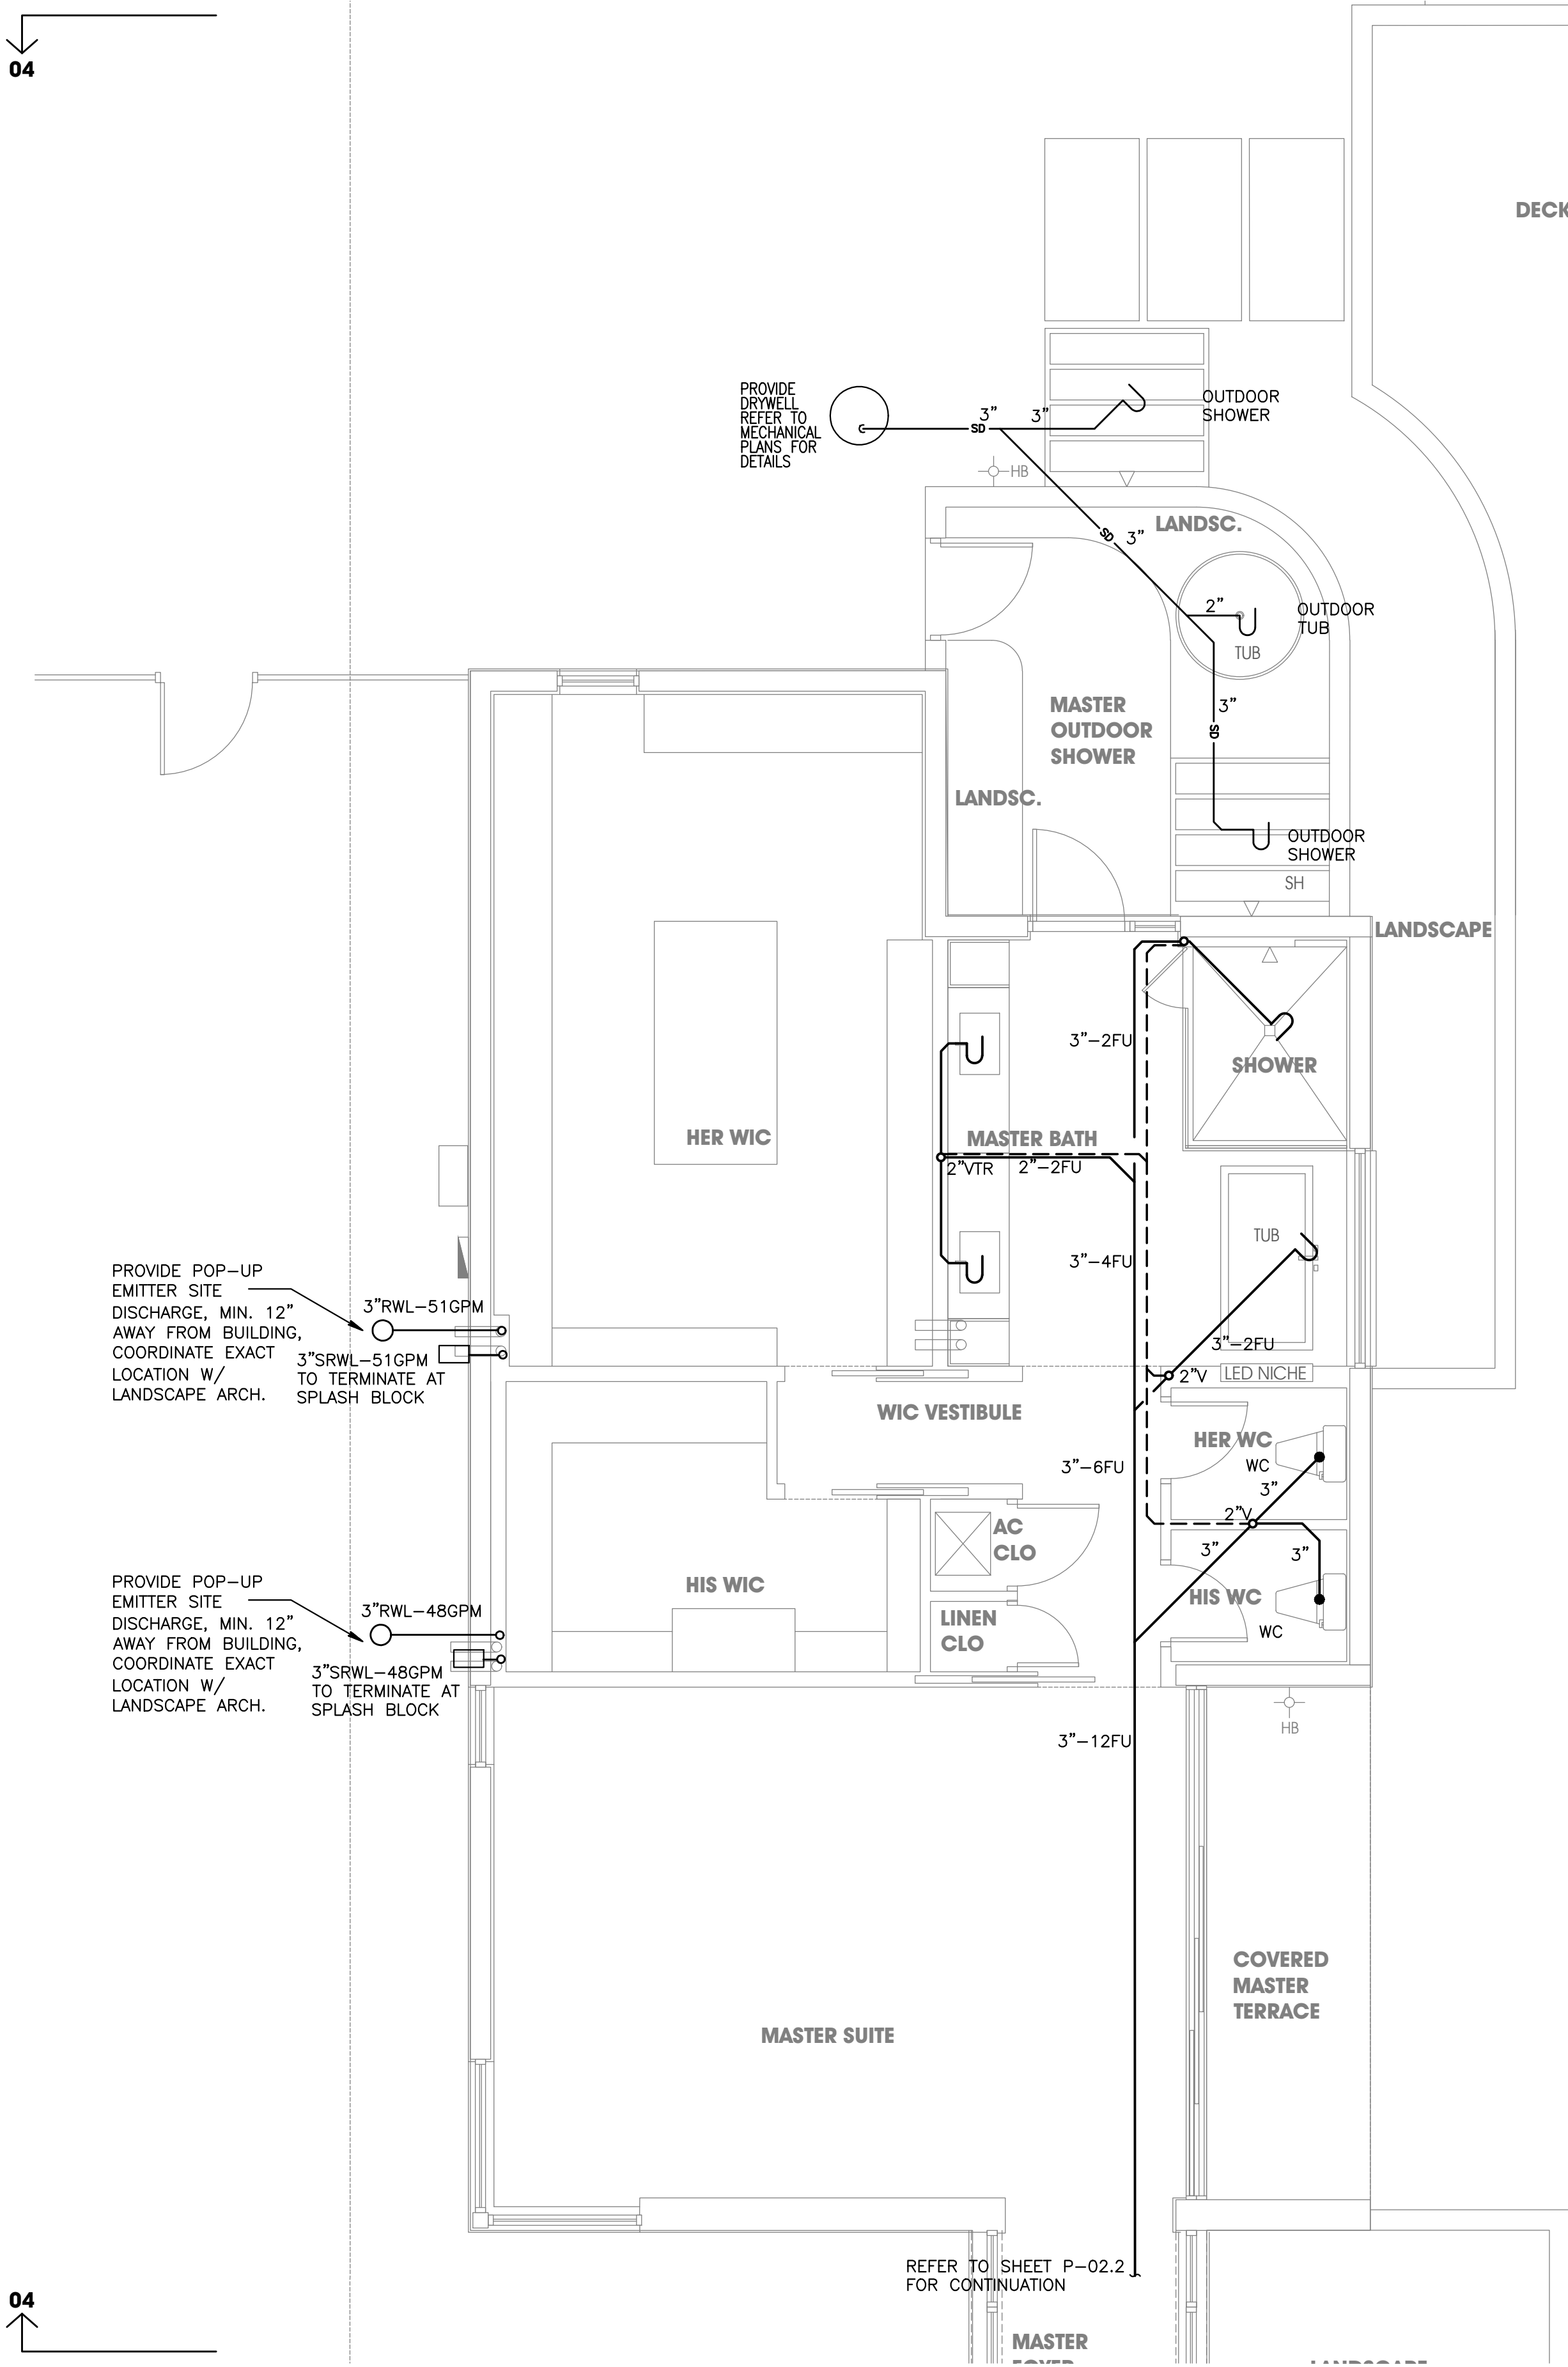


SANITARY & STORM FIRST FLOOR PLAN: 04

SCALE: 1/4" = 1'-0"

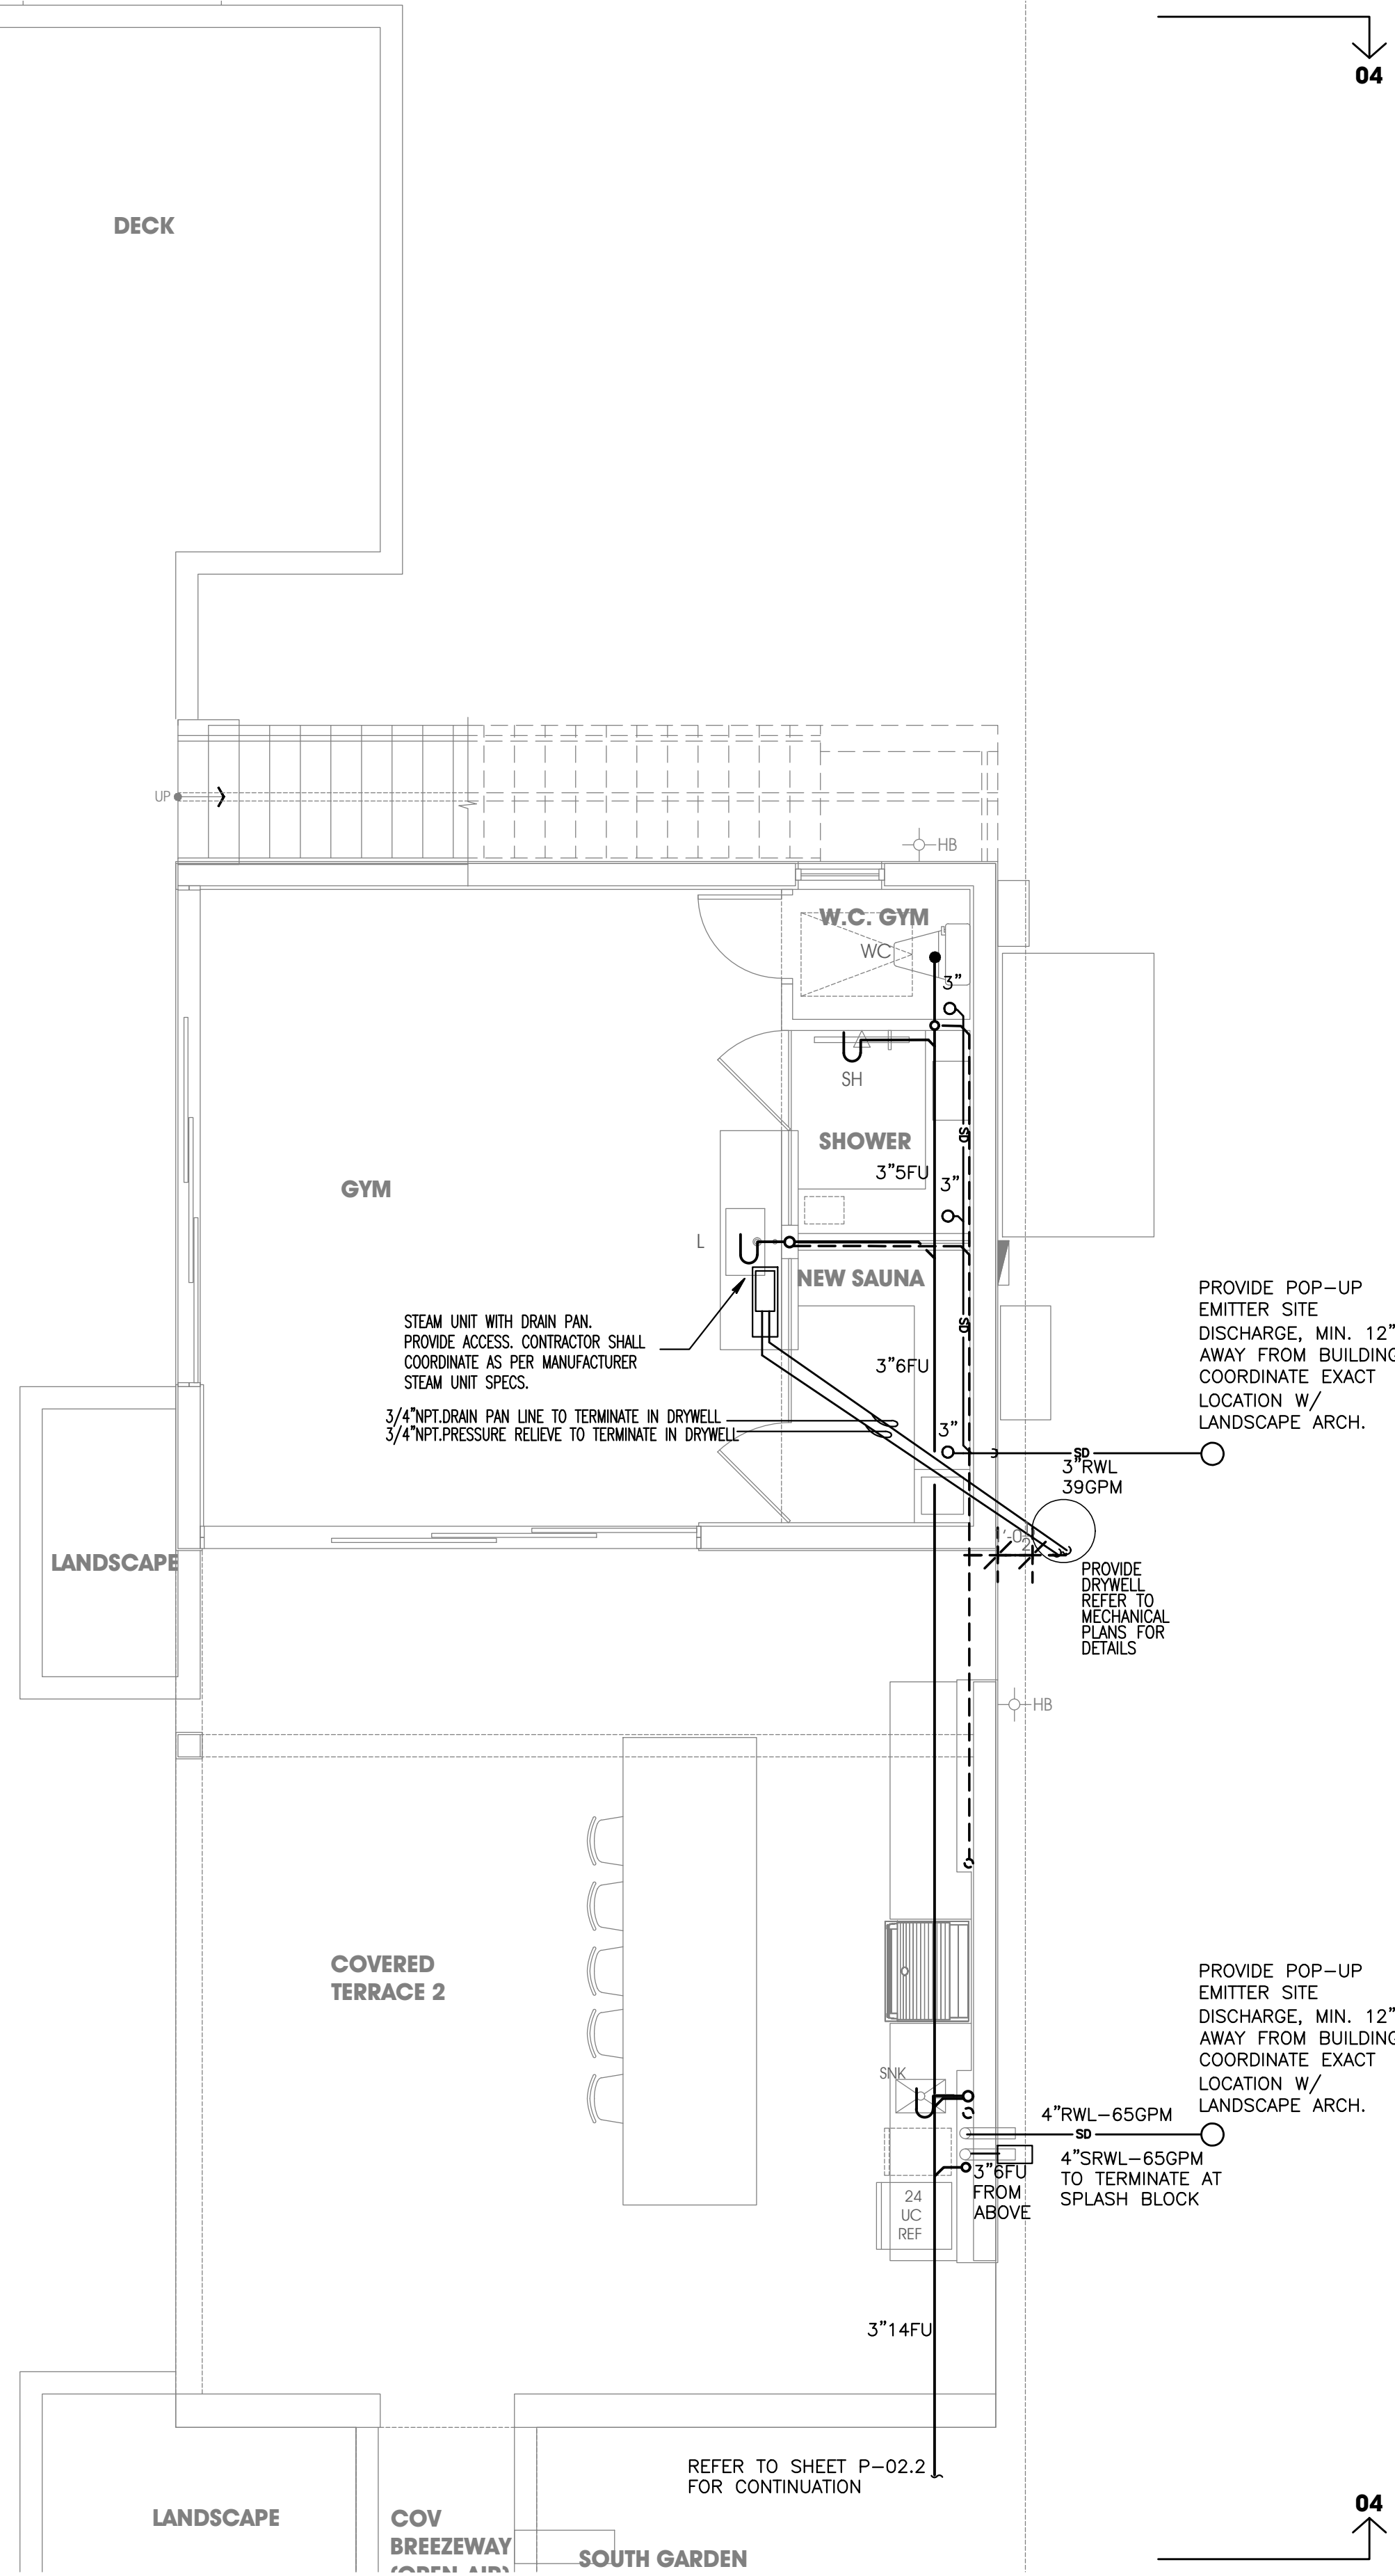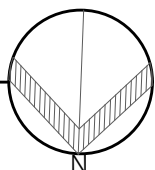

NOTES

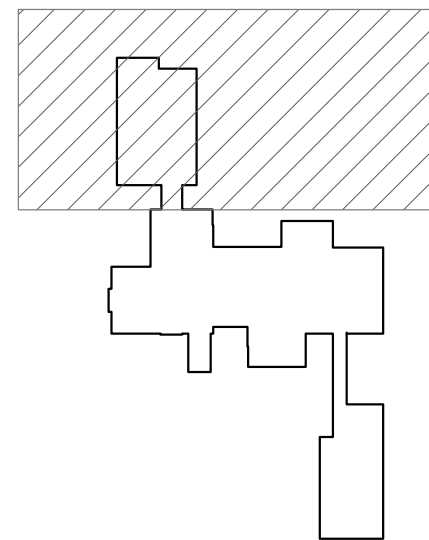

KEY PLAN

SCALE: 1/4" = 1'-0"



CONSULTANT(S)

NO.	REVISION/SUBMISSION	DATE
1	OWNER REVIEW	03-11-24
2	PERMIT SUBMITAL	06-07-24

PROJECT

New 2-Story Residence:
6100 W Suburban Dr, Pinecrest, FL 33156

DRAWING

Sanitary & Storm First Floor Plan: 04

SEAL	SCALE
	As Shown
DRAWN	
REVIEWED	
Nelson de Leon AR 13937	PROJ. NO. 351

SHEET NO.

P-02.3

This item has been digitally signed and sealed by Amarilis Rodriguez, P.E. on 06/10/24. Printed copies of this document are not considered signed and sealed and the signature must be verified on any electronic copies.

JOB# 24-0407



2020 Ponce de Leon Blvd., Suite 1002
Coral Gables, Florida 33134
Phone > 305 444 8809
Fax > 305 444 9827

Amarilis Rodriguez, P.E.
License Number 60236
C.A. 26359

Engineering Design:
> Mechanical > Electrical
> Plumbing > Fire Protection
www.arpe-eng.com

Signature _____
Date _____