


04


04
↑
↓
03

03

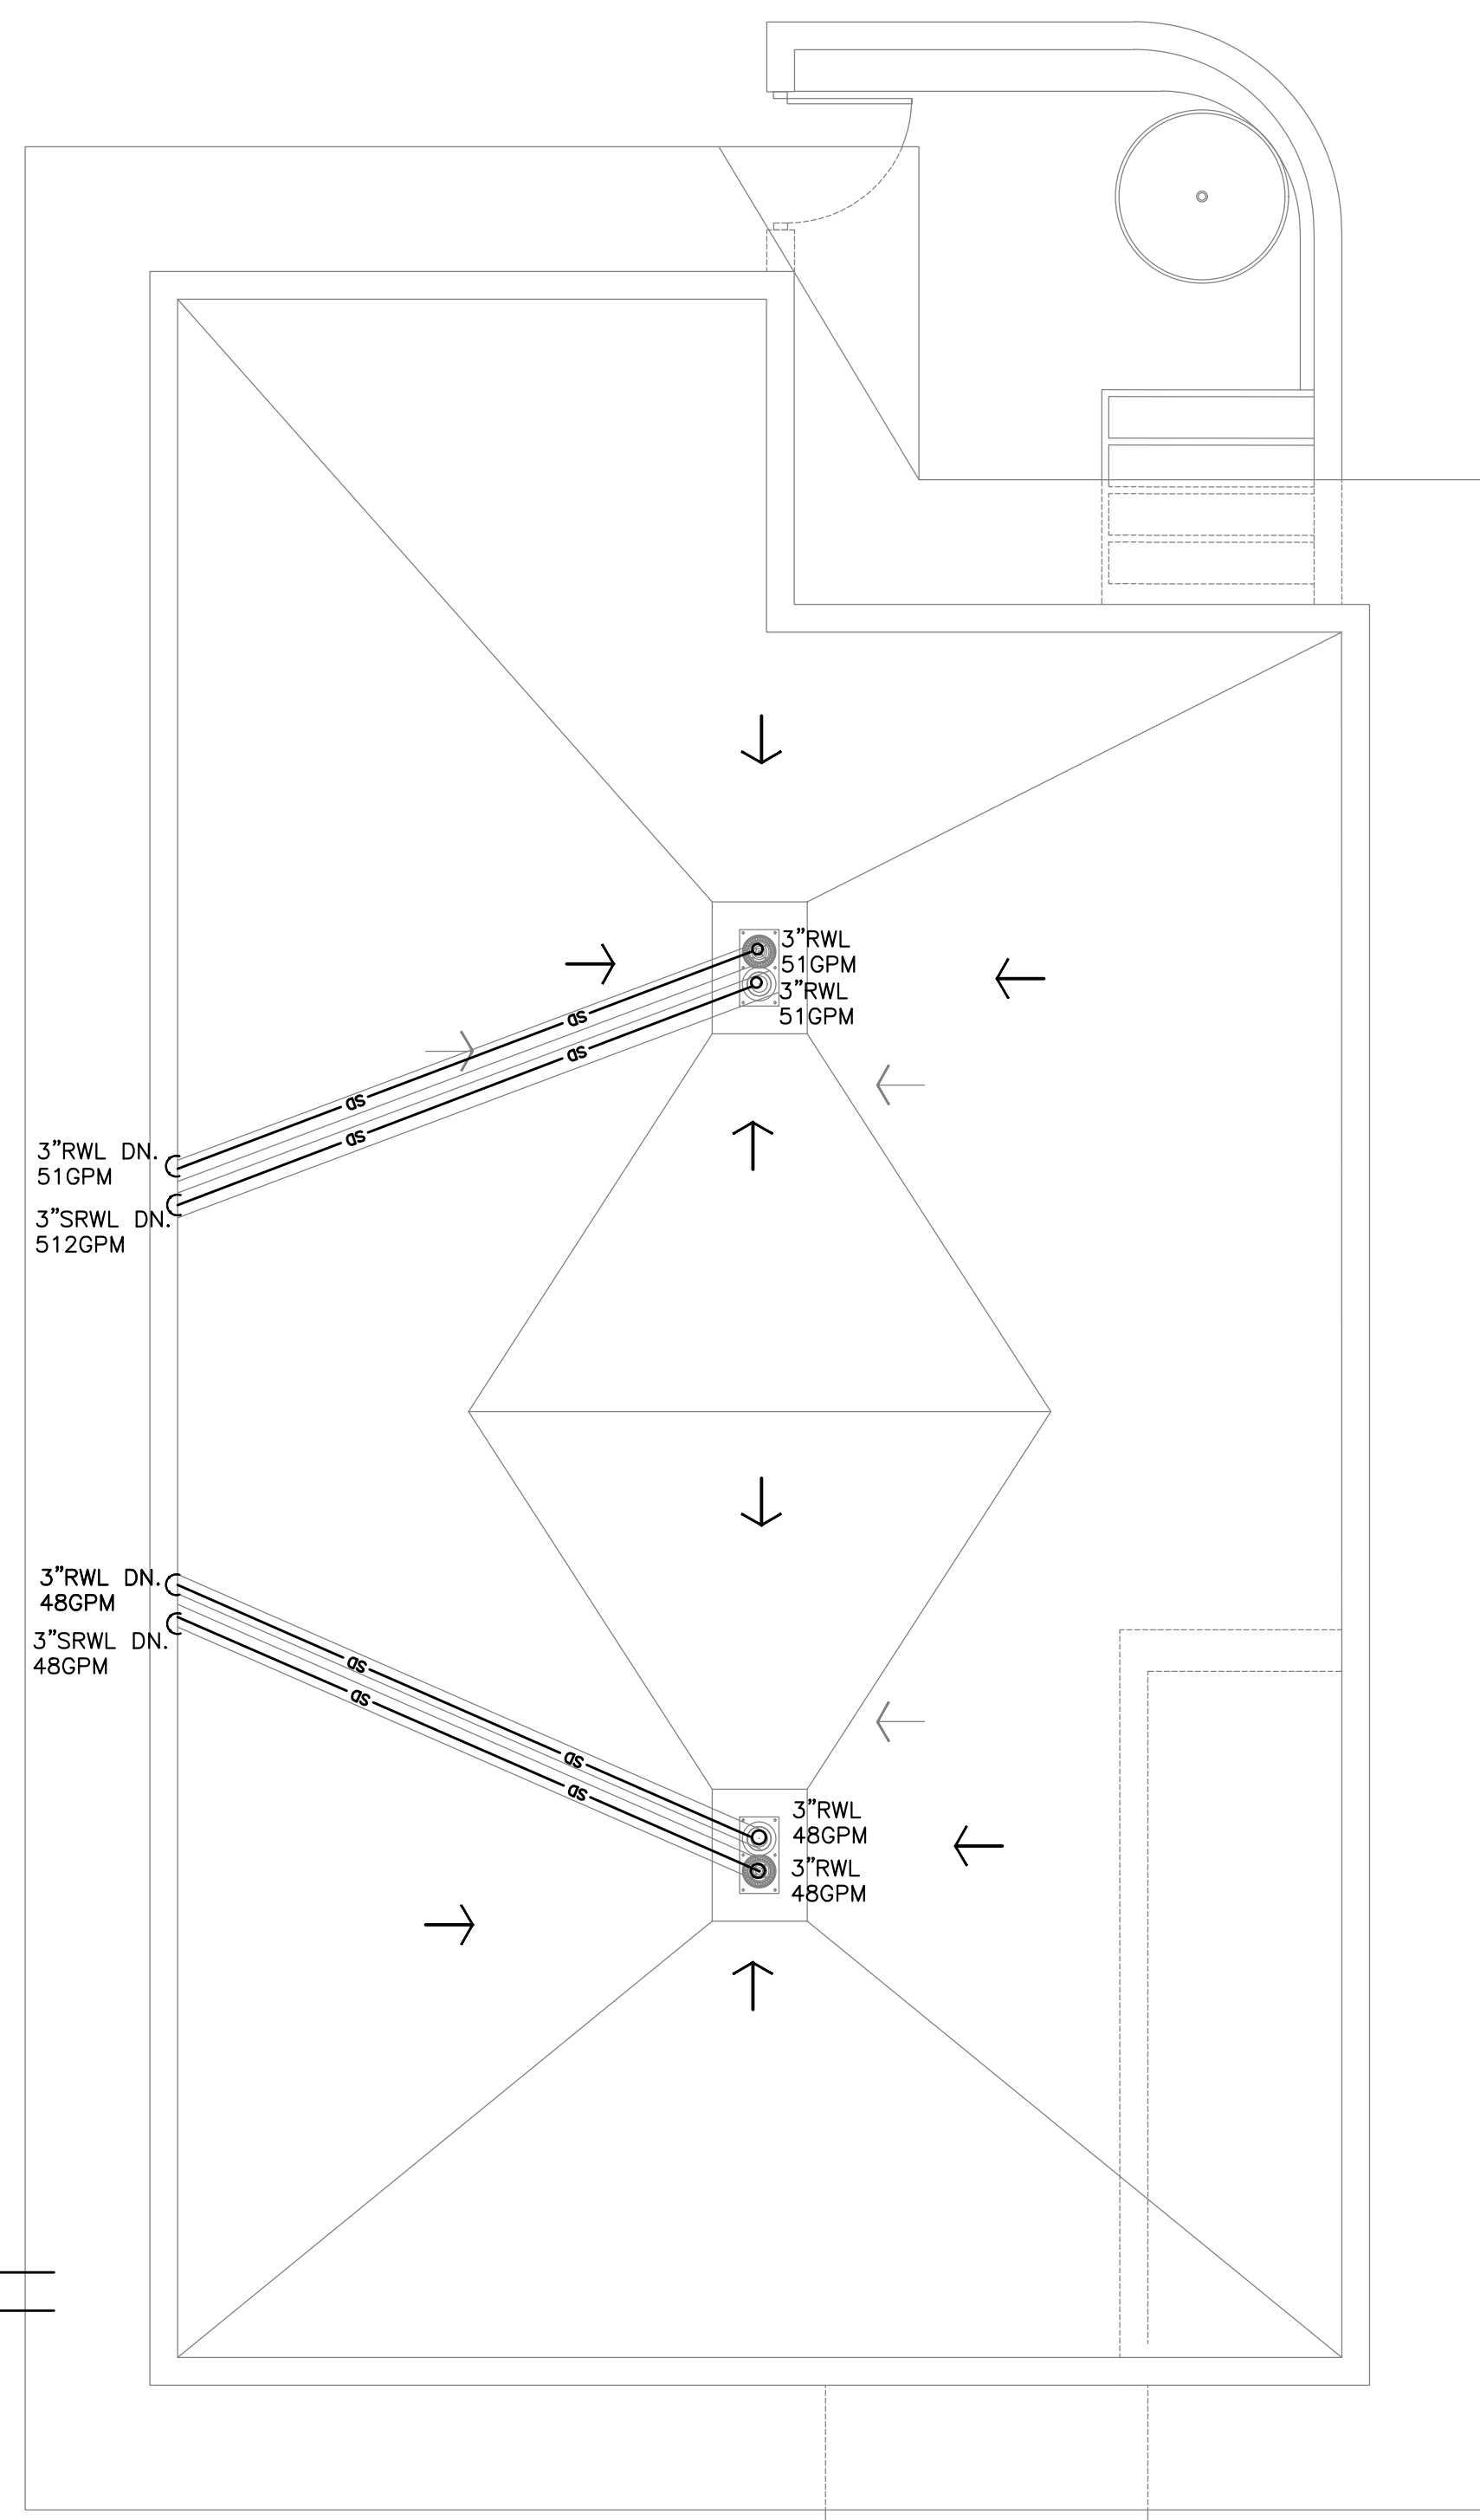

SANITARY & STORM SECOND FLOOR PLAN: 04

SCALE: 1/4" = 1'-0"

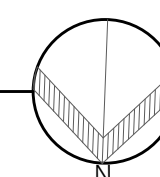

04


04
↑
↓
03

DRAWING

Partial Second Floor Plan

SEAL

SCA
AS :

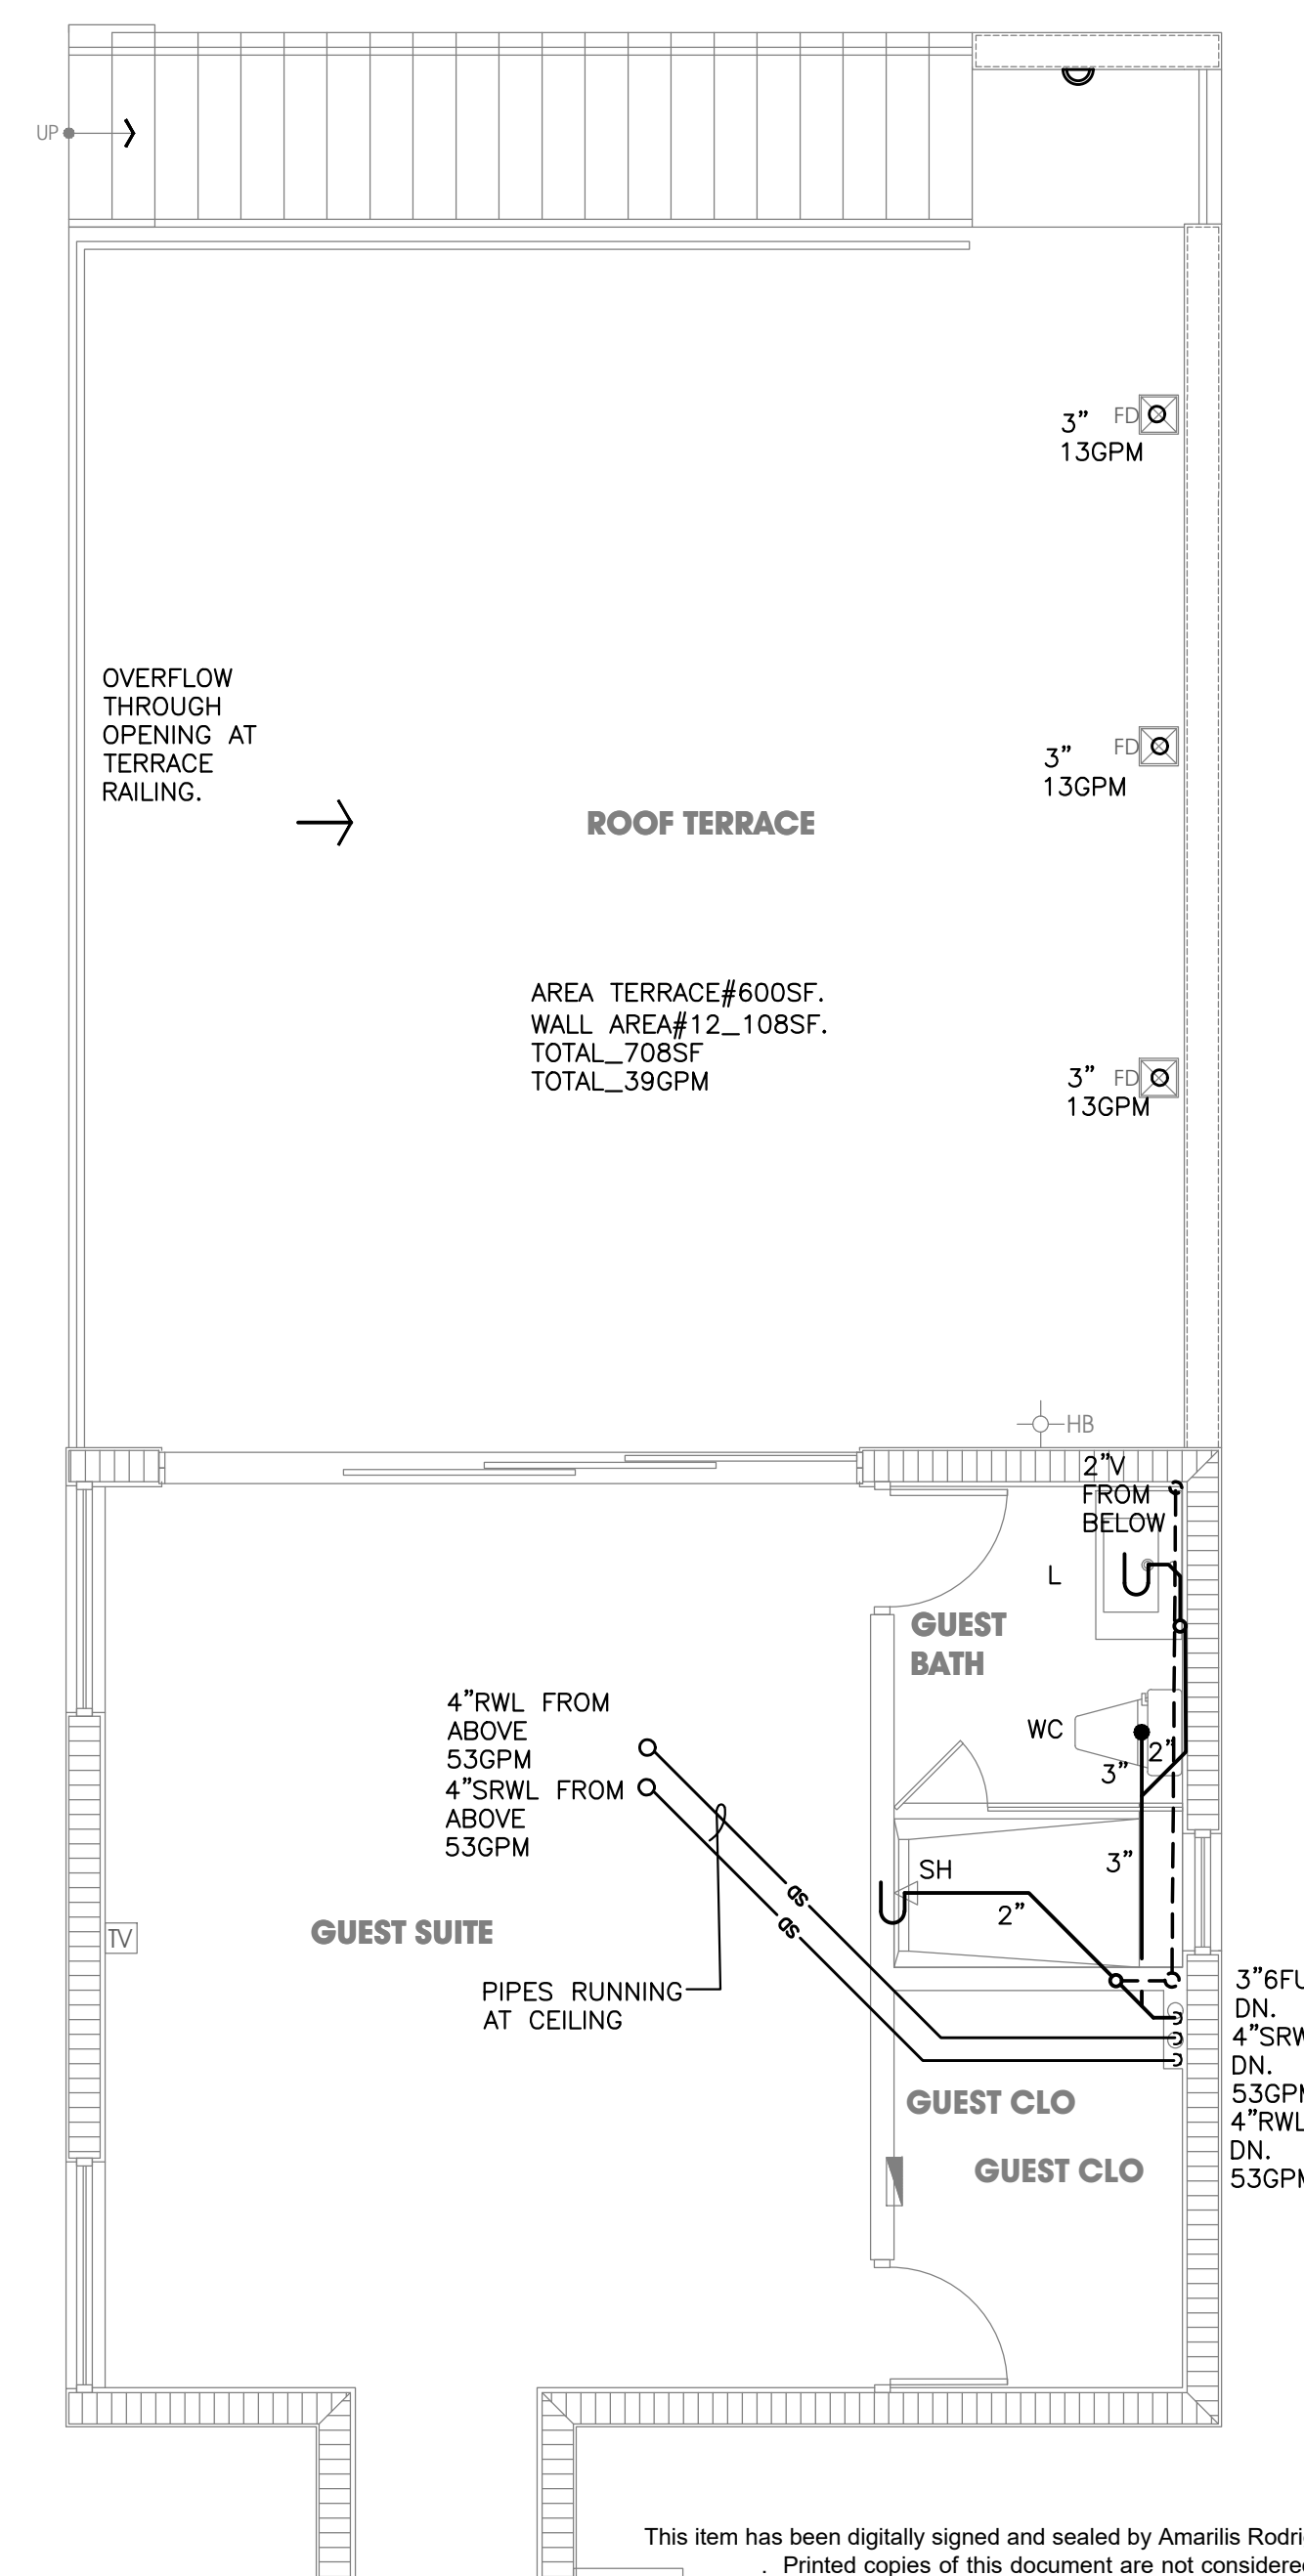

This item has been digitally signed and sealed by Amarilis Rodriguez, PE, on _____, Printed copies of this document are not considered signed and sealed and the signature must be verified on any electronic copies.

JOB# 24-0407



2020 Ponce de Leon Blvd., Suite 1002
Coral Gables, Florida 33134
Phone > 305 444 9809 >
Fax > 305 444 9827 >


Engineering Design:
 > Mechanical > Electrical
 > Plumbing > Fire Protection
www.arpe-eng.com

Amarilis Rodriguez, P.E.
License Number 60236
C.A. 26359

Signature _____

Date _____

NOTES

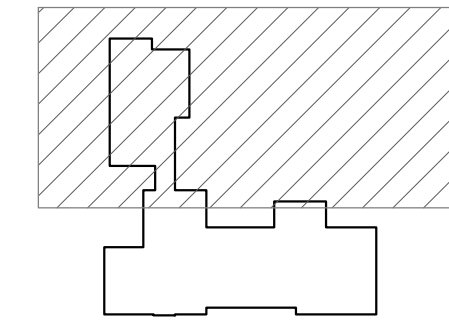

KEY PLAN

SCALE: 1/4" = 1'-0"



500 South Dixie Highway, Suite 307
Coral Gables, Florida 33146
Tel (305) 740-0120
Email locus@locusarchitecture.net
License AR 13937

CONSULTANT(S)

[illegible][illegible]

New 2-Story Residence:
6100 W Suburban Dr. Pinecrest, FL
33156

DRAWING

Partial Second Floor Plan: 04

SEAL

SCALE As Shown

DRAWN

REVIEWED

Nelson de Leon
AR 13937

PROJ. NO.	351
-----------	-----

SHEET NO.

P-02.5