



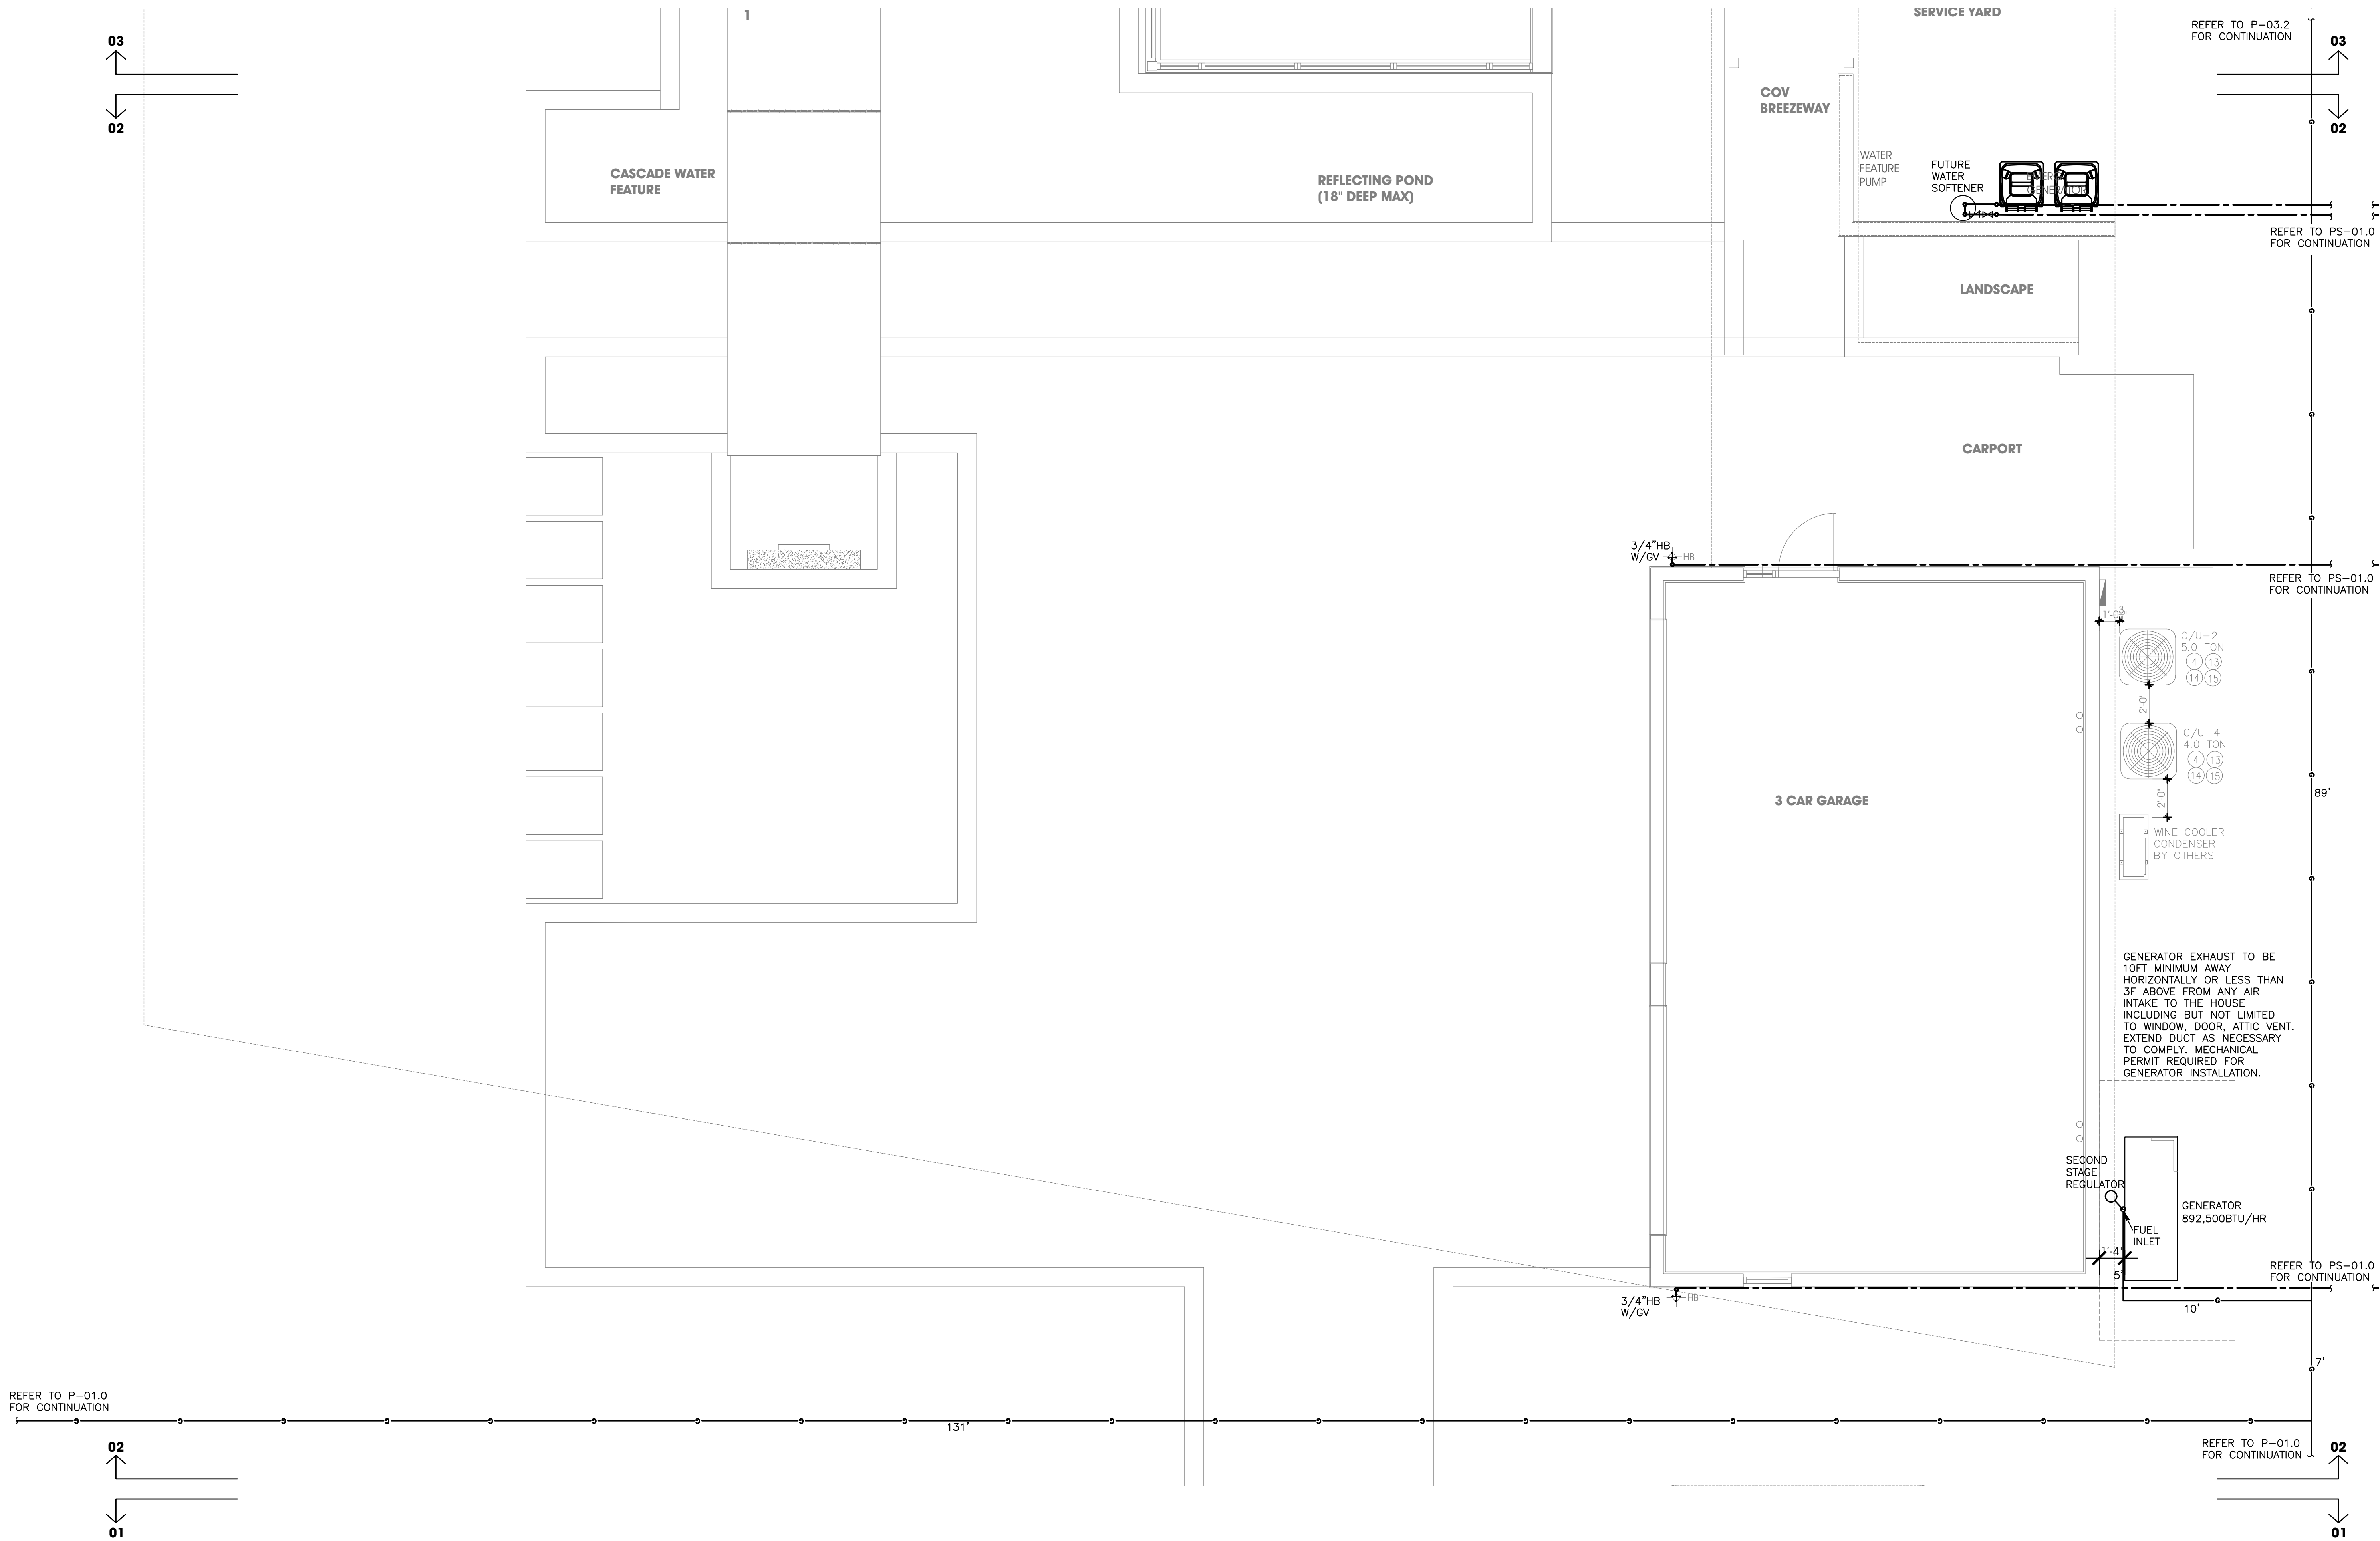

WATER & GAS PARTIAL FIRST FLOOR PLAN: 02

SCALE: 1/4" = 1'-0"

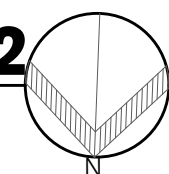

This item has been digitally signed and sealed by Amarilis Rodriguez, P.E. on
Printed copies of this document are not considered signed and
sealed and the signature must be verified on any electronic copies.


JOB# 24-0407



Amarilis Rodriguez, P.E.
License Number 60236
C.A. 26359


2020 Ponce de Leon Blvd., Suite 1002
Coral Gables, Florida 33134
Phone > 305 444 8809
Fax > 305 444 9827
Engineering Design:
> Mechanical > Electrical
> Plumbing > Fire Protection
www.arpe-eng.com
Signature _____
Date _____

NOTES

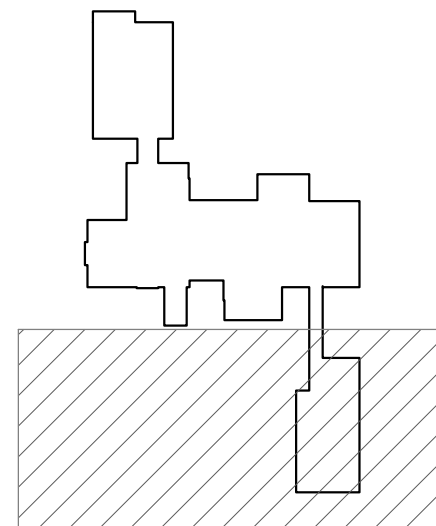

KEY PLAN

SCALE: 1/4" = 1'-0"

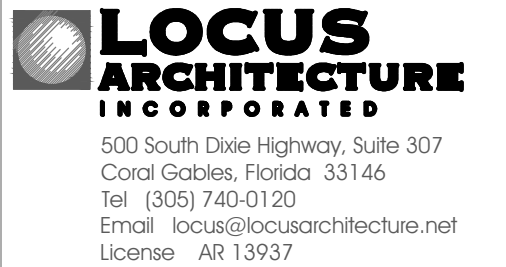

CONSULTANT(S)

NO.	REVISION/SUBMISSION	DATE
1	OWNER REVIEW	03-11-24
2	PERMIT SUBMITTAL	06-07-24

PROJECT

New 2-Story Residence:
6100 W Suburban Dr, Pinecrest, FL
33156

DRAWING

Partial First Floor Plan: 02

SEAL

SCALE
As Shown

DRAWN

REVIEWED

Nelson de Leon
AR 13937

PROJ. NO.
351

SHEET NO.

P-03.1