

04


04

03

04


04

03

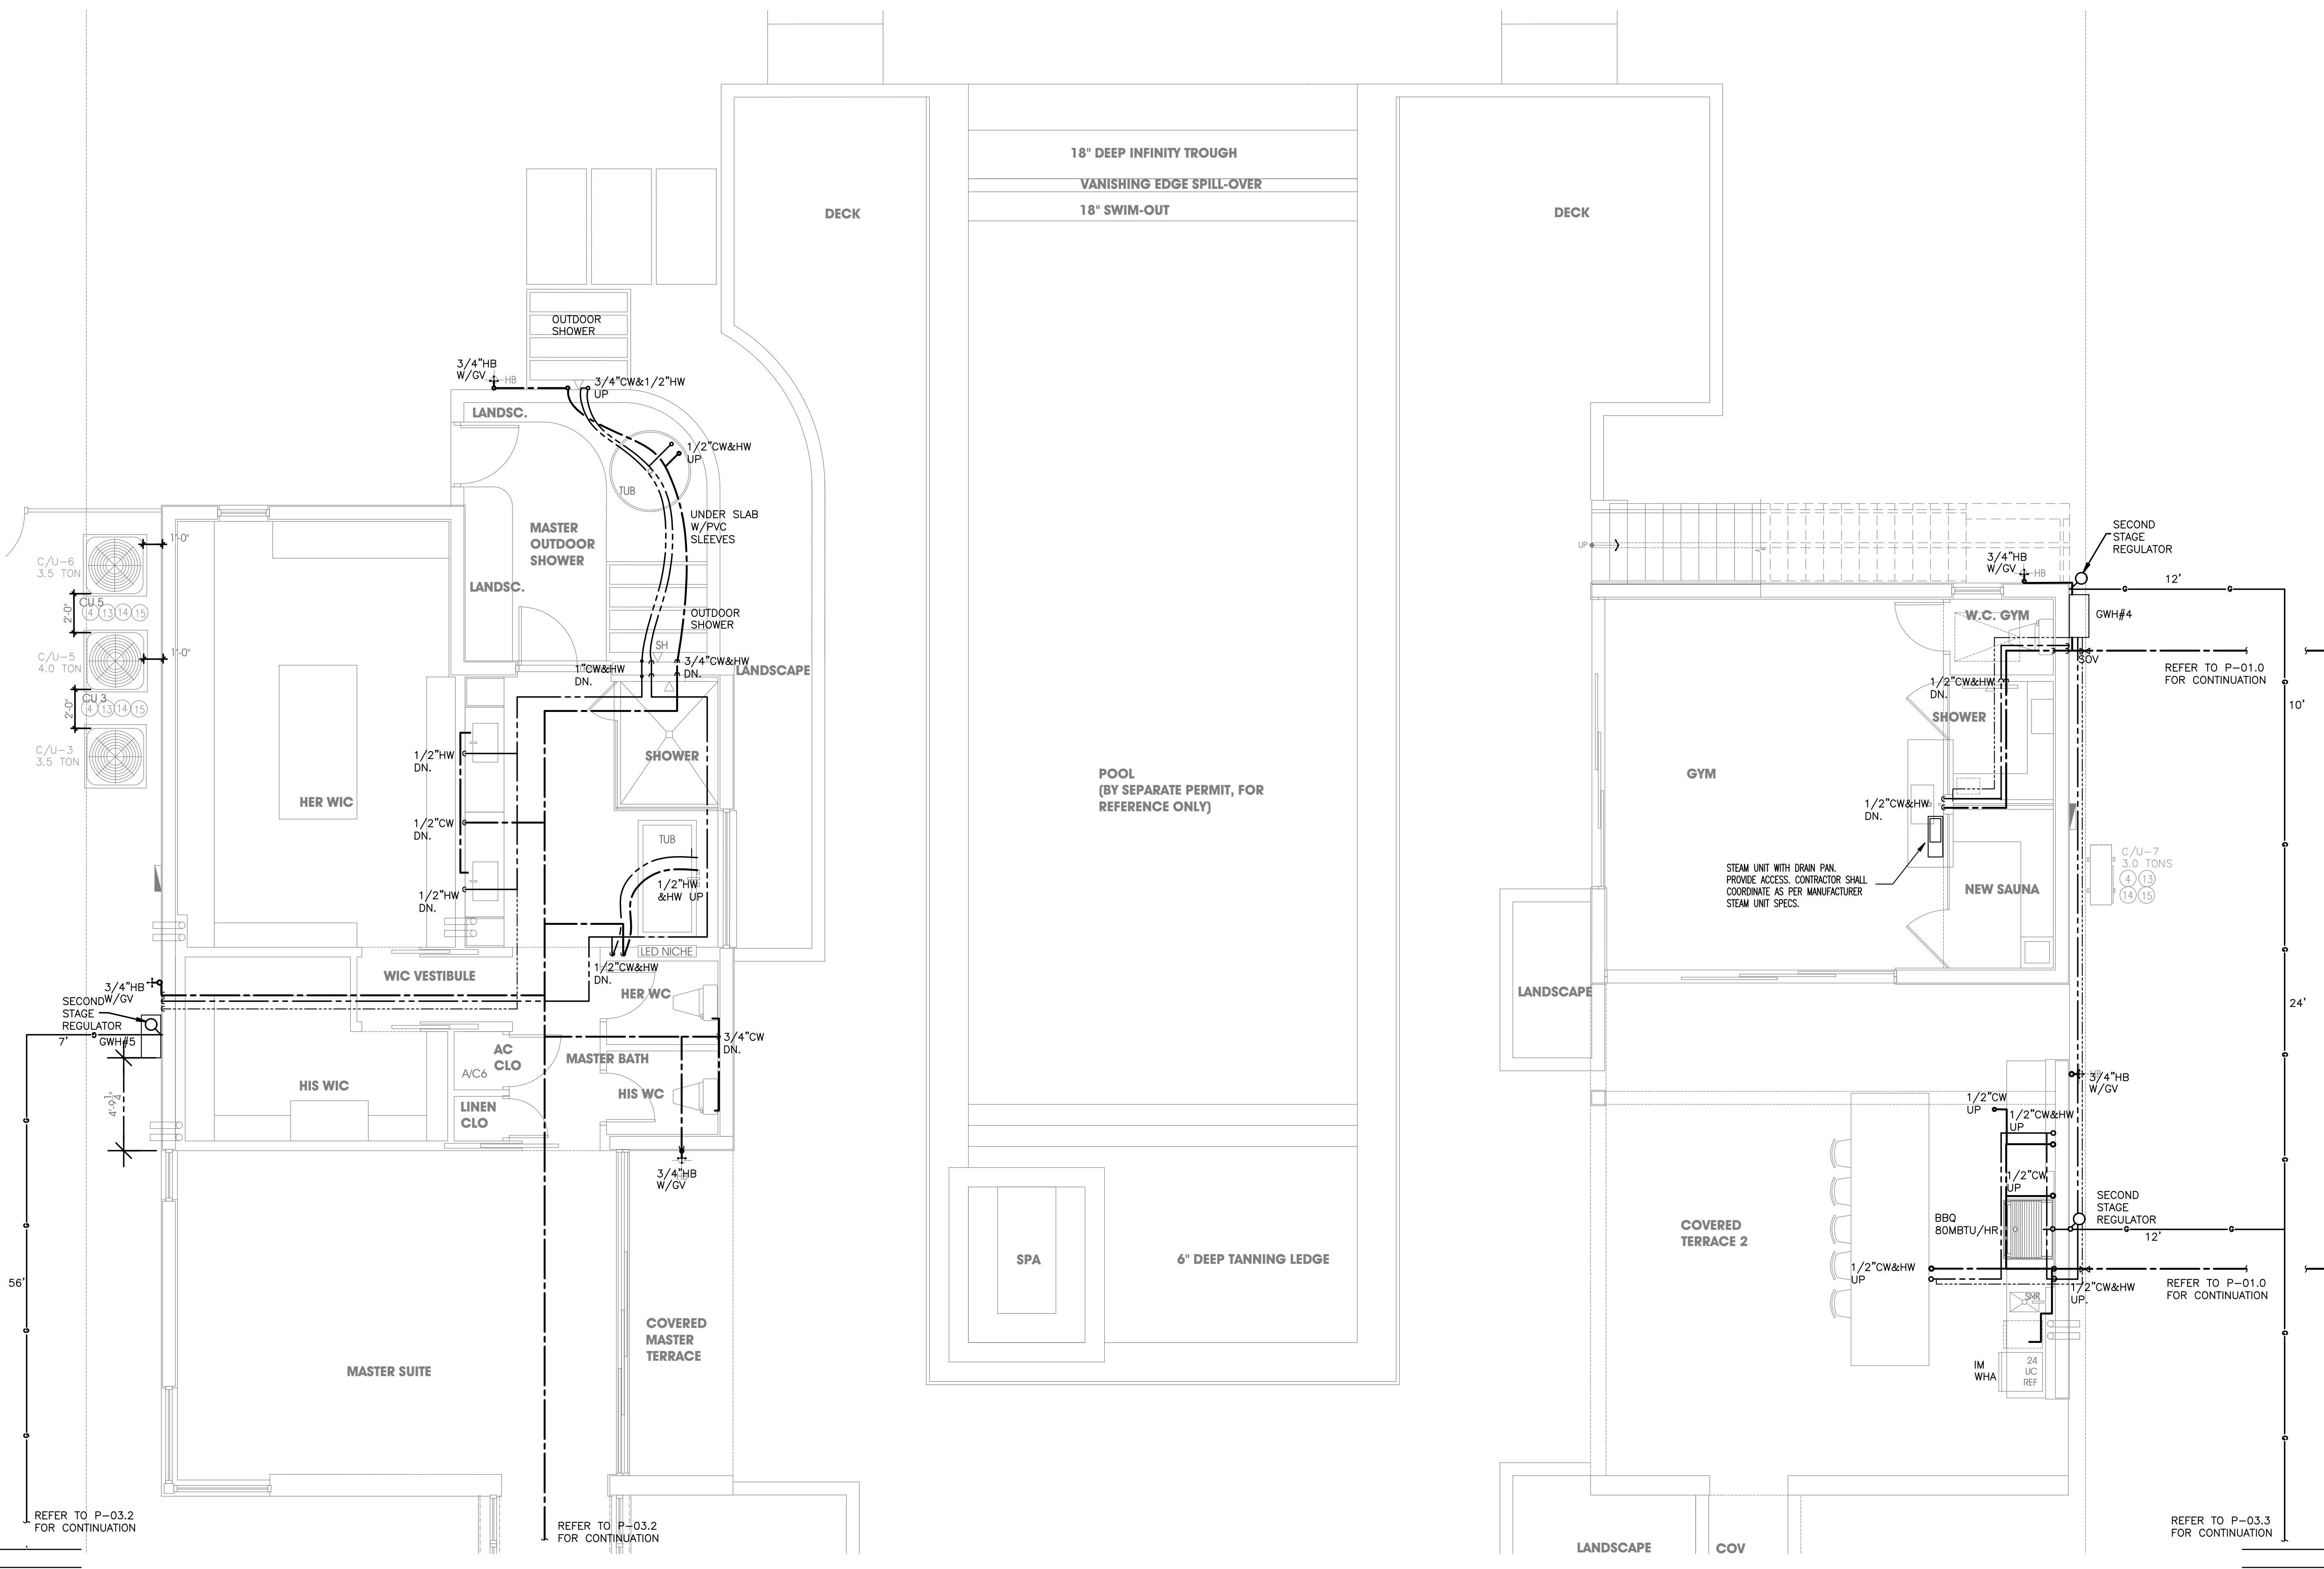

WATER & GAS PARTIAL FIRST FLOOR PLAN: 04

SCALE: 1/4" = 1'-0"

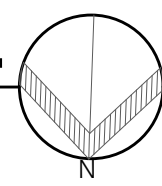

This item has been digitally signed and sealed by Amarilis Rodriguez, P.E. on 03/11/24. Printed copies of this document are not considered signed and sealed and the signature must be verified on any electronic copies.

JOB# 24-0407




2020 Ponce de Leon Blvd., Suite 1002
Coral Gables, Florida 33134
Phone > 305 444 8809
Fax > 305 444 9827

Amarilis Rodriguez, P.E.
License Number 60236
C.A. 26359

Engineering Design:
> Mechanical > Electrical
> Plumbing > Fire Protection
www.arpe-eng.com

Signature _____
Date _____

NOTES

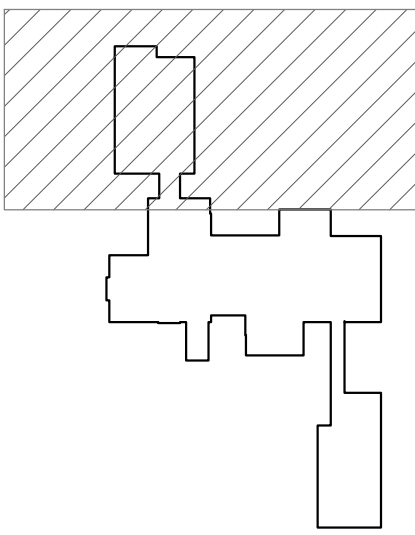

KEY PLAN

SCALE: 1/4" = 1'-0"



500 South Dixie Highway, Suite 307
Coral Gables, Florida 33146
Tel: (305) 740-0120
Email: locus@locusarchitecture.net
License: AR 13937

CONSULTANT(S)

NO.	REVISION/SUBMISSION	DATE
1	OWNER REVIEW	03-11-24
2	PERMIT SUBMITAL	06-07-24

PROJECT

New 2-Story Residence:
6100 W Suburban Dr, Pinecrest, FL 33156

DRAWING

Partial First Floor Plan: 04

SEAL

SCALE
As Shown

DRAWN

REVIEWED

Nelson de Leon
AR 13937

PROJ. NO.
351

SHEET NO.

P-03.3