

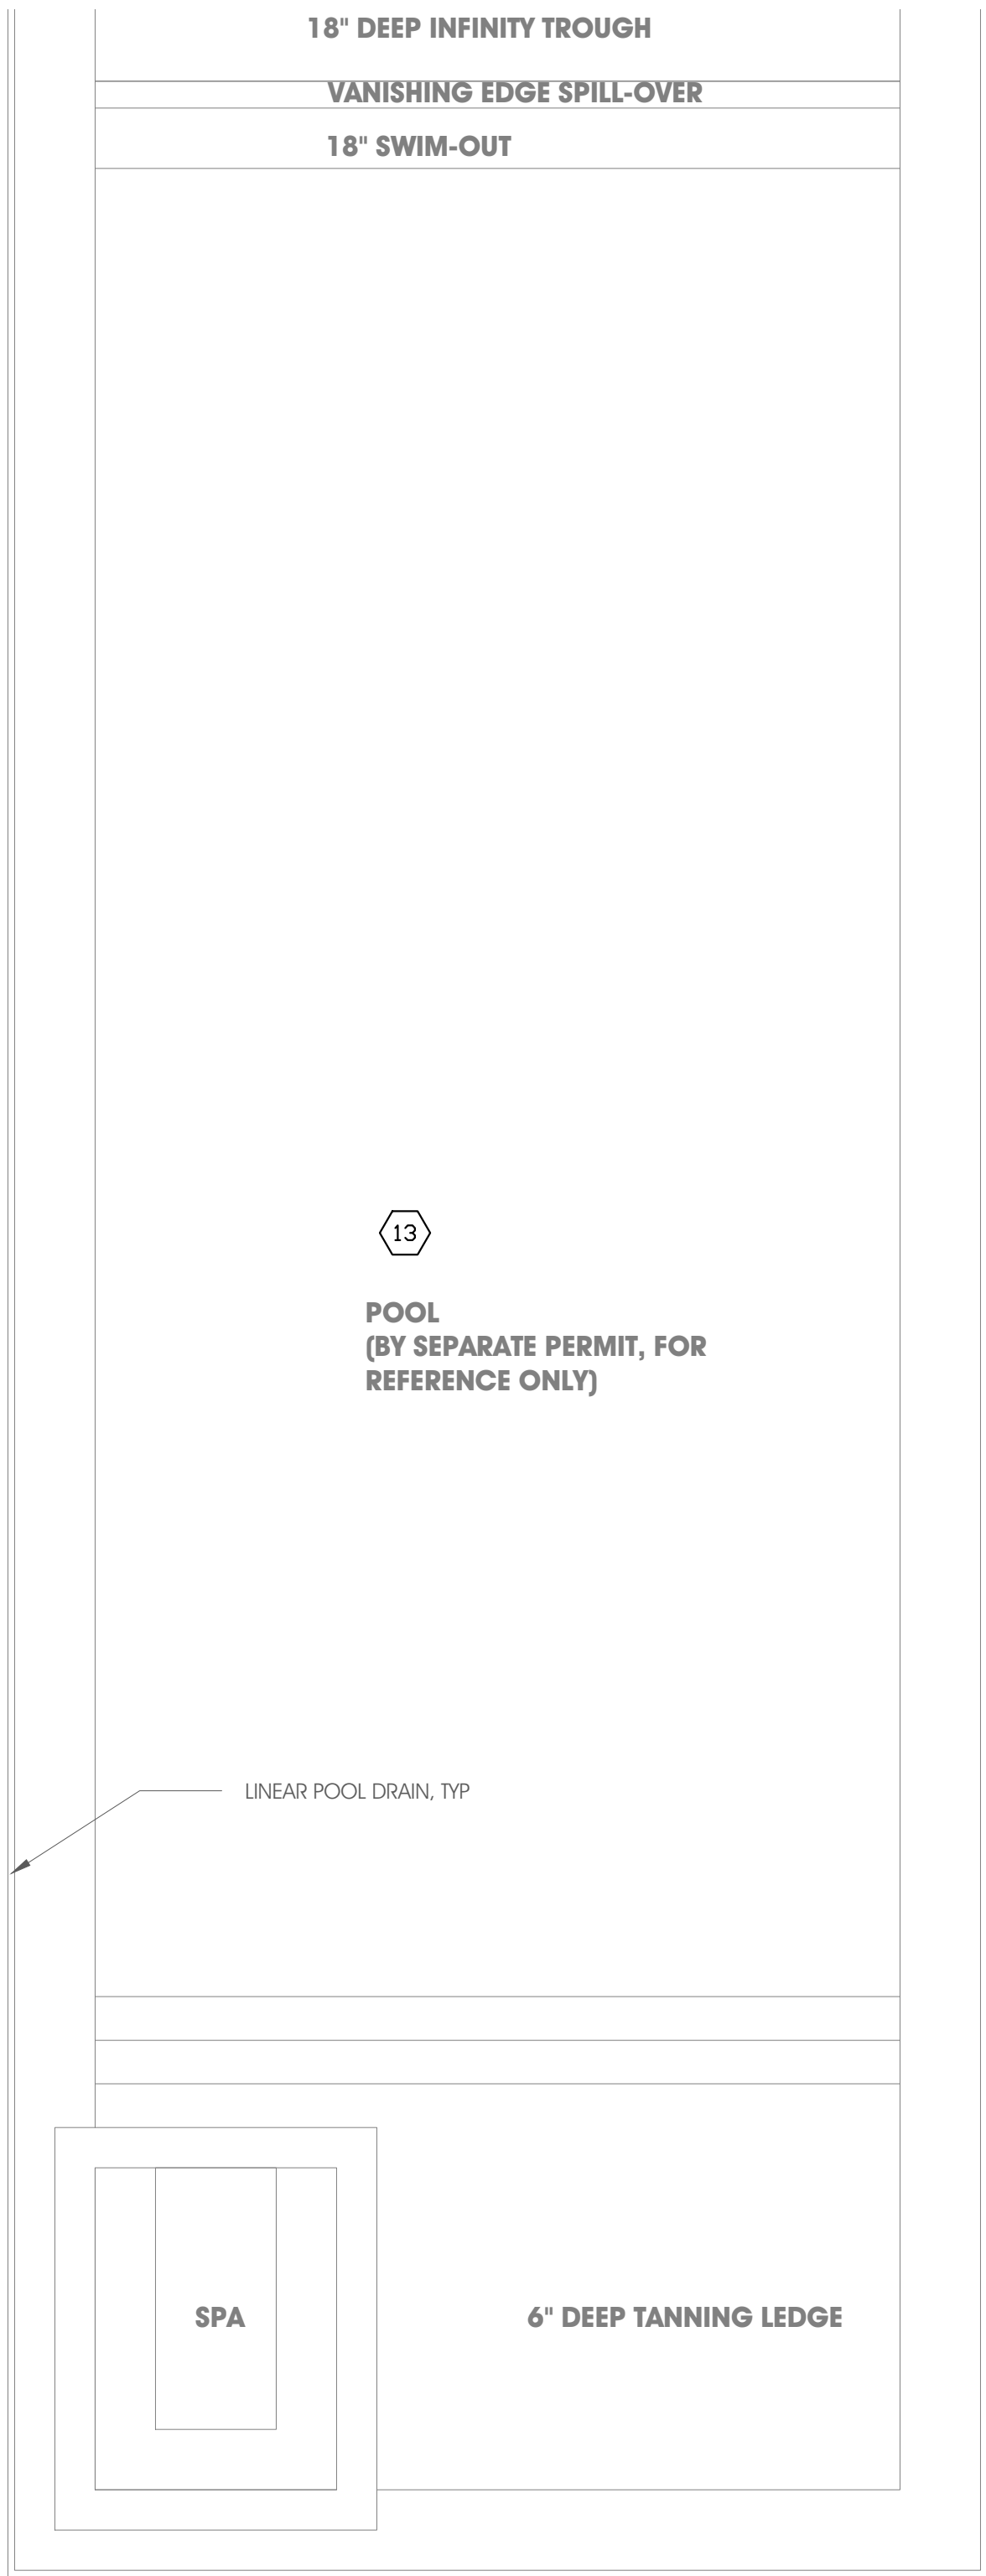


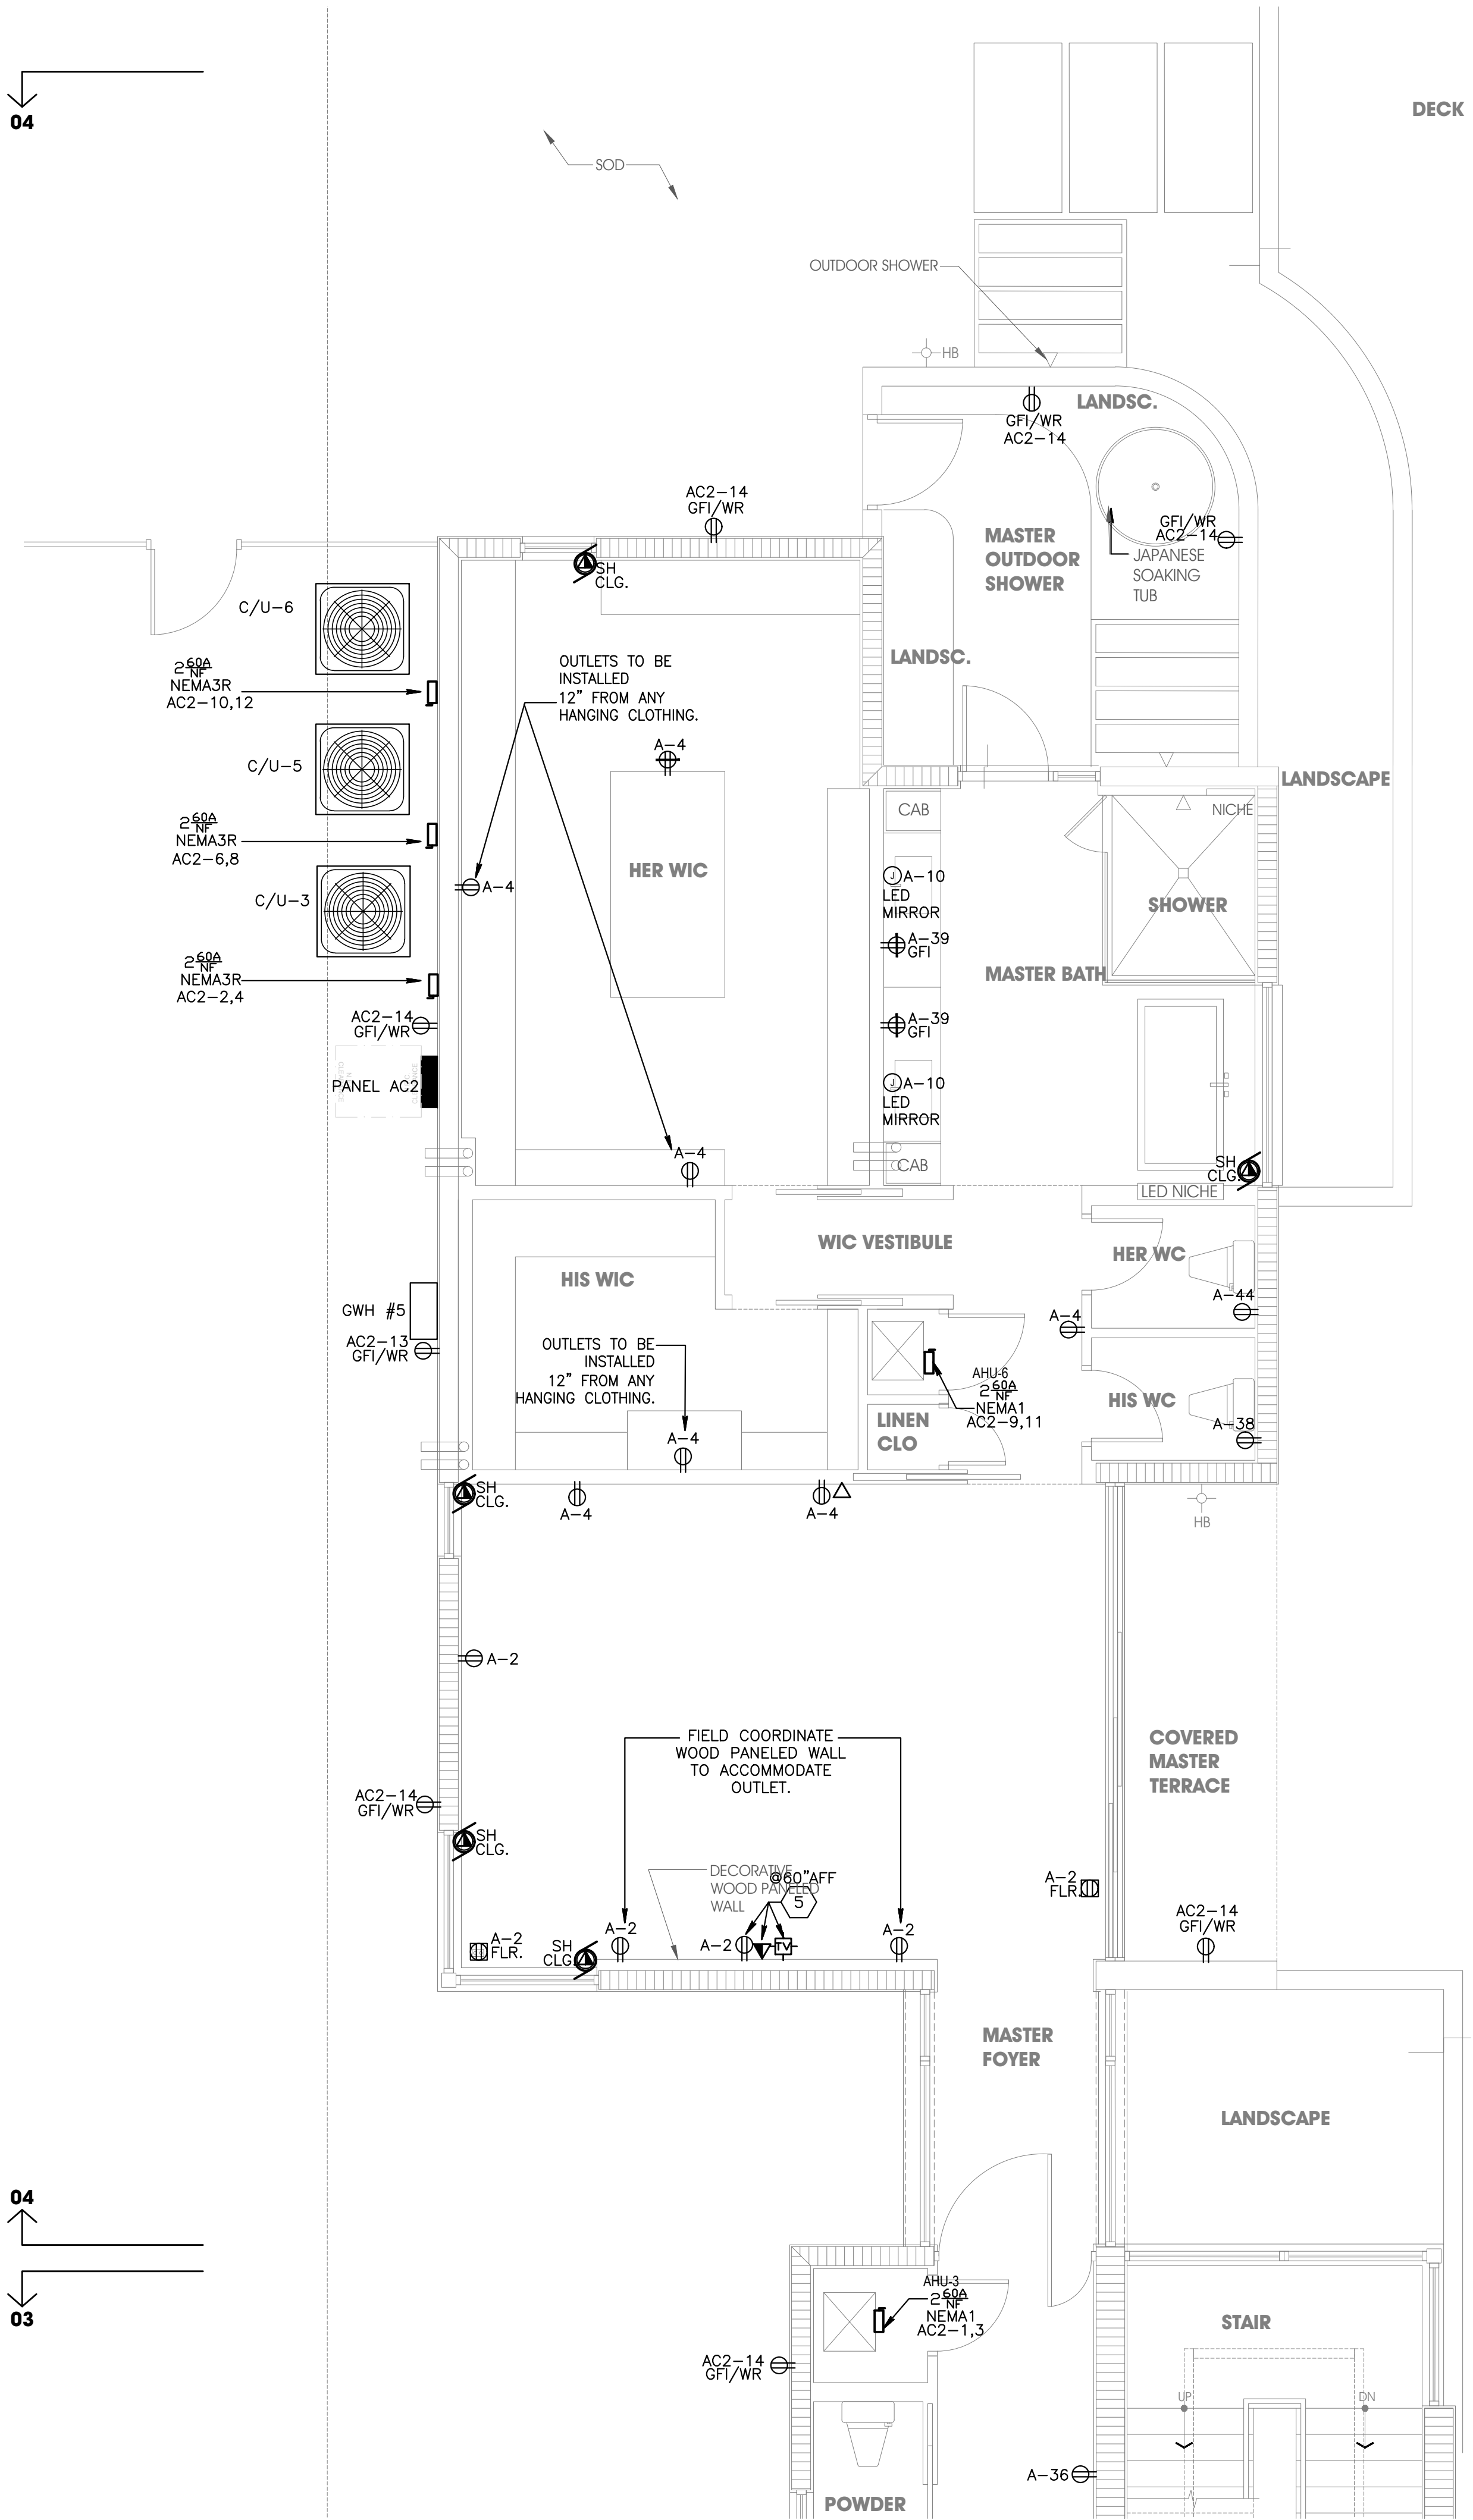

REFER TO SHEET E-01.0
SITE PLAN FOR LANDSCAPE
LIGHTS POWER LOCATIONS.

POWER PARTIAL FIRST FLOOR PLAN: 04

SCALE: 1/4" = 1'-0"

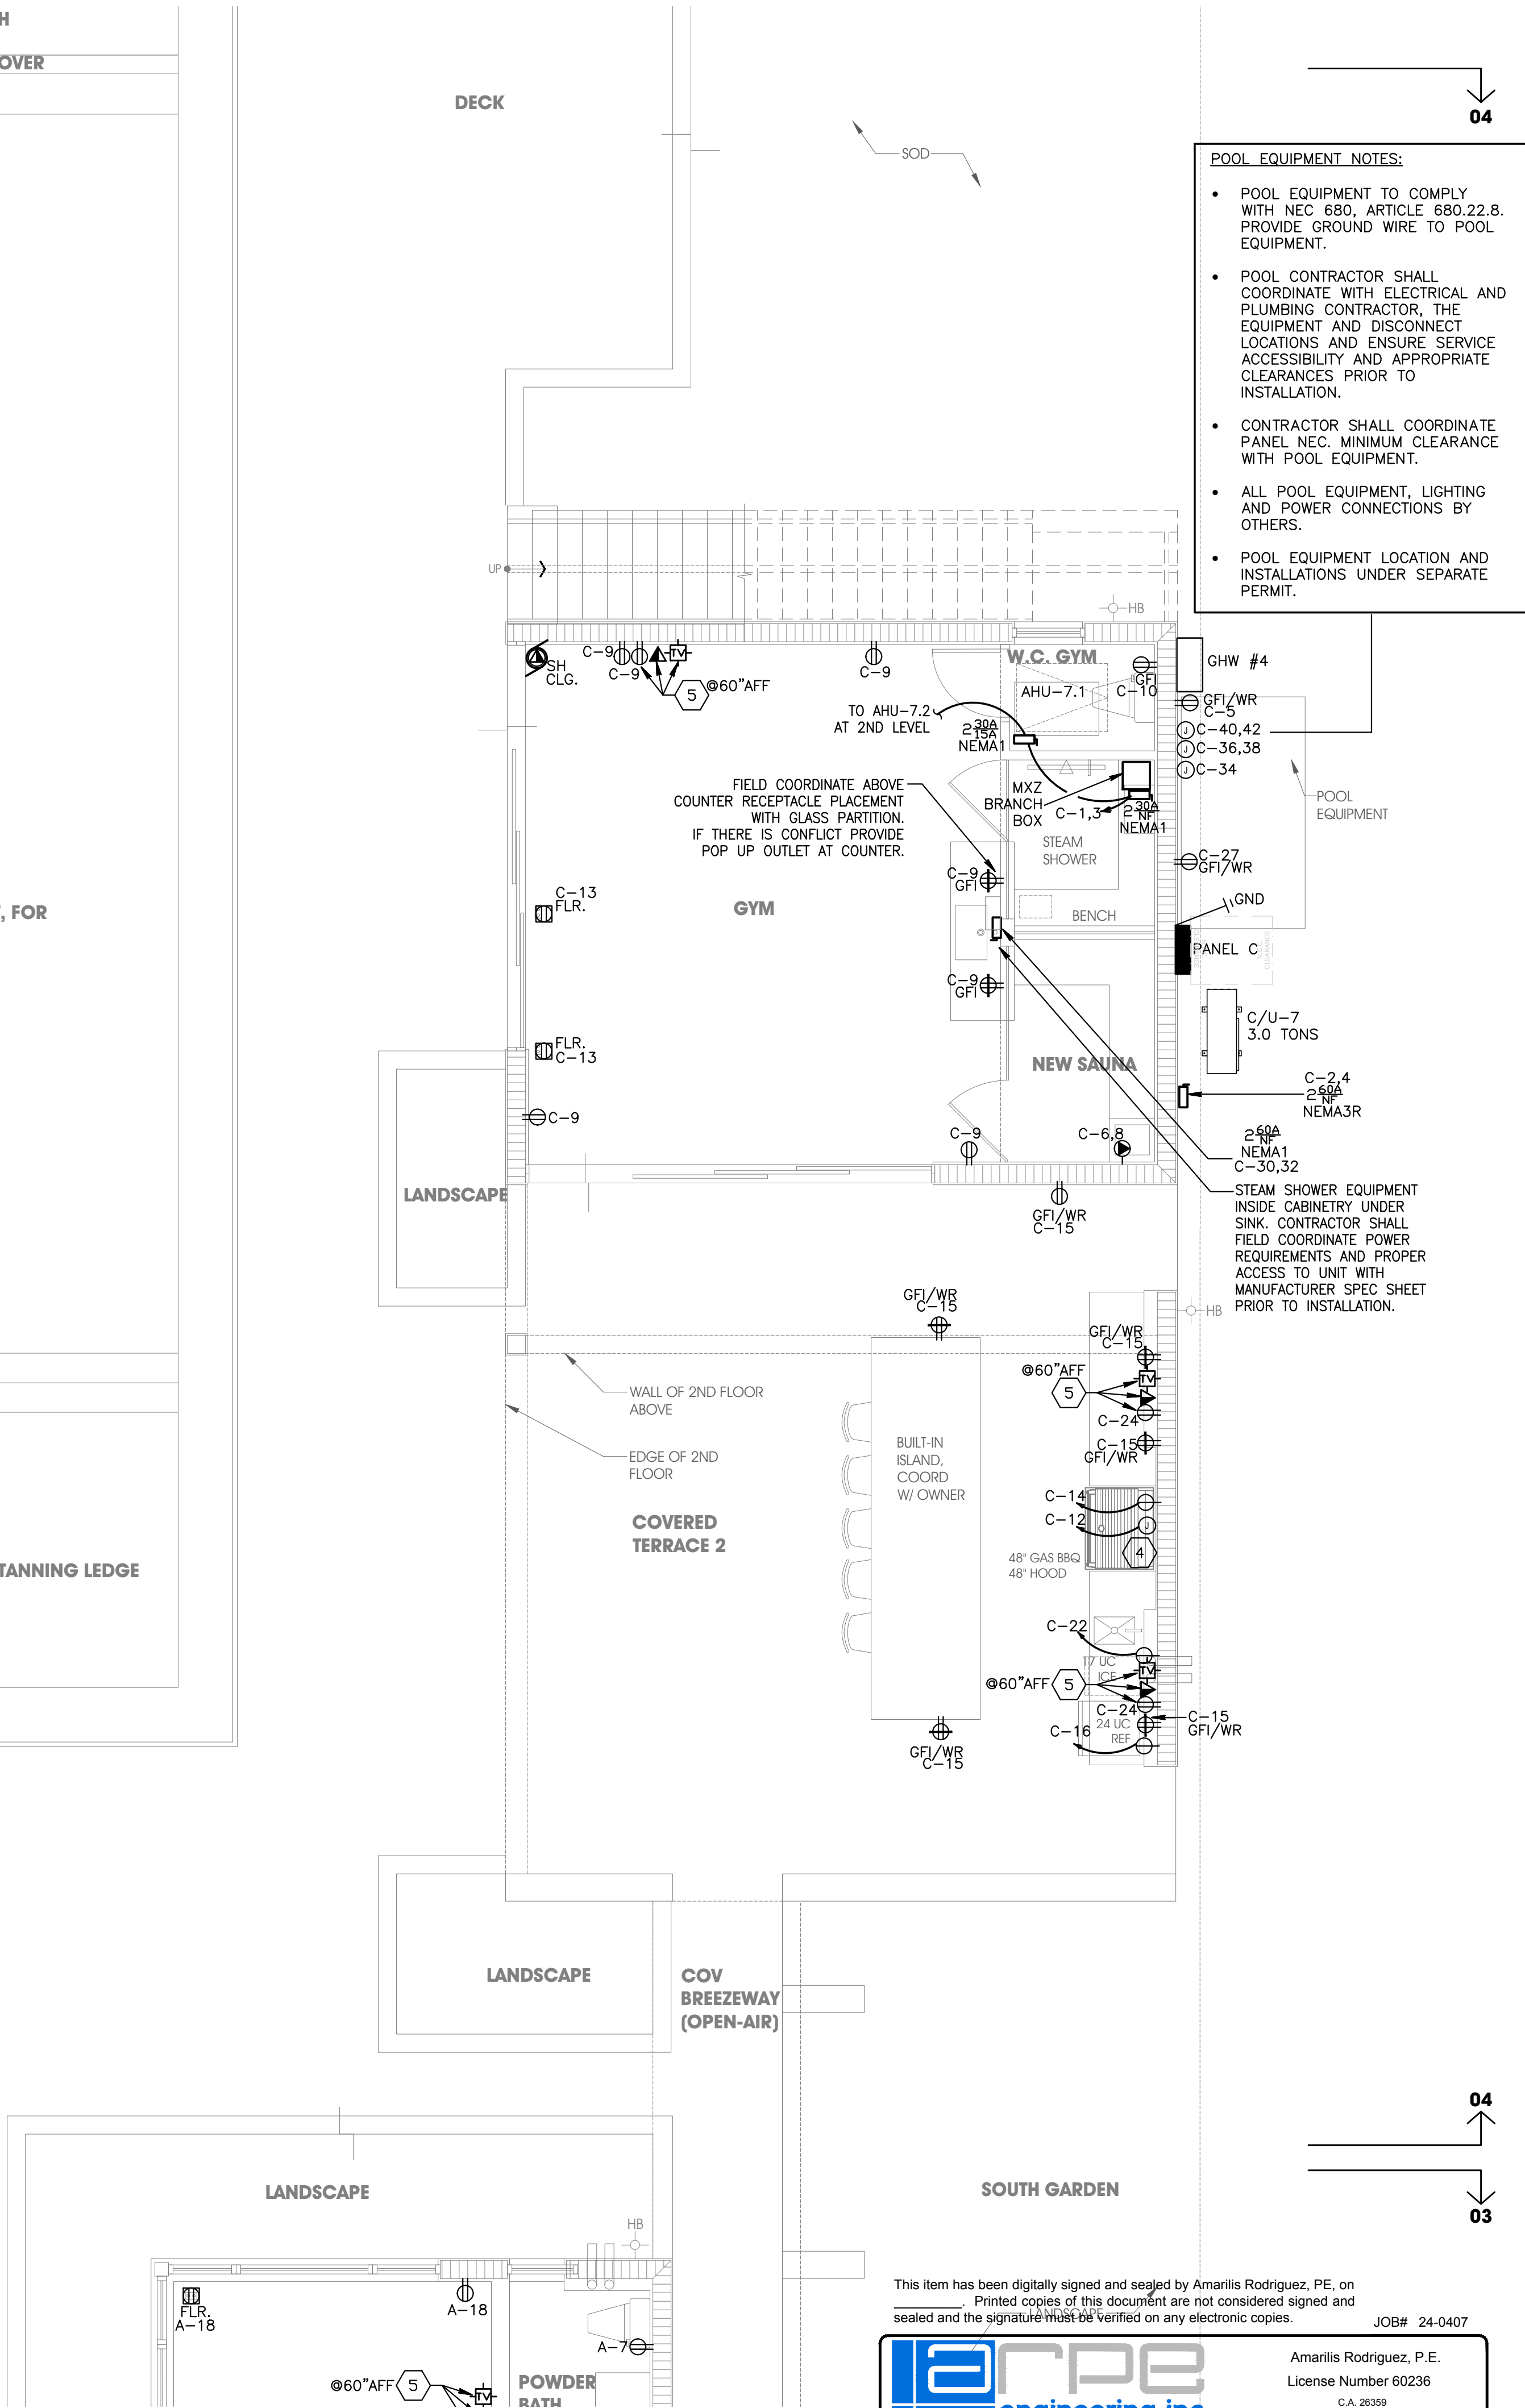

- POOL EQUIPMENT NOTES:**
- POOL EQUIPMENT TO COMPLY WITH NEC 680, ARTICLE 680.22.8. PROVIDE GROUND WIRE TO POOL EQUIPMENT.
 - POOL CONTRACTOR SHALL COORDINATE WITH ELECTRICAL AND PLUMBING CONTRACTOR, THE EQUIPMENT AND DISCONNECT LOCATIONS AND ENSURE SERVICE ACCESSIBILITY AND APPROPRIATE CLEARANCES PRIOR TO INSTALLATION.
 - CONTRACTOR SHALL COORDINATE PANEL NEC MINIMUM CLEARANCE WITH POOL EQUIPMENT.
 - ALL POOL EQUIPMENT, LIGHTING AND POWER CONNECTIONS BY OTHERS.
 - POOL EQUIPMENT LOCATION AND INSTALLATIONS UNDER SEPARATE PERMIT.

This item has been digitally signed and sealed by Amarilis Rodriguez, P.E. on
Printed copies of this document are not considered signed and
sealed and the signature must be verified on any electronic copies.

JOB# 24-0407

arpe
engineering inc


2020 Ponce de Leon Blvd., Suite 1002
Coral Gables, Florida 33134
Phone > 305 444 9809
Fax > 305 444 9827

Engineering Design:
> Mechanical > Electrical
> Plumbing > Fire Protection
www.arpe-eng.com

Amarilis Rodriguez, P.E.
License Number 60236
C.A. 26359

Signature _____
Date _____

NOTES

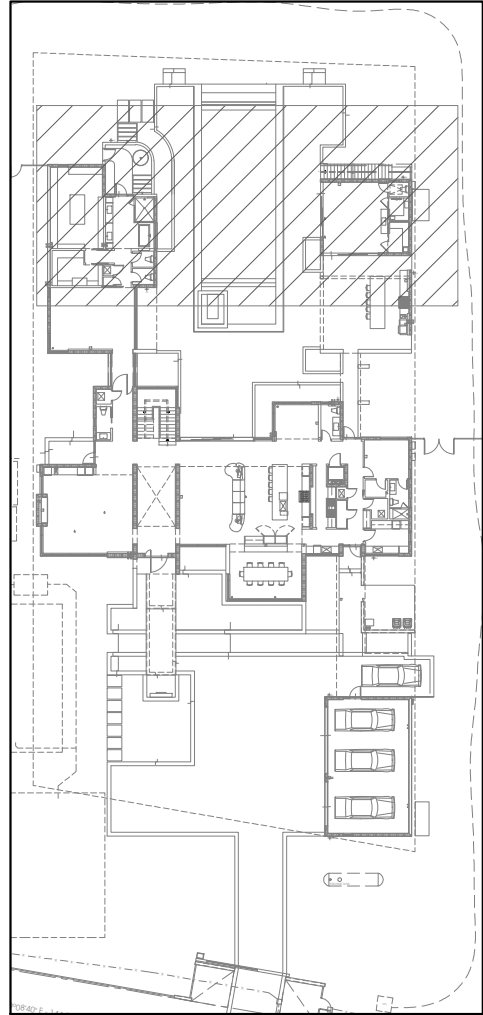

KEY PLAN

SCALE: NTS

LOCUS
ARCHITECTURE
INCORPORATED

500 South Dixie Highway, Suite 307
Coral Gables, Florida 33146
Tel: (305) 740-0120
Email: locus@locusarchitecture.net
License: AR 13937

CONSULTANT(S)

NO.	REVISION/SUBMISSION	DATE
	OWNER REVIEW	03-11-24
	PERMIT SUBMITTAL	06-07-24

PROJECT

New 2-Story Residence:
6100 W Suburban Dr, Pinecrest, FL 33156

DRAWING

Power PartialFirst Floor Plan: 04

SEAL

SCALE

As Shown

DRAWN

REVIEWED

Nelson de Leon
AR 13937

PROJ. NO.
351

SHEET NO.

E-02.3