


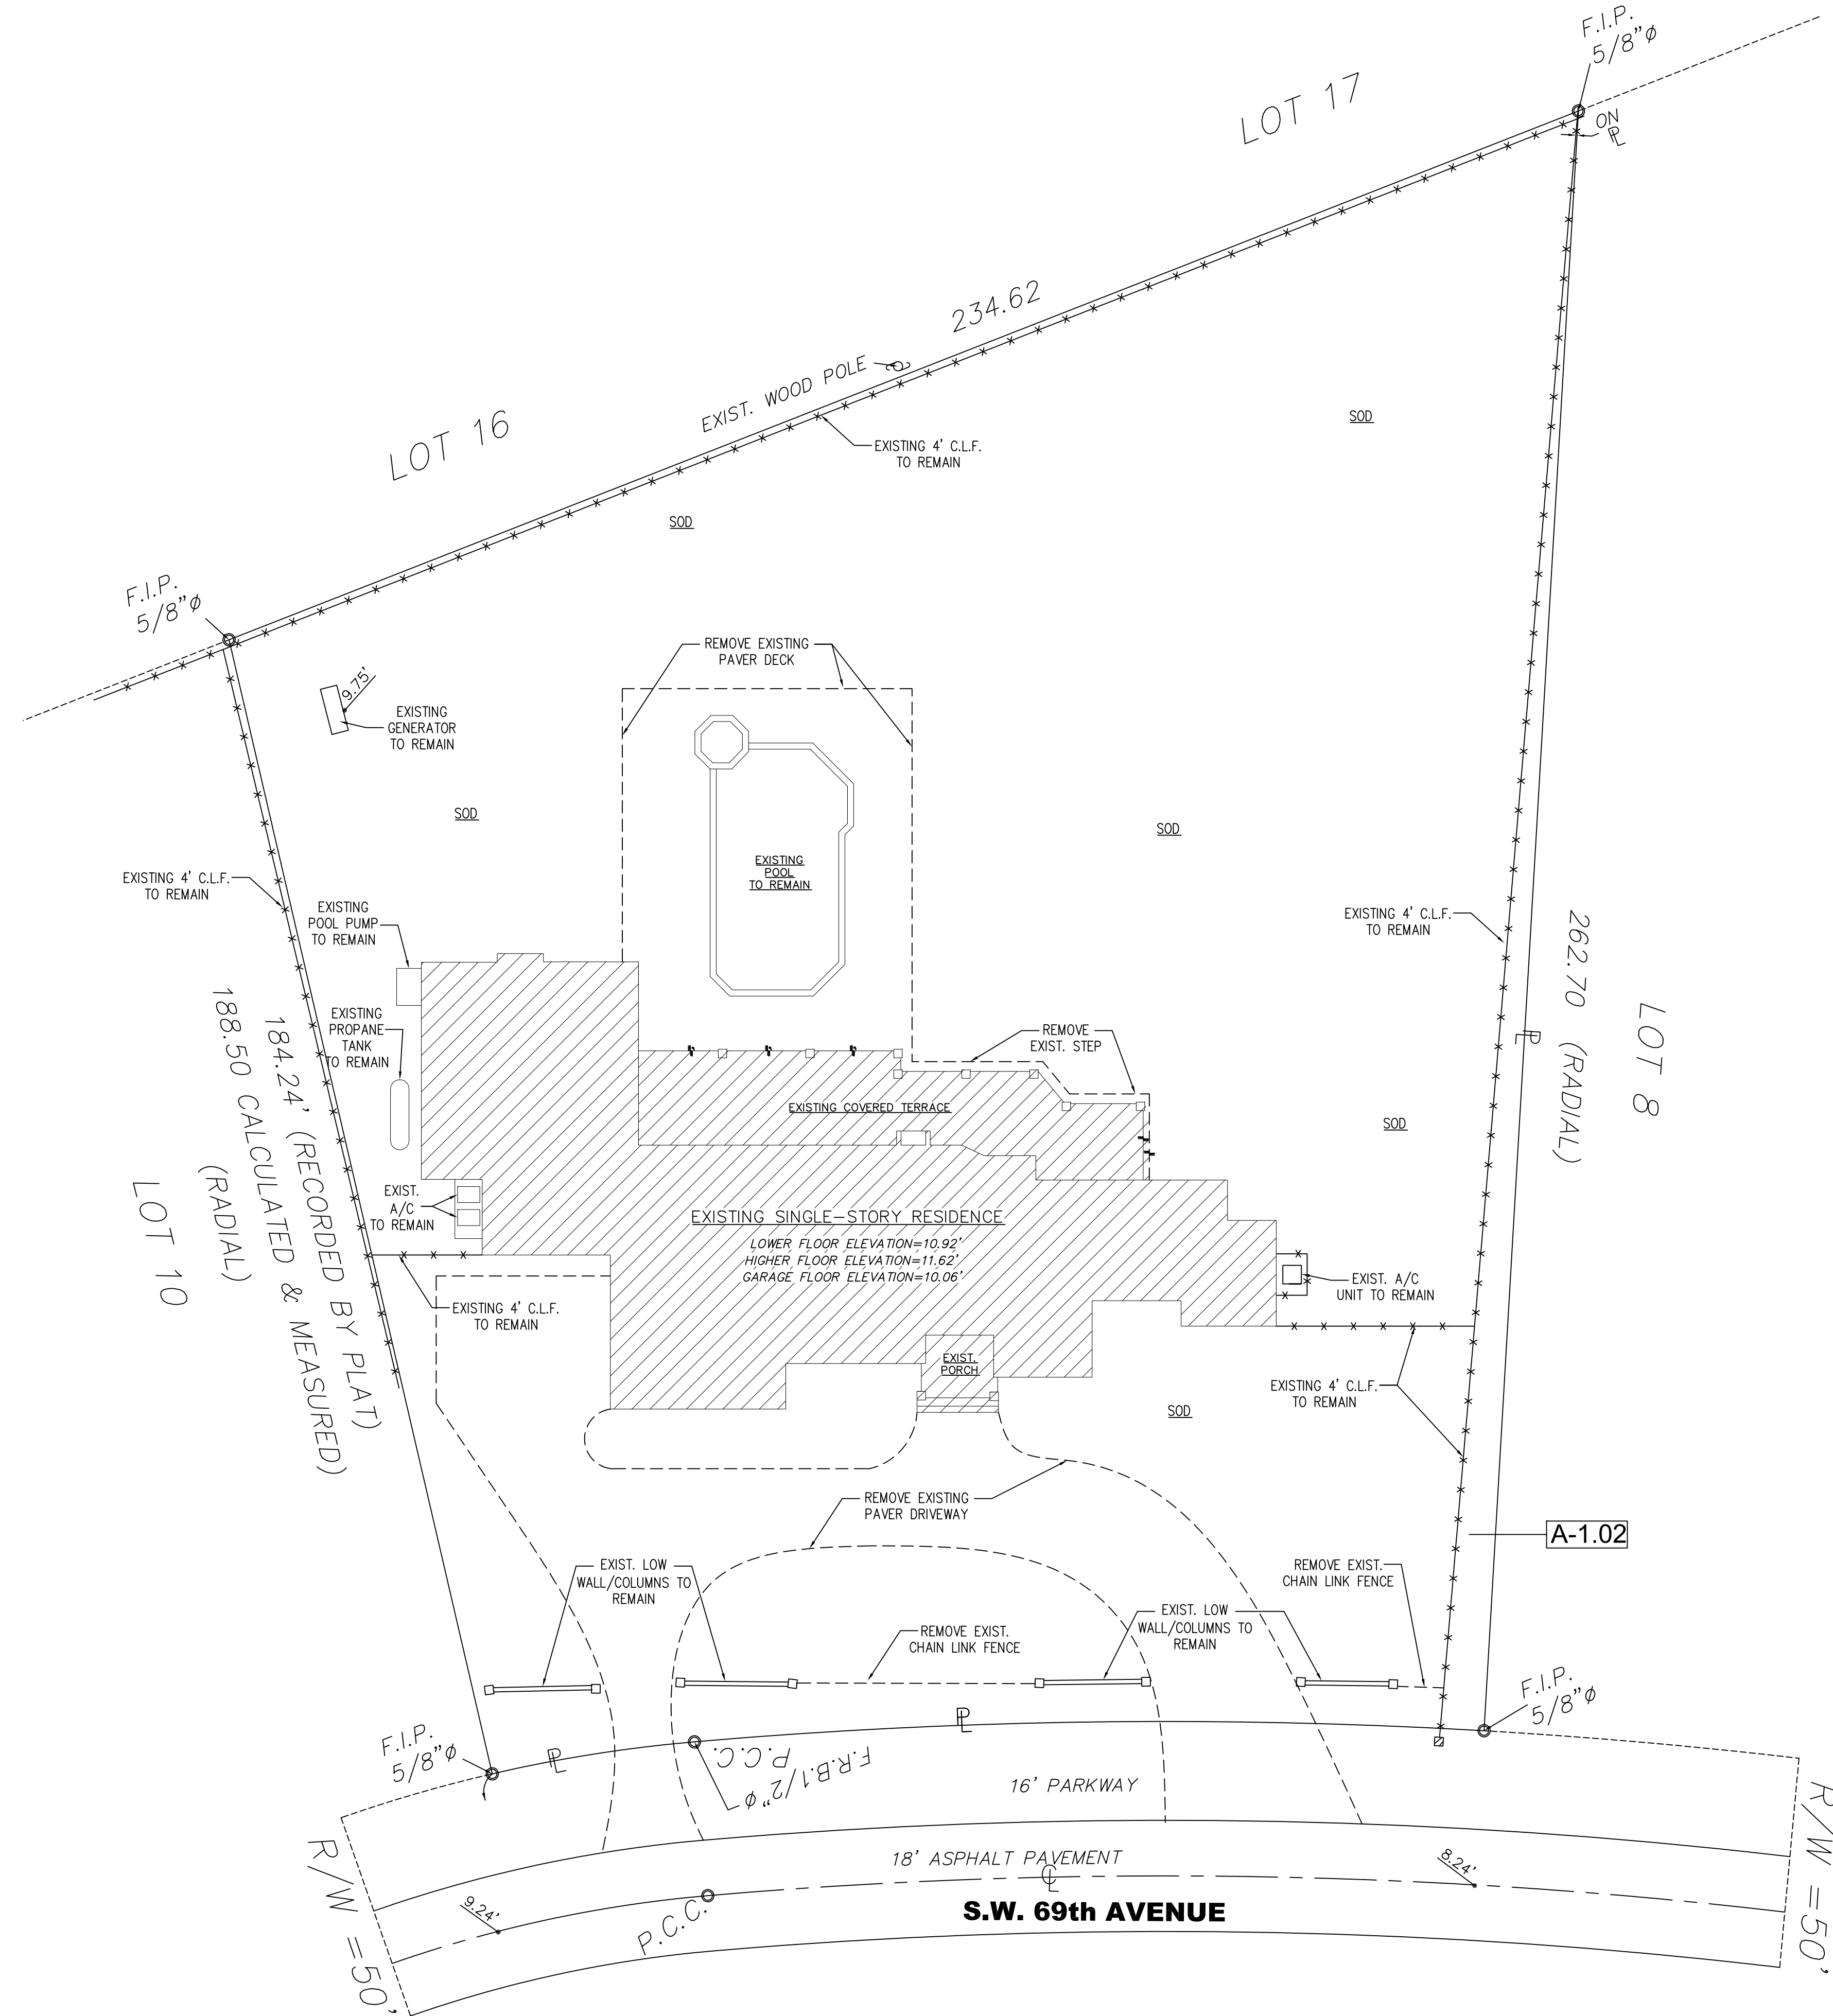

- LEGEND :
- EXISTING 8" CONC. BLK WALL
 - TO BE DEMOLISHED
- TYP. DEMOLITION NOTES :
- CAP EXISTING ELECTRICAL AND PLUMBING FIXTURES BEING REMOVED.
 - DURING DEMOLITION PROCESS IF ANY STRUCTURAL WALLS, COL'S AND BEAMS ARE ENCOUNTERED NOTIFY THE ARCHITECT/ENGINEER DO NOT SAW-CUT ANY STRUCTURAL SLABS WITHOUT INSTRUCTIONS FROM THE STRUCTURAL ENGINEER.
 - DISCONNECT ELECTRICAL MAIN PRIOR TO DEMOLITION.
 - DISCONNECT WATER MAIN PRIOR TO DEMOLITION.
 - DISCONNECT GAS MAIN PRIOR TO DEMOLITION.
 - REMOVE ALL ELECTRICAL FIXTURES & HOUSING, ELECTRICAL CONDUITS & WIRING TO REMAIN, TEMPORARY CAP AS REQUIRED FOR FUTURE USE.
 - PROVIDE TEMPORARY BARRIER FOR ALL DROPS OVER 24" HIGH.
 - REMOVE EXTERIOR WINDOWS & DOORS AS SHOWN ON PLAN.
 - ALL NEW EXTERIOR OPENING SHALL BE TEMPORARILY COVERED W/ PLYWOOD.
 - CONTRACTOR SHALL TAKE SPECIAL CARE DURING DEMOLITION PROCESS AND PROVIDE PROPER PROTECTION FOR SECURITY & WEATHER DURING CONSTRUCTION DOWN TIME.
 - CONTRACTOR SHALL BE RESPONSIBLE FOR METHODS AND COORDINATION DURING DEMOLITION INCLUDING PROPER SHORING OF STRUCTURAL ELEMENTS. NOTIFY ARCHITECT IMMEDIATELY IN CASE OF DISCREPANCY.
 - TREE PROTECTION BARRIERS MUST BE IN PLACE DURING DEMOLITION AND CONSTRUCTION.

CONSULTANTS

PROJECT NAME:
GOMEZ DRIVEWAY & BACKYARD REMODEL

OWNER:
WILLIAM GOMEZ & DANIELLA VILAR
11040 SW 69th AVENUE
PINECREST, FL 33156

JOB NUMBER: 2024.01
DATE: 02/17/24

REVISION
△
△
SEAL:

John Alexander Quintana AR99532

DRAWING TITLE:
DEMOLITION SITE PLAN

DRAWING NO:

D1.00

DEMOLITION SITE PLAN
SCALE: 1/16" = 1'-0"

A SEPARATE PERMIT AND PRODUCT CONTROL APPROVAL, WHEN APPLICABLE, IS REQUIRED FOR THE FOLLOWING ITEMS:
STRUCTURAL GLAZING WOOD TRUSSES DOORS ROOFING WINDOWS
RIDGE VENTILATION CURTAIN WALLS MULLIONS SIGNS GLASS WALL
PRECAST SYSTEMS HANDRAILS RAILS STORE FRONT FENCES
STORM SHUTTERS STEEL JOISTS