


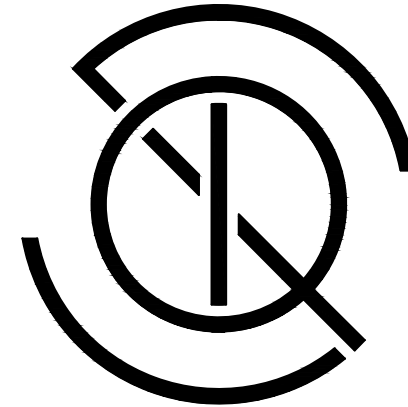

Q DESIGN STUDIO
ARCHITECTURE & PLANNING

License No AR99532

Q Design Studio, LLC
8000 SW 88th Court
Miami, FL 33173
T. 305.401.4950
E: John.Quintana10@gmail.com

PROJECT NAME:

GOMEZ DRIVEWAY & BACKYARD REMODEL

OWNER:
WILLIAM GOMEZ & DANIELLA VILAR
11040 SW 69th AVENUE
PINECREST, FL 33156

JOB NUMBER: 2024.01
DATE: 06.17.2024

REVISION

△	
△	

ERNESTO RODRIGUEZ, P.E.
P.E. # 58155

MECHANICAL, ELECTRICAL, PLUMBING, & FIRE
PROTECTION ENGINEERING DESIGN & CONSULTING
Office (305) 663-9191
Email ernesto@rodriguezpe.com
Address 4255 S.W. 72 Ave, Miami FL 33155

PLANS ARE PROTECTED UNDER THE COPYRIGHT LAWS
OF FLORIDA. ALL RIGHTS RESERVED.

CONTRACTOR SHALL VERIFY AND BE RESPONSIBLE FOR ALL DIMENSIONS
AND CONDITIONS ON THE JOB. THE DESIGN PROFESSIONAL MUST BE
NOTIFIED IN WRITING OF ANY VARIATION FROM THE PLANS.
ALL REVISIONS, AMENDMENTS AND PLANS INDICATED OF
REPRESENTED BY THIS DRAWING ARE OWNED BY AND THE PROPERTY OF
THE DESIGN PROFESSIONAL AND WERE CREATED, EVOLVED AND DEVELOPED
FOR USE ON AND IN CONNECTION WITH THE SPECIFIC PROJECT. ANY
CHANGES TO THESE PLANS WITHOUT THE WRITTEN APPROVAL OF THE
DESIGN PROFESSIONAL OR ANY CONSTRUCTION DEVIATED FROM THESE
PLANS WITHOUT EXPRESSED APPROVAL OF THE DESIGN PROFESSIONAL
SHALL AUTOMATICALLY RENDER THE DESIGN PROFESSIONAL AND THE
ENGINEERING CONSULTING FIRM LIABLE TO ANY PARTY FOR ANY
CLAIMS, SUIT OR LITIGATION BY ANY INTERESTED PARTIES OF THE PROJECT.
NO PART OF THESE PLANS SHALL BE COPIED OR REPRODUCED BY
ANY MEANS, OR USED IN CONNECTION WITH ANY WORK OTHER THAN FOR
THE SPECIFIC PROJECT FOR WHICH THEY HAVE BEEN PREPARED WITHOUT
WRITTEN CONSENT OF THE DESIGN PROFESSIONAL.

SEAL:

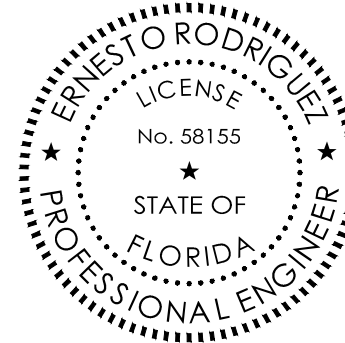


NOT VALID FOR CONSTRUCTION OR BIDDING
WITHOUT SIGNATURE & APPROVAL STAMPS.
THIS DOCUMENT HAS BEEN DIGITALLY SIGNED AND
SEALED BY ERNESTO RODRIGUEZ, P.E. ON DATE
AS APPEARS IN THE DIGITAL SIGNATURE. PRINTED
COPIES OF THIS DOCUMENT ARE NOT CONSIDERED
SIGNED AND SEALED AND THE SIGNATURE MUST
BE VERIFIED ON ANY ELECTRONIC COPIES.

DRAWING TITLE:

LP GAS PLUMBING FLOOR PLAN

DRAWING NO:


P3.00

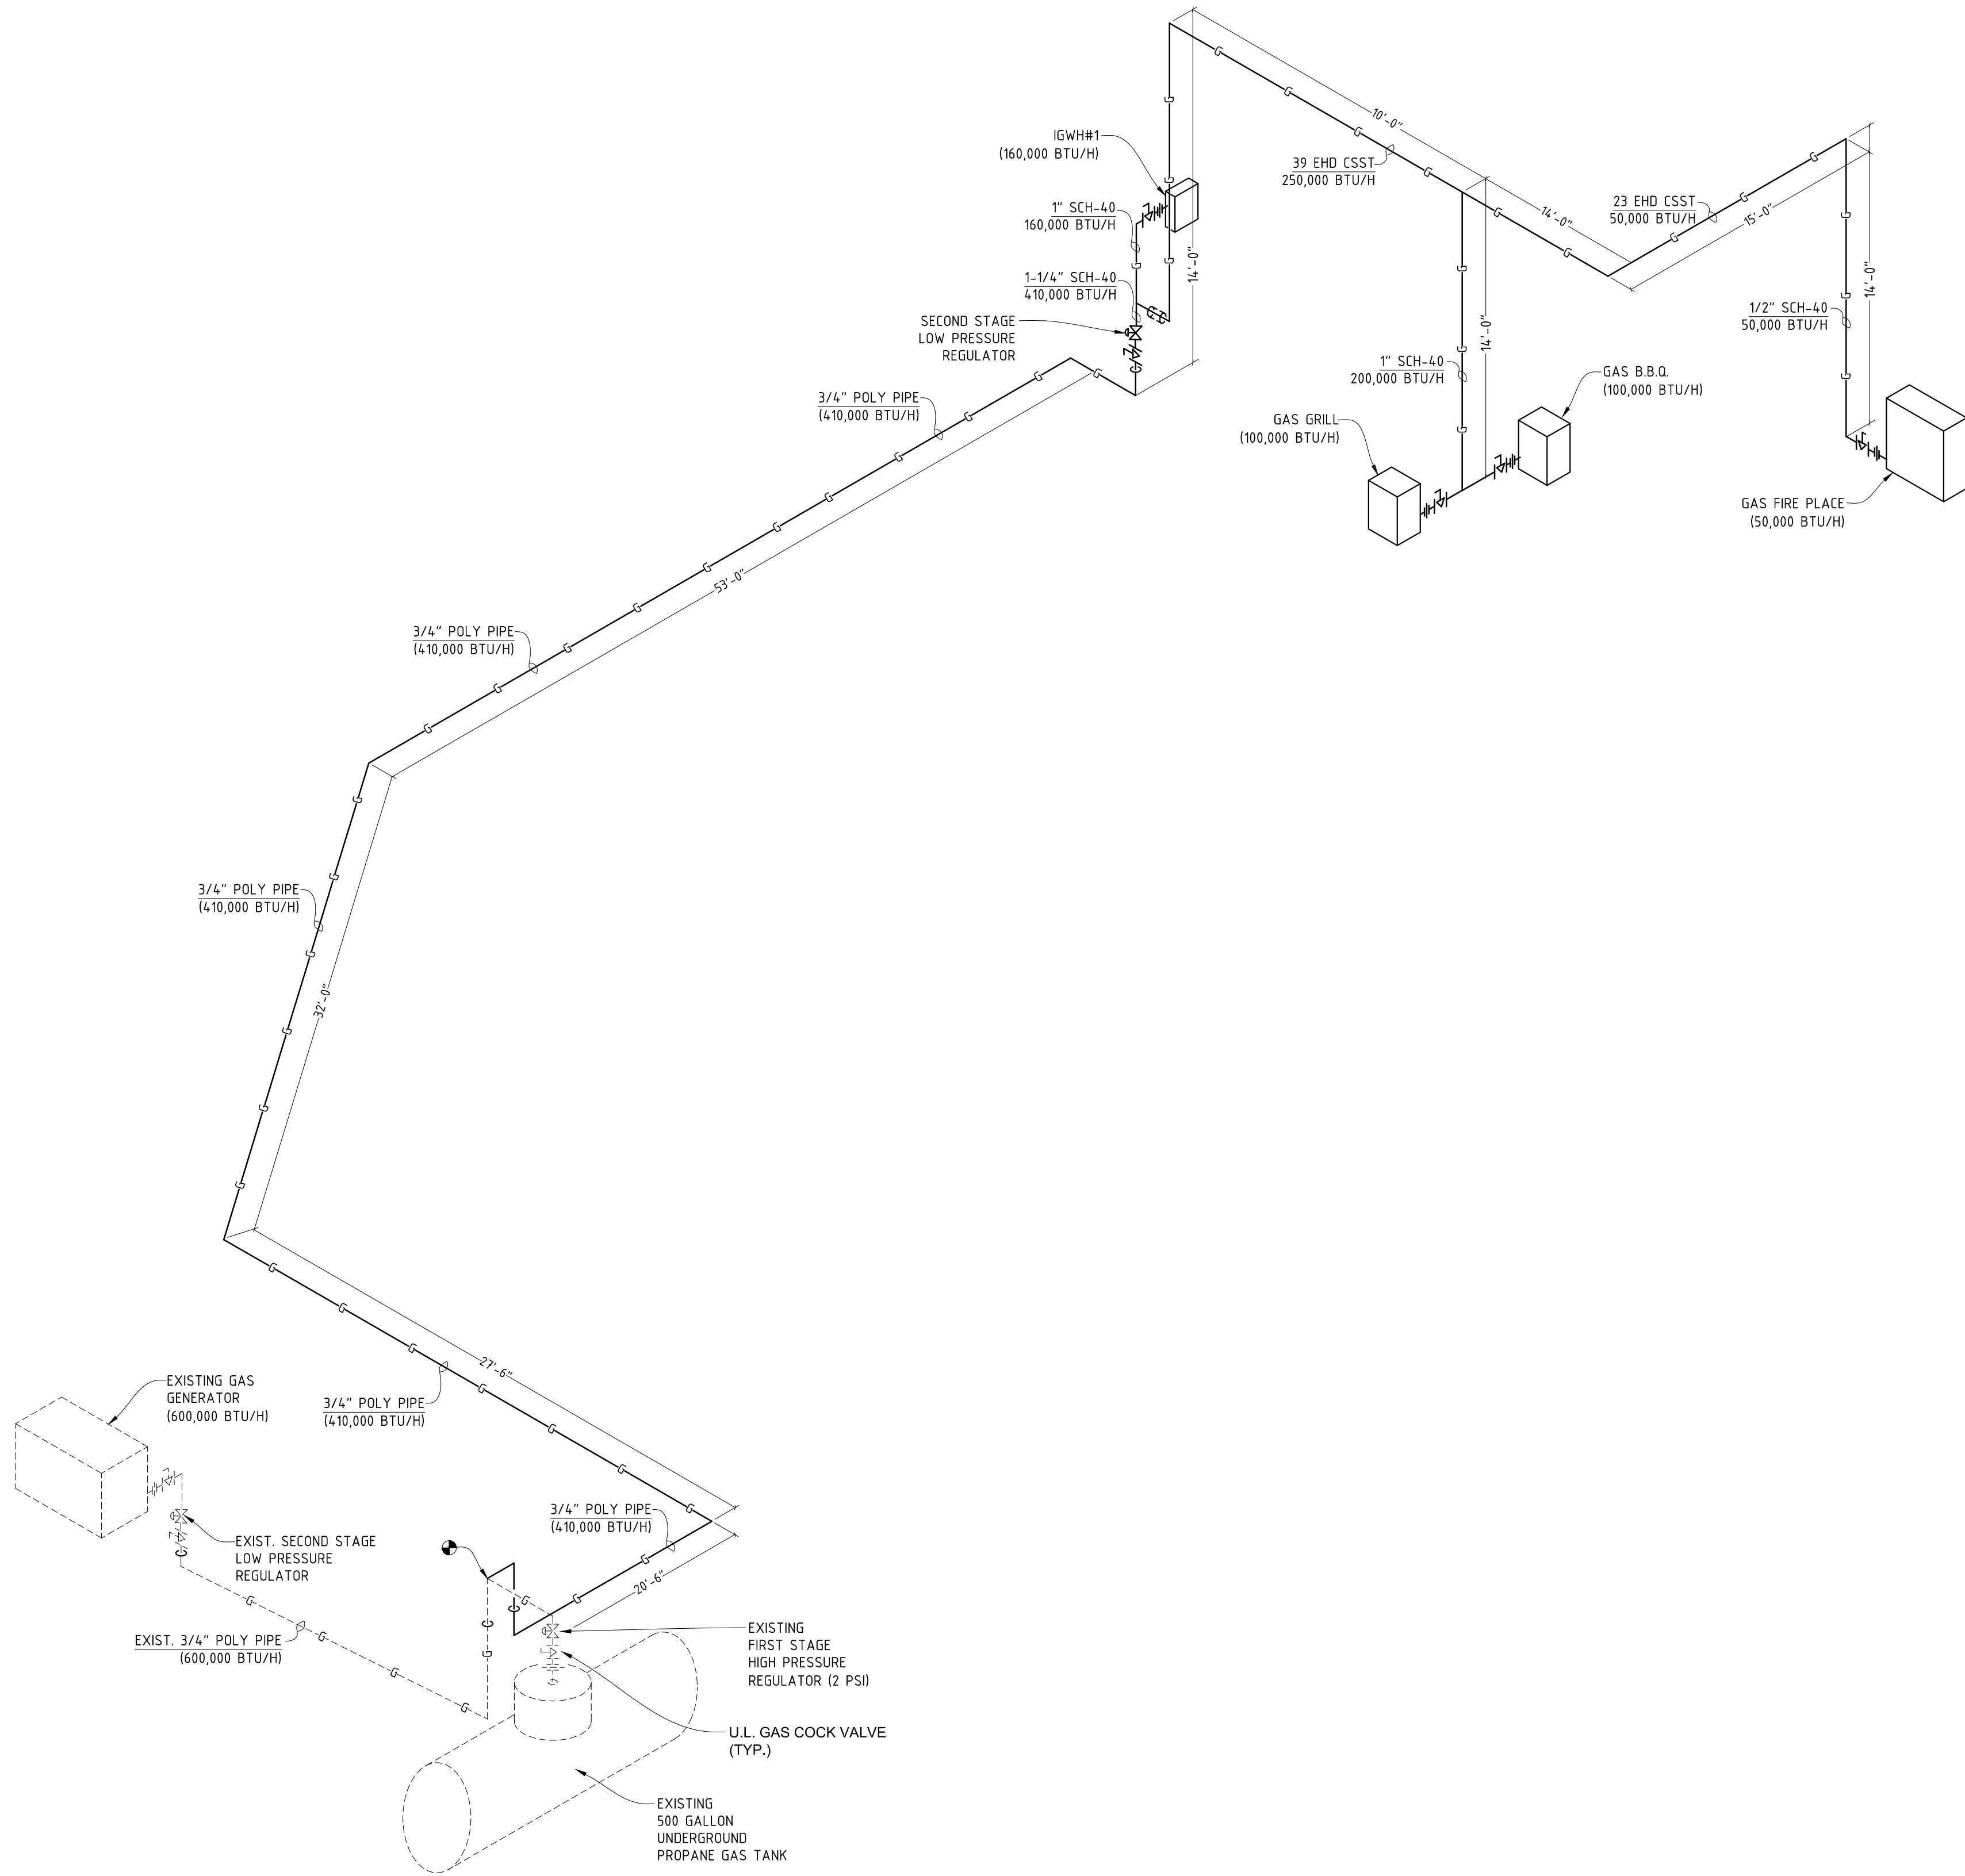

LP GAS PLUMBING ISOMETRIC DIAGRAM N.T.S.

GAS PIPING NOTES

- LOW PRESSURE GAS PIPE LONGEST= 200'-0" -- 410,000 BTU/H
- UNDERGROUND PIPING MATERIAL SHALL BE POLYETHYLENE PLASTIC PIPE (ANSI B16.3, A19.7), SIZED PER NFPA-58 2020 TABLE-16.1(n)
 - ABOVE GROUND PIPING MATERIAL OUTDOOR AND INSIDE PARTITIONS SHALL BE (ASTM A53) TREATED SCHEDULE 40 BLACK STEEL WITH MALLEABLE IRON FITTINGS (ANSI B16.3, A19.7), SIZED PER NFPA-58 2020 TABLE-16.1(c)
 - ABOVE GROUND PIPING MATERIAL IN CEILING SHALL BE CORRUGATED STAINLESS STEEL TUBING (CSST) WITH MALLEABLE IRON FITTINGS SIZED PER NFPA-58 2020 TABLE-16.1(k)
 - INSTALL GAS PIPING IN ACCORDANCE WITH NFPA-58 2024 AND TEST WITH PRESSURES AND TEST DURATIONS ACCORDING TO NFPA 54.

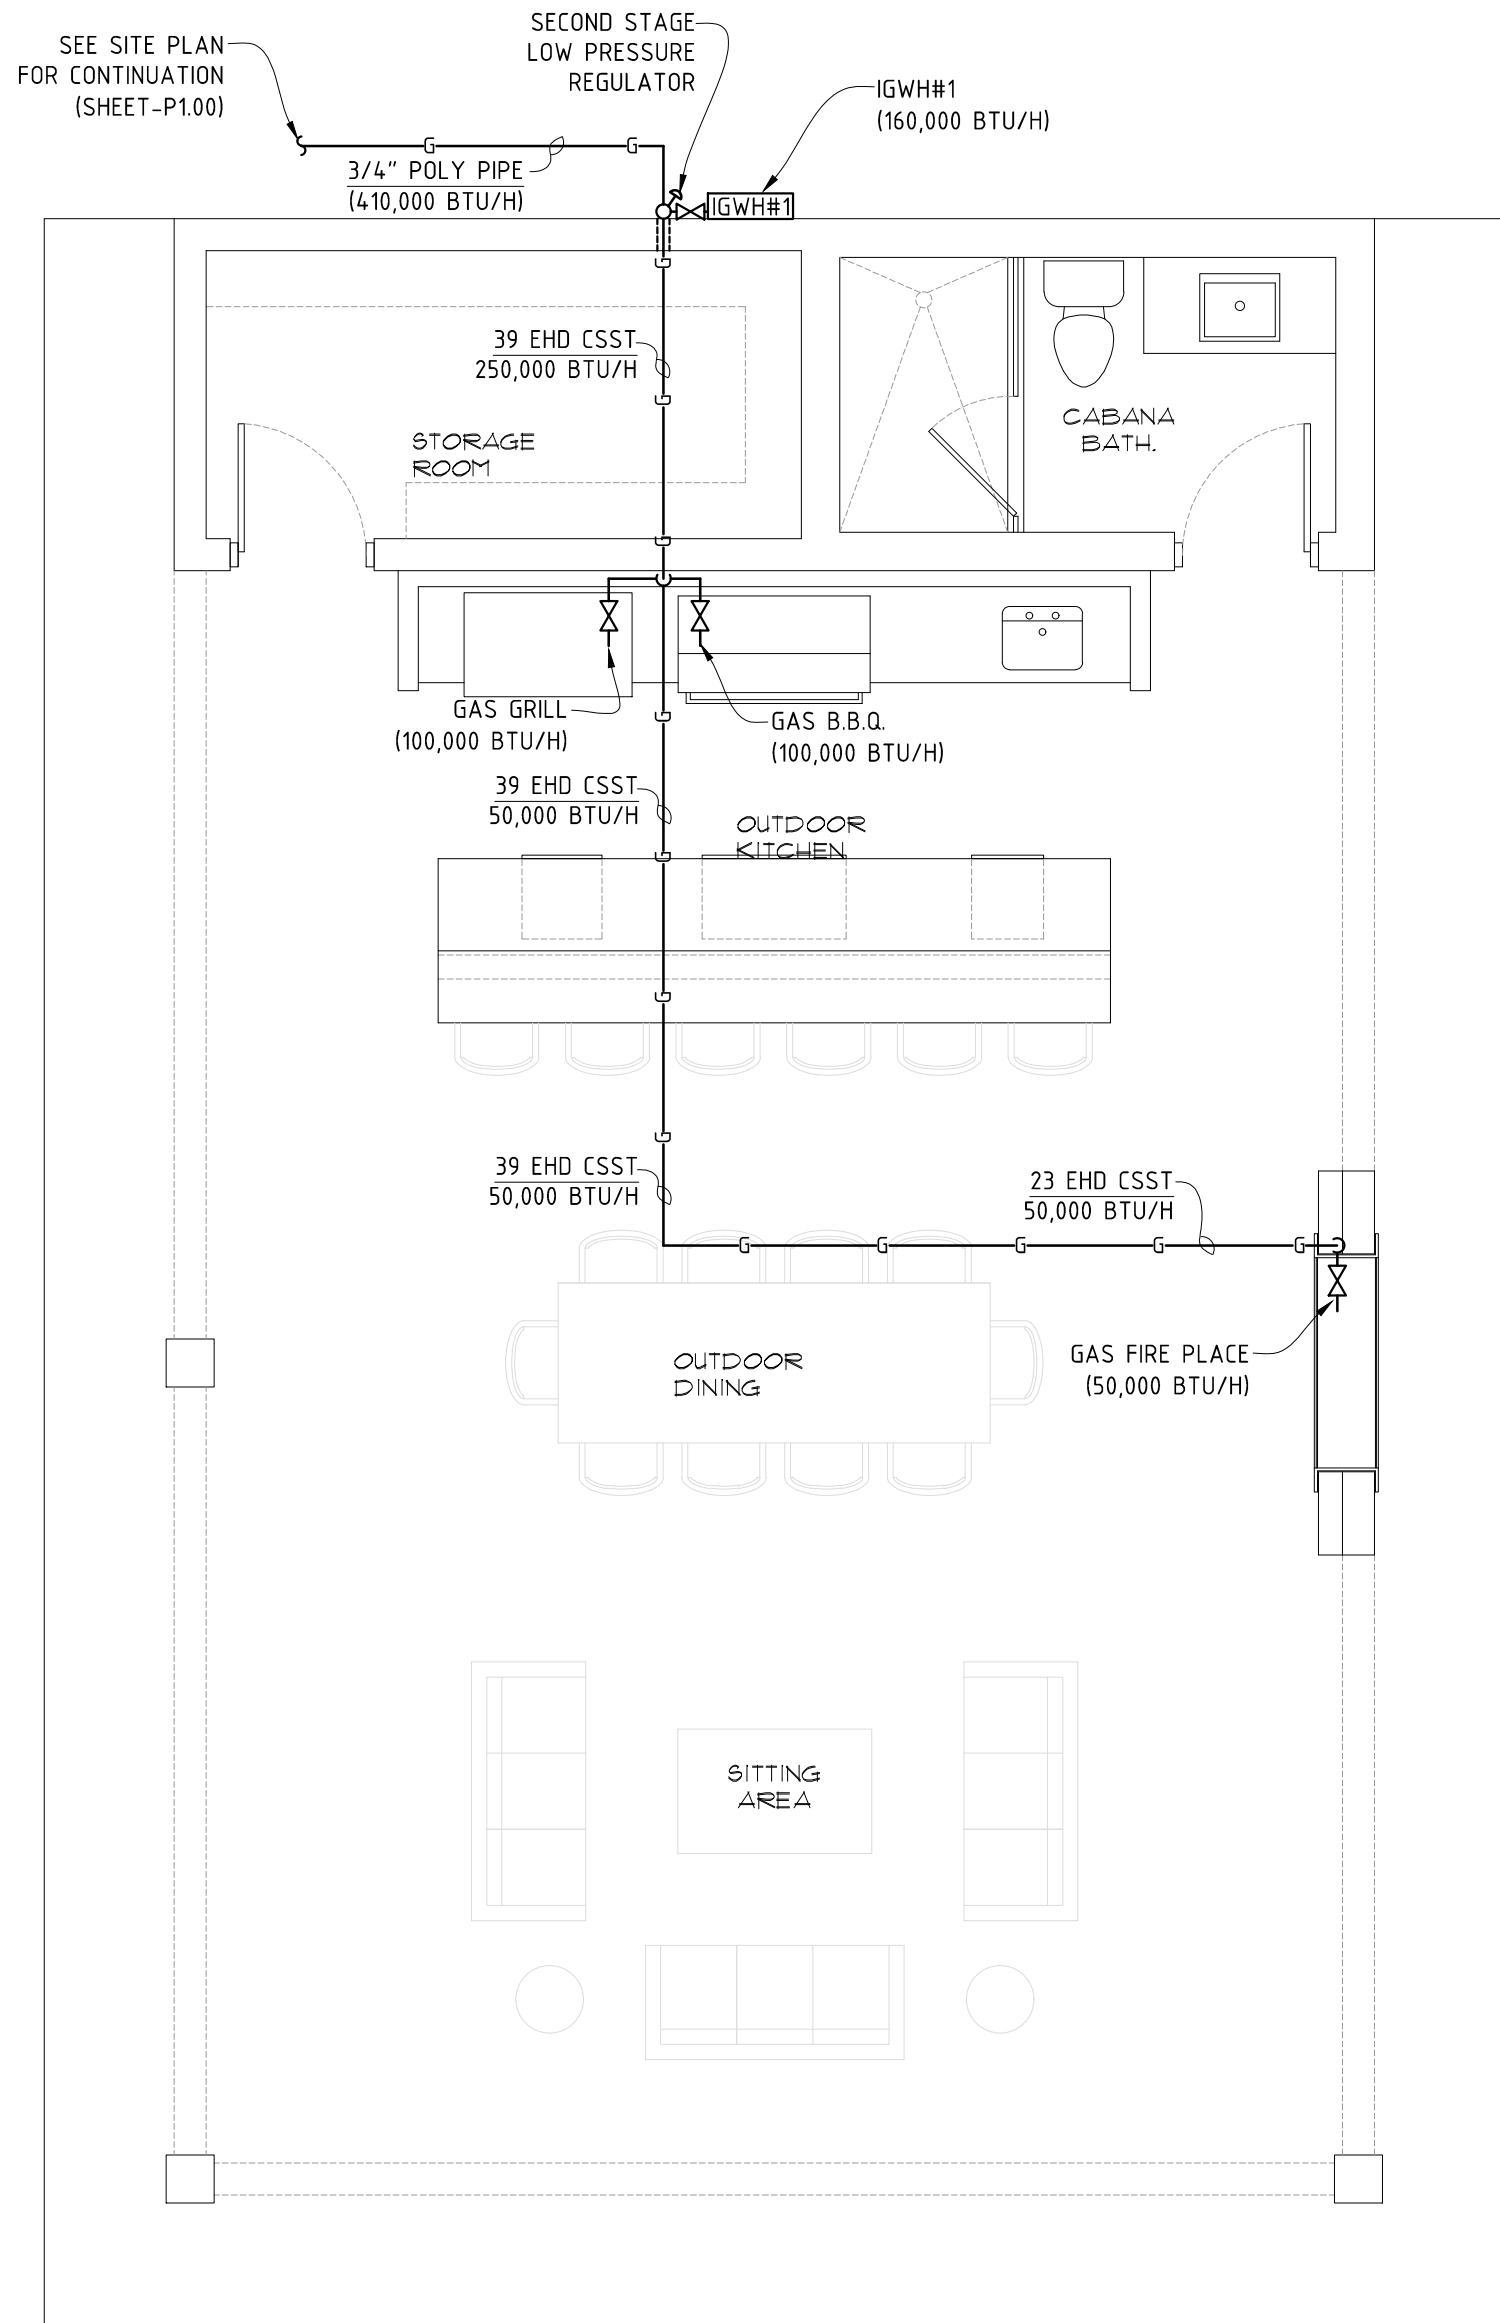

LP GAS PLUMBING FLOOR PLAN SCALE: 1/4" = 1'-0"

PLUMBING SYMBOL LEGEND

SYMBOL	DESCRIPTION
---	EXISTING GAS PIPE
—	GAS PIPE
IGWH	INSTANT GAS WATER HEATER