


3

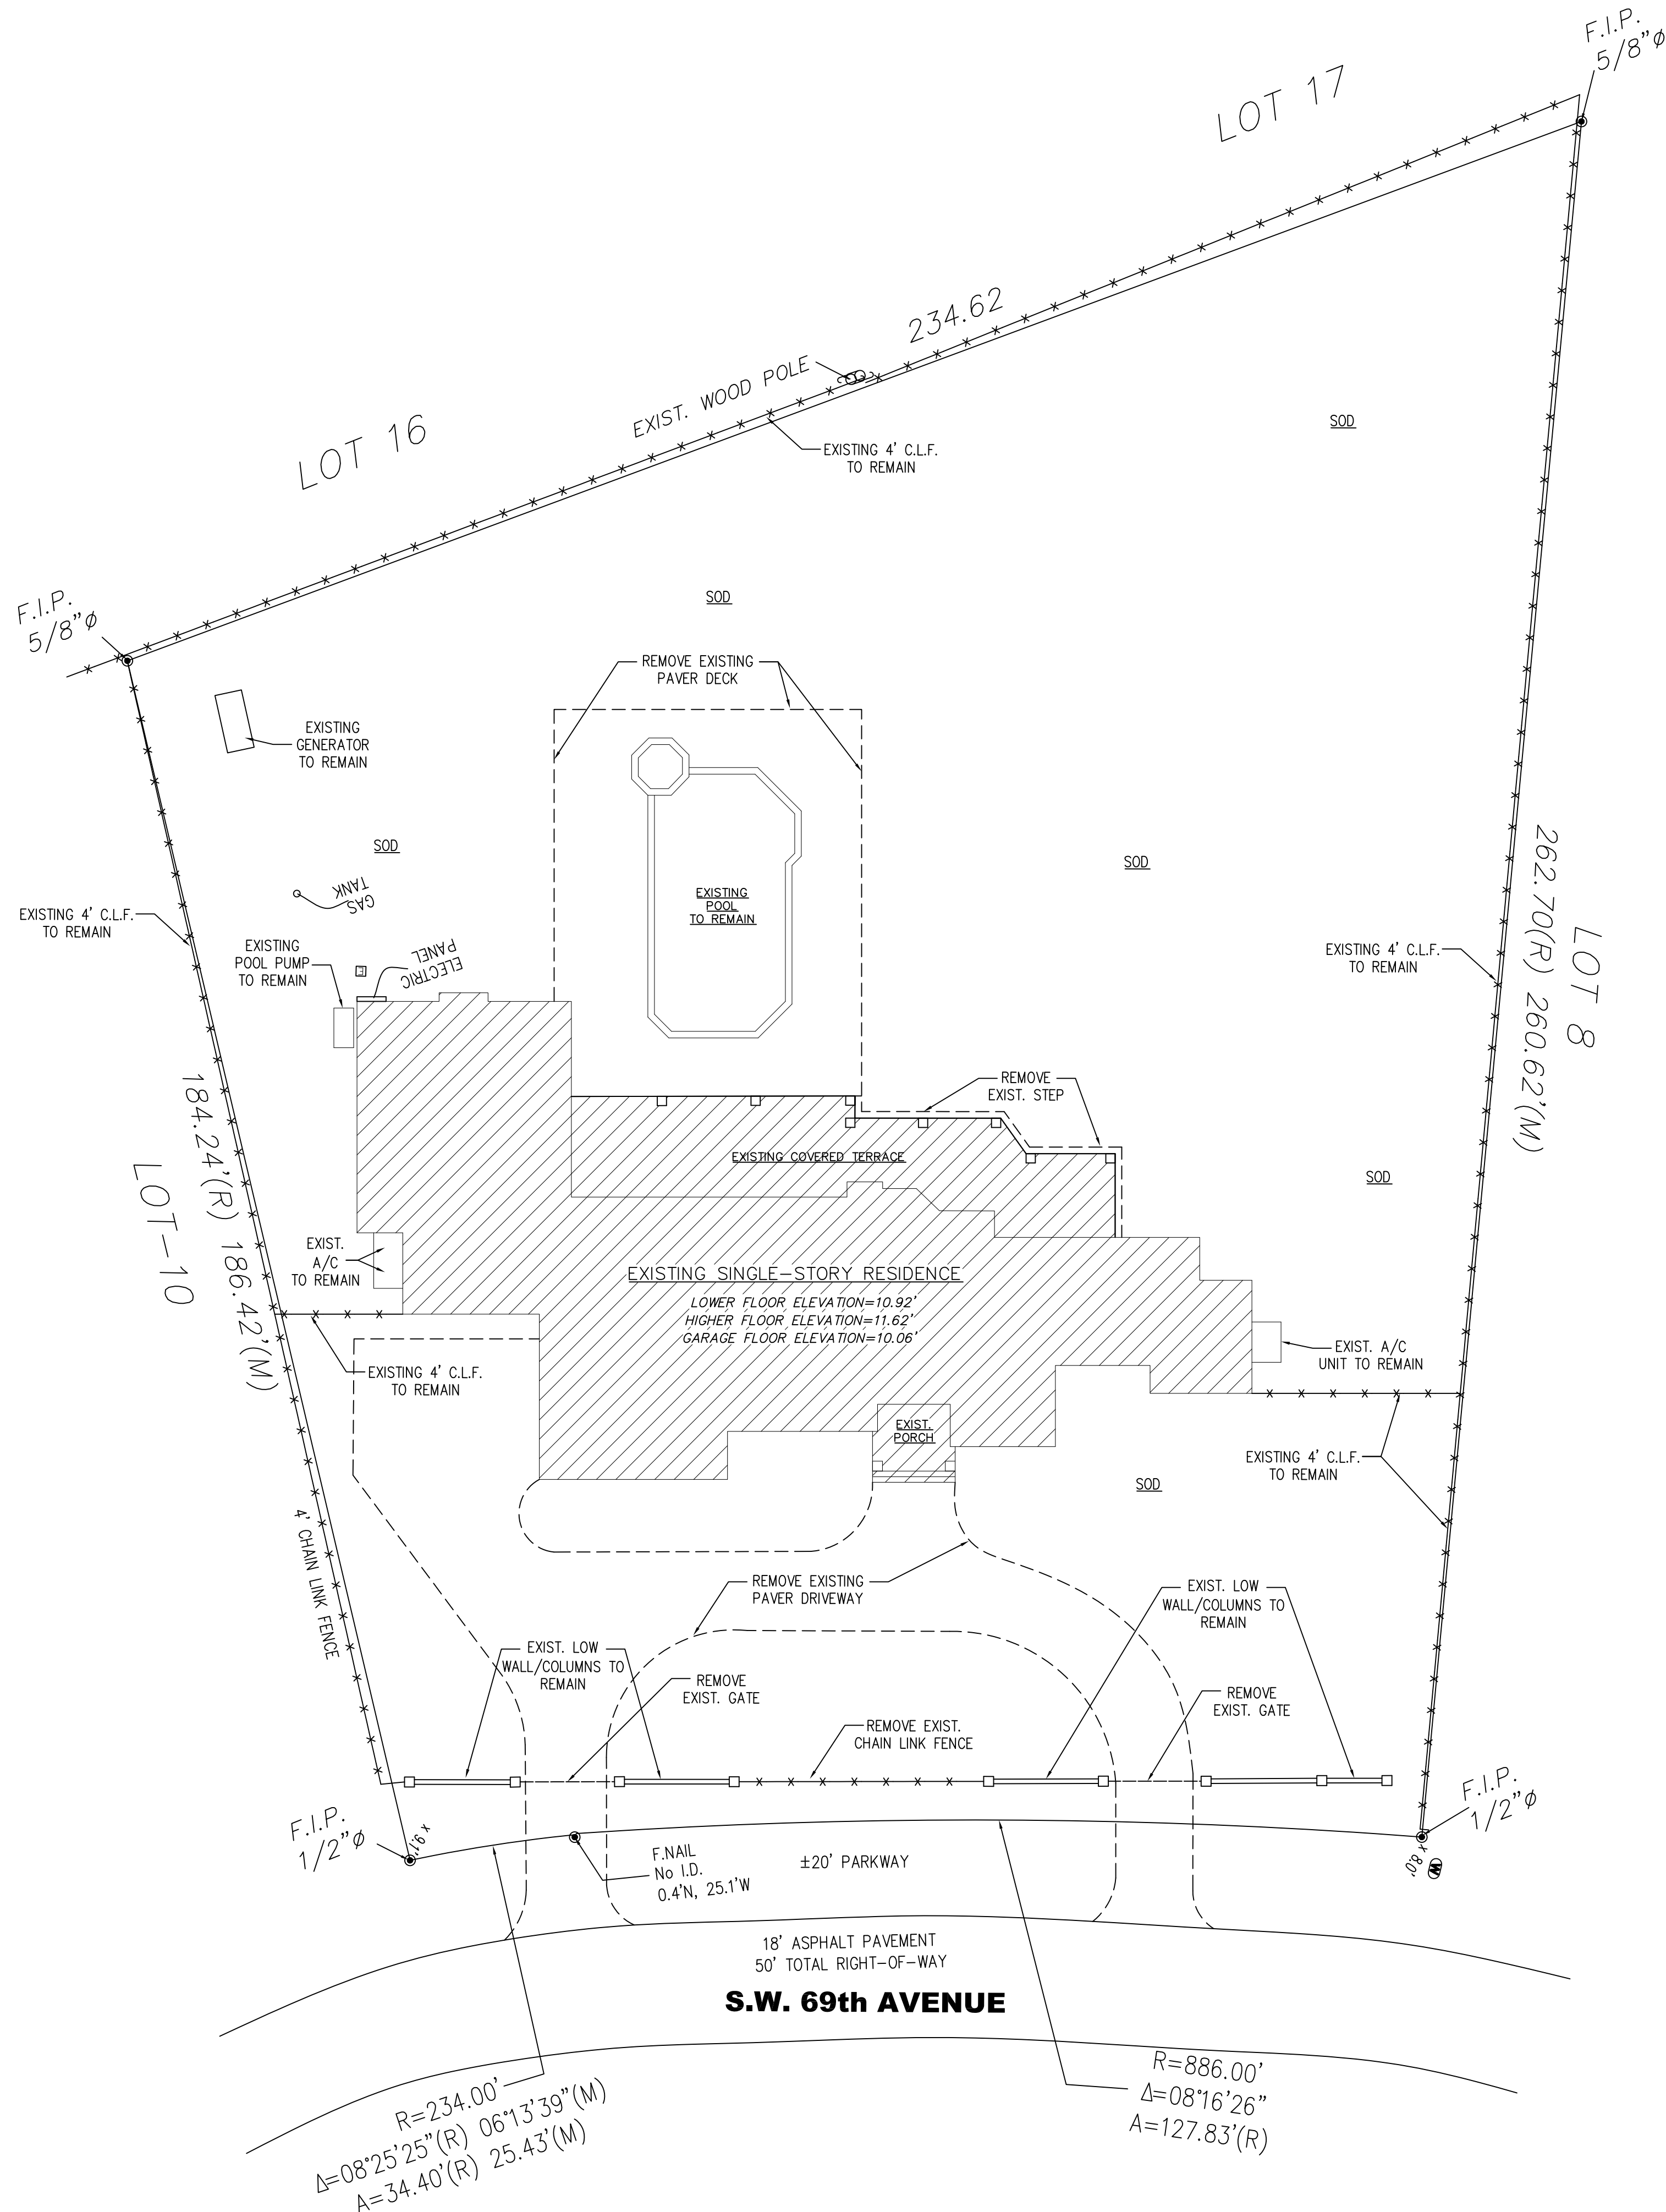


LEGEND :

- EXISTING 8" CONC. BLK WALL
- TO BE DEMOLISHED

TYP. DEMOLITION NOTES :

- CAP EXISTING ELECTRICAL AND PLUMBING FIXTURES BEING REMOVED.
- DURING DEMOLITION PROCESS IF ANY STRUCTURAL WALLS, COL'S AND BEAMS ARE ENCOUNTERED NOTIFY THE ARCHITECT/ENGINEER DO NOT SAW-CUT ANY STRUCTURAL SLABS WITHOUT INSTRUCTIONS FROM THE STRUCTURAL ENGINEER.
- DISCONNECT ELECTRICAL MAIN PRIOR TO DEMOLITION.
- DISCONNECT WATER MAIN PRIOR TO DEMOLITION.
- DISCONNECT GAS MAIN PRIOR TO DEMOLITION.
- REMOVE ALL ELECTRICAL FIXTURES & HOUSING, ELECTRICAL CONDUITS & WIRING TO REMAIN, TEMPORARY CAP AS REQUIRED FOR FUTURE USE.
- PROVIDE TEMPORARY BARRIER FOR ALL DROPS OVER 24" HIGH.
- REMOVE EXTERIOR WINDOWS & DOORS AS SHOWN ON PLAN.
- ALL NEW EXTERIOR OPENING SHALL BE TEMPORARILY COVERED W/ PLYWOOD.
- CONTRACTOR SHALL TAKE SPECIAL CARE DURING DEMOLITION PROCESS AND PROVIDE PROPER PROTECTION FOR SECURITY & WEATHER DURING CONSTRUCTION DOWN TIME.
- CONTRACTOR SHALL BE RESPONSIBLE FOR METHODS AND COORDINATION DURING DEMOLITION INCLUDING PROPER SHORING OF STRUCTURAL ELEMENTS. NOTIFY ARCHITECT IMMEDIATELY IN CASE OF DISCREPANCY.
- TREE PROTECTION BARRIERS MUST BE IN PLACE DURING DEMOLITION AND CONSTRUCTION.

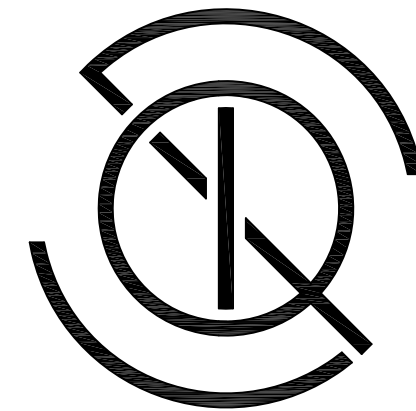

Q DESIGN STUDIO
ARCHITECTURE & PLANNING

License No AR99532

Q Design Studio, LLC
8000 SW 88th Court
Miami, FL 33173
T. 305.401.4950
E: John.Quintana10@gmail.com

CONSULTANTS

PROJECT NAME:

GOMEZ DRIVEWAY &
BACKYARD REMODEL

OWNER:

WILLIAM GOMEZ & DANIELLA VILAR

11040 SW 69th AVENUE
PINECREST, FL 33156

JOB NUMBER:

2024.01

DATE:

02/17/24

REVISION

△ ZONING COMMENT & UPDATED SURVEY

△

△

△

△

△


△

△

△

△

SEAL:

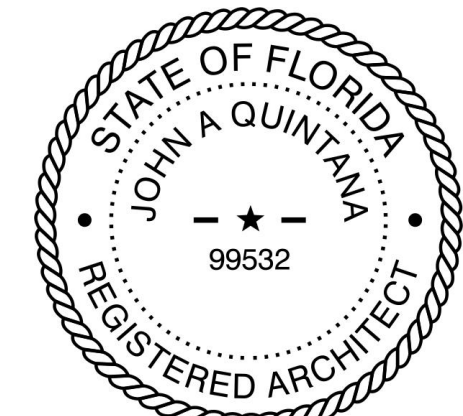

John Alexander Quintana

AR99532

DRAWING TITLE:

DEMOLITION
SITE PLAN

DRAWING NO:

D1.00



DEMOLITION SITE PLAN

SCALE: 1/16" = 1'-0"

A SEPARATE PERMIT AND PRODUCT CONTROL APPROVAL, WHEN APPLICABLE, IS REQUIRED FOR THE FOLLOWING ITEMS:
STRUCTURAL GLAZING
RIDGE VENTILATION
PRECAST SYSTEMS
STORM SHUTTERS
WOOD TRUSSES
CURTAIN WALLS
HANDRAILS
STEEL JOISTS
DOORS
MULLIONS
RAILS
STORE FRONT
ROOFING
SIGNS
FENCES
AWNINGS
WINDOWS
GLASS WALL