

GOMEZ DRIVEWAY & BACKYARD REMODEL
11040 SW 69th AVENUE, PINECREST, FL 33156

GENERAL NOTES


1. CONCRETE SHALL HAVE 3,000 PSI COMPRESSIVE STRENGTH AT 28 DAYS, UNLESS OTHERWISE NOTED (U.O.W.).
 2. ALL REINFORCING STEEL SHALL BE DEFORMED BARS, AND SHALL HAVE A MINIMUM YIELD STRENGTH OF 60,000 PSI GRADE 60, AND MEET ASTM A-36 SPECS.
 3. ALL STRUCTURAL STEEL SHALL HAVE A MINIMUM YIELD STRENGTH OF 36,000 PSI, AND MEET ASTM A-36 SPECS.
 4. ALL DETAILING, FABRICATION AND PLACING OF REINFORCING BARS MUST FOLLOW THE ACI "MANUAL OF STANDARD PRACTICE FOR DETAILING REINFORCED CONCRETE STRUCTURES", U.O.N.
 5. CONTRACTOR SHALL VERIFY ALL DIMENSIONS AND CONDITIONS AT JOB SITE BEFORE STARTING WORK. DISCREPANCIES SHALL BE BROUGHT TO THE ATTENTION OF THE ARCHITECT/ENGINEER BEFORE PROCEEDING WITH THE WORK.
 6. STRUCTURAL DRAWINGS SHALL COORDINATED TOGETHER WITH ARCHITECTURAL, A/C, ELECTRICAL AND MECHANICAL DWGS., TO LOCATE OPENINGS, DRAINS, SLEEVES, SLOPES, DEPRESSED SLABS, BOLTS, CURBS, ETC.
 7. ALL CONCRETE WORK SHALL BE IN ACCORDANCE WITH ACI-301 "SPECIFICATIONS FOR STRUCTURAL CONCRETE FOR BUILDINGS"
 8. REMOVAL OF FORMWORK SHALL BE IN ACCORDANCE WITH ACI-347 "RECOMMENDED PRACTICE FOR CONCRETE FORMWORK."
 9. CONTRACTOR SHALL SUBMIT SHOP DRAWINGS FOR ARCHITECT/ENGINEER'S APPROVAL.
 10. DO NOT SCALE DRAWINGS, DIMENSIONS GOVERN.
 11. REBARS SHOWN ON SECTIONS ARE FOR PLACEMENT DETAIL ONLY, SIZE AND AMOUNT OF REBARS ARE AS PER SCHEDULES.
 12. CONTRACTOR SHALL OBTAIN LATEST SET OF DRAWINGS, INCLUDING ANY REVISIONS, BEFORE STARTING CONSTRUCTION.
 13. DO NOT SUBSTITUTE MATERIALS, EQUIPMENT, OR METHODS OF CONSTRUCTION UNLESS SUCH SUBSTITUTIONS OR CHANGES HAVE BEEN APPROVED IN WRITING BY THE OWNER / ARCHITECT / ENGINEER.
 14. THIS OFFICE DOES NOT ACCEPT ANY RESPONSIBILITY FOR THE INTERPRETATION OF THESE PLANS BY OTHERS, UNLESS REQUESTED IN WRITING, AND IT IS GIVEN THE AUTHORITY TO CHECK AND APPROVE SHOP DRAWINGS, AND TO VERIFY THE ACTUAL PLACING OF REBARS IN THE FIELD
 15. ALL CONSTRUCTION SHALL MEET THE REQUIREMENTS OF LOCAL ORDINANCES AND THE "FLORIDA BUILDING CODE", CURRENT EDITION.
 16. WINDOW MANUFACTURER TO VERIFY ALL WINDOW OPENINGS AT FIELD PRIOR TO WINDOW PLACEMENT.
 17. NO TIE BEAMS SHALL BE FORMED / POURED PRIOR TO TRUSS SHOP DRAWINGS APPROVAL.
 18. ARCHITECT / ENGINEER'S VISITS AT THE SITE DURING CONSTRUCTION SHALL BE SCHEDULED WITH CONTRACTOR BEFORE COMMENCING OF WORK AND DURING CONSTRUCTION SHALL BE COORDINATED WITHIN 24 HOURS IN ADVANCE PRIOR TO INSPECTION.
 19. THE CONTRACTOR IS FULLY RESPONSIBLE FOR ANY ITEMS PURCHASED BY THE OWNER AND GIVEN TO THE CONTRACTOR FOR INSTALLATION.
 20. THE CONTRACTOR SHALL NOT PROCEED WITH ANY ADDITIONAL SERVICES OR EXTRA WORK WITHOUT PRIOR NOTIFICATION TO THE OWNER FOLLOWED BY A CHANGE ORDER.
 21. THE CONTRACTOR SHALL MAKE REQUIRED ARRANGEMENTS, SECURE AND PAY FOR ALL SANITARY FACILITIES, BARRICADES, ENCLOSURES, AND FENCING AS NEEDED FOR AND DURING THE PROGRESS OF CONSTRUCTION. CONTRACTOR SHALL PROTECT ADJACENT PROPERTIES.
 22. THE ARCHITECT / INTERIOR DESIGNER / OWNER HAS THE RIGHT TO REFUSE ANY MATERIAL AND WORKMANSHIP THAT DOES NOT MEET HIGHEST QUALITY STANDARDS OF THE VARIOUS TRADES INVOLVED.
 23. THE CONTRACTOR SHALL MAINTAIN AN ACCURATE RECORD OF CHANGE ORDERS AND VARIATIONS THROUGHOUT THE PROGRESS OF THE WORK. USE ONE SET OF DOCUMENTS EXCLUSIVELY FOR THIS JOB.
 24. THE CONTRACTOR SHALL DELIVER THE ANNOTATED JOB RECORD SET TO THE OWNER UPON COMPLETION OF THE WORK AS A CONDITION OF ACCEPTANCE.
 25. CLEANING AND DEBRIS REMOVAL. THE OWNER SHALL RECIEVE THE PROPERTY FREE FROM DUST, ALL GLASS SURFACES SHALL BE CLEAN AND DEBRIS SHALL BE REMOVED FROM THE SITE. THE CONTRACTOR SHALL MAINTAIN THE FLOOR CLEAN DURING CONSTRUCTION PROGRESS. LEFTOVERS FORM MEALS CONSUMED ON PREMISES SHALL BE DEPOSITED IN SEALED CONTAINERS. THE CONTRACTOR SHALL CLEAN SITE ONCE PER WEEK TO THE OWNERS SATISFACTION.
 26. THE CONTRACTOR IS SOLELY RESPONSIBLE FOR MEANS AND METHODS OF CONSTRUCTION, AND FOR THE SEQUENCES AND PROCEDURES TO BE USED.
 27. FOR BURGLARY INTRUSION NOTES REFER TO "METROPOLITAN DADE COUNTY CODE", SECTION 8C/18.
 28. THE ARCHITECTURAL AND STRUCTURAL DRAWINGS SHALL GOVERN THE LOCATIONS OF THE INSTALLATIONS OF THE MECHANICAL AND ELECTRICAL SYSTEM. CONTRACTOR MUST INFORM THE ARCHITECT BEFORE FORMING ANY CONCRETE BEAM IF INTERFERING WITH A/C DUCT OR PLUMBING FIXTURES EXACT LOCATION. ANY DEVIATION FROM THE MECHANICAL / ELECTRICAL PLANS TO ACCOMODATE THE ABOVE CONDITIONS SHALL BE MADE WITHOUT ADDITIONAL COST TO THE OWNER.
 29. THE CONTRACTOR SHALL PRODUCE, BY MEANS OF SHOP DRAWINGS, ALL ADDITIONAL DETAILS WHICH ARE INFERABLE FROM THESE PLANS AND WHICH ARE NECESSARY FOR THE EXECUTION AND COMPLETION OF THE WORK. ALL SHOP DRAWINGS ARE TO BE APPROVED BY THE ARCHITECT BEFORE THE WORK COMMENCES.
 30. THE CONTRACTOR MUST FURNISH ALL LABOR, TOOLS, MATERIALS AND EQUIPMENT NECESSARY TO EXECUTE THE CONSTRUCTION OF THIS JOB.
 31. UPON ACCEPTANCE AS SUBSTANTIALLY COMPLETE, THE ARCHITECT SHALL ISSUE THE CONTRACTOR A "PUNCHLIST", INDICATING THE OBSERVED DEFICIENCIES IN THE WORK. THE CONTRACTOR SHALL MAKE SUCH CORRECTIONS AND ACHIEVE FINAL COMPLETION WITHIN 14 CALENDAR WORKING DAYS.
 32. CONTRACTOR TO VERIFY THAT THERE ARE NO PERTINENT FEATURES ON THE ADJACENT PROPERTIES AND ACROSS THE STREET THAT MAY AFFECT THE ONSITE SEWAGE TREATMENT AND DISPOSAL SYSTEM INSTALLATION.

SAFETY NOTE:

 1. EVERY BATHROOM & CLOSET DOOR SHALL BE DESIGNED TO ALLOW OPENING FROM THE OUTSIDE DURING AN EMERGENCY WHEN LOCKED.
 2. EVERY CLOSET LATCH SHALL BE SUCH THAT CHILDREN CAN OPEN THE DOOR FROM INSIDE THE CLOSET.

LEGAL DESCRIPTION :

HELMS COUNTRY ESTS RE-PLAT PB 50-48 LOT 9 BLK 6 F/A/U
30-50111-005-0680 OR 18248-4569 0898 1

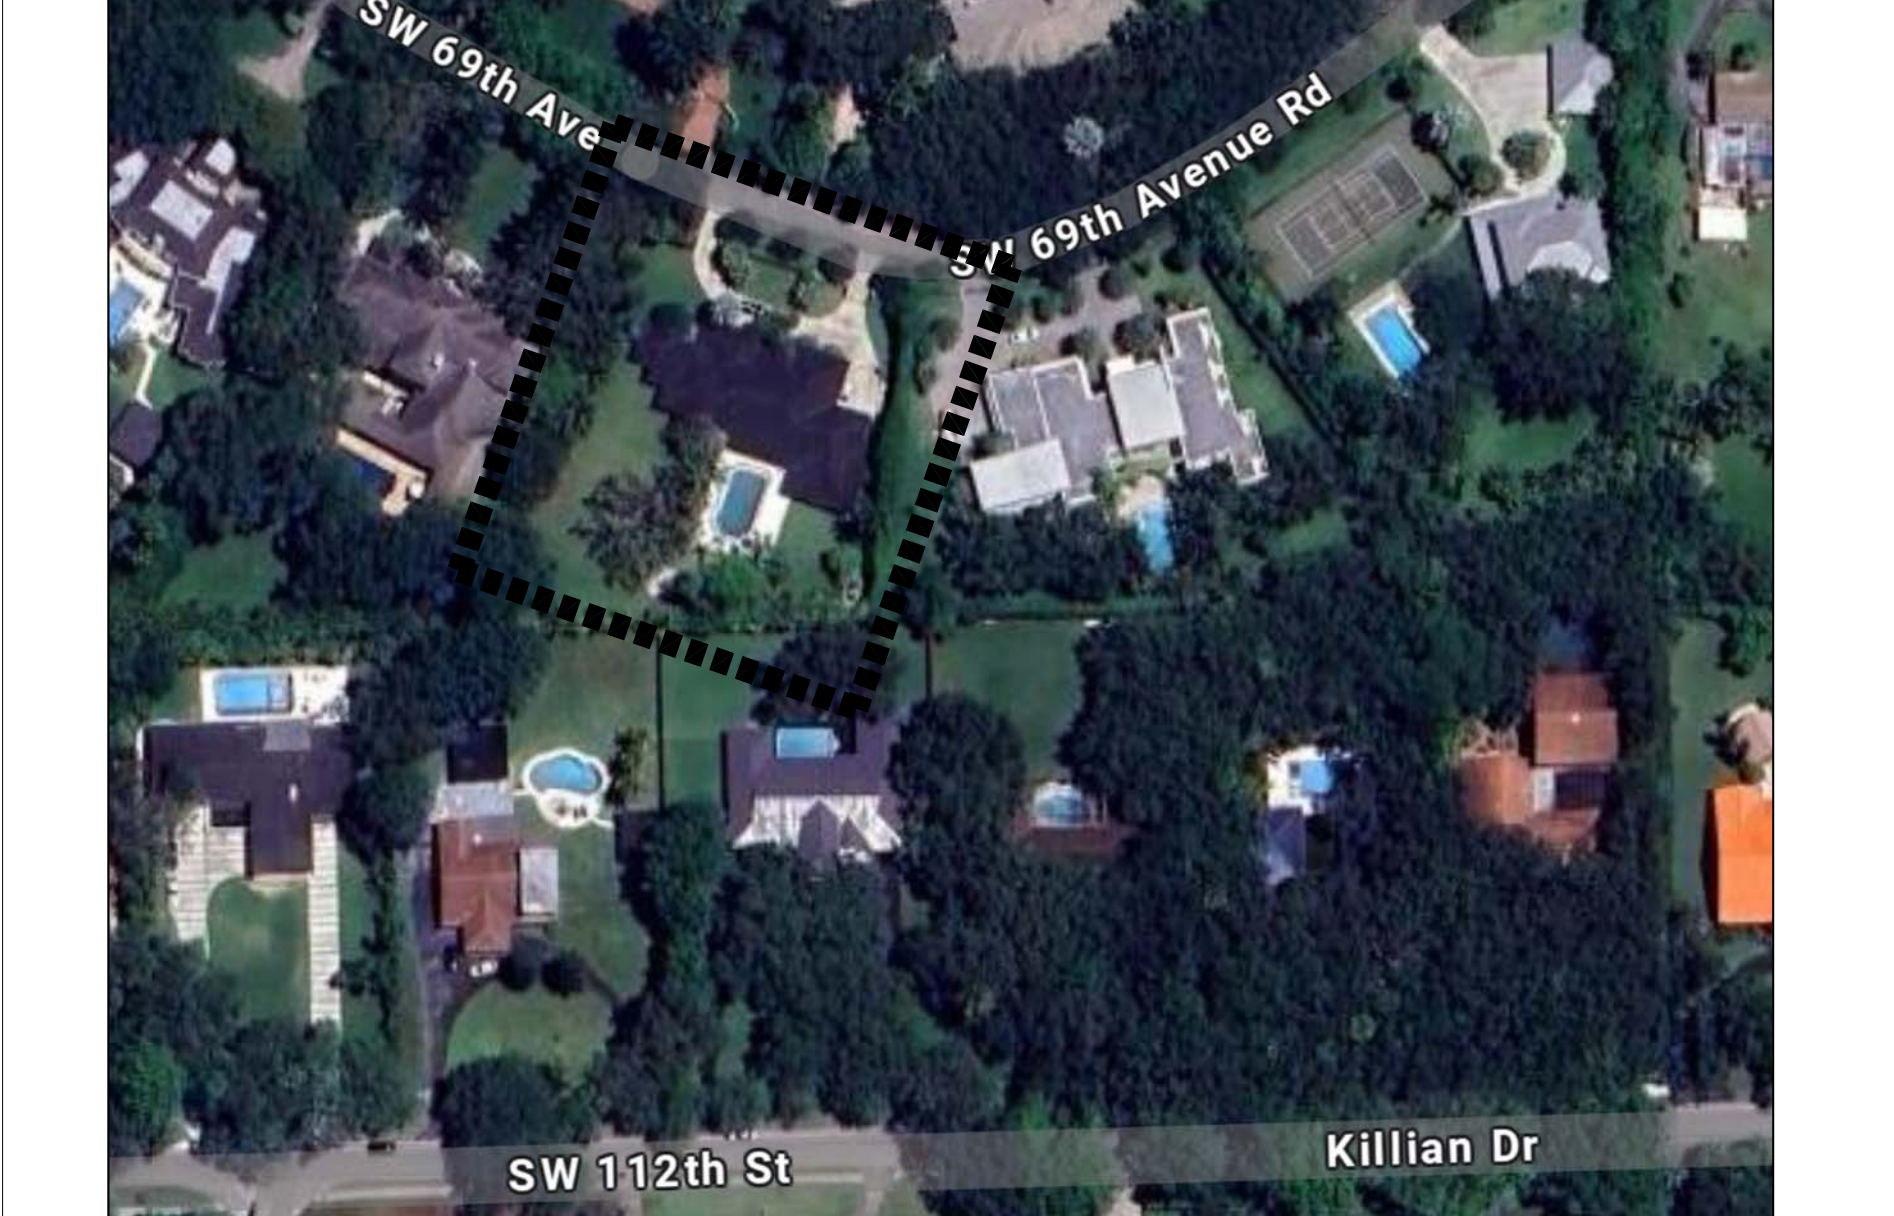AREA LOCATION MAP 

NARRATIVE	
1	1
2	2
3	3
100	100

THE SCOPE OF THE WORK IN THIS PROJECT CONSISTS OF A NEW GAZEBO
ACCESSORY STRUCTURE AND OUTDOOR DECK RE-MODEL, AS WELL AS A NEW
DRIVEWAY PLAN.

DRAWING INDEX

[illegible]

A SEPARATE PERMIT AND PRODUCT CONTROL APPROVAL, WHEN APPLICABLE, IS REQUIRED FOR THE FOLLOWING ITEMS:				
STRUCTURAL GLAZING	WOOD TRUSSES	DOORS	ROOFING	WINDOWS
RIDGE VENTILATION	CURTAIN WALLS	MULLIONS	SIGNS	GLASS WALL
PRECAST SYSTEMS	HANDRAILS	RAILS	FENCES	
STORM SHUTTERS	STEEL JOISTS	STORE FRONT	AWNINGS	



License No AR99532

Q Design Studio, LLC
8000 SW 88th Court
Miami, FL 33173
T. 305.401.4950
E: John.Quintana10@gmail.com

CONSULTANTS

PROJECT NAME:

GOMEZ DRIVEWAY & BACKYARD REMODEL

OWNER:

11040 SW 69th AVENUE
PINECREST, FL 33156

 
 
 
 
 
JOB NUMBER: 2024.01
DATE: 02/17/24

REVISION


1 BUILDING DEPT. COMMENTS - AUG. 2024

2 BUILDING DEPT. COMMENTS - SEPT. 2024

ZONING COMMENT & UPDATED SURVEY



SEAL:

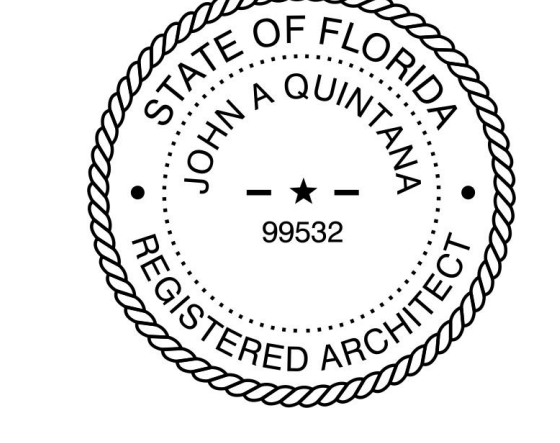

John Alexander Quintana AR99532

DRAWING TITLE:

COVER SHEET

DRAWING NO:

T1.00