


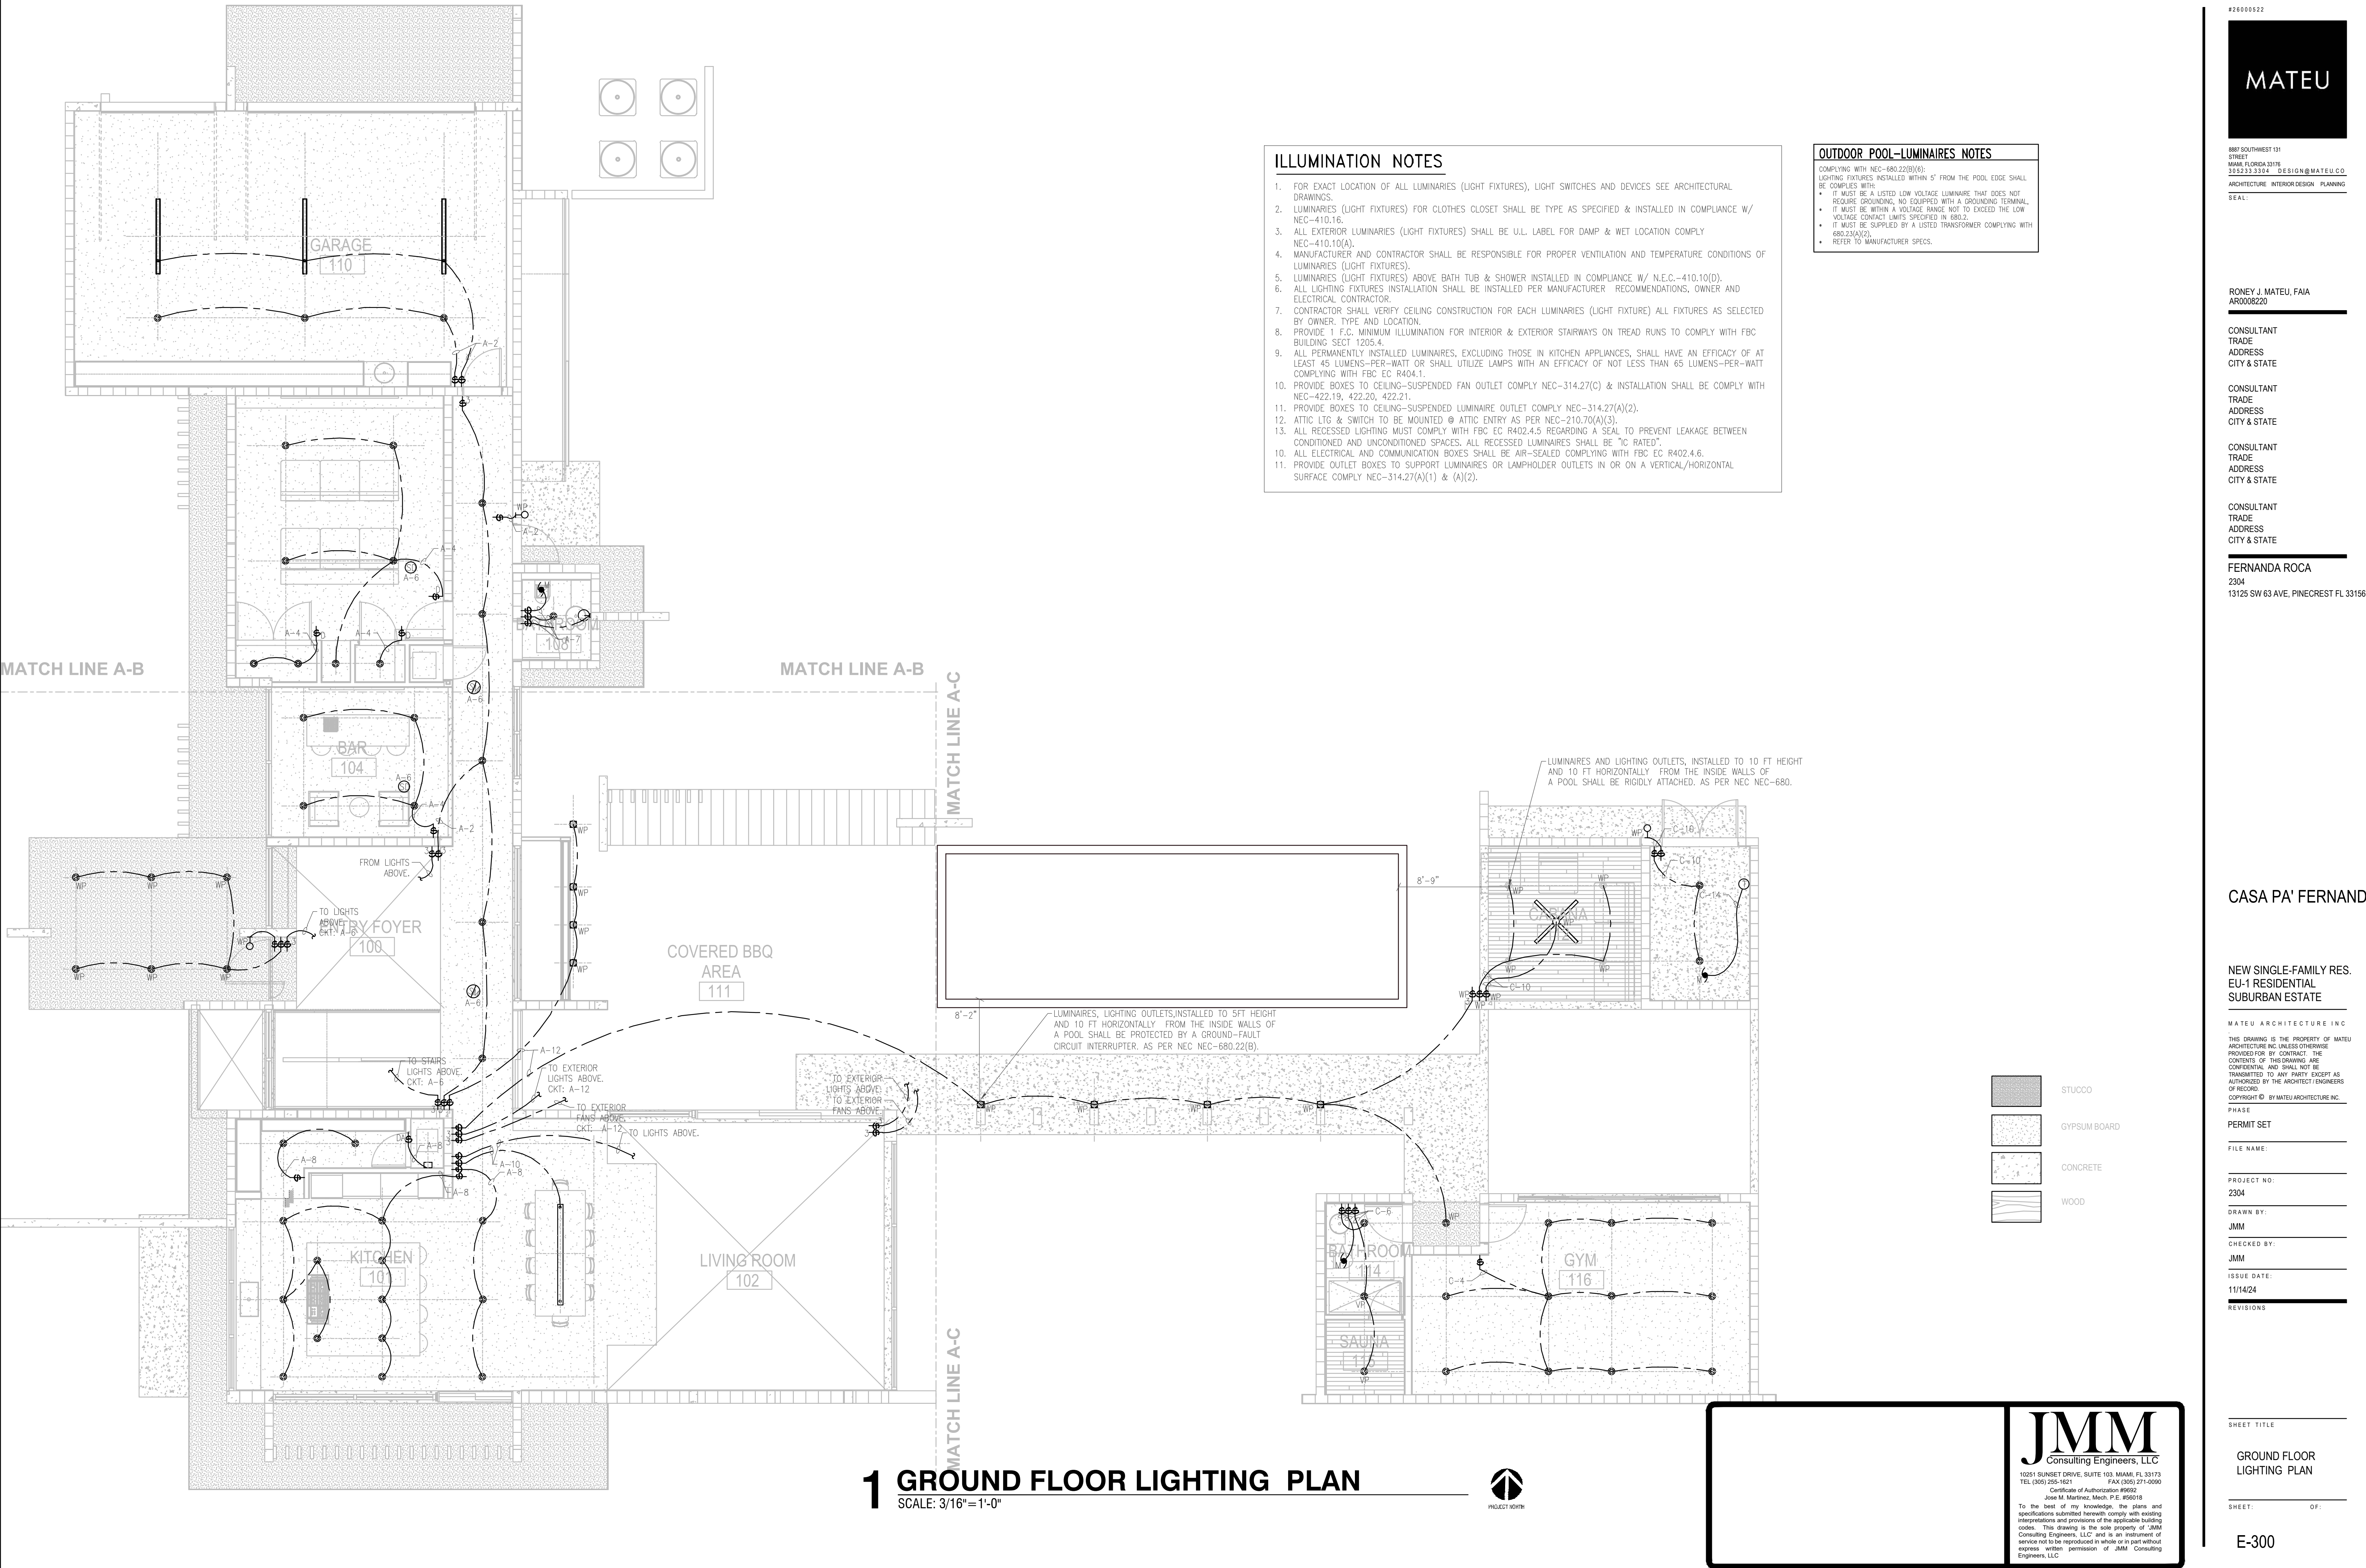

#26000522

MATEU

8877 SOUTHWEST 131
STREET
MIAMI, FLORIDA 33176
305.233.3314 DESIGN@MATEU.CO.
ARCHITECTURE INTERIOR DESIGN PLANNING

SEAL:

RONEY J. MATEU, FAIA
AR0008220

CONSULTANT
TRADE
ADDRESS
CITY & STATE

CONSULTANT
TRADE
ADDRESS
CITY & STATE

CONSULTANT
TRADE
ADDRESS
CITY & STATE

CONSULTANT
TRADE
ADDRESS
CITY & STATE

FERNANDA ROCA
2304
13125 SW 63 AVE, PINECREST FL 33156

CASA PA' FERNANDA

NEW SINGLE-FAMILY RES.
EU-1 RESIDENTIAL
SUBURBAN ESTATE

MATEU ARCHITECTURE INC

THIS DRAWING IS THE PROPERTY OF MATEU
ARCHITECTURE INC. UNLESS OTHERWISE
PROVIDED FOR BY CONTRACT, THE
CONTENTS OF THIS DRAWING ARE
CONFIDENTIAL AND SHALL NOT BE
TRANSMITTED TO ANY PARTY EXCEPT AS
AUTHORIZED BY THE ARCHITECT/ENGINEERS
OF RECORD.

COPYRIGHT © BY MATEU ARCHITECTURE INC.

PHASE

PERMIT SET

FILE NAME:

PROJECT NO:

2304

DRAWN BY:

JMM

CHECKED BY:

JMM

ISSUE DATE:

11/14/24

REVISIONS

SHEET TITLE

GROUND FLOOR
LIGHTING PLAN

SHEET:

OF:

E-300

JMM
Consulting Engineers, LLC

10251 SUNSET DRIVE, SUITE 103, MIAMI, FL 33173
TEL (305) 256-1621 FAX (305) 271-0090
Certificate of Authorization #6662

Jose M. Martinez, Mech. P.E. #50018
To the best of my knowledge, the plans and
specifications submitted herewith comply with existing
interpretations and provisions of the applicable building
codes. This drawing is the sole property of JMM
Consulting Engineers, LLC and is an instrument of
service not to be reproduced in whole or in part without
express written permission of JMM Consulting
Engineers, LLC.



PROFESSIONAL