



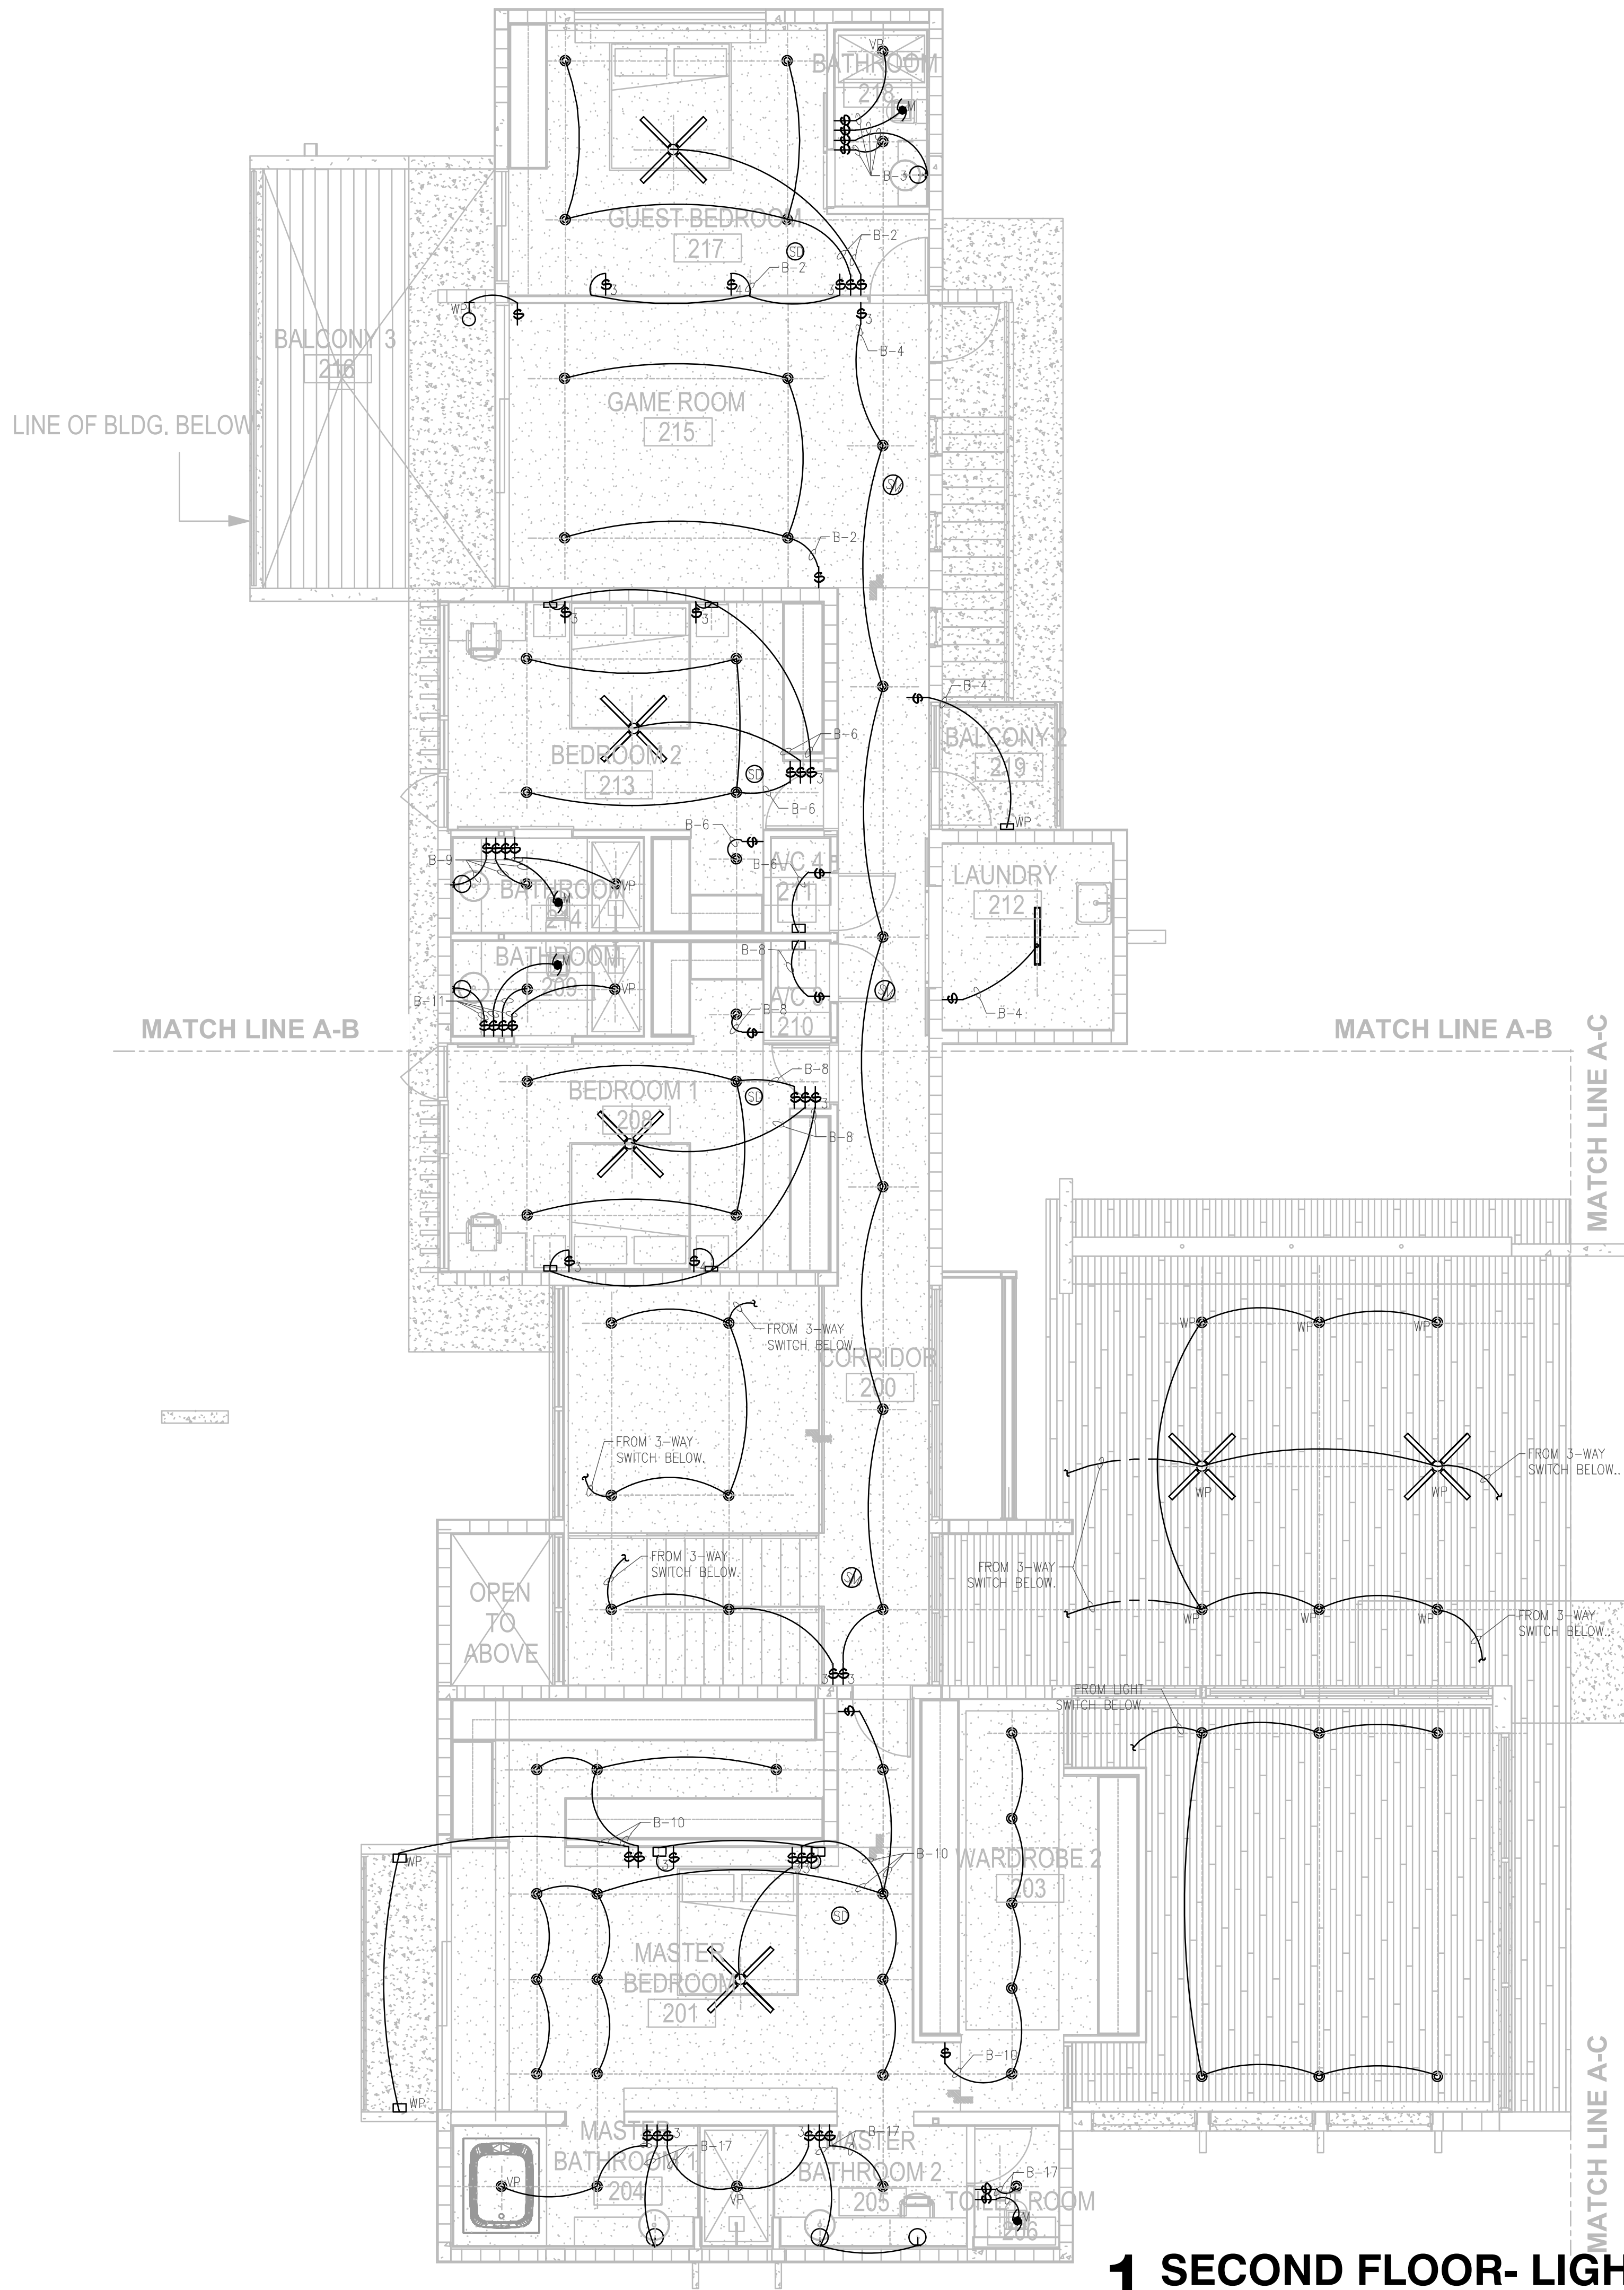

NOTES

- DO NOT CONNECT TO GFI CIRCUITS.
- OPERATION OF A SWITCH (OTHER THAN A CIRCUIT BREAKER) OR A GROUND-FAULT CIRCUIT-INTERRUPTER SHALL NOT CAUSE LOSS OF PRIMARY (MAIN) POWER. SMOKE ALARMS POWERED BY AFCI-PROTECTED CIRCUITS SHALL HAVE A SECONDARY POWER SOURCE. NFPA 72, CHAPTER 11.
- INTERCONNECT ALL SMOKE DETECTORS OR CARBON MONOXIDE IN SUCH A WAY THAT THE OPERATION OF ANY SMOKE DETECTOR OR CARBON MONOXIDE WILL ACTIVATE ALL DETECTOR SOUNDING ALARM IN DWELLING UNIT.
- EACH DETECTOR SHALL BE LOCATED A MINIMUM OF 36" AWAY FROM A BATHROOM OR KITCHEN DOOR OPENING OR ANY A/C SUPPLY DIFFUSER OR A/C RETURN AIR GRILL.
- COMBINATION SMOKE DETECTOR-CARBON MONOXIDE, SHALL BE LOCATED A MAXIMUM OF 10'-0" OF EACH DOOR ROOM USED FOR SLEEPING PROPOSES. ISSUED AND HAVING A FOSSIL FUEL-BURNING HEATER OR APPLIANCE, A FIRE PLACE, AN ATTACHED GARAGE SHALL BE MONITORED IN ACCORDANCE WITH NFPA 72 AND NEC-760.

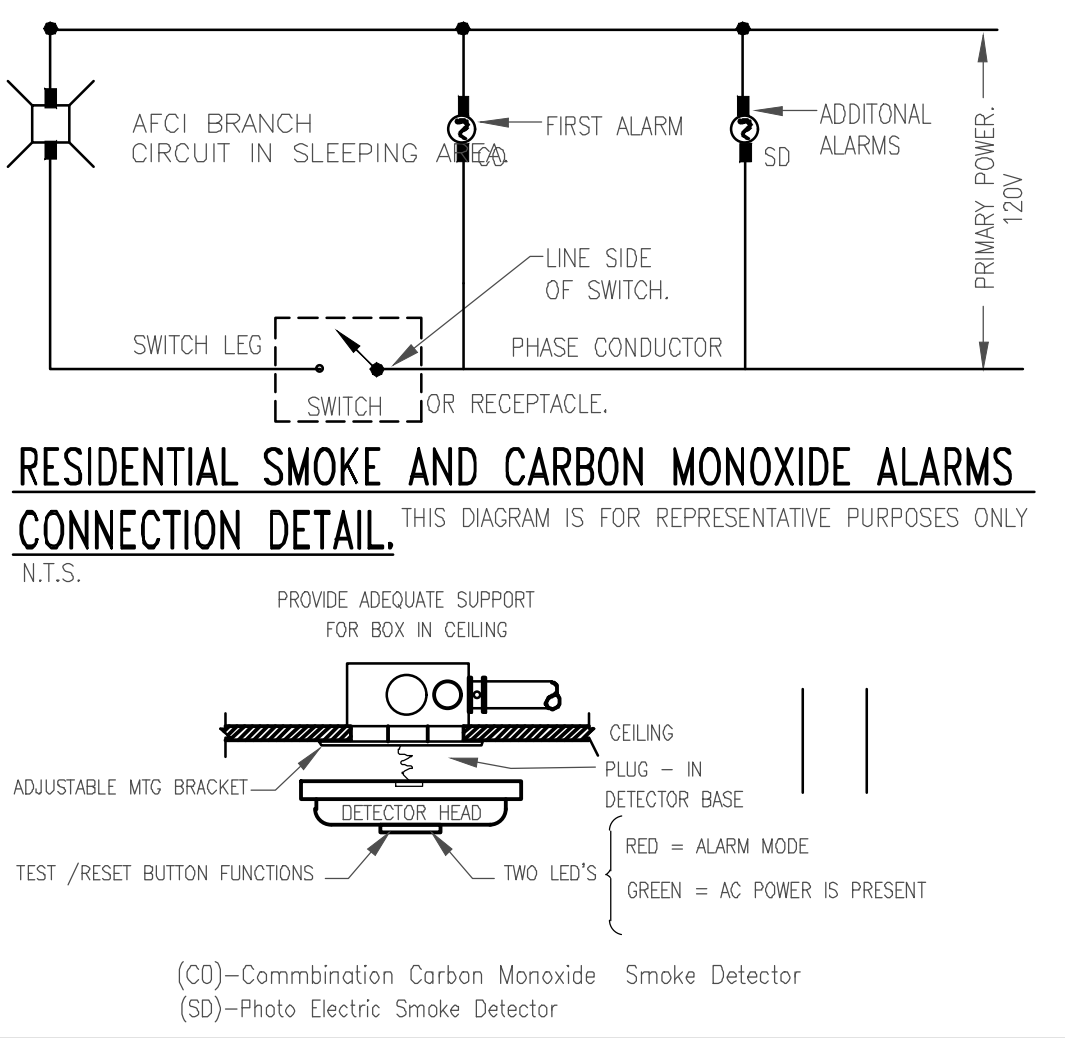

#2600052



887 SOUTHWEST 131 STREET
MIAMI, FLORIDA 33176
305.231.3314 DESIGN@MATEU.CO
ARCHITECTURE INTERIOR DESIGN PLANNING
SEAL:

RONNEY J. MATEU, FAIA
AR0008220

CONSULTANT
TRADE
ADDRESS
CITY & STATE

CONSULTANT
TRADE
ADDRESS
CITY & STATE

CONSULTANT
TRADE
ADDRESS
CITY & STATE

CONSULTANT
TRADE
ADDRESS
CITY & STATE

FERNANDA ROCA
2304
13125 SW 63 AVE, PINECREST FL 33156

CASA PA' FERNANDA

NEW SINGLE-FAMILY RES.
EU-1 RESIDENTIAL
SUBURBAN ESTATE

MATEU ARCHITECTURE INC

THIS DRAWING IS THE PROPERTY OF MATEU ARCHITECTURE INC. UNLESS OTHERWISE PROVIDED FOR BY CONTRACT, THE CONTENTS OF THIS DRAWING ARE CONFIDENTIAL AND SHALL NOT BE TRANSMITTED TO ANY PARTY EXCEPT AS AUTHORIZED BY THE ARCHITECT/ENGINEERS OF RECORD.

COPYRIGHT © BY MATEU ARCHITECTURE INC.

PHASE

PERMIT SET

FILE NAME:

PROJECT NO:

2304

DRAWN BY:

JMM

CHECKED BY:

JMM

ISSUE DATE:

11/14/24

REVISIONS

SHEET TITLE

SECOND FLOOR
LIGHTING PLAN

SHEET:

OF:

E-301

JMM
Consulting Engineers, LLC

10251 SUNSET DRIVE, SUITE 103, MIAMI, FL 33173
TEL (305) 256-1621 FAX (305) 271-0090
Certificate of Authorization #6662

Jose M. Martinez, Mech. P.E. #50018
To the best of my knowledge, the plans and specifications submitted herewith comply with existing interpretations and provisions of the applicable building codes. This drawing is the sole property of JMM Consulting Engineers, LLC and is an instrument of service not to be reproduced in whole or in part without express written permission of JMM Consulting Engineers, LLC.



1 SECOND FLOOR- LIGHTING PLAN
SCALE: 3/16"=1'-0"