


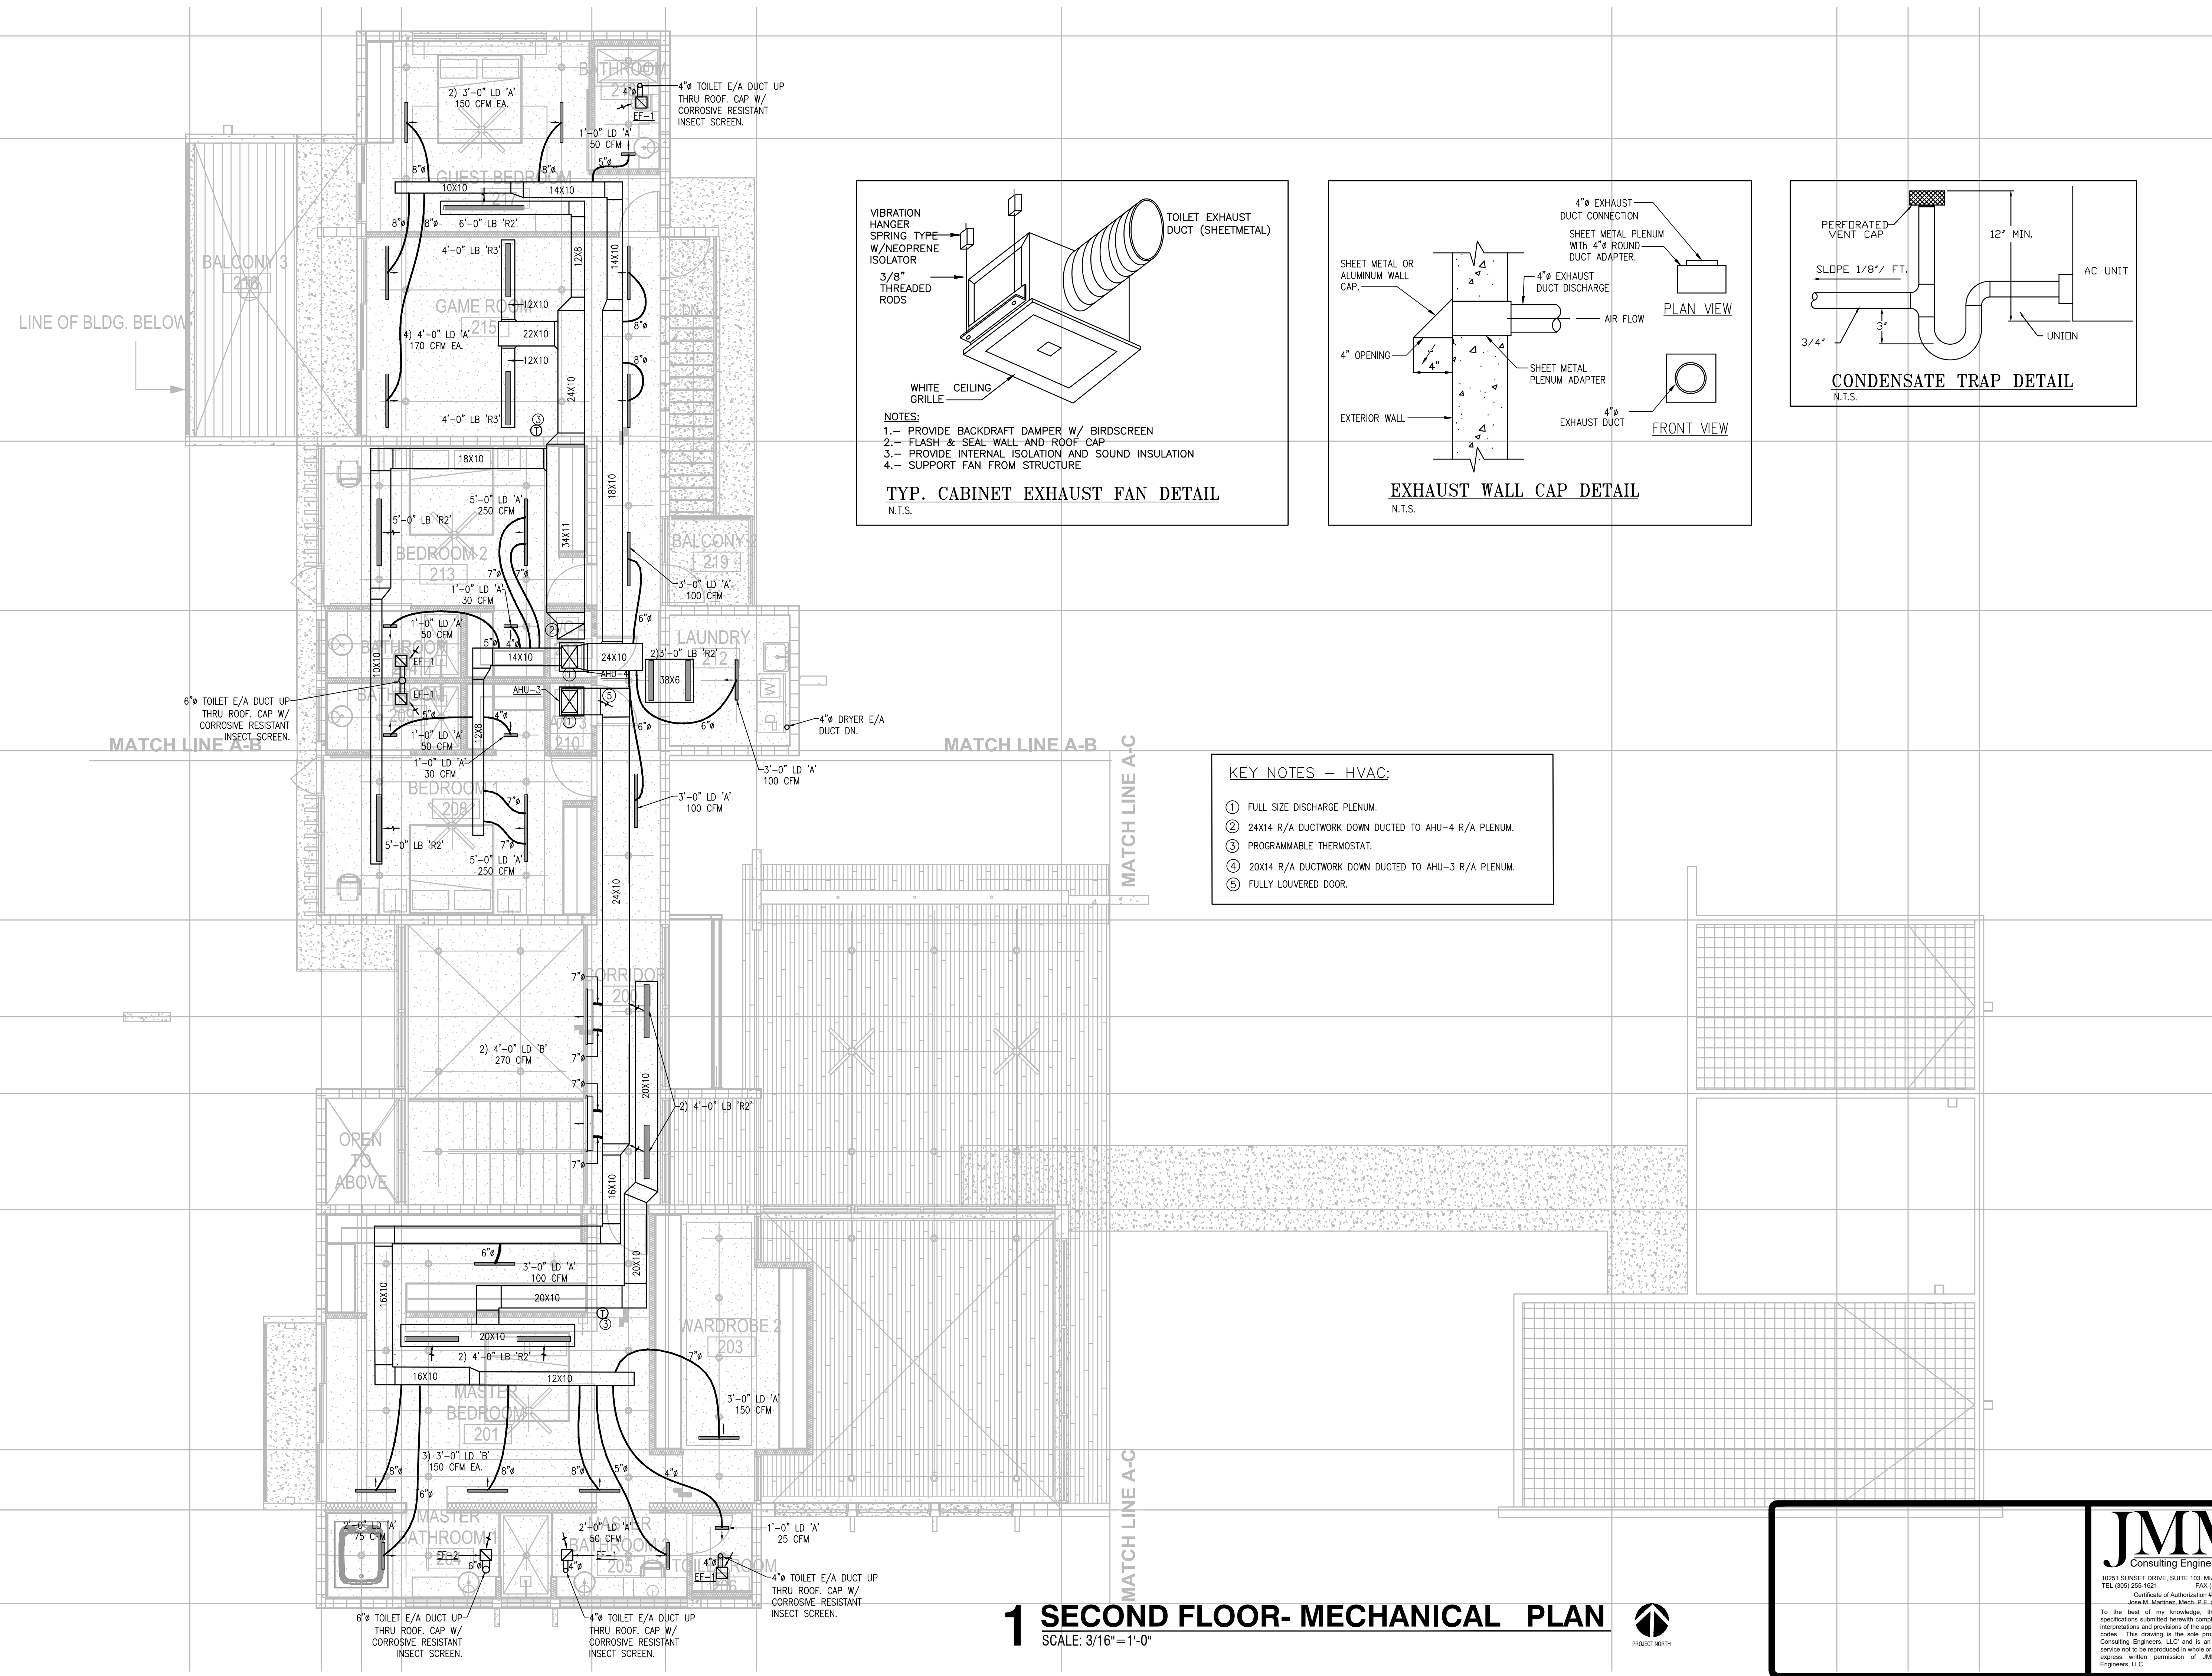

#2600522

MATEU

8887 SOUTHWEST 131  
STREET  
MIAMI, FLORIDA 33176  
305.233.3304 DESIGN@MATEU.CO  
ARCHITECTURE INTERIOR DESIGN PLANNING  
SEAL:

RONNEY J. MATEU, FAIA  
AR0008220

CONSULTANT  
TRADE  
ADDRESS  
CITY & STATE

CONSULTANT  
TRADE  
ADDRESS  
CITY & STATE

CONSULTANT  
TRADE  
ADDRESS  
CITY & STATE

CONSULTANT  
TRADE  
ADDRESS  
CITY & STATE

FERNANDA ROCA  
2304  
13125 SW 63 AVE, PINECREST FL 33156

CASA PA' FERNANDA

NEW SINGLE-FAMILY RES.  
EU-1 RESIDENTIAL  
SUBURBAN ESTATE

MATEU ARCHITECTURE INC.  
THIS DRAWING IS THE PROPERTY OF MATEU  
ARCHITECTURE INC. UNLESS OTHERWISE  
PROVIDED FOR BY CONTRACT. THE  
CONTENTS OF THIS DRAWING ARE  
CONFIDENTIAL AND SHALL NOT BE  
TRANSMITTED TO ANY PARTY EXCEPT AS  
AUTHORIZED BY THE ARCHITECT/ENGINEER  
OF RECORD.  
COPYRIGHT © BY MATEU ARCHITECTURE INC.

PHASE

PERMIT SET

FILE NAME:

PROJECT NO:  
2304

DRAWN BY:  
JMM

CHECKED BY:  
JMM

ISSUE DATE:  
11/14/24

REVISIONS

SHEET TITLE

SECOND FLOOR  
MECHANICAL PLAN

SHEET: OF:

M-101

JMM  
Consulting Engineers, LLC

10281 SUNSET DRIVE, SUITE 103, MIAMI, FL 33173  
TEL (305) 255-1621 FAX (305) 271-0090  
Certificate of Authorization #9592  
John A. Martinez, Mech. P.E. #55015

To the best of my knowledge, the plans and  
specifications submitted herewith comply with existing  
interpretations and provisions of the applicable building  
codes. This drawing is the sole property of JMM  
Consulting Engineers, LLC and is an instrument of  
service not to be reproduced in whole or in part without  
express written permission of JMM Consulting  
Engineers, LLC.

