



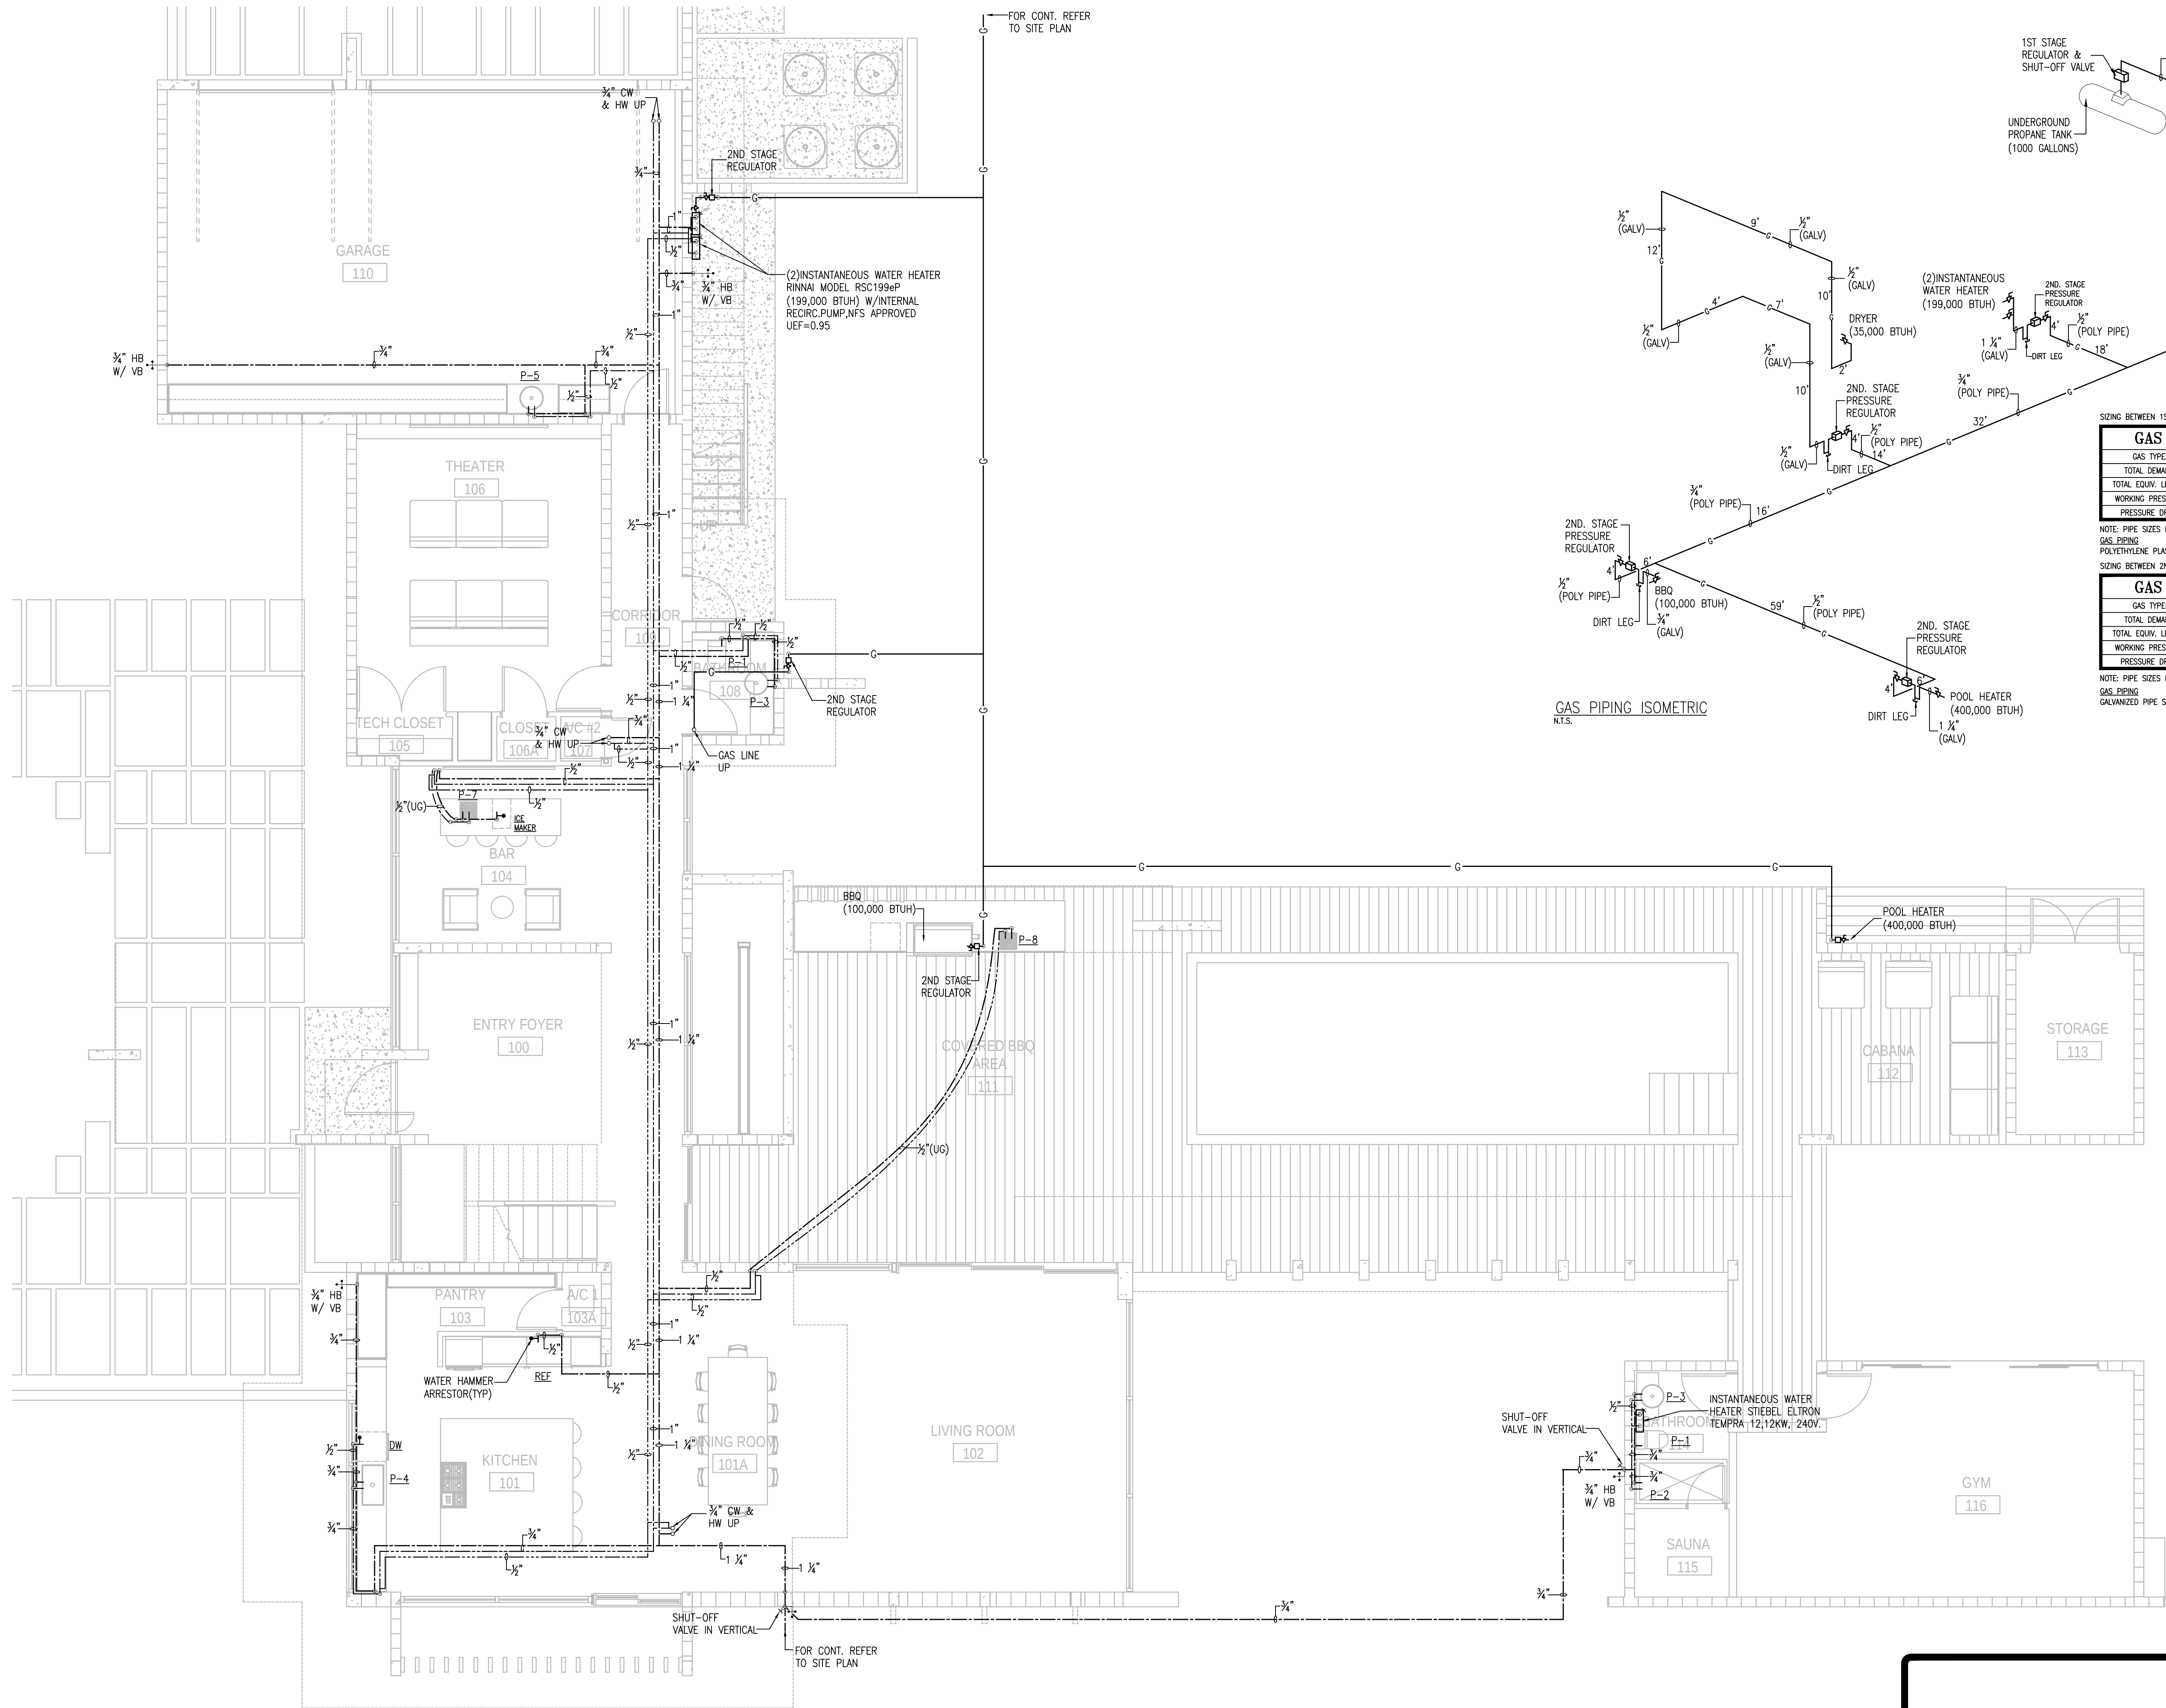

GAS PIPING ISOMETRIC
N.T.S.

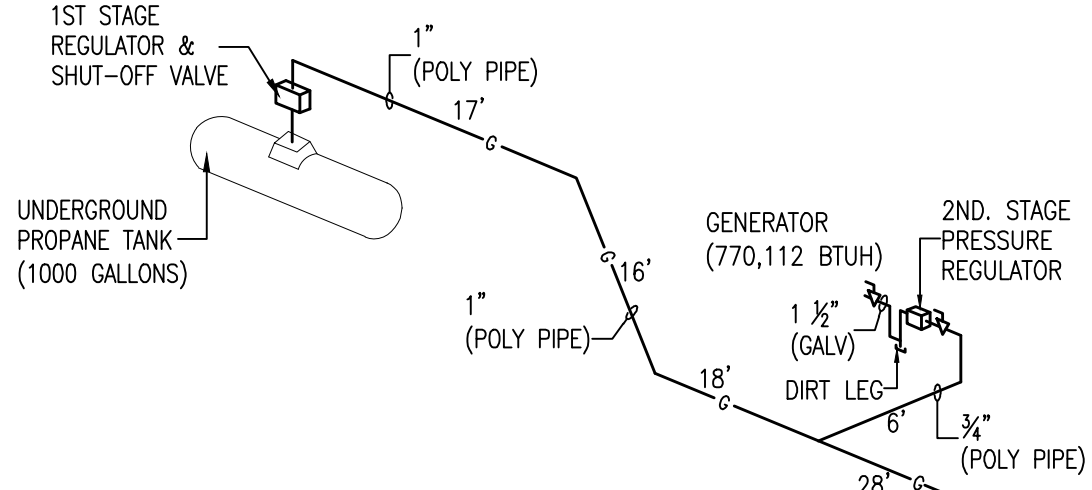

SIZING BETWEEN 1ST STAGE & 2ND STAGE REG.

GAS DESIGN CRITERIA	
GAS TYPE:	LP GAS
TOTAL DEMAND:	1,703,112 MBTU
TOTAL EQUIV. LENGTH:	223'
WORKING PRESSURE:	2 PSI
PRESSURE DROP:	1 PSI

NOTE: PIPE SIZES BASED ON FBC2023 FGC TABLE 402.4(36)
GAS PIPING
POLYETHYLENE PLASTIC PIPE

SIZING BETWEEN 2ND STAGE REGULATOR & APPLIANCE

GAS DESIGN CRITERIA	
GAS TYPE:	LP GAS
TOTAL DEMAND:	770,112 MBTU
TOTAL EQUIV. LENGTH:	54'
WORKING PRESSURE:	LESS THAN 1 PSI
PRESSURE DROP:	0.5" WATER COLUMN

NOTE: PIPE SIZES BASED ON FBC2023 FGC TABLE 402.4(28)
GAS PIPING
GALVANIZED PIPE SCHEDULE 40

1 GROUND FLOOR PLUMBING PLAN

SCALE: 3/16"=1'-0"



JMM
Consulting Engineers, LLC
10251 SUNSET DRIVE, SUITE 103, MIAMI, FL 33173
TEL (305) 256-1621 FAX (305) 271-0090
Certificate of Authorization #6662
Jose M. Martinez, Mech. P.E. #56018
To the best of my knowledge, the plans and specifications submitted herewith comply with existing interpretations and provisions of the applicable building codes. This drawing is the sole property of JMM Consulting Engineers, LLC and is an instrument of service not to be reproduced in whole or in part without express written permission of JMM Consulting Engineers, LLC.

#26000522



8807 SOUTHWEST 131 STREET
MIAMI, FLORIDA 33176
305.531.3334 DESIGN@MATEU.CO
ARCHITECTURE INTERIOR DESIGN PLANNING
SEAL:

RONEY J. MATEU, FAIA
AR0008220

CONSULTANT
TRADE
ADDRESS
CITY & STATE

CONSULTANT
TRADE
ADDRESS
CITY & STATE

CONSULTANT
TRADE
ADDRESS
CITY & STATE

CONSULTANT
TRADE
ADDRESS
CITY & STATE

FERNANDA ROCA
2304
13125 SW 63 AVE, PINECREST FL 33156

CASA PA' FERNANDA

NEW SINGLE-FAMILY RES.
EU-1 RESIDENTIAL
SUBURBAN ESTATE

MATEU ARCHITECTURE INC

THIS DRAWING IS THE PROPERTY OF MATEU ARCHITECTURE INC. UNLESS OTHERWISE PROVIDED FOR BY CONTRACT, THE CONTENTS OF THIS DRAWING ARE CONFIDENTIAL AND SHALL NOT BE TRANSMITTED TO ANY PARTY EXCEPT AS AUTHORIZED BY THE ARCHITECT/ENGINEERS OF RECORD.
COPYRIGHT © BY MATEU ARCHITECTURE INC.

PHASE

PERMIT SET

FILE NAME:

PROJECT NO:
2304

DRAWN BY:
JMM

CHECKED BY:
JMM

ISSUE DATE:
11/14/24

REVISIONS

SHEET TITLE

GROUND FLOOR
PLUMBING PLAN
(DOMESTIC WATER)

SHEET:

OF:

P-201