


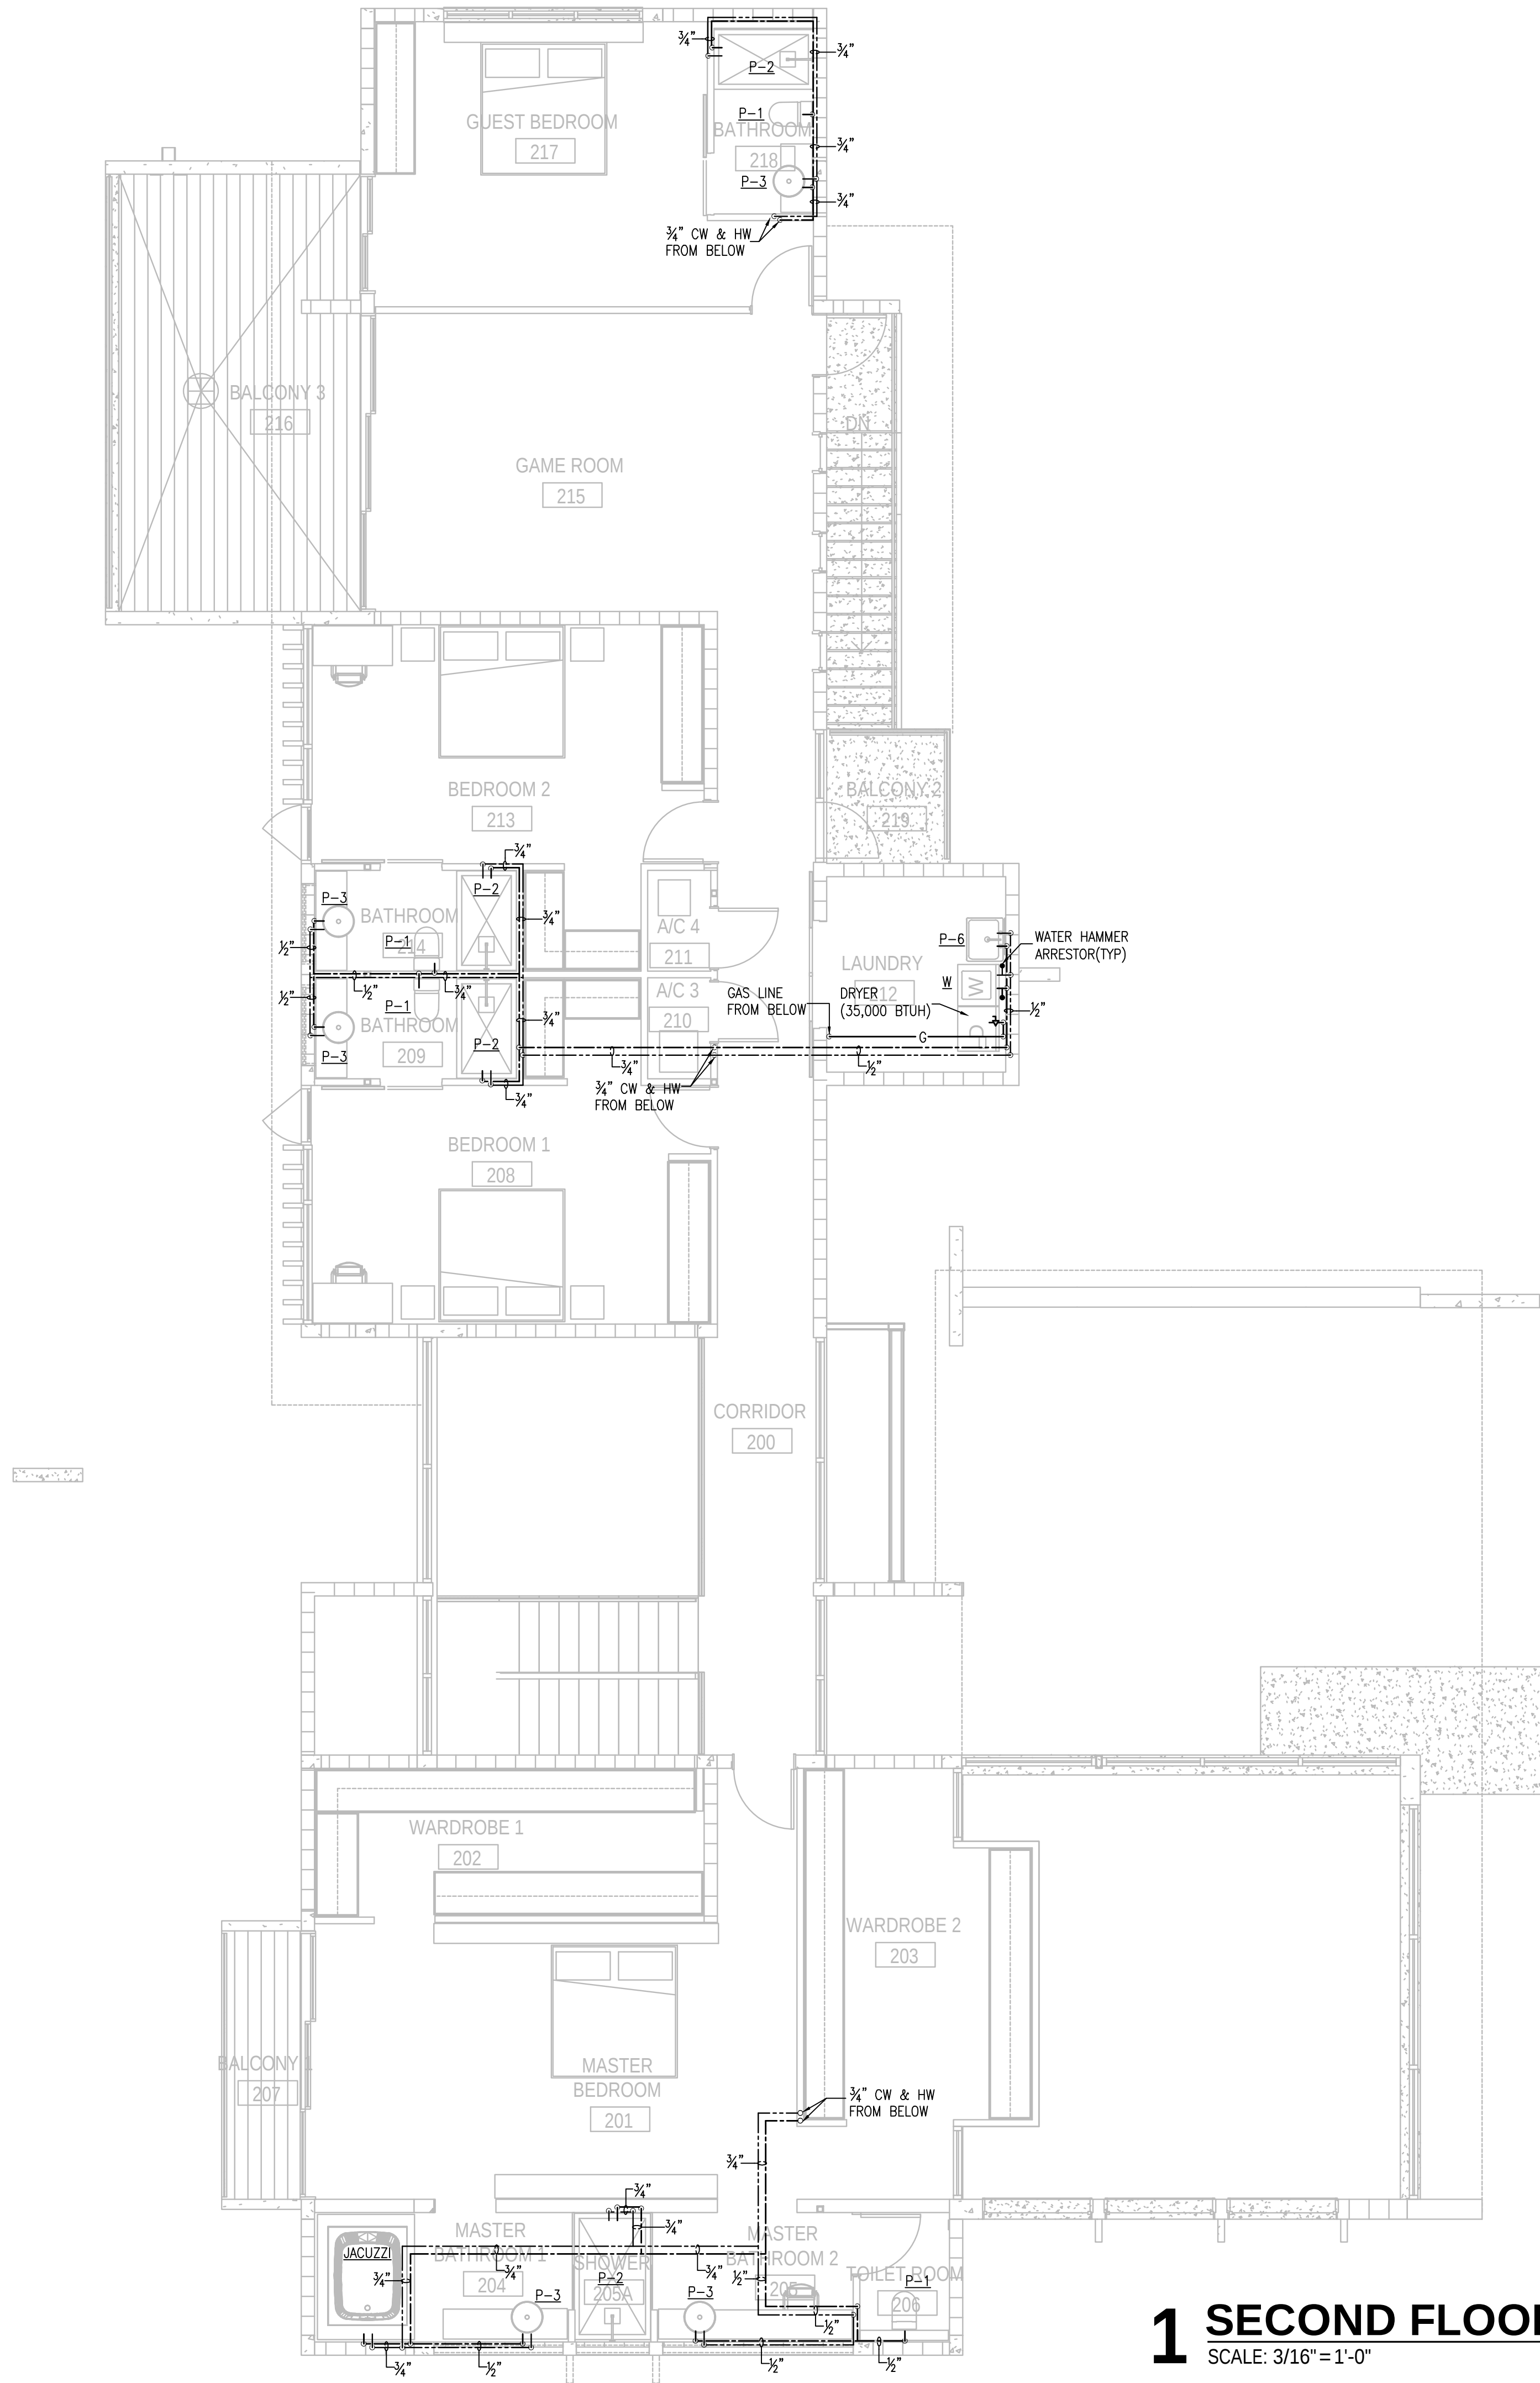

**1 SECOND FLOOR- PLUMBING PLAN**  
SCALE: 3/16"=1'-0"



**JMM**  
Consulting Engineers, LLC  
10251 SUNSET DRIVE, SUITE 103, MIAMI, FL 33173  
TEL (305) 256-1621 FAX (305) 271-0090  
Certificate of Authorization #6662  
Jose M. Martinez, Mech, P.E. #56018  
To the best of my knowledge, the plans and specifications submitted herewith comply with existing interpretations and provisions of the applicable building codes. This drawing is the sole property of JMM Consulting Engineers, LLC and is an instrument of service not to be reproduced in whole or in part without express written permission of JMM Consulting Engineers, LLC.

#26000592

**MATEU**

887 SOUTHWEST 131 STREET  
MIAMI, FLORIDA 33176  
305.521.3334 DESIGN@MATEU.LLC  
ARCHITECTURE INTERIOR DESIGN PLANNING  
SEAL:

RONEY J. MATEU, FAIA  
AR0008220

CONSULTANT  
TRADE  
ADDRESS  
CITY & STATE

CONSULTANT  
TRADE  
ADDRESS  
CITY & STATE

CONSULTANT  
TRADE  
ADDRESS  
CITY & STATE

CONSULTANT  
TRADE  
ADDRESS  
CITY & STATE

FERNANDA ROCA  
2304  
13125 SW 63 AVE, PINECREST FL 33156

CASA PA' FERNANDA

NEW SINGLE-FAMILY RES.  
EU-1 RESIDENTIAL  
SUBURBAN ESTATE

MATEU ARCHITECTURE INC.

THIS DRAWING IS THE PROPERTY OF MATEU ARCHITECTURE INC. UNLESS OTHERWISE PROVIDED FOR BY CONTRACT, THE CONTENTS OF THIS DRAWING ARE CONFIDENTIAL AND SHALL NOT BE TRANSMITTED TO ANY PARTY EXCEPT AS AUTHORIZED BY THE ARCHITECT/ENGINEERS OF RECORD.  
COPYRIGHT © BY MATEU ARCHITECTURE INC.

PHASE

PERMIT SET

FILE NAME:

PROJECT NO:  
2304

DRAWN BY:  
JMM

CHECKED BY:  
JMM

ISSUE DATE:  
11/14/24

REVISIONS

SHEET TITLE

SECOND FLOOR  
PLUMBING PLAN  
(DOMESTIC WATER)

SHEET: OF:

P-203