

30' SIDE STREET SETBACK LINE

MATCH LINE A-B

MATCH LINE A-B

MATCH LINE A-C

MATCH LINE A-C

1 SECOND FLOOR- ELECTRICAL PLAN

SCALE: 3/16"=1'-0"



JMM
Consulting Engineers, LLC
10251 SUNSET DRIVE, SUITE 103, MIAMI, FL 33173
TEL (305) 255-1621 FAX (305) 271-0590
Certificate of Authorization #96652
Jose M. Martinez, Mech. P.E. #96018
To the best of my knowledge, the plans and specifications submitted herewith comply with existing interpretations and provisions of the applicable building codes. This drawing is the sole property of JMM Consulting Engineers, LLC and is an instrument of service not to be reproduced in whole or in part without express written permission of JMM Consulting Engineers, LLC.

#26000522

MATEU
8887, SOUTHWEST 131 STREET
MIAMI, FLORIDA 33176
305.223.3304 DESIGN@MATEU.CO
ARCHITECTURE INTERIOR DESIGN PLANNING
SEAL:

RONEY J. MATEU, FAIA
AR0008220

G.F. CONSULTING ENGINEERS, INC.
STRUCTURAL ENGINEERING
13170 SW 128 STREET, SUITE 204
MIAMI, FLORIDA 33166

JMM CONSULTING ENGINEERS
MECH. ELEC. PLUMB. ENGINEERING
10251 SUNSET DRIVE, SUITE 103
MIAMI, FLORIDA 33173

CARLAB, INC.
CIVIL ENGINEERING
8730 SW 25 STREET
MIAMI, FLORIDA 33165

CARLOS MAURICIO &
FERNANDA ROCA
MA 2405
13125 SW 63 AVENUE
PINECREST, FLORIDA 33156

CASA @
63RD AVENUE

NEW SINGLE-FAMILY RES.
EU-1 RESIDENTIAL ESTATE

MATEU ARCHITECTURE INC

THIS DRAWING IS THE PROPERTY OF MATEU ARCHITECTURE INC. UNLESS OTHERWISE PROVIDED FOR BY CONTRACT, THE CONTENTS OF THIS DRAWING ARE CONFIDENTIAL AND SHALL NOT BE TRANSMITTED TO ANY PARTY EXCEPT AS AUTHORIZED BY THE ARCHITECT/ENGINEERS OF RECORD.
COPYRIGHT © BY MATEU ARCHITECTURE INC.

PHASE

Project Status

FILE NAME:

PROJECT NO:
MA 2405

DRAWN BY:
JMM

CHECKED BY:
JMM

ISSUE DATE:
11/01/24

REVISIONS

B.D.C. 11-25-24

SHEET TITLE

SECOND FLOOR
ELECTRICAL PLAN

SHEET:

OF:


E-201

NOTES:

1. ELECTRICAL WORK SHALL COMPLY WITH EIA-TIA.
2. PRIOR TO ANY WORK COORDINATE WITH EACH PROVIDER FOR ACCESSORIES, MOUNTING HEIGHT, ETC.
3. REQUIRED FIRE RATING OF ALL WALLS.
4. REFER TO FLOOR PLAN FOR EXACT QUANTITIES AND LOCATIONS OF STRUCTURED MEDIA OUTLETS. VERIFY WITH OWNER PRIOR TO COMMENCEMENT OF WORK.

INSTALLATION INSTRUCTIONS FOR UL No. CAJ1149

STEP 1 - PREPARATION: ALL SURFACES MUST BE CLEAN, SOUND, DRY AND FROST FREE PRIOR TO APPLICATION OF MATERIALS.
STEP 2 - BACKING MATERIAL: PACK MINERAL WOOL TIGHTLY AROUND THE PENETRATING ITEM TO THE DEPTH SHOWN IN THE DRAWINGS, AND RECESS IT BELOW THE TOP SURFACE OF THE FLOOR (OR BOTH SURFACES OF A WALL) TO ALLOW PROPER SPACE FOR THE FIRESTOP MATERIAL.
STEP 3 - FIRESTOP SEALANT: APPLY THE FIRESTOP SEALANT OVER THE BACKING MATERIAL TO THE DEPTH SHOWN. IF THE PIPE IS OFFSET TO ONE SIDE, APPLY A 1/2" BEAD OF FIRESTOP SEALANT AROUND ITS CIRCUMFERENCE WHERE IT CONTACTS THE WALL OR FLOOR.
WALL PENETRATIONS REQUIRED FIRESTOP SEALANT ON BOTH SIDES. LEAVE COMPLETED SEAL UNDISTURBED FOR 48 HOURS.

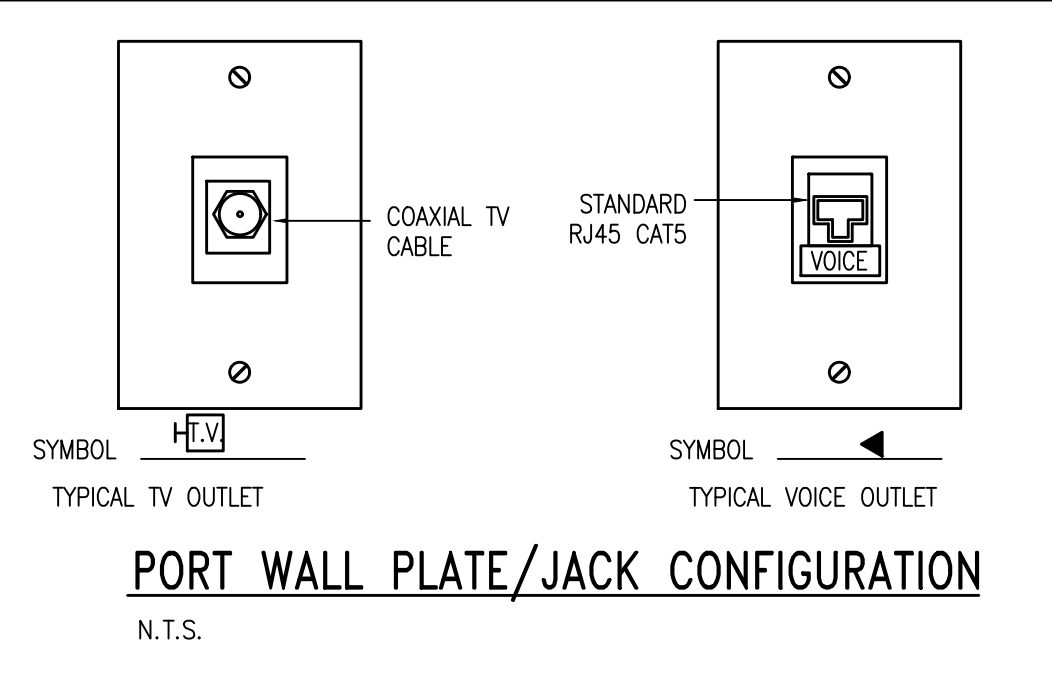

20' INTERIOR SIDE SETBACK LINE

50' FRONT SETBACK LINE