

0635 SW 63 AV
MIAMI, FL


A circular professional engineer seal for Daniel F. Gutierrez, License No. 49086, State of Florida. The seal features the text "DANIEL F. GUTIERREZ", "LICENSE", "No. 49086", "STATE OF FLORIDA", and "PROFESSIONAL ENGINEER" around the perimeter. There are three stars on the seal. A stylized drawing of a satellite or probe is superimposed over the seal.

DANIEL F. GUTIERREZ, P.E.
ELECTRICAL ENGINEER

LIC. #049086

[illegible]


SEAL

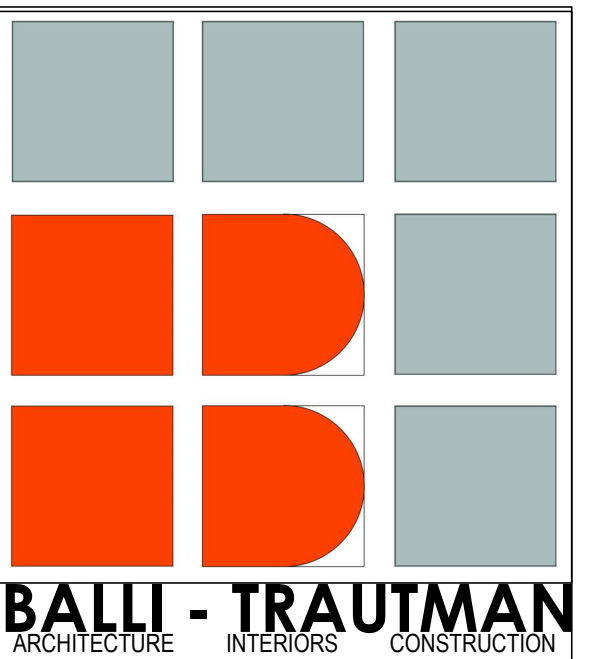

SHEET TITLE

SHEET NUMBER

COPYRIGHT BALLI-TRAUTMAN ARCHITECTS, LLC
1533 SUNSET DRIVE SUITE 101, CORAL GABLES, FL 33143

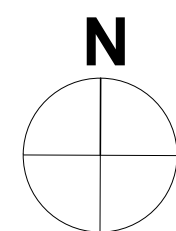

ELECTRICAL LIGHTING 1ST FLOOR PLAN
SCALE: 3/16" = 1'-0"

"This item has been digitally signed and sealed by Daniel F. Gutierrez on the date adjacent to the seal. Printed copies of this document are not considered signed and sealed and the signature must be verified on any electronic copies"

29111 KINSINGTON COURT
WESLEY CHAPEL
PH: (786)499-4167
Email: danny@dfgengineers.com

DG CONSULTING ENGINEERS, LLC
DESIGN — INSPECTIONS