


10635 SW 63 AV
MIAMI, FL

SEAL

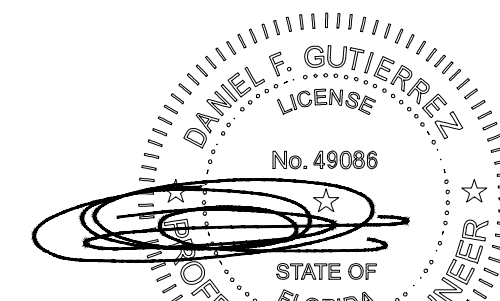


11-13-24

DANIEL F. GUTIERREZ, P.E.
ELECTRICAL ENGINEER LIC. #049086

[illegible]

SCHEMATIC SET

SEAI

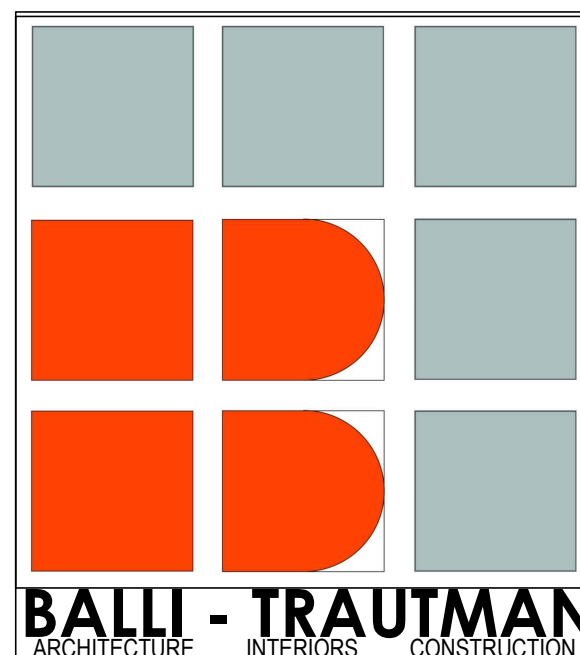

JOB NUMBER:

CHECKED BY: _____ GB _____

ISSUE DATE: _____ Issue Date _____

SCALE: AS NOTED


SHEET TITLE

MECHANICAL 1ST FLOOR PLAN

SHEET NUMBER

M-101

COPYRIGHT BALLI-TRAUTMAN ARCHITECTS, LLC
1533 SUNSET DRIVE SUITE 101, CORAL GABLES, FL 3314

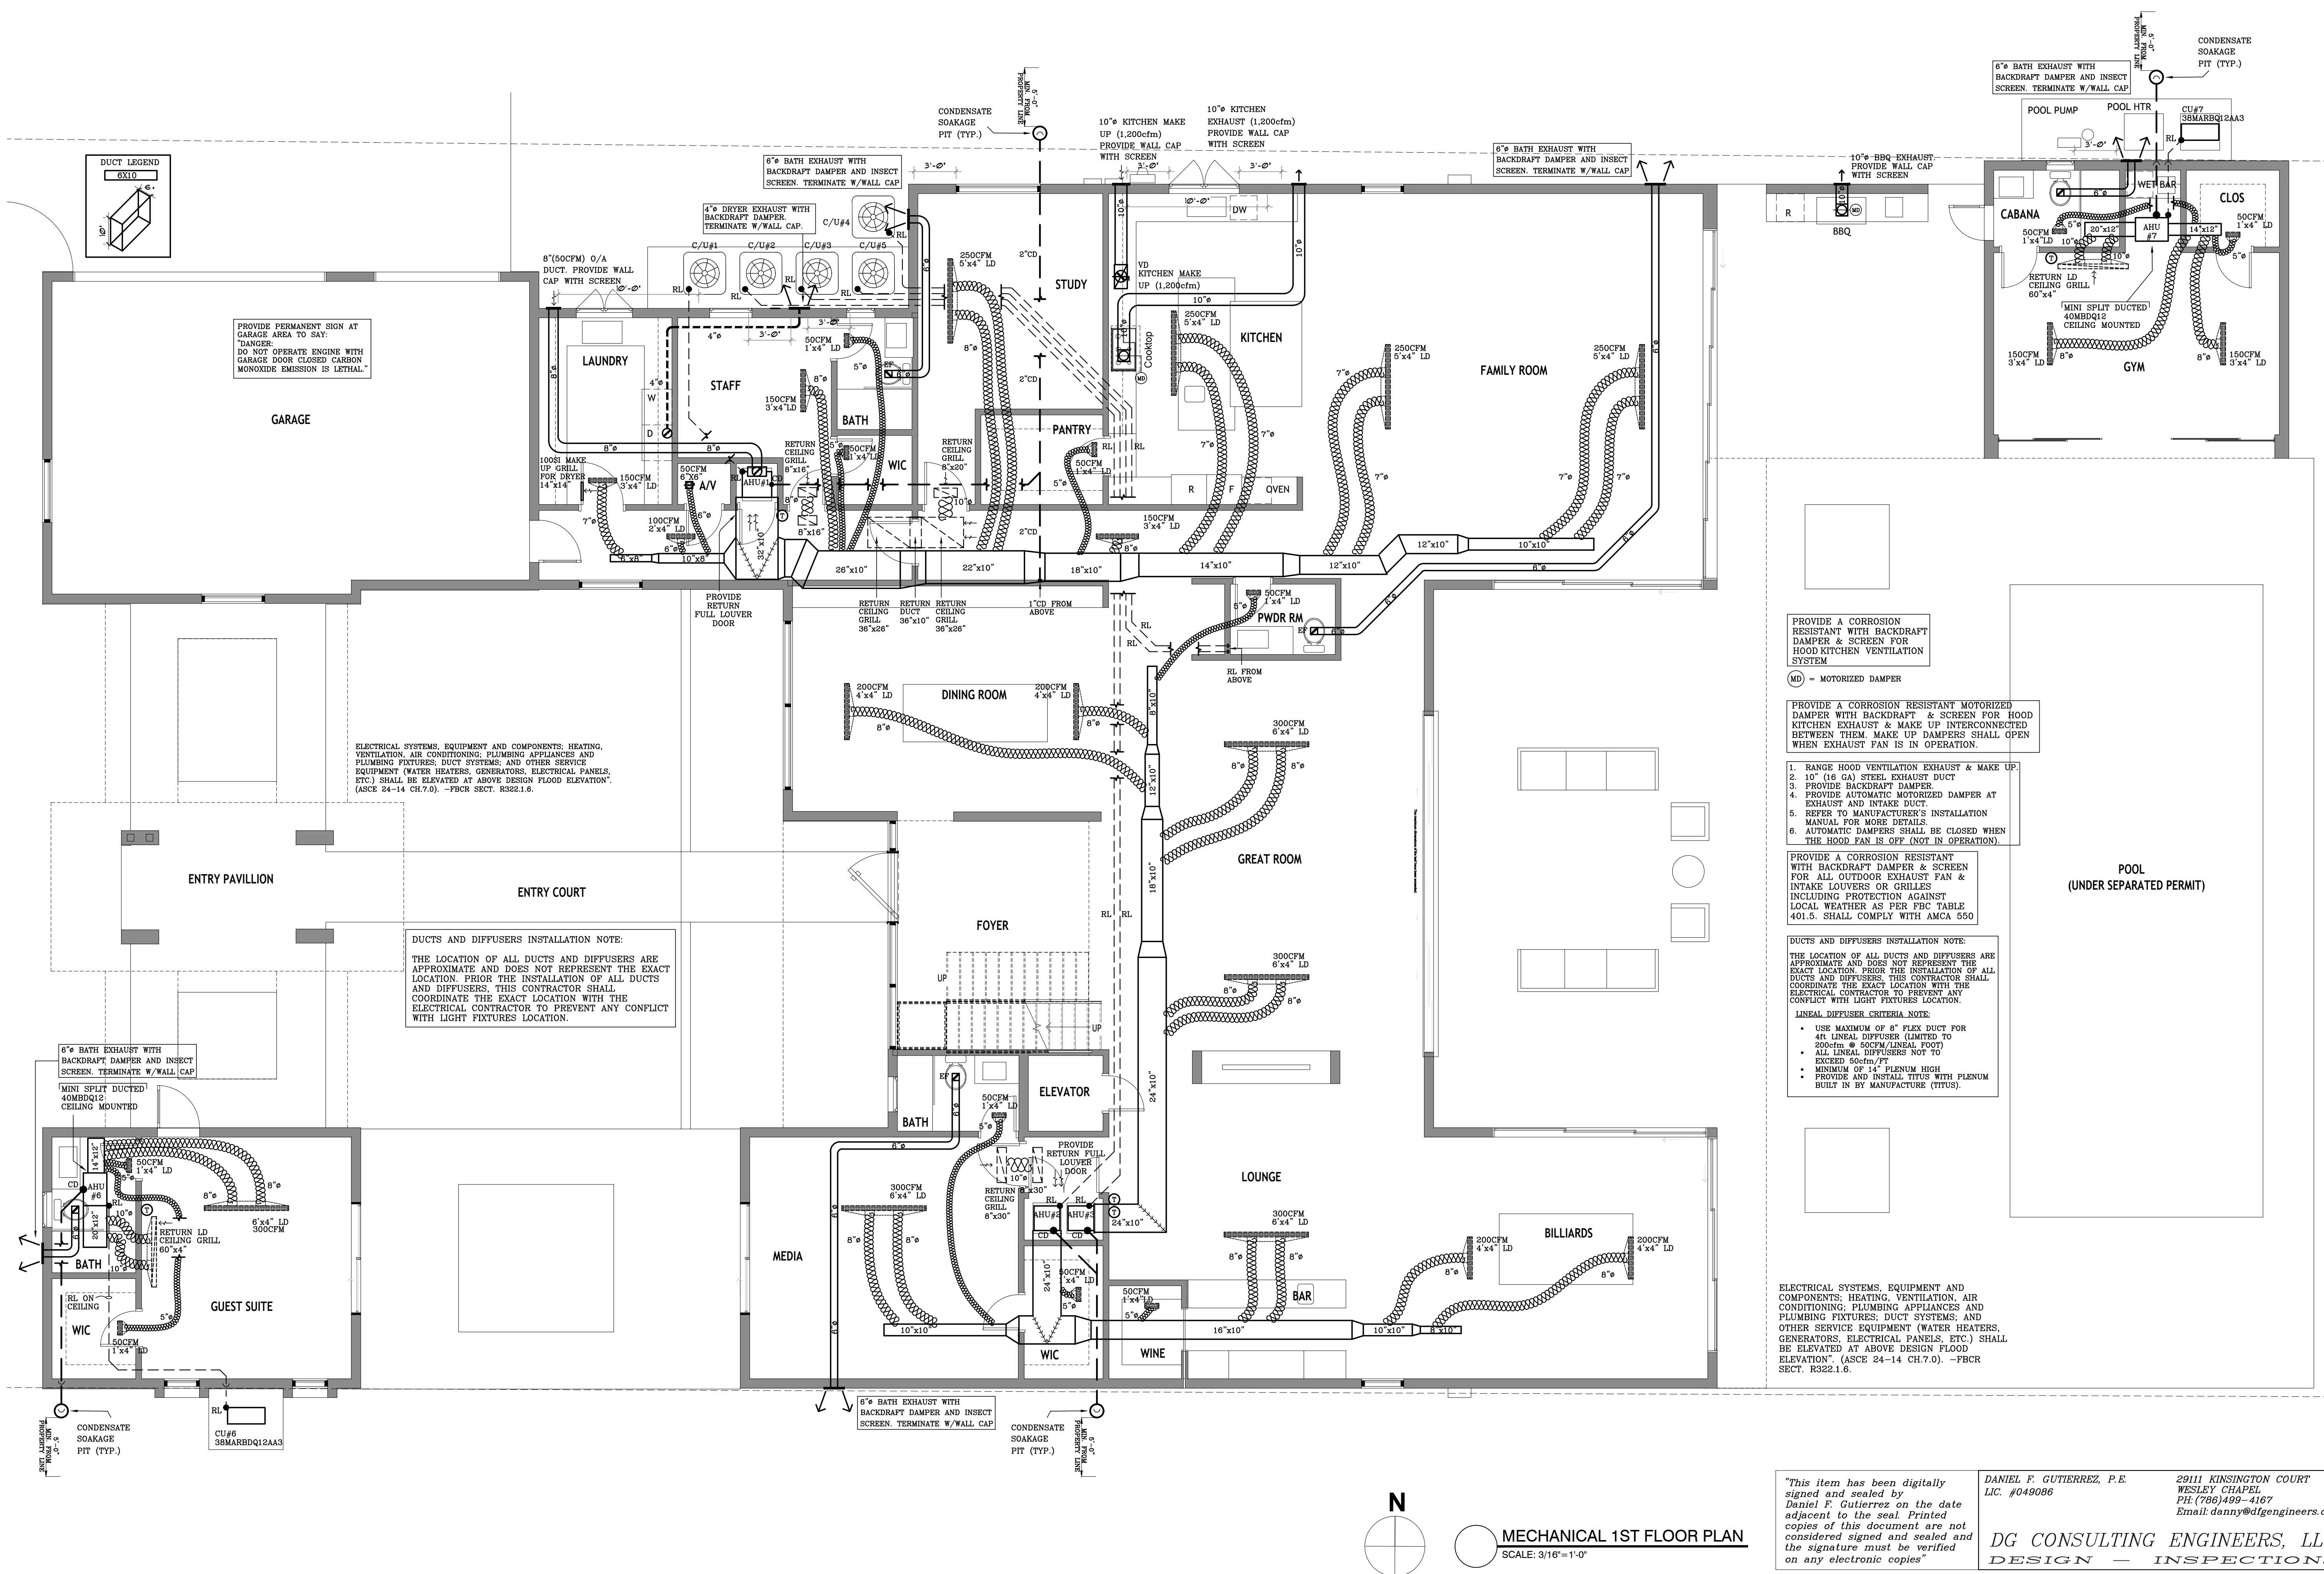

"This item has been digitally signed and sealed by Daniel F. Gutierrez on the date adjacent to the seal. Printed copies of this document are not considered signed and sealed and the signature must be verified on any electronic copies"

DANIEL F. GUTIERREZ, P.E.
LIC. #049086

29111 KINSINGTON COURT
WESLEY CHAPEL
PH: (786)499-4167
Email: danny@dfgengineers.com

DG CONSULTING ENGINEERS, LLC
DESIGN - INSPECTIONS