


10635 SW 63 AV
MIAMI, FL

SEAL

[illegible]



SEAL

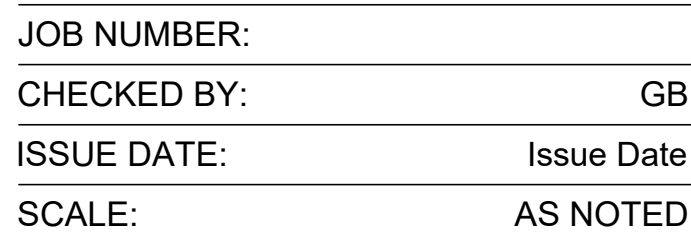

PLUMBING SANITARY 2ND FLOOR PLAN

P-103


PLUMBING SYMBOLS

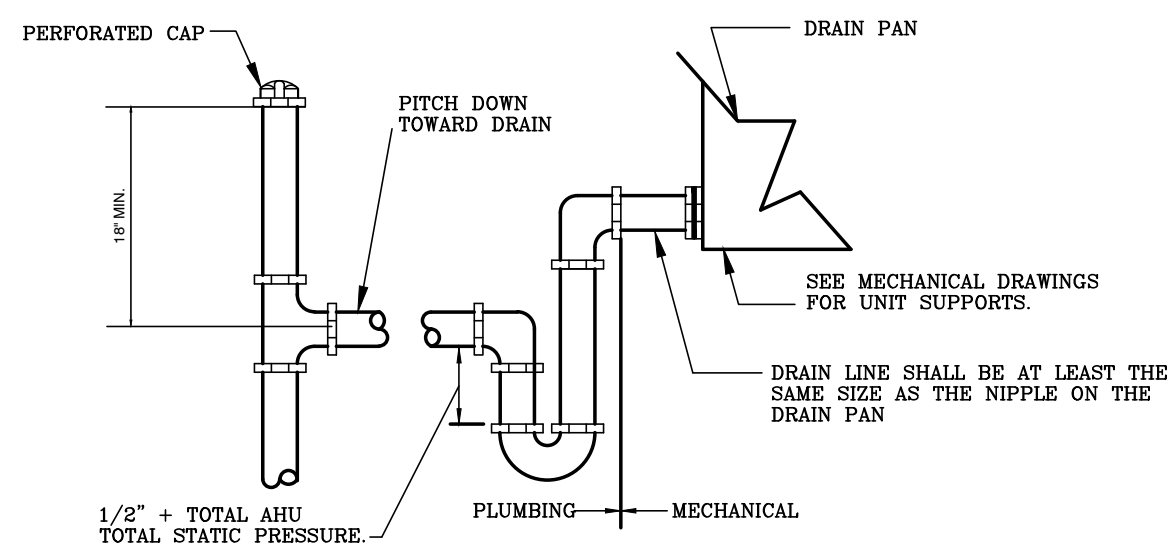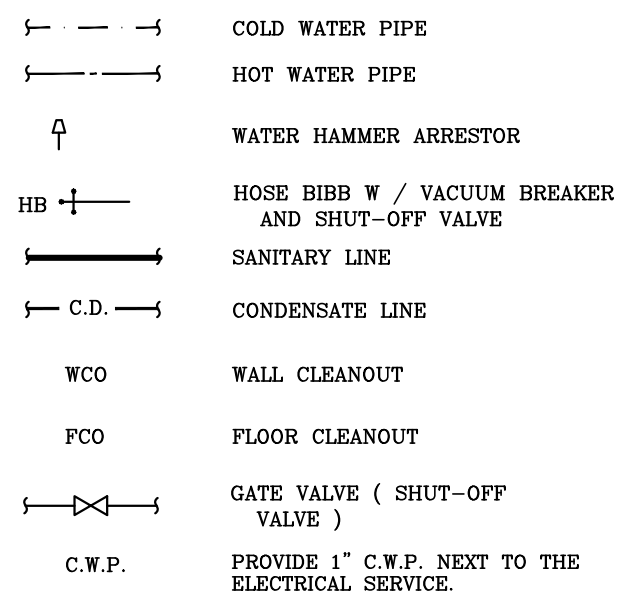



N.T.S.

Diagram illustrating the cross-section of a well casing and screen assembly. The assembly consists of a 24" DIA X 24" REINFORCED CONCRETE PIPE with a 2" CONDENSATE DRAIN PIPE inside. The pipe is surrounded by CLEAN LOOSE PEA ROCK. The top of the pipe is at FIN. GRADE. The bottom of the pipe is in contact with the PREVIOUS ROCK layer. The overall diameter of the pipe is 24" ϕ .

N.T.S.

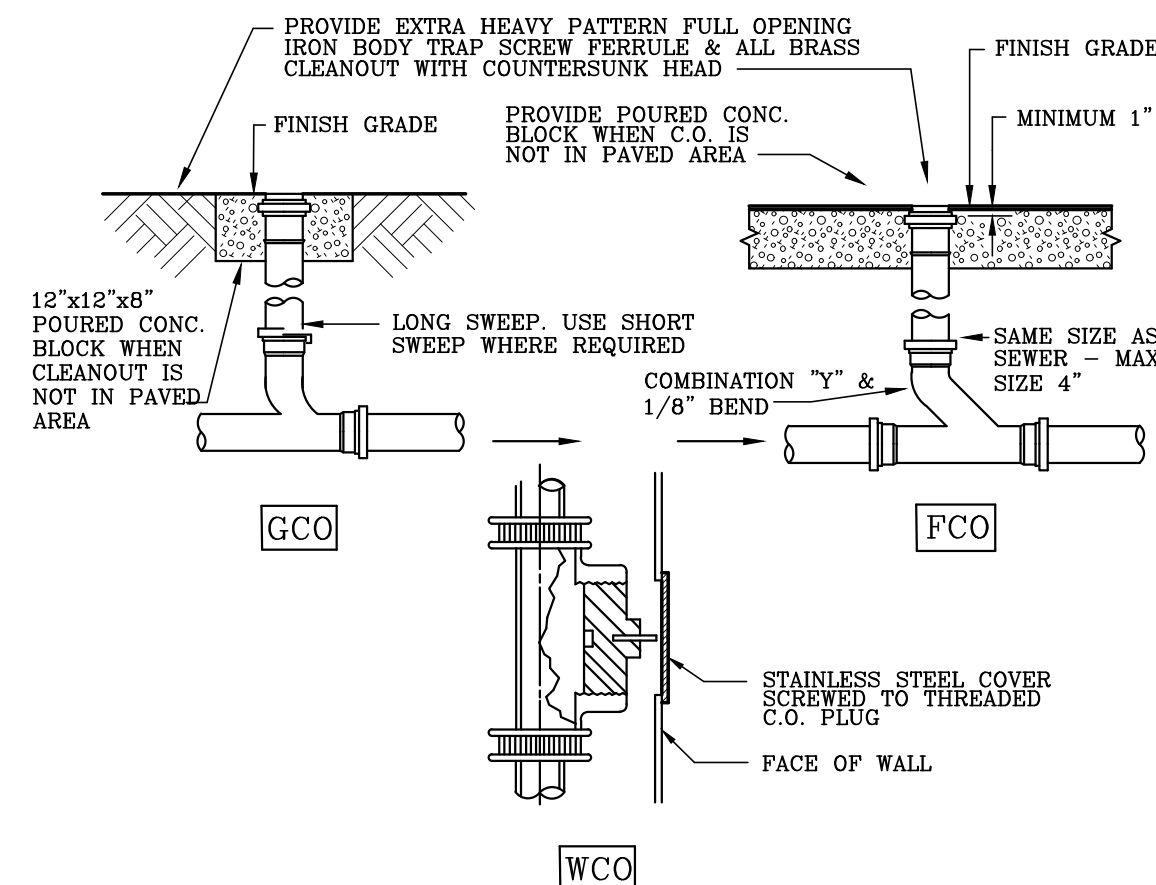

TYPICAL CLEANOUT DETAIL
N.T.S.

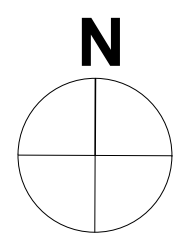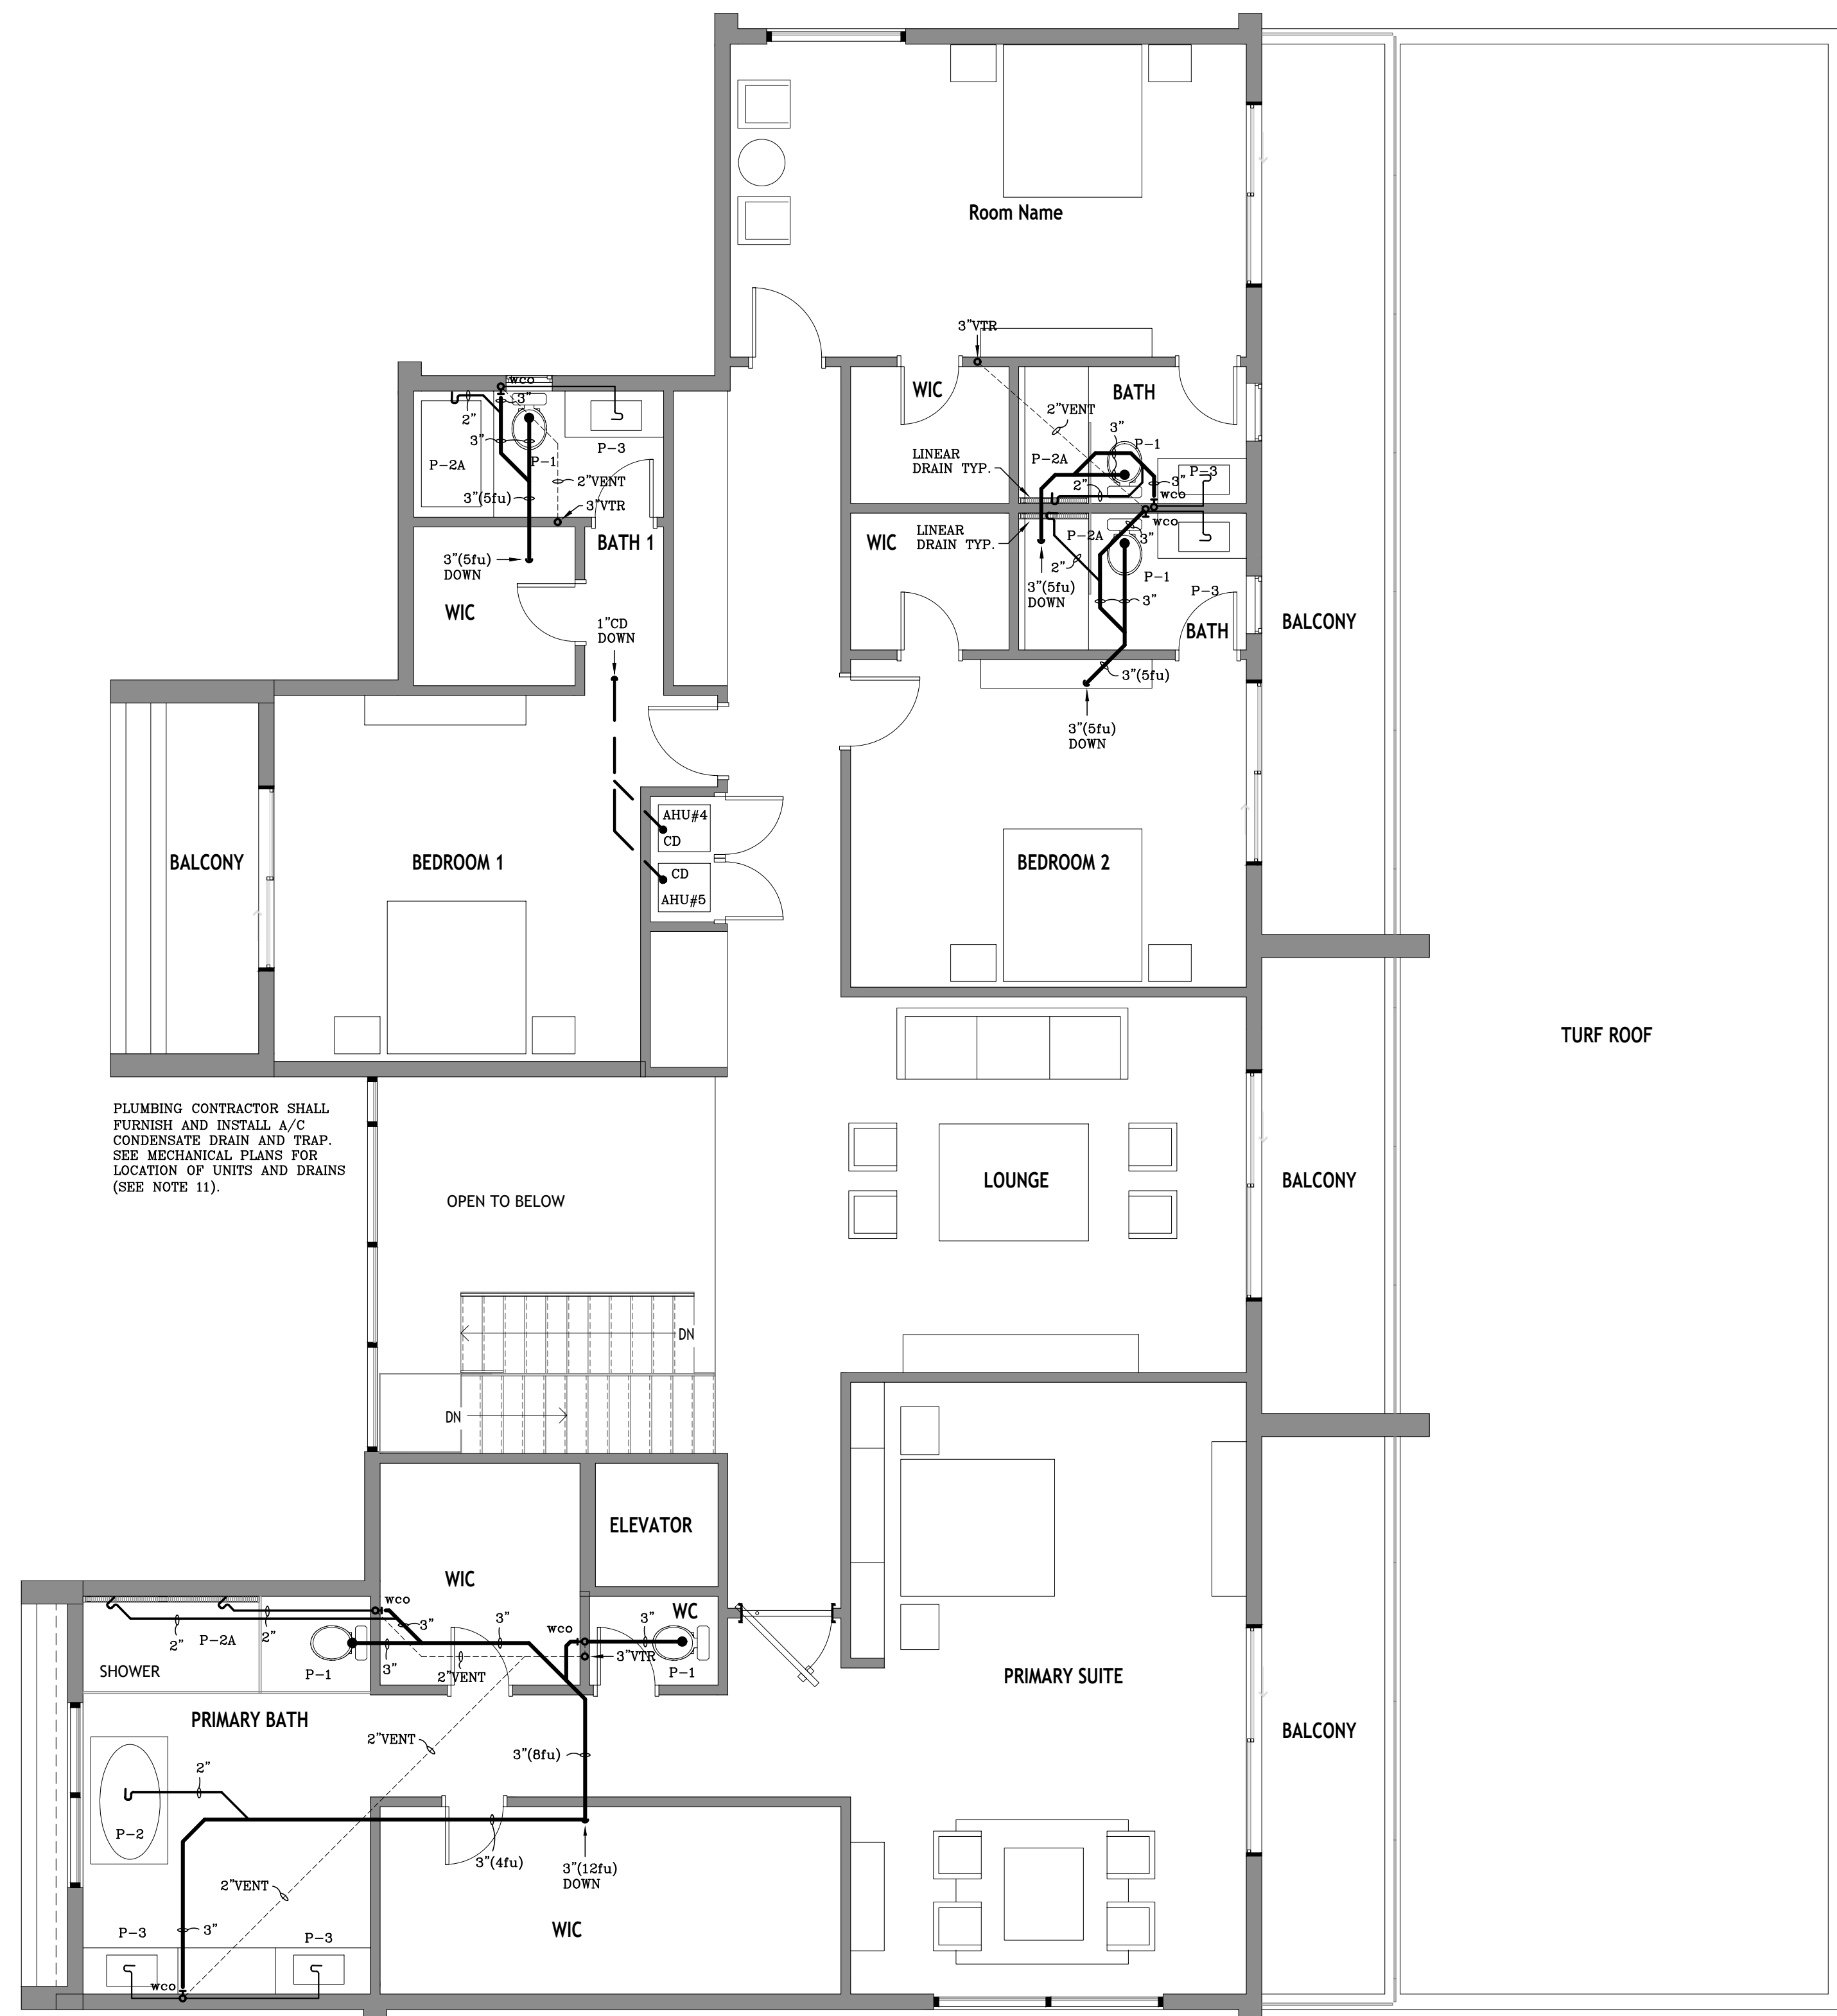

SCALE: 3/16"=1'-0"

"This item has been digitally signed and sealed by Daniel F. Gutierrez on the date adjacent to the seal. Printed copies of this document are not considered signed and sealed and the signature must be verified on any electronic copies"

29111 KINSINGTON COURT
WESLEY CHAPEL
PH: (786)499-4167
Email: danny@dfgengineers.com

DG CONSULTING ENGINEERS, LLC
DESIGN - INSPECTIONS