


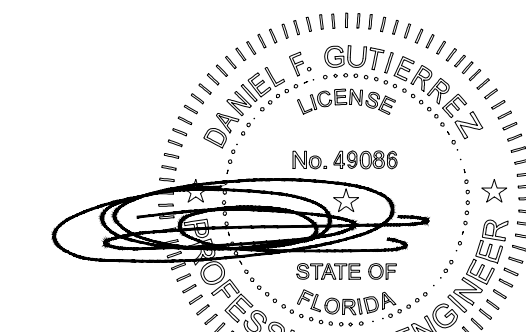


01-20-25
DANIEL F. GUTIERREZ, P.E.
ELECTRICAL ENGINEER
LIC. #049086

REVISIONS

NO.	DESC	DATE
1.	Bldg Dept Comm	01-20-25

SCHEMATIC SET

SEAL

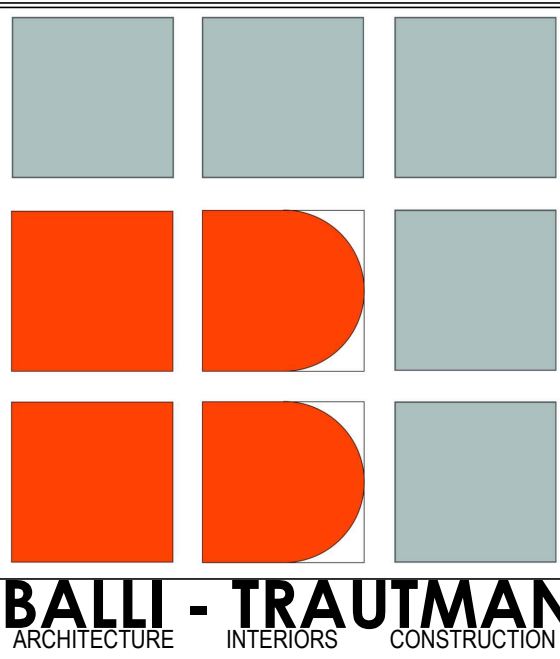



JOB NUMBER:
CHECKED BY: GB
ISSUE DATE: Issue Date
SCALE: AS NOTED

SHEET TITLE

MECHANICAL 1ST
FLOOR PLAN

SHEET NUMBER

M-101

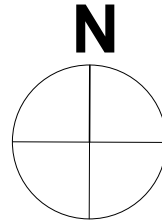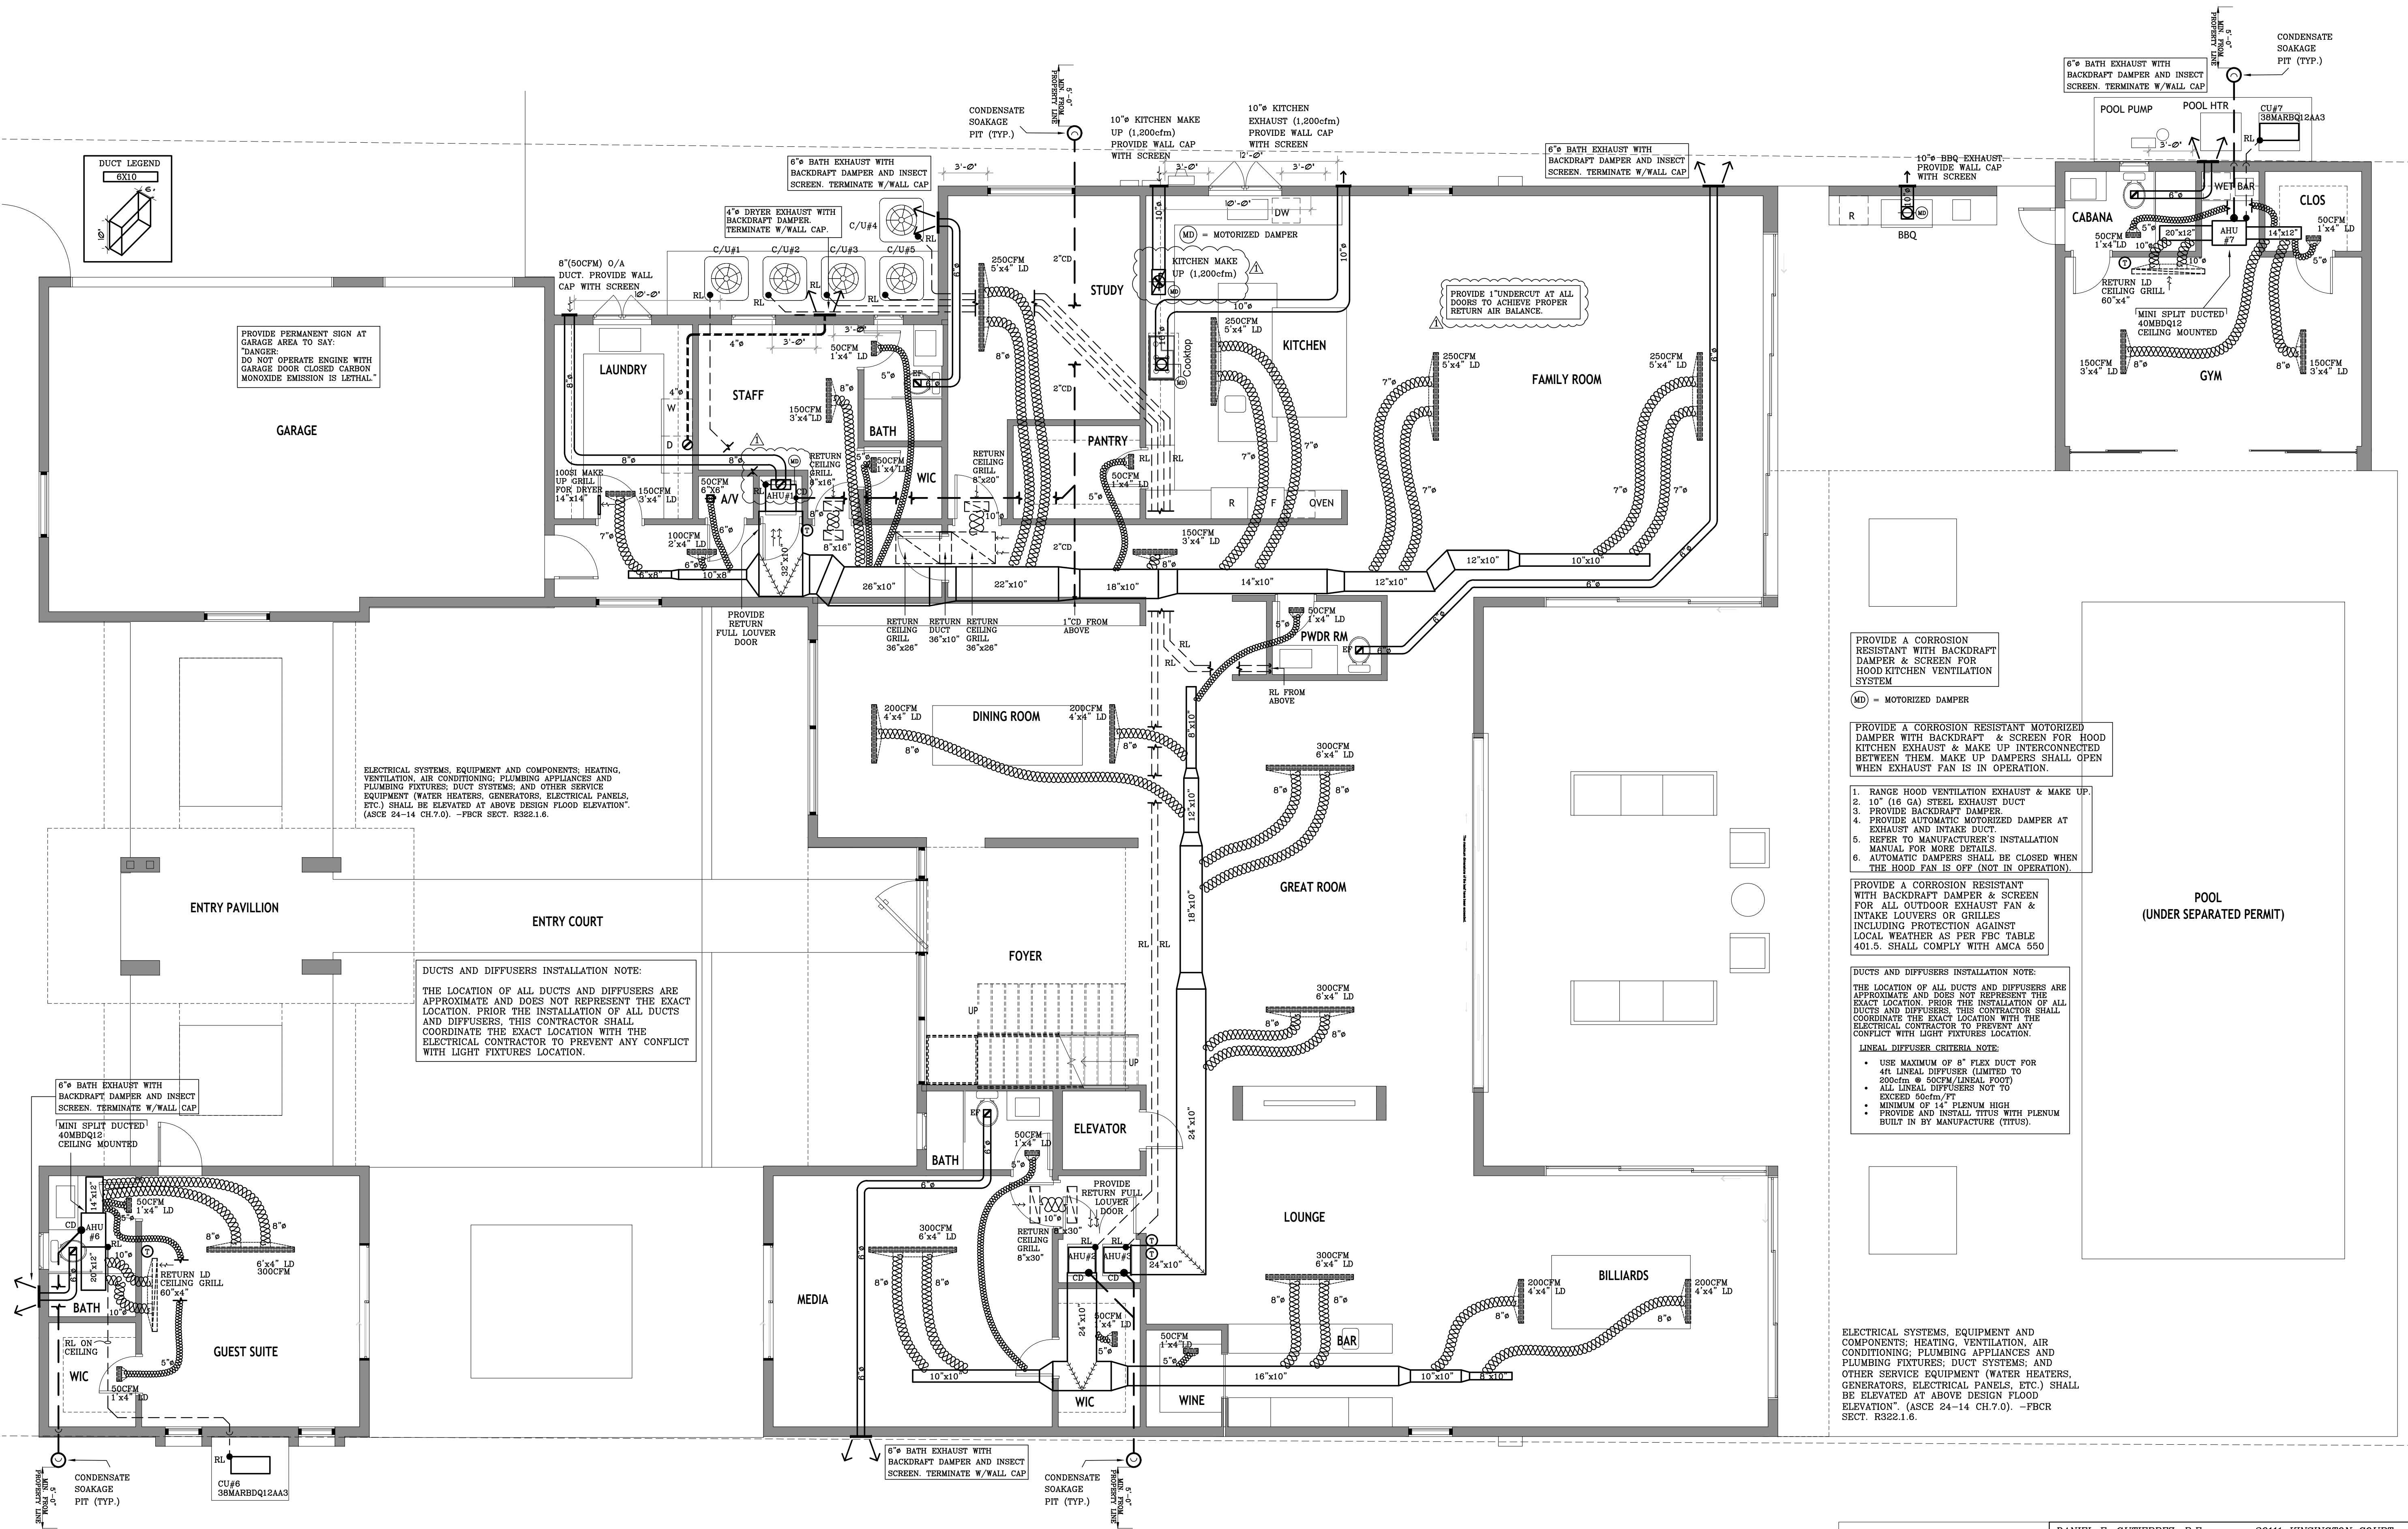

MECHANICAL 1ST FLOOR PLAN
SCALE: 3/16"=1'-0"

"This item has been digitally signed and sealed by Daniel F. Gutierrez on the date adjacent to the seal. Printed copies of this document are not considered signed and sealed and the signature must be verified on any electronic copies"

DANIEL F. GUTIERREZ, P.E.
LIC. #049086
29111 KINSINGTON COURT
WESLEY CHAPEL
FL (786)499-4167
Email: danny@dfgenr.com
DG CONSULTING ENGINEERS, LLC
DESIGN - INSPECTIONS