




THE CONTENTS OF THIS DOCUMENT, ITS DESIGN AND DRAWINGS, ARE THE COPYRIGHTED PROPERTY OF DE LA LLAMA - ASSOCIATES, INC. AND MAY NOT BE REPRODUCED OR IN ANY PART WITHOUT THE EXPRESS WRITTEN CONSENT OF DE LA LLAMA - ASSOCIATES, INC. THE GENERAL CONTRACTOR AND ALL TRADES PERFORMING WORK ON THIS PROJECT SHALL BE EXCLUSIVELY RESPONSIBLE FOR VERIFYING ALL DIMENSIONS AND CONDITIONS WITH REPORTING ANY DISCREPANCIES TO THE DE LA LLAMA - ASSOCIATES, INC. BEFORE COMMENCING ANY WORK.

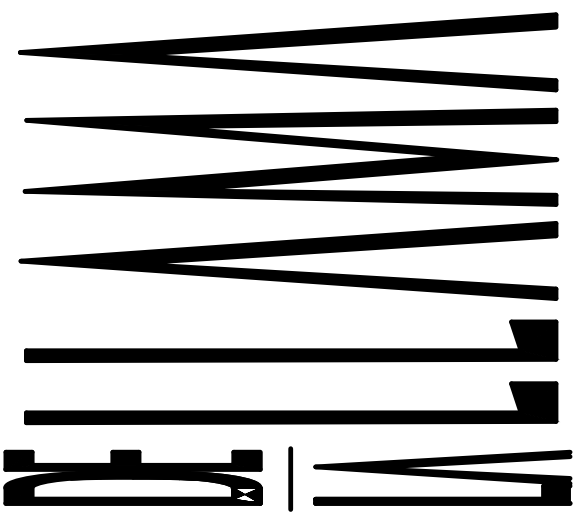


ARCHITECTURE
PLANNING
INTERIOR DESIGN

JORGE A. DE LA LLAMA
STATE OF FLORIDA - #80807707
STATE OF COLORADO - ARC 00445438

522 MADIERA CORAL GABLES - FLORIDA 33134
(305) 461-5590 | (305) 567-1425 FAX
EMAIL: JAD@LLAARCH.COM

CONSULTANTS

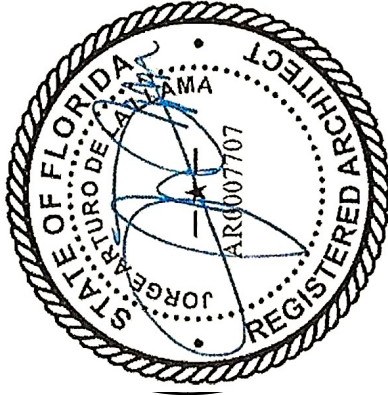

JORGE A. DE LA LLAMA
STATE OF FLORIDA - #80807707
STATE OF COLORADO - ARC 00445438

PROJECT NAME

P8
PINECREST
EIGHT

13100 SW 80TH AVE
PINECREST, FLORIDA 33156

FILE NAME

JUNCO
RESIDENCE

DATE
DEC 16, 2024
REVISION
BY
3-20-25 REVISION

DRAWING NAME


DESIGN BY:
ZECKY DA COSTA


DRAWN BY:
HUMBERTO LANTIGUA

SHEET NO.

ELECT. GROUND
FLOOR PLAN - POWER

E-1.1

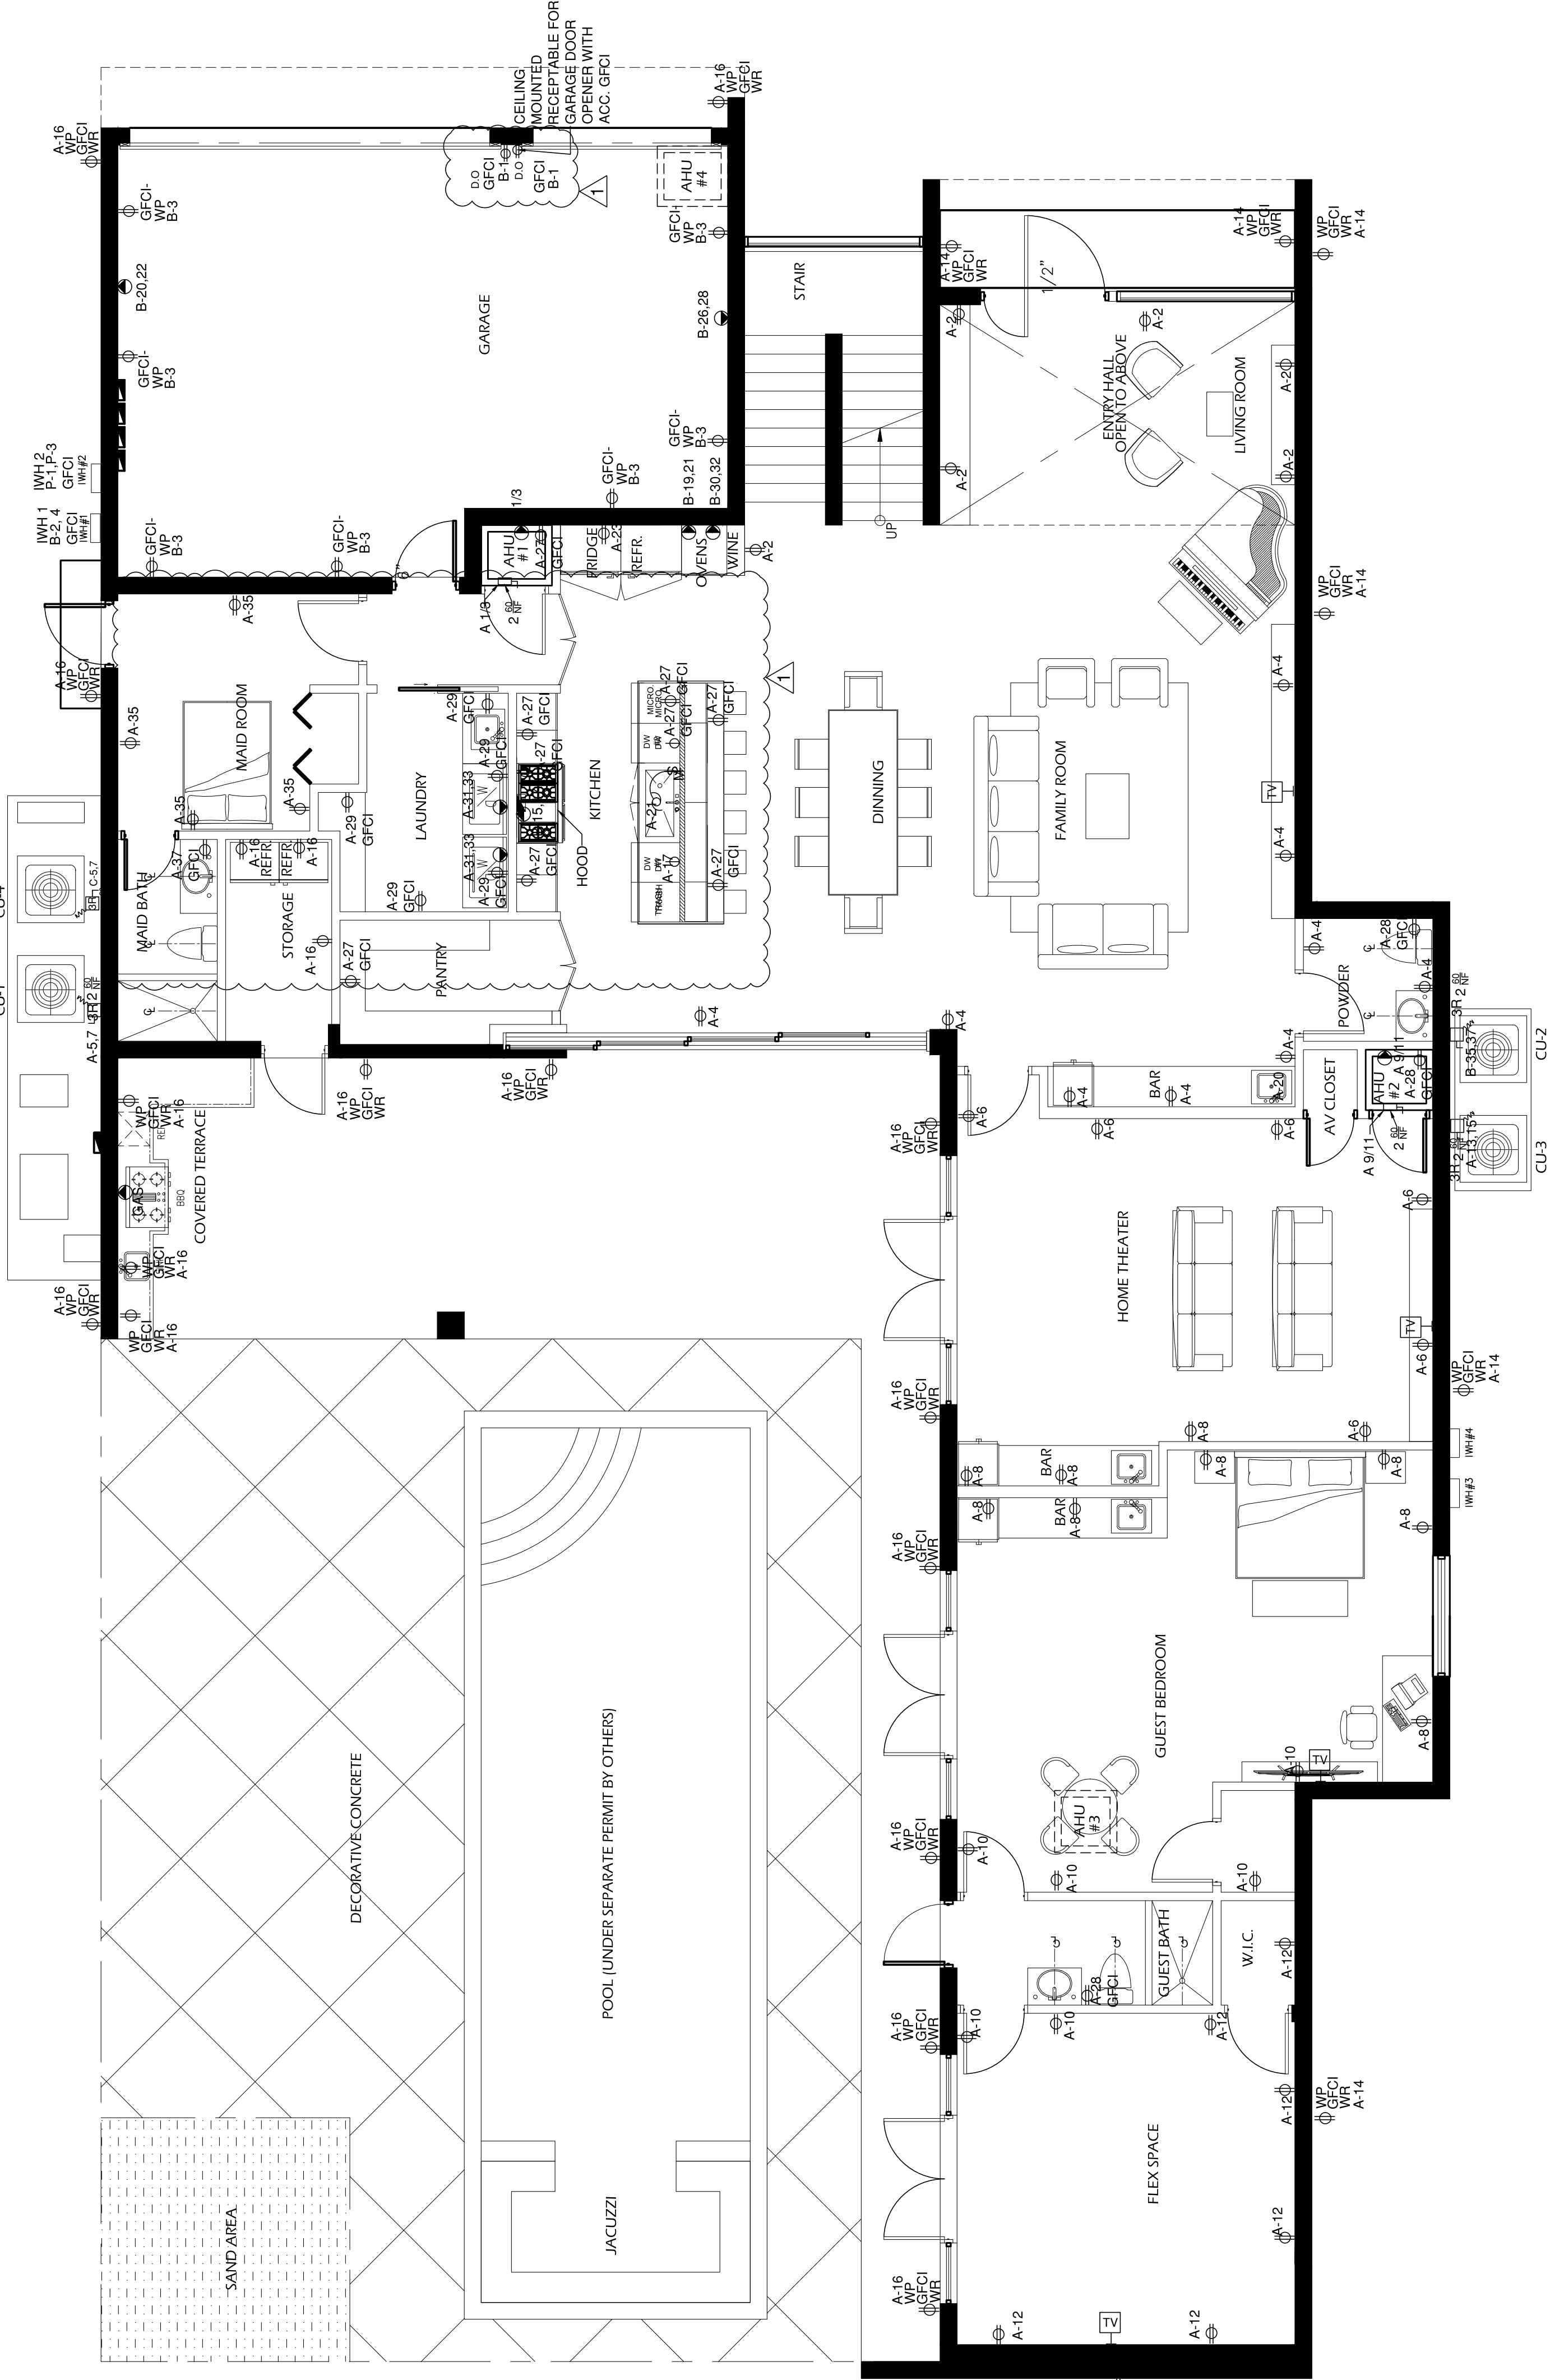

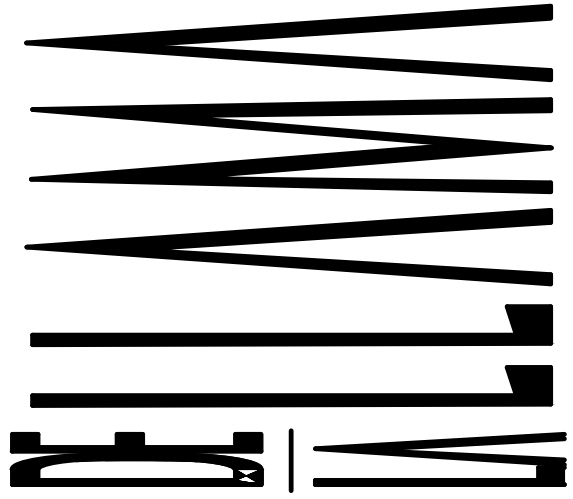


ARCHITECTURE
PLANNING
INTERIOR DESIGN

JORGE A. DE LA LLAMA
STATE OF FLORIDA - A00097707
STATE OF COLORADO - ARC00494538

522 MADIERA CORAL GABLES, FLORIDA 33134
(305) 140-1590 | (305) 567-1425 FAX
EMAIL: JAC@ARCHPACOL.COM

CONSULTANTS

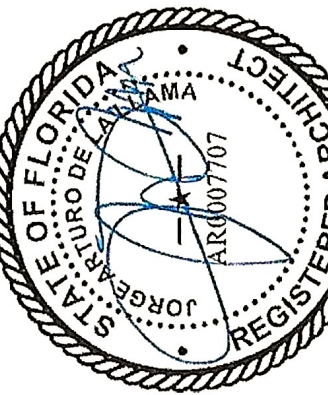

JORGE A. DE LA LLAMA
STATE OF FLORIDA - A00097707
STATE OF COLORADO - ARC00494538

PROJECT NAME

P8
PINECREST
EIGHT

13100 SW 80TH AVE
PINECREST, FLORIDA 33156

FILE NAME

JUNCO
RESIDENCE

DATE

DEC 16, 2024

REVISION
DATE
BY

1 3-20-25 REVISION

DRAWING NAME

DESIGN BY:

ZECKY DA COSTA


DRAWN BY:


HUMBERTO LANTIGUA

SHEET NO.

ELECT. SECOND
FLOOR PLAN - LIGHTING

E-2

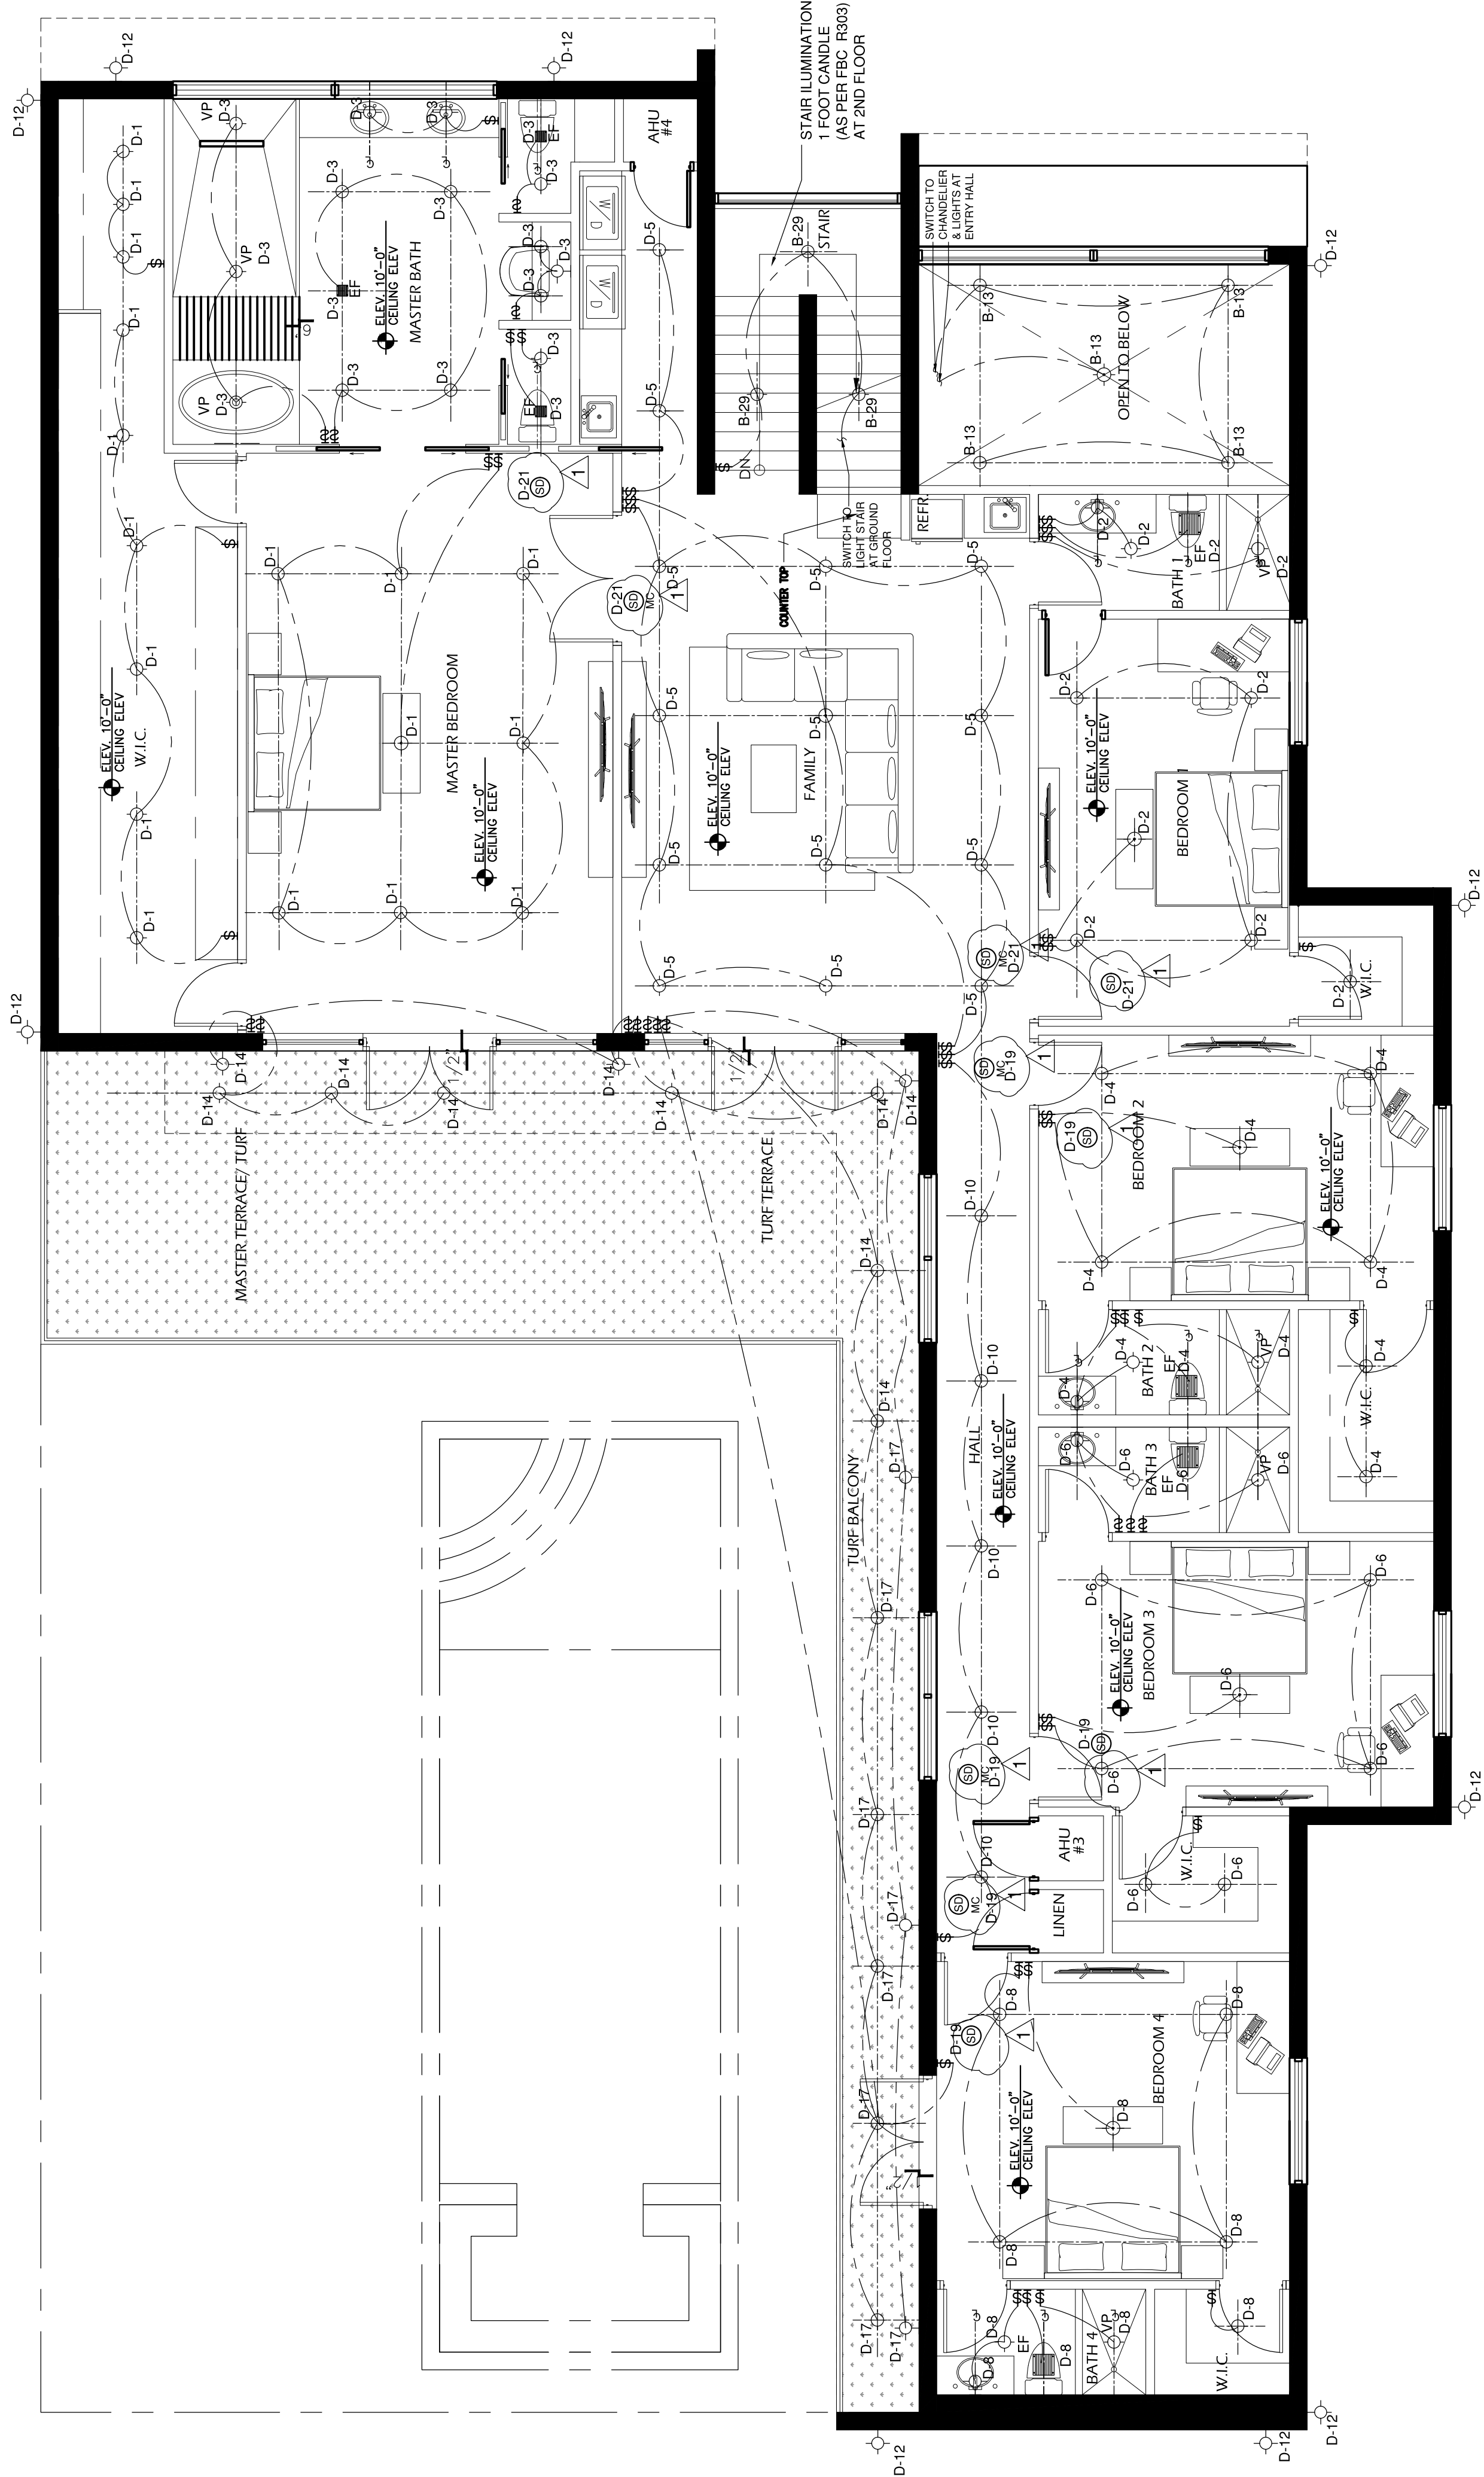

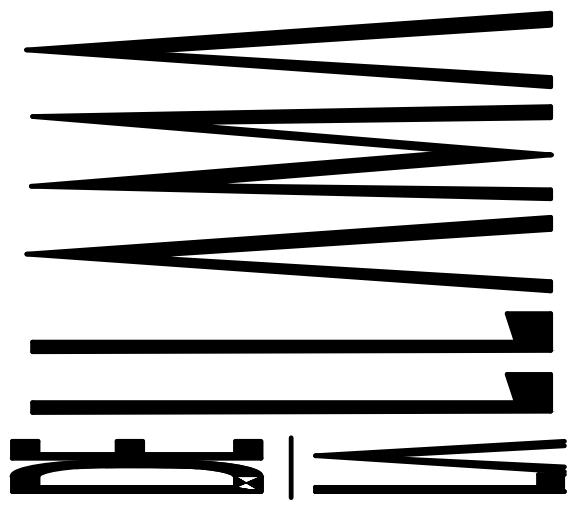

ARCHITECTURE
PLANNING
INTERIOR DESIGN


JORGE A. DE LA LLAMA

STATE OF FLORIDA - AR0007707

STATE OF COLORADO - ARC00404538

522 MADIERA CORAL GABLES, FLORIDA 33134
(305) 441-5590 | (305) 567-1425 FAX
EMAIL: JACL@ARCHPCL.COM

CONSULTANTS

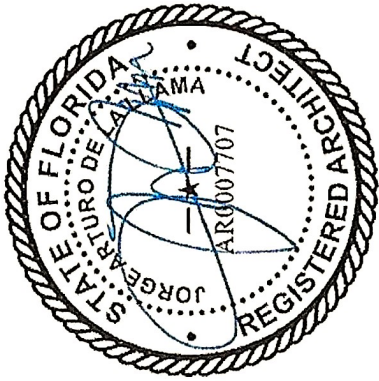

JORGE A. DE LA LLAMA

STATE OF FLORIDA - AR0007707

STATE OF COLORADO - ARC00404538

PROJECT NAME

P8
PINECREST
EIGHT

13100 SW 80TH AVE
PINECREST, FLORIDA 33156

FILE NAME

JUNCO
RESIDENCE

DATE

DEC 16, 2024

REVISION

DATE

BY

3-20-25 REVISION

DRAWING NAME

DESIGN BY:

ZECKY DA COSTA


DRAWN BY:

HUMBERTO LANTIGUA

SHEET NO.

ELECT. SECOND
FLOOR PLAN - POWER

E-2.1

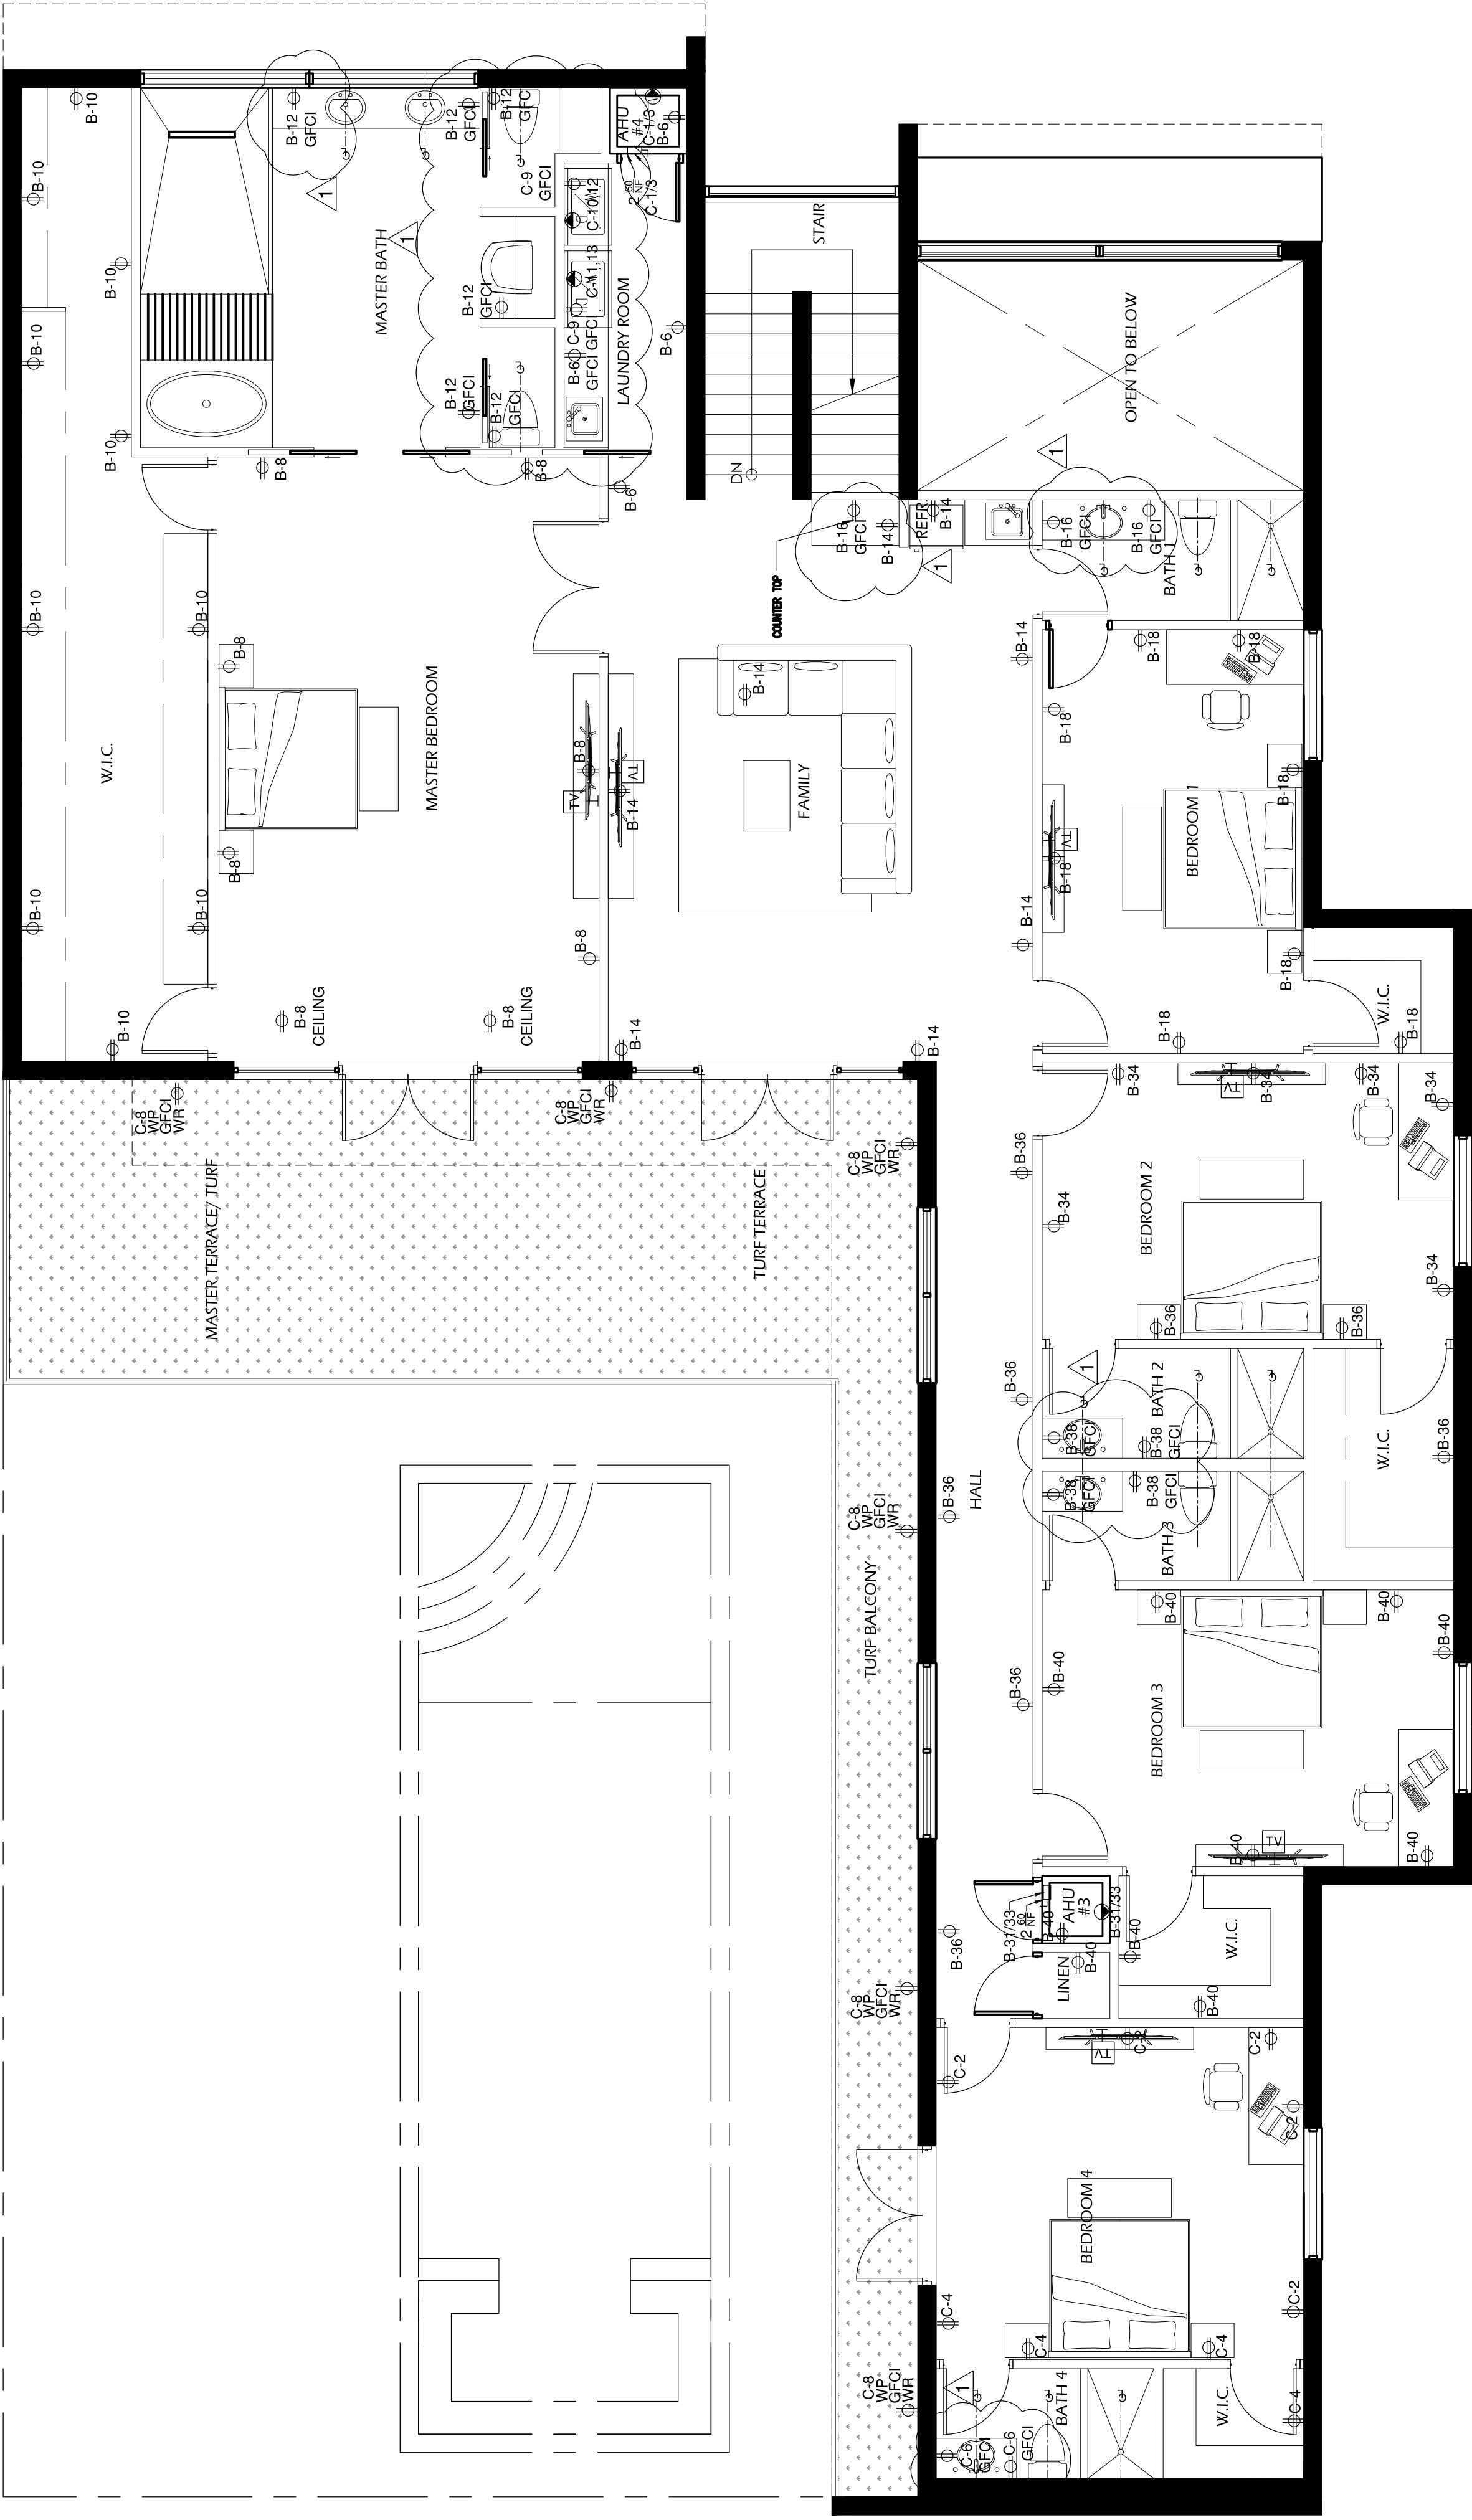

ELECTRICAL SECOND FLOOR PLAN - POWER

SCALE: 3/16" = 1'-0"

