



1/4" = 1'-0"

SCAN QR CODE
FOR ALL RFIs

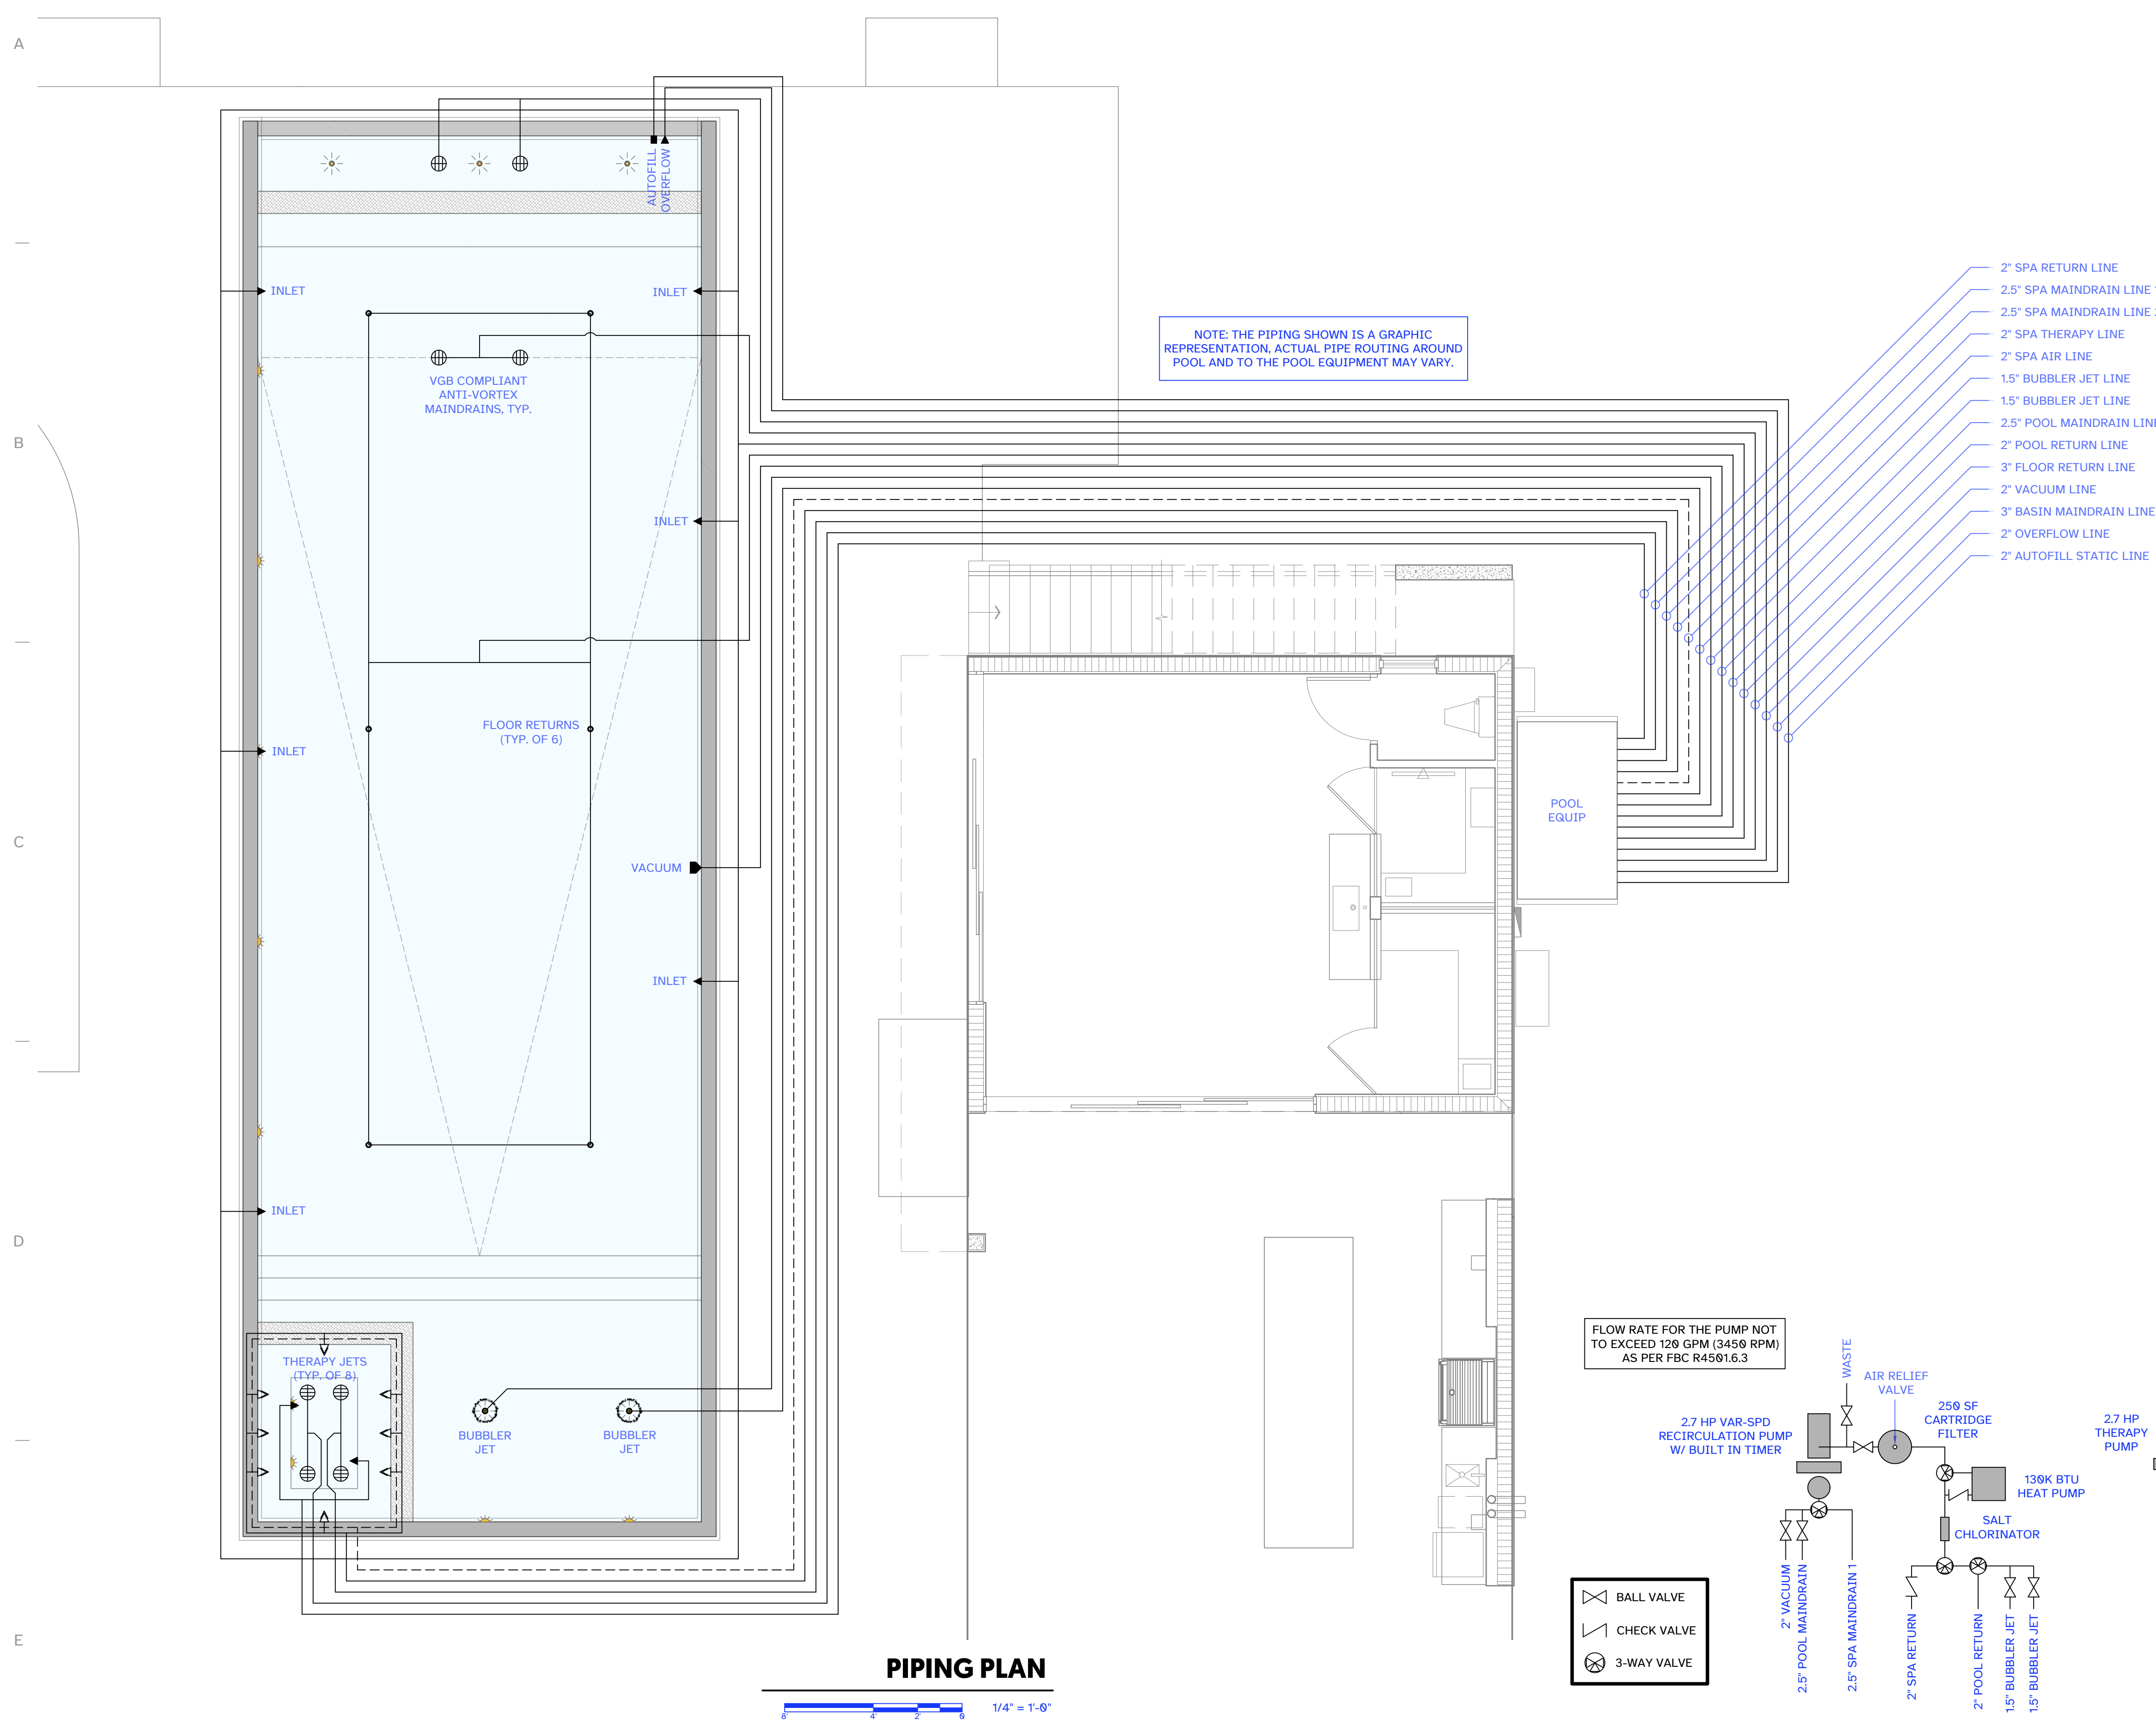

OVERFLOW SPECIFICATIONS

VANISHING EDGE REQUIRED OVERFLOW RATE	28'-0" 90.0 GPM
DESIGN FLOW RATE	120 GPM WITH (1) 2.7HP VAR-SPD PUMP @ 3,450 RPM & (1) 250 SF CARTRIDGE FILTERS
4.5 GPM PER FOOT REQUIRED FOR 1/4" HEAD OVER EDGE	

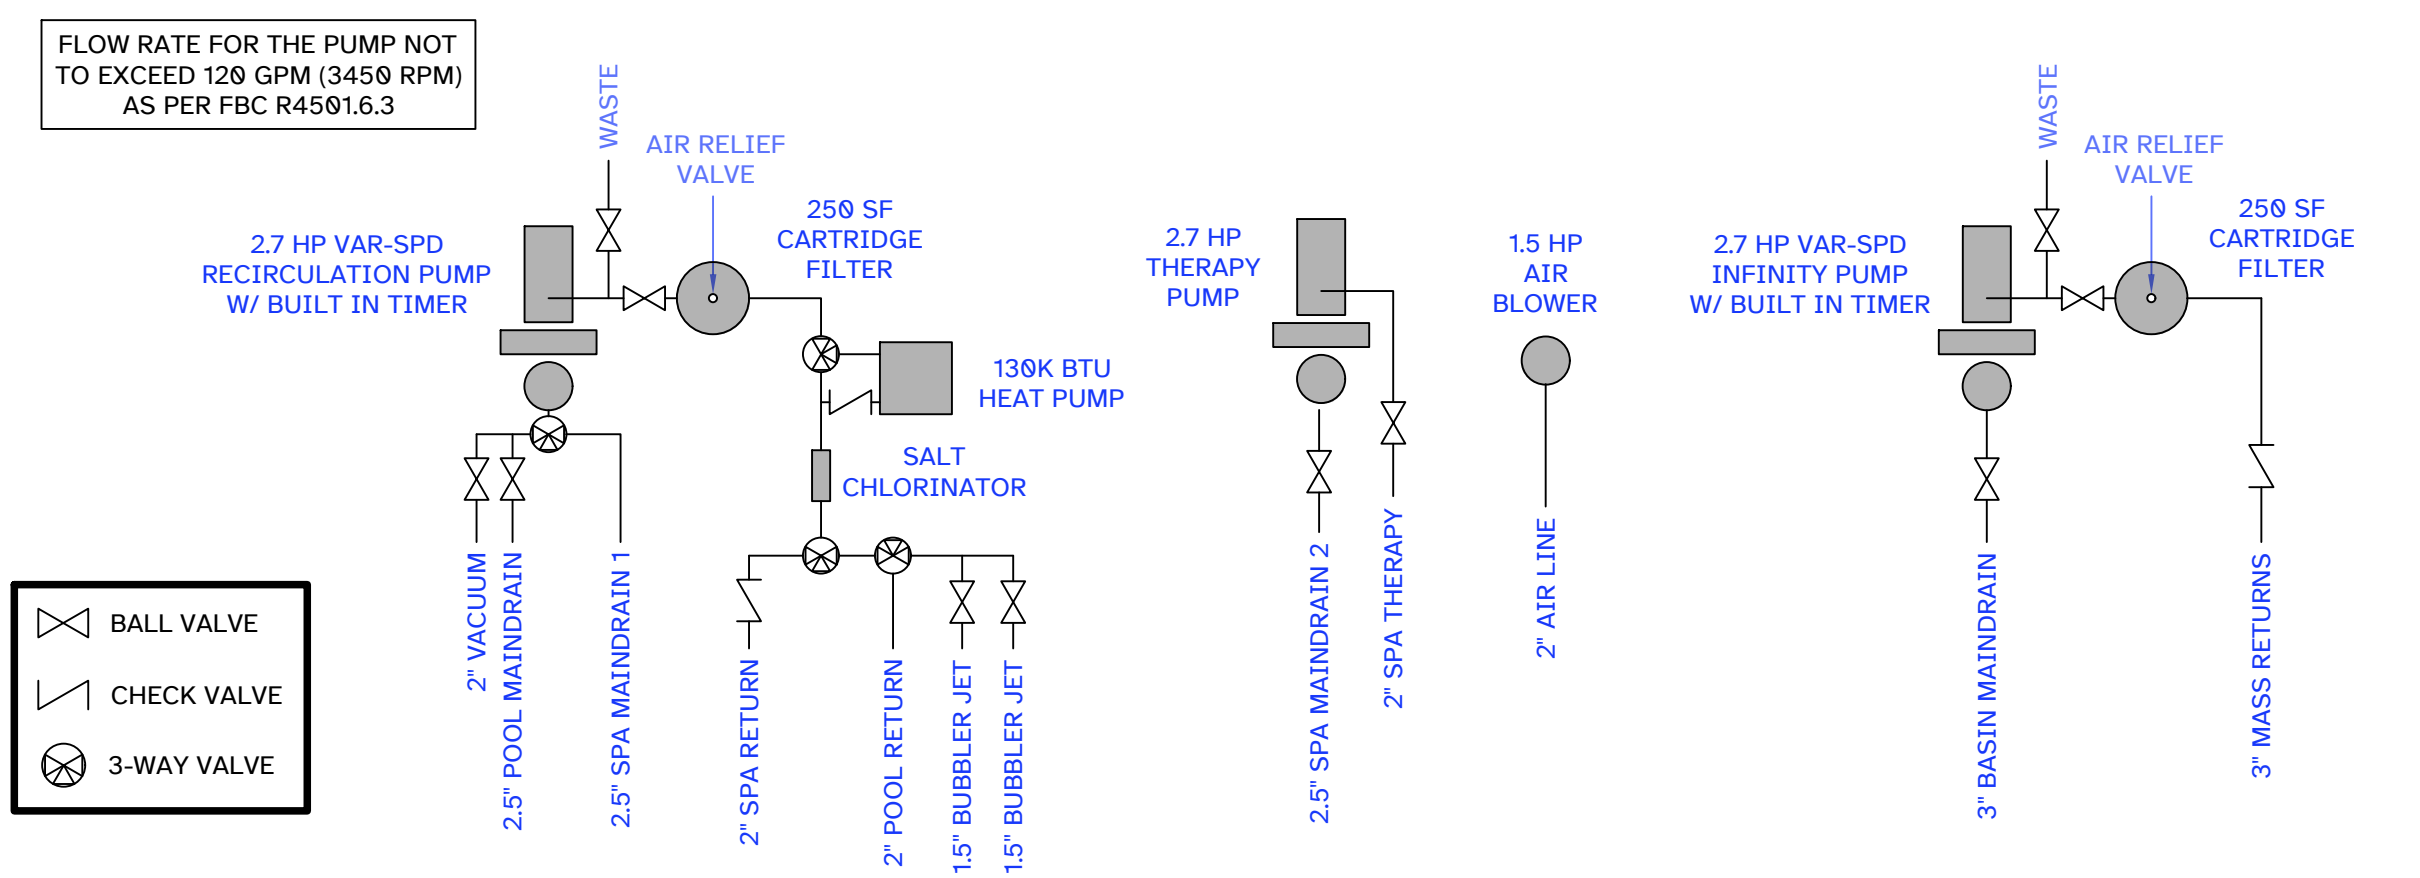

POOLPRINTS@GMAIL.COM
(9 5 4) 2 0 3 - 0 9 9 2
POOLPRINTSTUDIO.COM

CONSULTANT
ENGINEER OF RECORD
ZAKARY JAMES LATA, P.E.
P.E. #79443
PLAN Z DESIGNS LLC
C.A. NO.: 33210
PLANZDESIGNS@OUTLOOK.COM

HH6100 RESIDENCE

6100 WEST SUBURBAN DRIVE
PINECREST, FL 33156

REVISIONS
BLDG DEPT COMMENTS 01.09.26

NOTES
1.

PROJECT NORTH

SCALE 1/4" = 1'-0"

PLUMBING PLAN

SP3.0

SHEET NO. © 2025