


1/4" = 1'-0"
CUT ON DASH LINE FOR SCALE RULER



SCAN QR CODE
FOR ALL RFIS

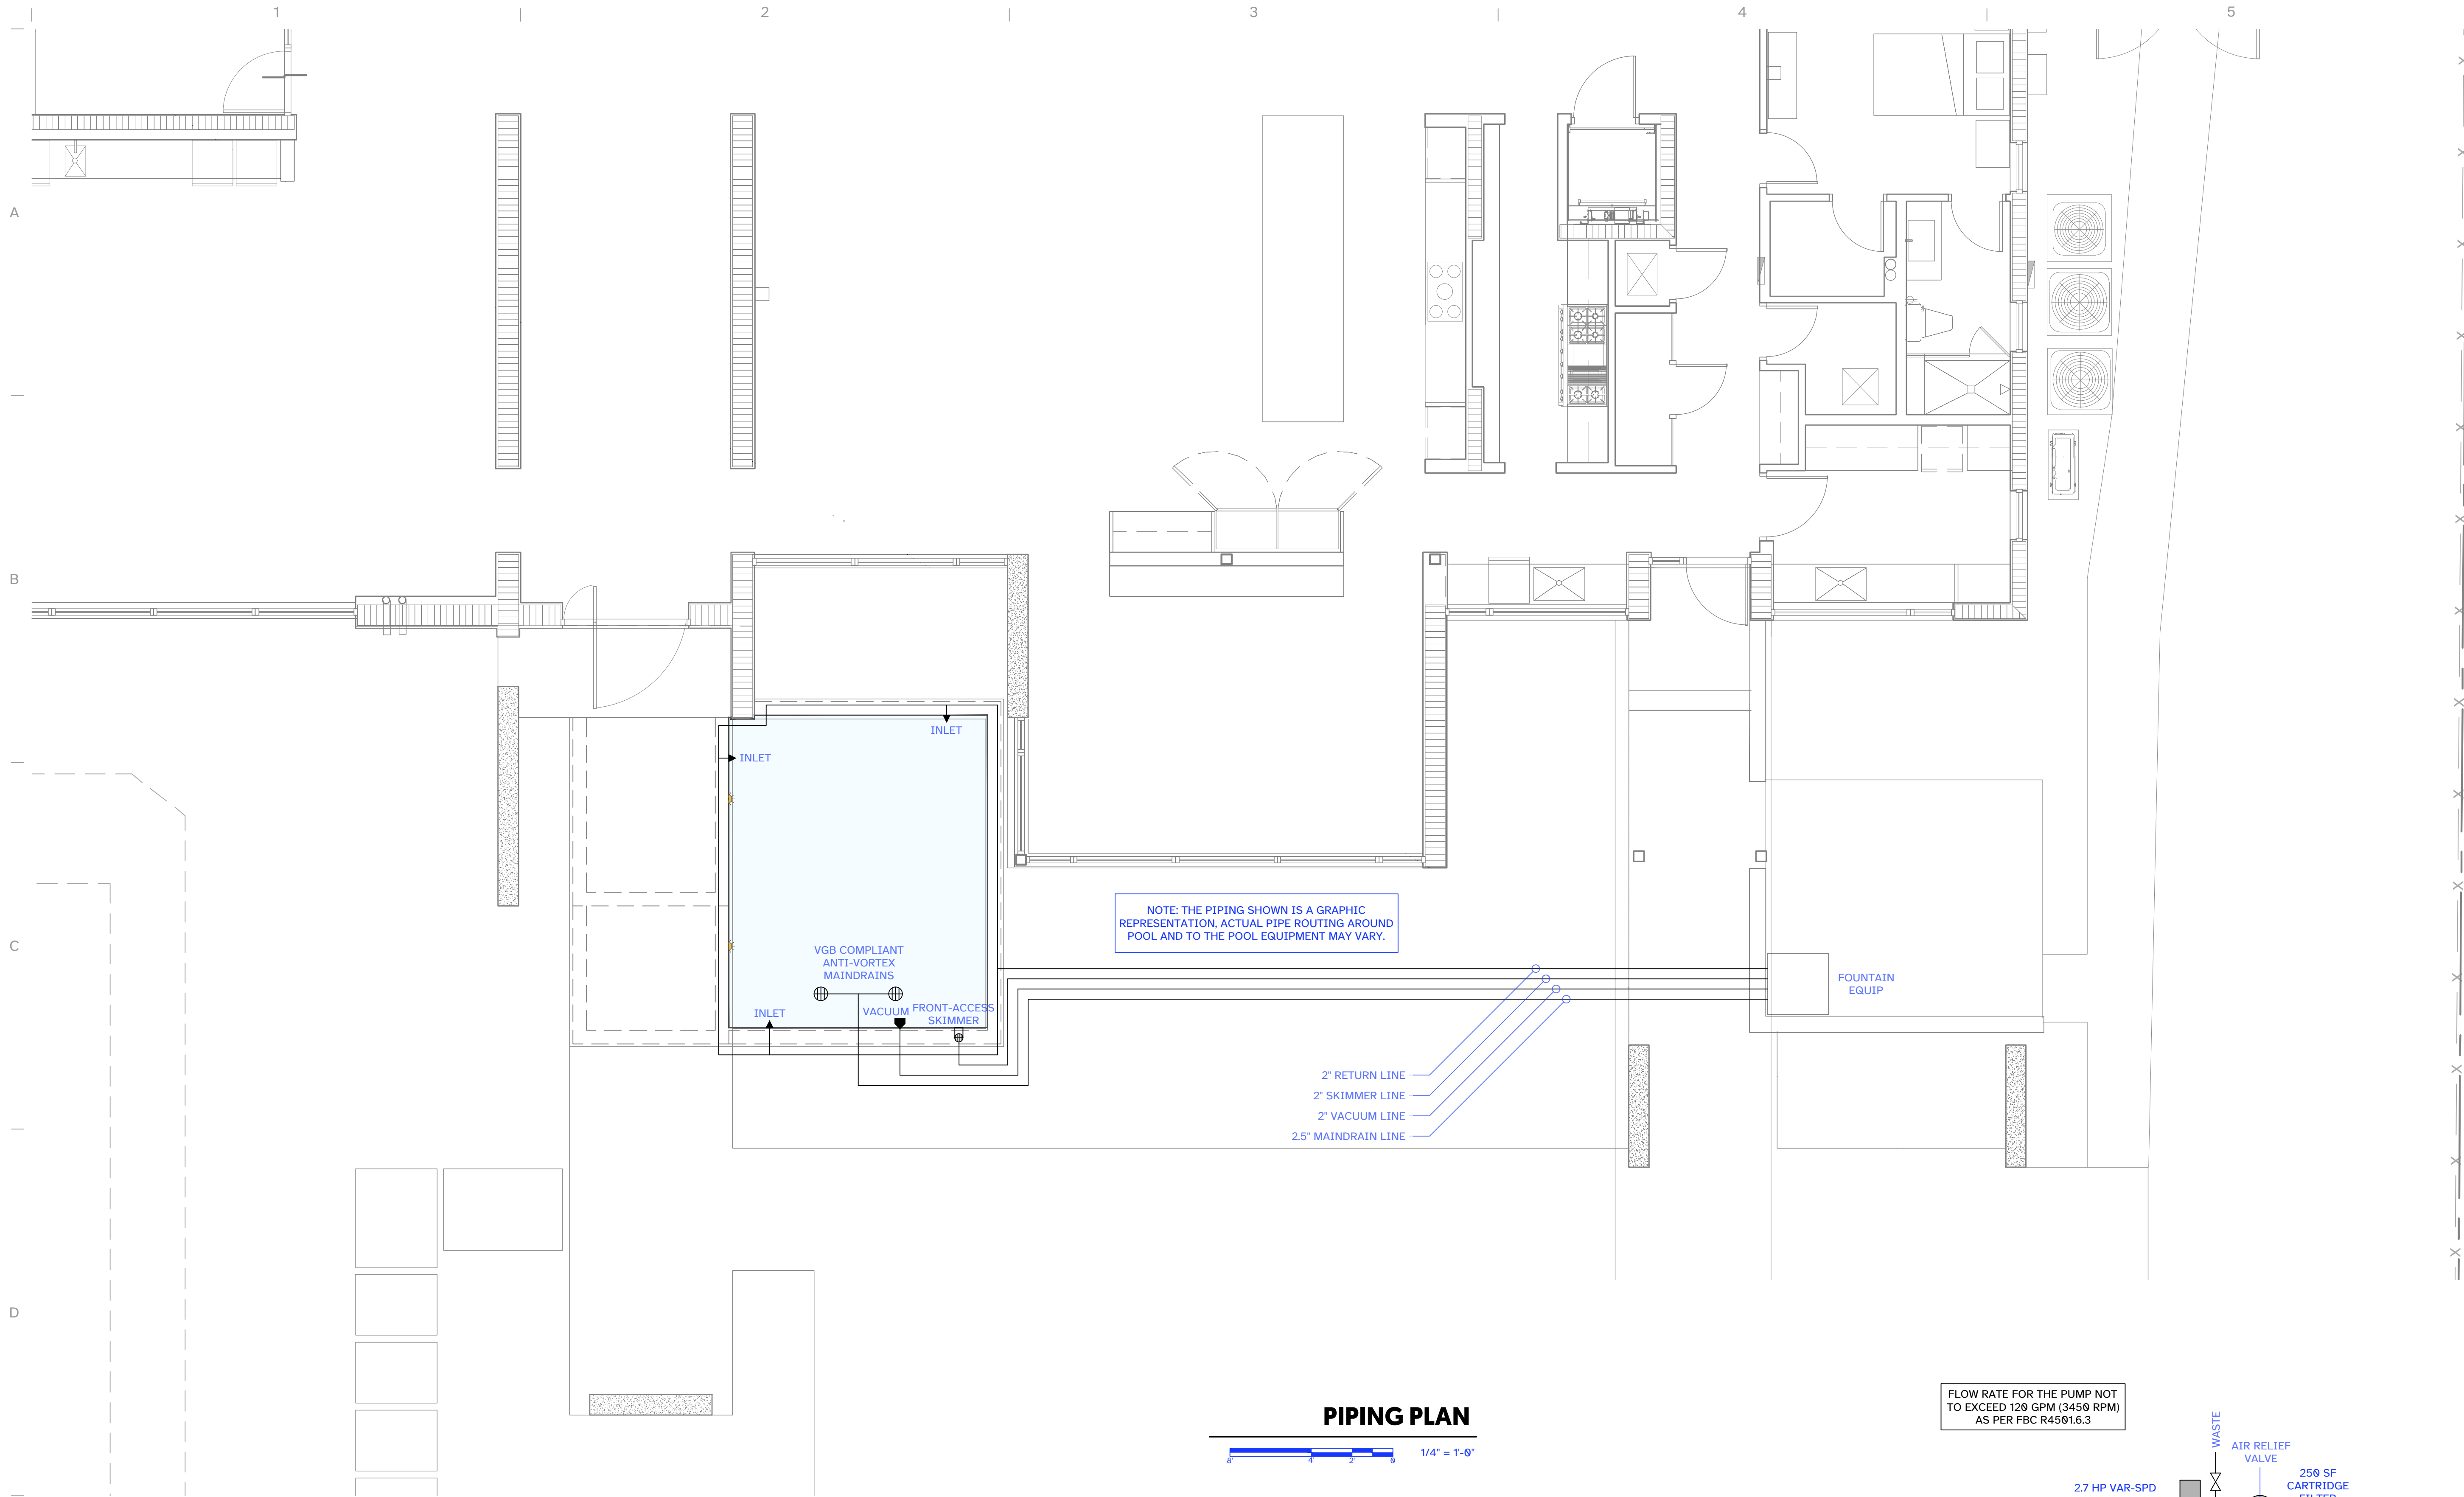

NOTE: THE PIPING SHOWN IS A GRAPHIC REPRESENTATION, ACTUAL PIPE ROUTING AROUND POOL AND TO THE POOL EQUIPMENT MAY VARY.

2" RETURN LINE
2" SKIMMER LINE
2" VACUUM LINE
2.5" MAINDRAIN LINE

FOUNTAIN EQUIP

PIPING PLAN


1/4" = 1'-0"

FLOW RATE FOR THE PUMP NOT TO EXCEED 120 GPM (3450 RPM) AS PER FBC R4501.6.3

- BALL VALVE
- CHECK VALVE
- 3-WAY VALVE

RECIRCULATION EQUIPMENT

NOT TO SCALE

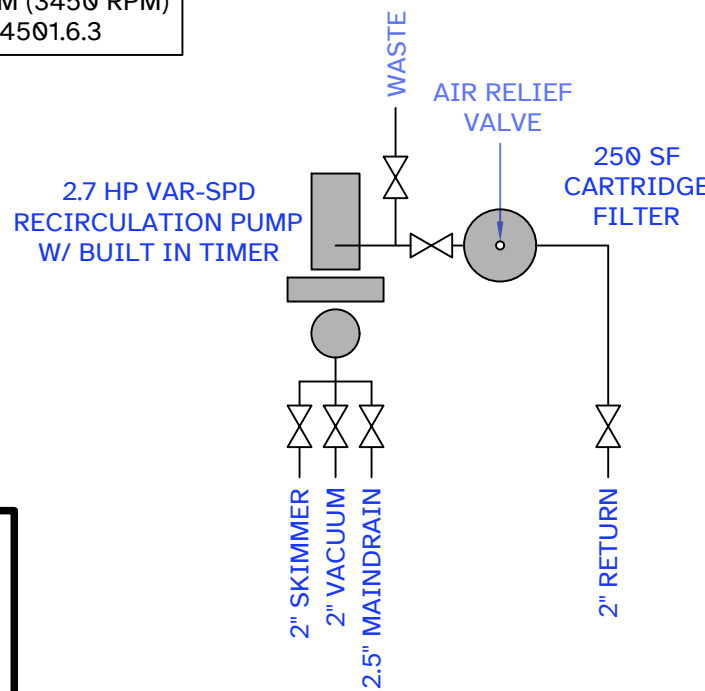

DIMENSION VERIFICATION: THE CONTRACTOR IS REQUIRED TO CONSULT THE PROJECT ENGINEER FOR ANY NECESSARY DIMENSIONS INSTEAD OF RELYING SCALING DRAWINGS. SCALING MAY RESULT IN INACCURACIES AND IS NOT PERMITTED.

FIELD CONDITION DISCREPANCIES: SHOULD FIELD CONDITIONS DEVIATE FROM THE DIMENSIONS SPECIFIED ON THE DRAWINGS, THE CONTRACTOR MUST PROMPTLY INFORM THE PROJECT ENGINEER FOR RESOLUTION AND CLARIFICATION.

FAILURE TO COMPLY WITH THESE REQUIREMENTS MAY RESULT IN CONSTRUCTION DELAYS AND ASSOCIATED COSTS.

ALL CODES TO COMPLY WITH
F.B.C. 2023, 8TH EDITION

 
PLOT DATE -

13 January 2026



POOLPRINTS@GMAIL.COM
(954) 203-0992
POOLPRINTSTUDIO.COM

CONSULTANT
ENGINEER OF RECORD
ZAKARY JAMES LATA, P.E.
P.E. #79443
PLAN Z DESIGNS LLC
C.A. NO.: 33210
PLANZDESIGNS@OUTLOOK.COM



RESIDENCE

HH6100

6100 WEST SUBURBAN DRIVE
PINECREST, FL 33156

REVISIONS

BLDG DEPT
COMMENTS
01.09.26

NOTES

1.

PROJECT NORTH



SCALE 1/4" = 1'-0"

FOUNTAIN PLUMBING PLAN SP3.1

SHEET NO.

© 2025